


TRAFFIC DATA			
A.A.D.T.		N/A	V.P.D.
A.A.D.T.		N/A	V.P.D.
D.H.V		N/A	V.P.H.
DIRECTIONAL DISTRIBUTION		N/A	%
TRUCKS		N/A	% A.A.D.T.
DESIGN DATA			
DESIGN SPEED		20	M.P.H.
PROJECT DESIGN CRITERIA	AASHTO Guide for the Development of Bicycle Facility		
FUNCTIONAL CLASSIFICATION	Shared Use Path		
RURAL/URBAN		Urban	
TERRAIN		Level	
ACCESS CONTROL		None	

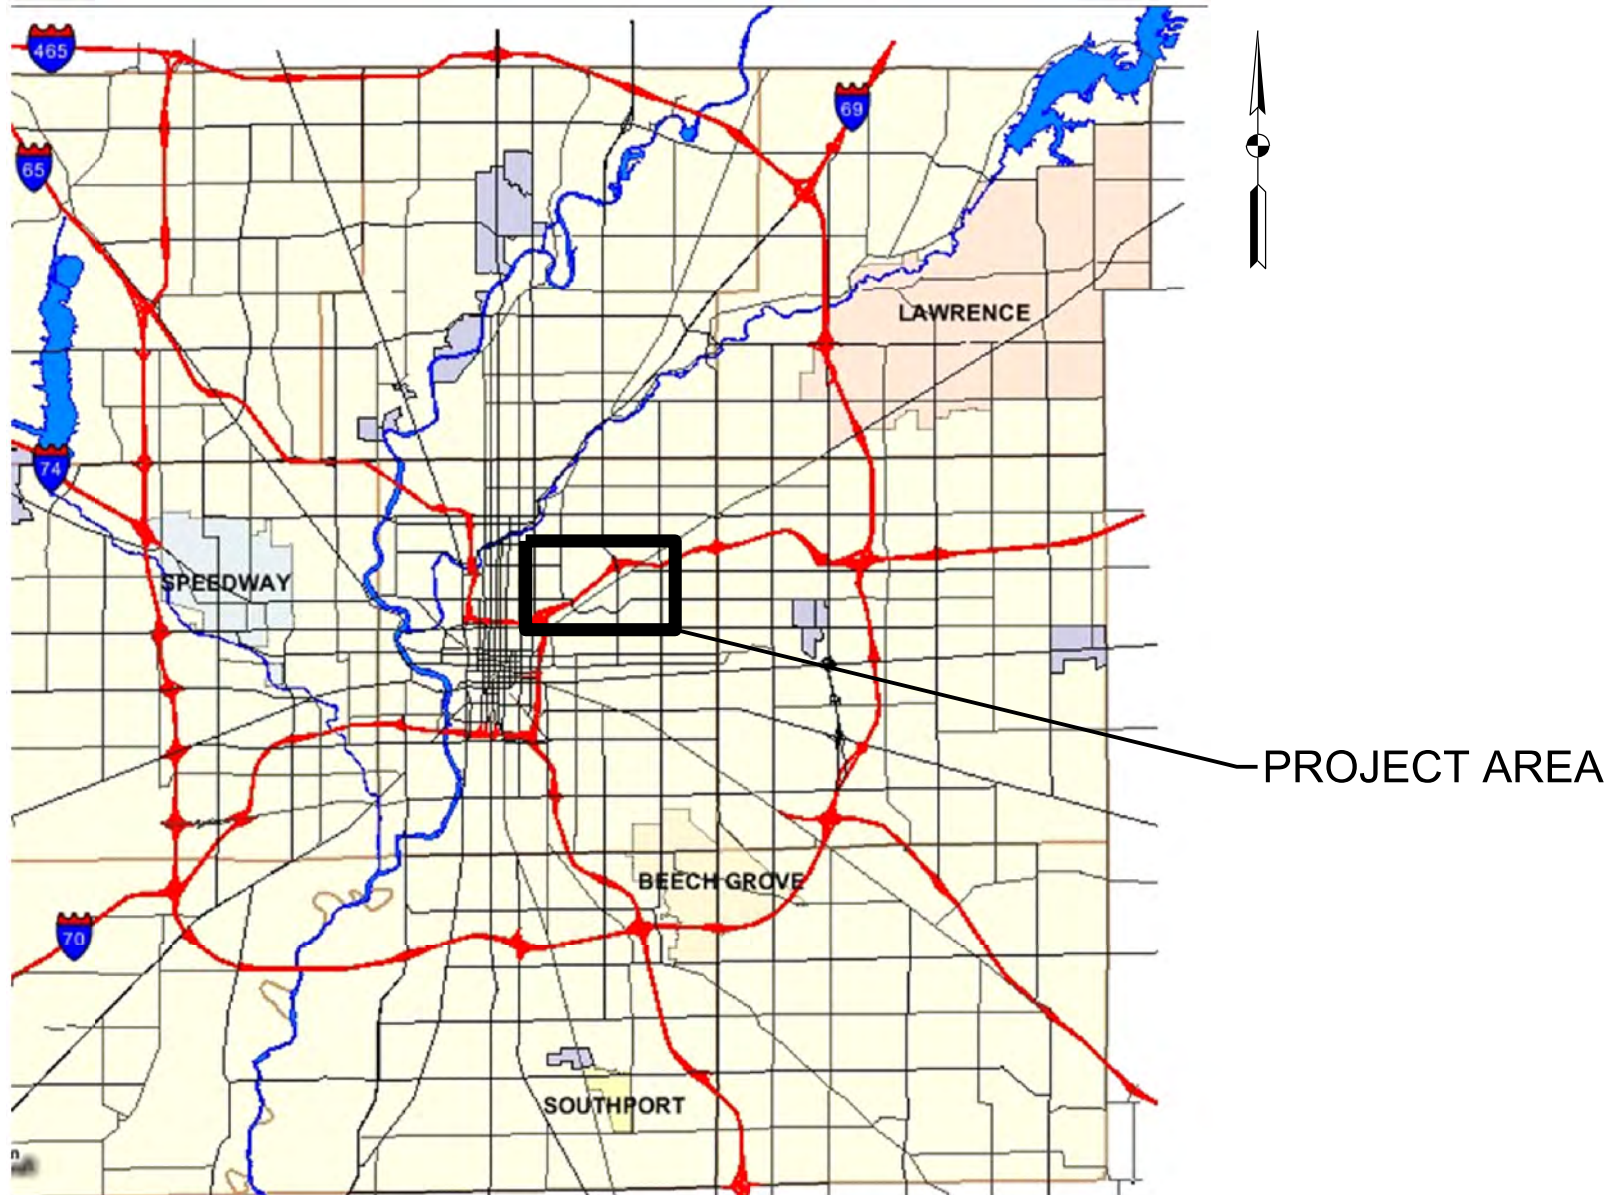

LOCATION MAP

CITY OF INDIANAPOLIS DEPARTMENT OF PUBLIC WORKS POGUES RUN TRAIL PHASE 1

DPW PROJECT NO. PA-25-001

Shared use path along 10th Street
and Brookside Avenue, from Massachusetts Avenue
to Commerce Avenue
Gross Length = 0.55 Miles
Net Length = 0.55 Miles


MAYOR, GREGORY A. BALLARD
DIRECTOR, ANDY LUTZ

END PROJECT - PHASE 1
Sta. 44+12.52 Line "P"

END CONSTRUCTION
P.O.T. 15+48.57 "P10th"

BEGIN PROJECT - PHASE 1
Sta. 10+00.00 Line "P10th"

BEGIN CONSTRUCTION
P.O.T. 20+13.27 "P"

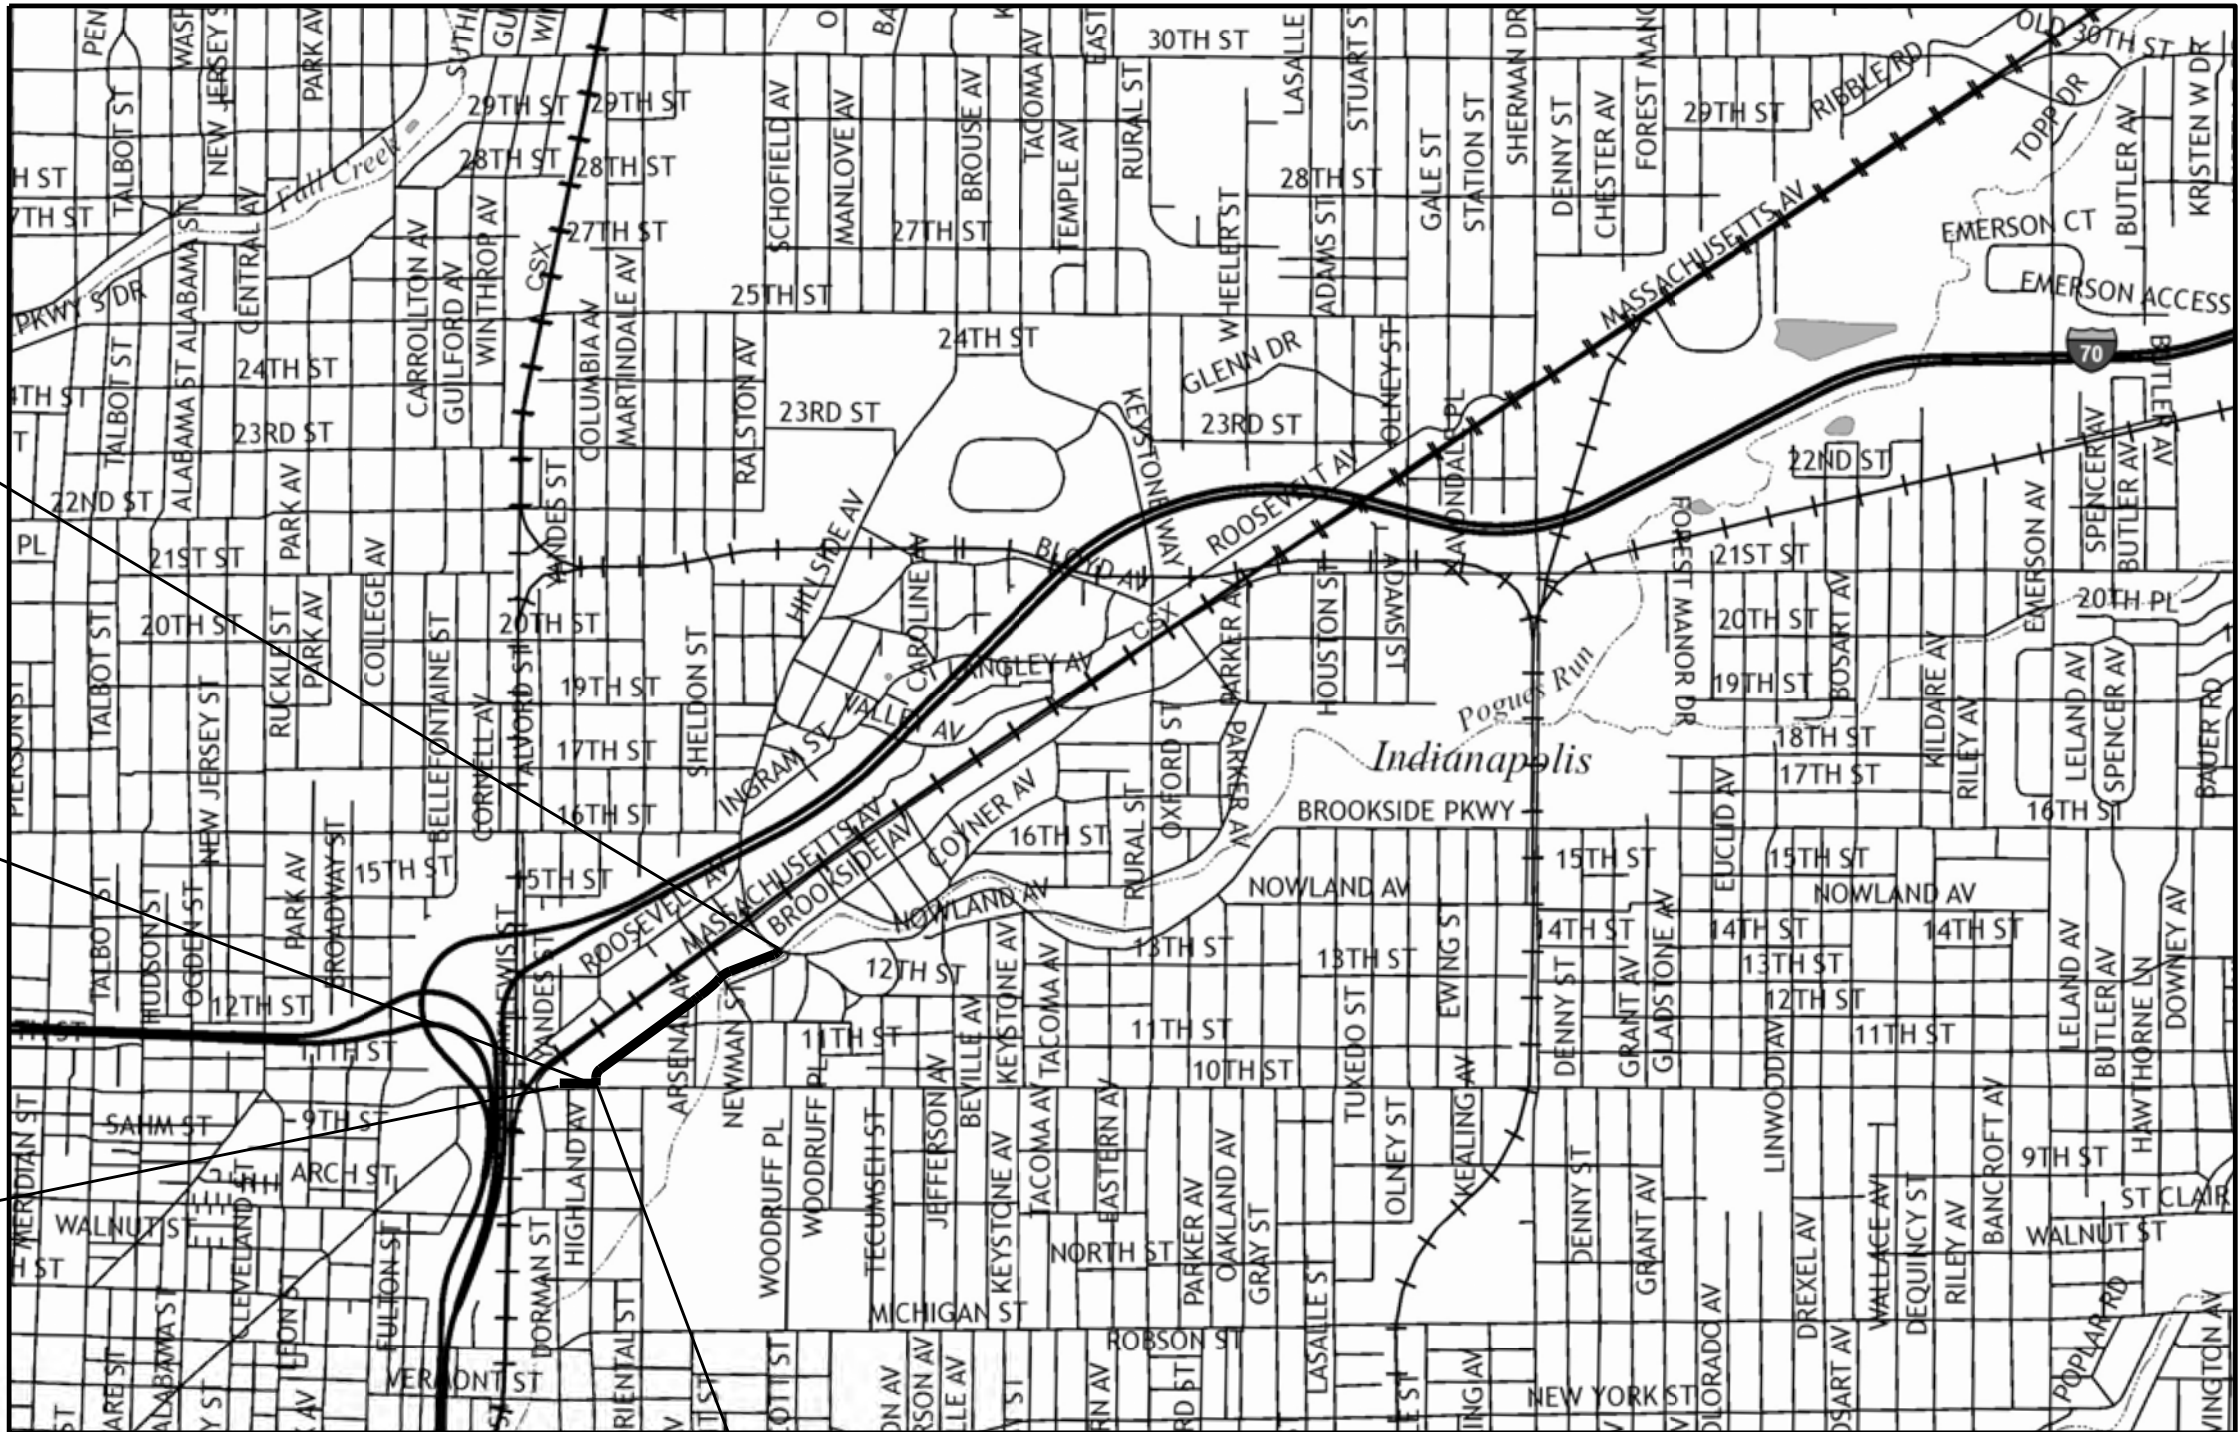

DEPARTMENT OF PUBLIC WORKS
1200 S. MADISON AVENUE
SUITE 200
INDIANAPOLIS, IN 46225

INDIANA DEPARTMENT OF TRANSPORTATION
STANDARD SPECIFICATIONS DATED 2014
TO BE USED WITH THESE PLANS

PATH AND FILENAME: V:\Projects\IIN62\Planning and Urban Design\Projects\27813 Pogues Run Greenway\30 SheetDrawings\20 Singles\Sht Title.dgn
MODEL NAME: RD _Title Sheet 01
DATE PLOTTED: 4/16/2015
TIME PLOTTED: 5:20:48 PM



PLANS PREPARED BY: CHA Consulting, Inc. 317.786.0461 PHONE NUMBER
CERTIFIED BY: [Signature] 4-16-2015 DATE
APPROVED FOR LETTING: DATE

BRIDGE FILE	
DESIGNATION	
SURVEY BOOK	SHEETS
1	of 47
CONTRACT	PROJECT
	PA-25-001

UTILITIES

TELEPHONE/COMMUNICATIONS

AT&T Distribution

5858 N. College Ave.
Indianapolis, IN 46220

WATER

Citizens Energy Group

2150 Dr. Martin Luther King Jr. St
Indianapolis, IN 46202

SANITARY SEWER

Citizens Energy Group

Robert Masbaum

Indianapolis, IN 46202
317-429-3961

GAS

Citizens Energy Group

Richard Miller
2150 Dr. Martin Luther King Jr. St
Indianapolis, IN 46202
317-927-4684

ELECTRIC

Indianapolis Power & Light Co.

1230 West Morris St.
Indianapolis, IN 46221

STREETLIGHTS

Indianapolis Power & Light Co.

Dennis Fox
1230 West Morris St.
Indianapolis, IN 46221
317-261-6196


INDEX

SHEET NO.	DRAWINGS INDEX
1	TITLE
2	INDEX AND GENERAL NOTES
3 - 7	LOCATION CONTROL ROUTE SURVEY
8 - 10	TYPICAL CROSS SECTIONS
11 - 15	MAINTENANCE OF TRAFFIC
16 - 20	PLAN AND PROFILE SHEETS
21 - 26	CURB RAMP / SPOT ELEVATIONS DETAILS
27	SITE DETAILS
28	MISCELLANEOUS DETAILS
29 - 31	PAVEMENT MARKING & SIGN DETAILS
32	SIGN DETAILS
33 - 34	TRAFFIC SIGNAL DETAILS
35 - 37	TEMPORARY EROSION CONTROL DETAILS
40	STRUCTURE DATA TABLE
XS39 - XS47	CROSS SECTIONS

REVISIONS

SHEET NO.	DATE	REVISED
\$sht1\$	\$date1\$	\$rev1\$
\$sht2\$	\$date2\$	\$rev2\$
\$sht3\$	\$date3\$	\$rev3\$
\$sht4\$	\$date4\$	\$rev4\$
\$sht5\$	\$date5\$	\$rev5\$
\$sht6\$	\$date6\$	\$rev6\$
\$sht7\$	\$date7\$	\$rev7\$
\$sht8\$	\$date8\$	\$rev8\$
\$sht9\$	\$date9\$	\$rev9\$
\$sht10\$	\$date10\$	\$rev10\$
\$sht11\$	\$date11\$	\$rev11\$
\$sht12\$	\$date12\$	\$rev12\$
\$sht13\$	\$date13\$	\$rev13\$
\$sht14\$	\$date14\$	\$rev14\$
\$sht15\$	\$date15\$	\$rev15\$
\$sht16\$	\$date16\$	\$rev16\$


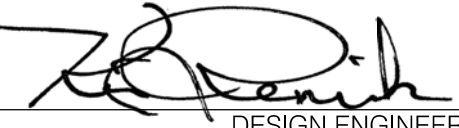


RECOMMENDED FOR APPROVAL		4-16-2015 DATE
DESIGNED: VA	DRAWN: JSS	
CHECKED: ACD	CHECKED: VA	

CITY OF INDIANAPOLIS
DEPARTMENT OF PUBLIC WORKS

INDEX SHEET

HORIZONTAL SCALE	BRIDGE FILE
VERTICAL SCALE	DESIGNATION
SURVEY BOOK	SHEETS
CONTRACT	2 of 47
	PROJECT
	PA-25-001

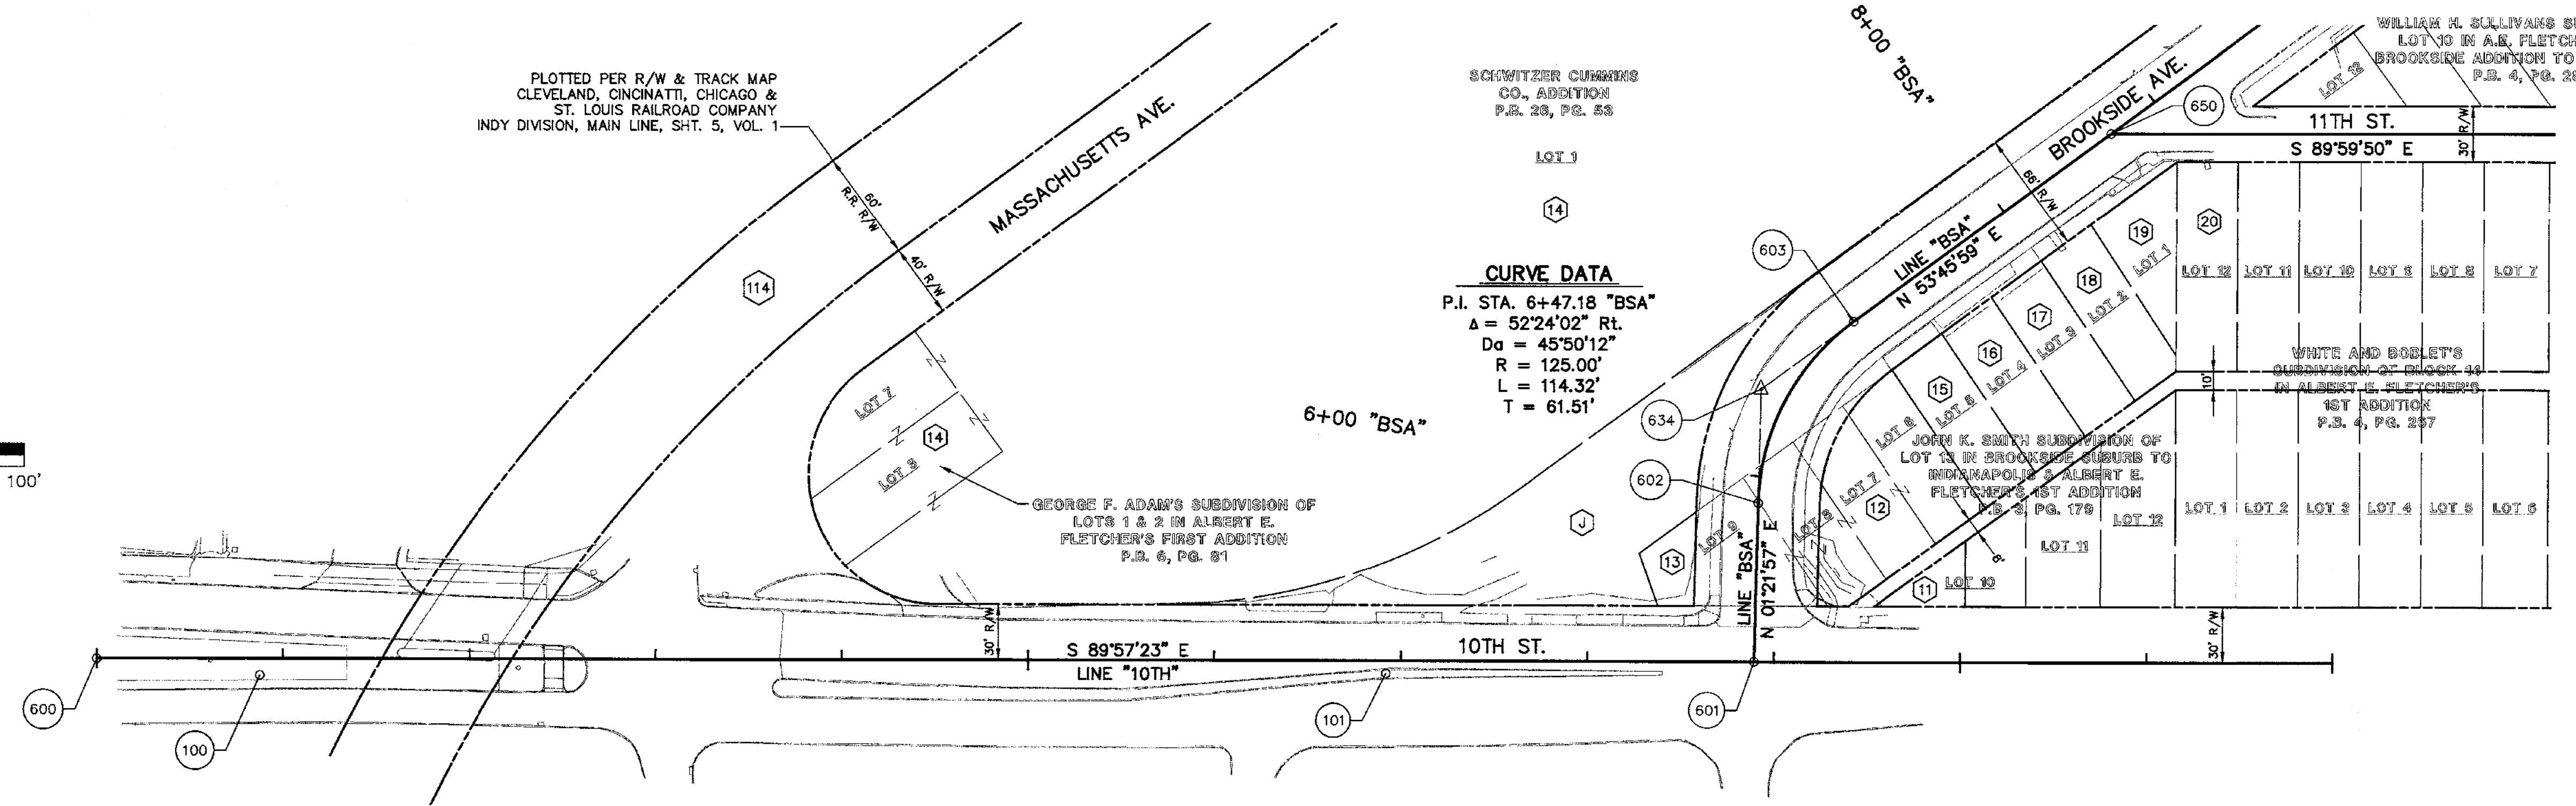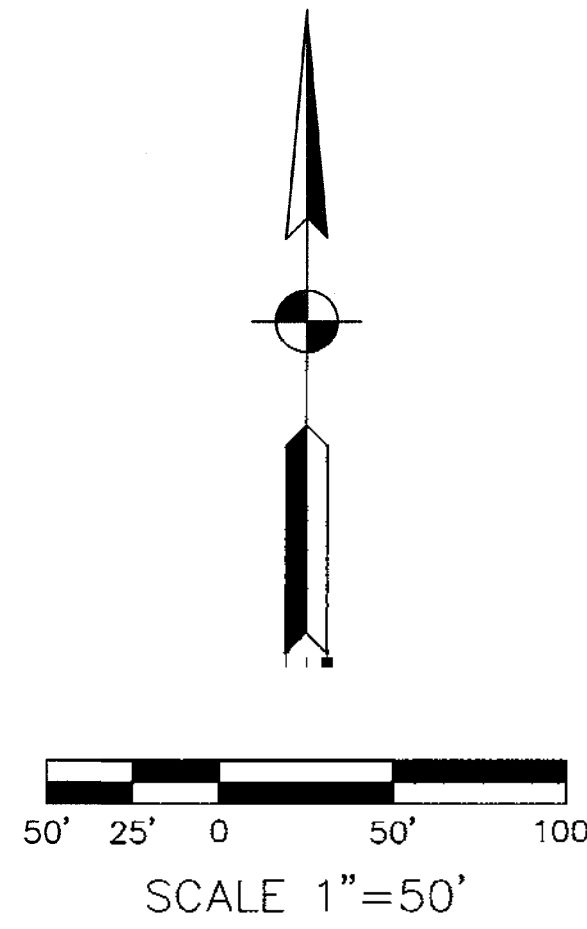

- 11 GREGORY S. DUGAN & HUI LIN CHUA
INSTR. No. A201300093773
- 12 CITY OF INDIANAPOLIS DOT
INSTR. No. 73-26384
- 13 THE NATIONAL BANK OF INDIANAPOLIS
INSTR. No. A201400042374
- 14 THE NATIONAL BANK OF INDIANAPOLIS
INSTR. No. A201000098588
- 15 GEORGE A. BERRY & RUTH A. BERRY
INSTR. No. 840013953
- 16 SHERMAN STEVENS (PER GIS, DEED NOT FND.)
- 17 SHERMAN STEVENS
INSTR. No. A201100094869
- 18 GEORGE A. BERRY & RUTH A. BERRY, H/W
INSTR. No. 67-7312
- 19 GEORGE BERRY & RUTH BERRY, H/W
INSTR. No. 77-003144
- 20 GEORGE ARNOLD BERRY & RUTH ANN BERRY, H/W
INSTR. No. 73-76267
- 114 NEW YORK CENTRAL LINES LLC
INSTR. No. 1999-0151430
AUGUST 10, 1999
- 1 VACATION OF PART OF BROOKSIDE AVE.
INSTR. No. 77-001891
JANUARY 12, 1977
EASEMENTS RESERVED FOR ALL UTILITIES

NOTE: THERE MAY BE INSTANCES THROUGH CURVES, OR WHERE ADDING THE SEGMENT LENGTHS OF LINES VERSUS THE OVERALL LENGTH, THERE APPEAR TO BE MATHEMATICAL ERRORS (+/- 0.01 FEET). THESE APPARENT ERRORS RESULT FROM NUMERIC ROUNDING, ARE CONSIDERED NEGLIGIBLE, AND, ARE THEREFORE NOT REVISED HEREIN.

ALIGNMENT TABLE

POINT No.	NORTHING	EASTING	MONUMENT TYPE	DESCRIPTION
600	18,164.9464	14,225.9475	REBAR SET W/ ORANGE "VSEI 0063" CAP	P.O.T. STA. 0+00.00 "10TH"
601	18,163.9712	15,115.2151	MAG NAIL SET	P.O.T. STA. 8+89.37 "10TH" P.O.T. STA. 5+00.00 "BSA"
602	18,249.6171	15,117.2571	CALCULATED POINT NO MON. SET	P.C. STA. 5+85.67 "BSA"
603	18,347.4645	15,168.3367	CALCULATED POINT NO MON. SET	P.T. STA. 6+99.99 "BSA"
634	18,311.1081	15,118.7231	MAG NAIL SET	P.I. STA. 6+47.18 "BSA"
650	18,448.3308	15,305.3929	CALCULATED POINT NO MON. SET	P.O.T. STA. 8+71.15 "BSA"

MONUMENT TABLE


POINT No.	NORTHING	EASTING	STATION	OFFSET	DESCRIPTION
100	18,155.6963	14,313.5255	STA. 0+87.68 "10TH"	8.91' RL	REBAR SET W/ RED "VSEI" CAP (SURVEY CONTROL POINT)
101	18,157.3891	14,917.7723	STA. 6+91.93 "10TH"	6.73' RL	REBAR SET W/ RED "VSEI" CAP (SURVEY CONTROL POINT)

"I AFFIRM, UNDER THE PENALTIES FOR PERJURY, THAT I HAVE TAKEN REASONABLE CARE TO REDACT EACH SOCIAL SECURITY NUMBER IN THIS DOCUMENT, UNLESS REQUIRED BY LAW."
NAME: *Matthew R. Healy* 6/27/14
MATTHEW R. HEALY, P.S.

LEGEND

ALIGNMENT
SECTION LINE
RIGHT-OF-WAY
RIGHT-OF-WAY EASEMENT
APPROXIMATE PARCEL LINE
LOT LINE
SUPERSEDED LOT LINE
EASEMENT LINE
EXISTING FENCE
EXISTING FLOWLINE
EXISTING TOPOGRAPHY
(R) RECORD DIMENSION
(M) MEASURED DIMENSION
(P) PLAN DIMENSION
123 CONTROL POINT
FND., SET, OR CALC.
APP. APPARENT
EP EDGE OF PAVEMENT
R/W RIGHT-OF-WAY
EX. EXISTING
M.C.S.O. MARION COUNTY SURVEYOR'S OFFICE


UNLESS NOTED OTHERWISE ALL MONUMENTS, FOUND OR SET, ARE LOCATED FLUSH WITH THE SURFACE

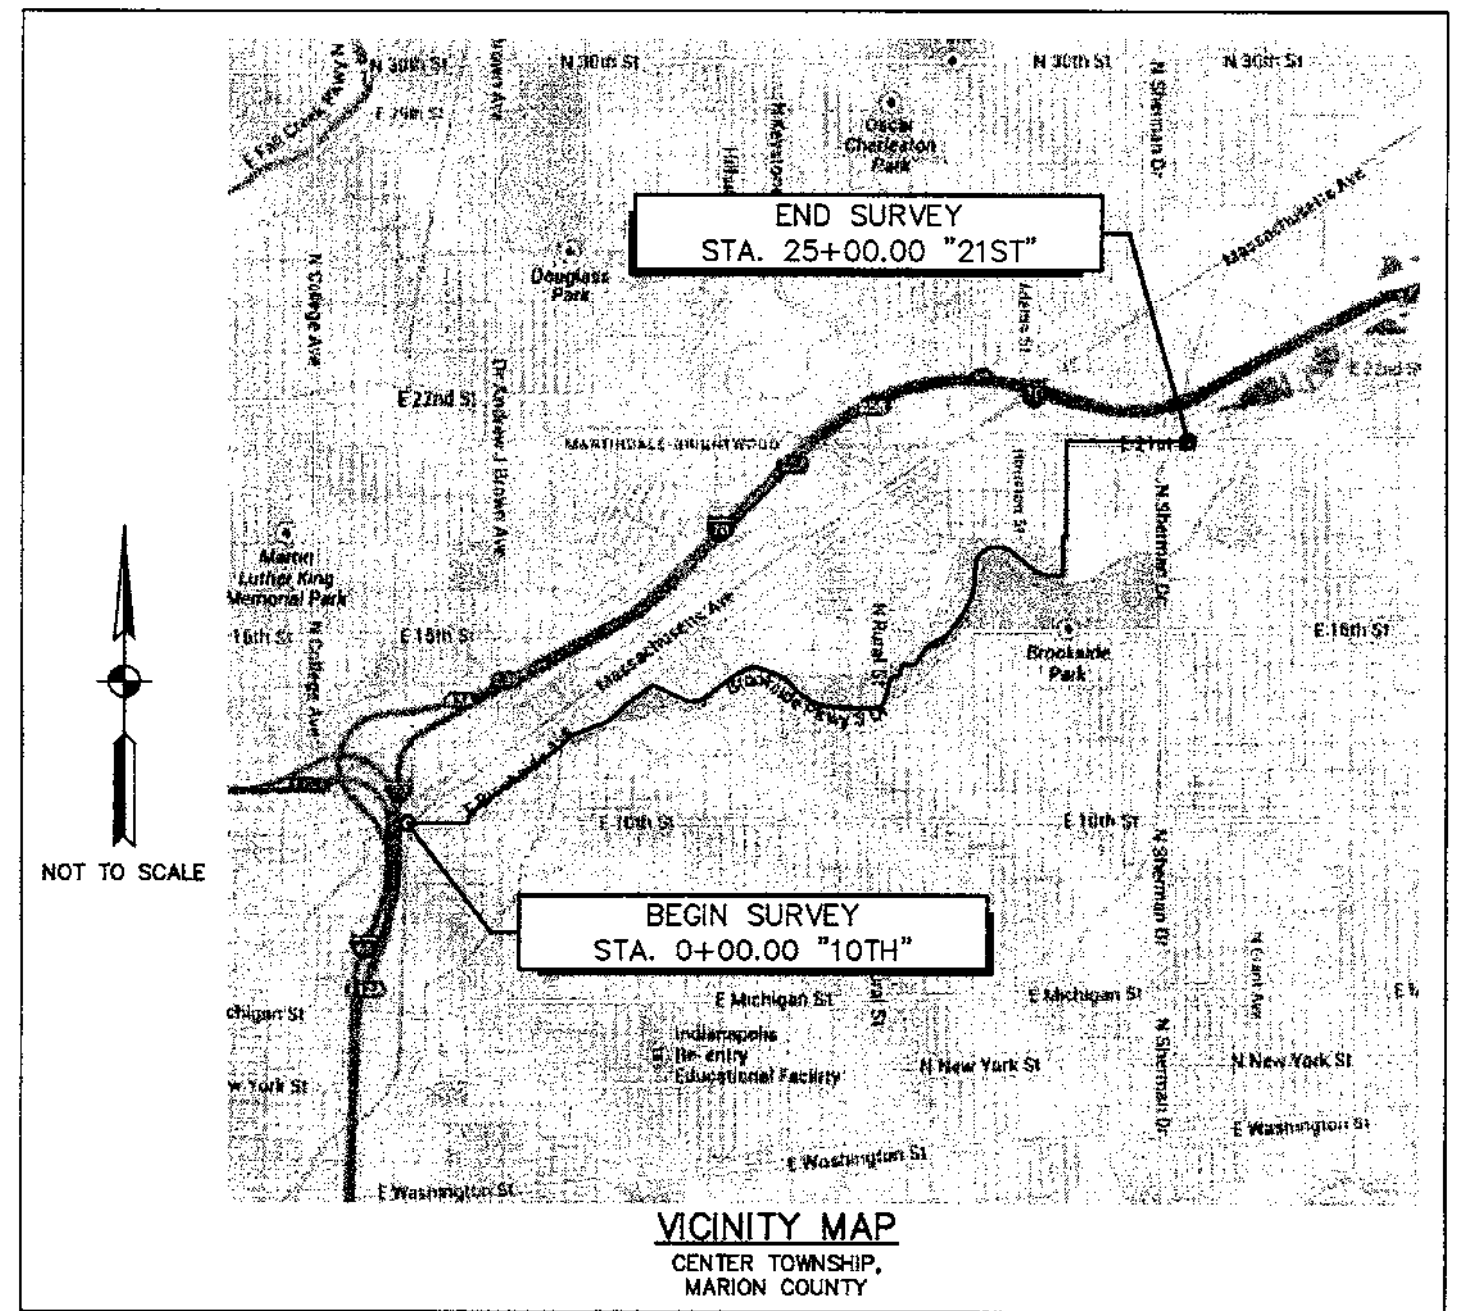

DIRECTORY: F:\2013\13-2072 Poplar Run Greenway\Survey\Drawings\USPS\...
DATE: 6/27/2014 10:40am

SURVEY STARTED 12/31/2013 SURVEY COMPLETED 05/02/2014 ROUTE PLAT SHEETS 1 of 15	VS ENGINEERING, INC. 4275 N. HIGH SCHOOL RD. INDIANAPOLIS, INDIANA 46254 TEL. (317) 293-3542 FAX: (317) 293-4737	FIELD SURVEYOR STATEMENT THIS SURVEY, TO THE BEST OF MY KNOWLEDGE AND BELIEF, IS EXECUTED ACCORDING TO THE PROVISIONS OF 865 I.A.C. 1-12-20 THROUGH 1-12-26 REGARDING ROUTE SURVEYS, EXCEPT THAT ANY DATA SHOWN REGARDING THE LOCATION OR DESCRIPTION OF THE EXISTING PARCELS IS NOT A PART OF THIS SURVEY.	MATTHEW R. HEALY REGISTERED No. 21000201 STATE OF INDIANA PROFESSIONAL SURVEYOR	RECOMMENDED FOR APPROVAL <i>Matthew R. Healy</i> 6/27/14 REGISTERED LAND SURVEYOR, FIELD DRAWN: JAG CHECKED: MRH	CITY OF INDIANAPOLIS DEPARTMENT OF PUBLIC WORKS LOCATION CONTROL ROUTE SURVEY LINE "10TH"	<table><tr><td>HORIZONTAL SCALE</td><td>DESIGNATION</td></tr><tr><td>1" = 50'</td><td></td></tr><tr><td>VERTICAL SCALE</td><td>N/A</td></tr><tr><td>SURVEY BOOK</td><td>SHEETS</td></tr><tr><td>CONTRACT</td><td>3 of 47</td></tr><tr><td></td><td>PROJECT</td></tr><tr><td></td><td>PA-25-001</td></tr></table>	HORIZONTAL SCALE	DESIGNATION	1" = 50'		VERTICAL SCALE	N/A	SURVEY BOOK	SHEETS	CONTRACT	3 of 47		PROJECT		PA-25-001
HORIZONTAL SCALE	DESIGNATION																			
1" = 50'																				
VERTICAL SCALE	N/A																			
SURVEY BOOK	SHEETS																			
CONTRACT	3 of 47																			
	PROJECT																			
	PA-25-001																			

MASSACHUSETTS AVE.

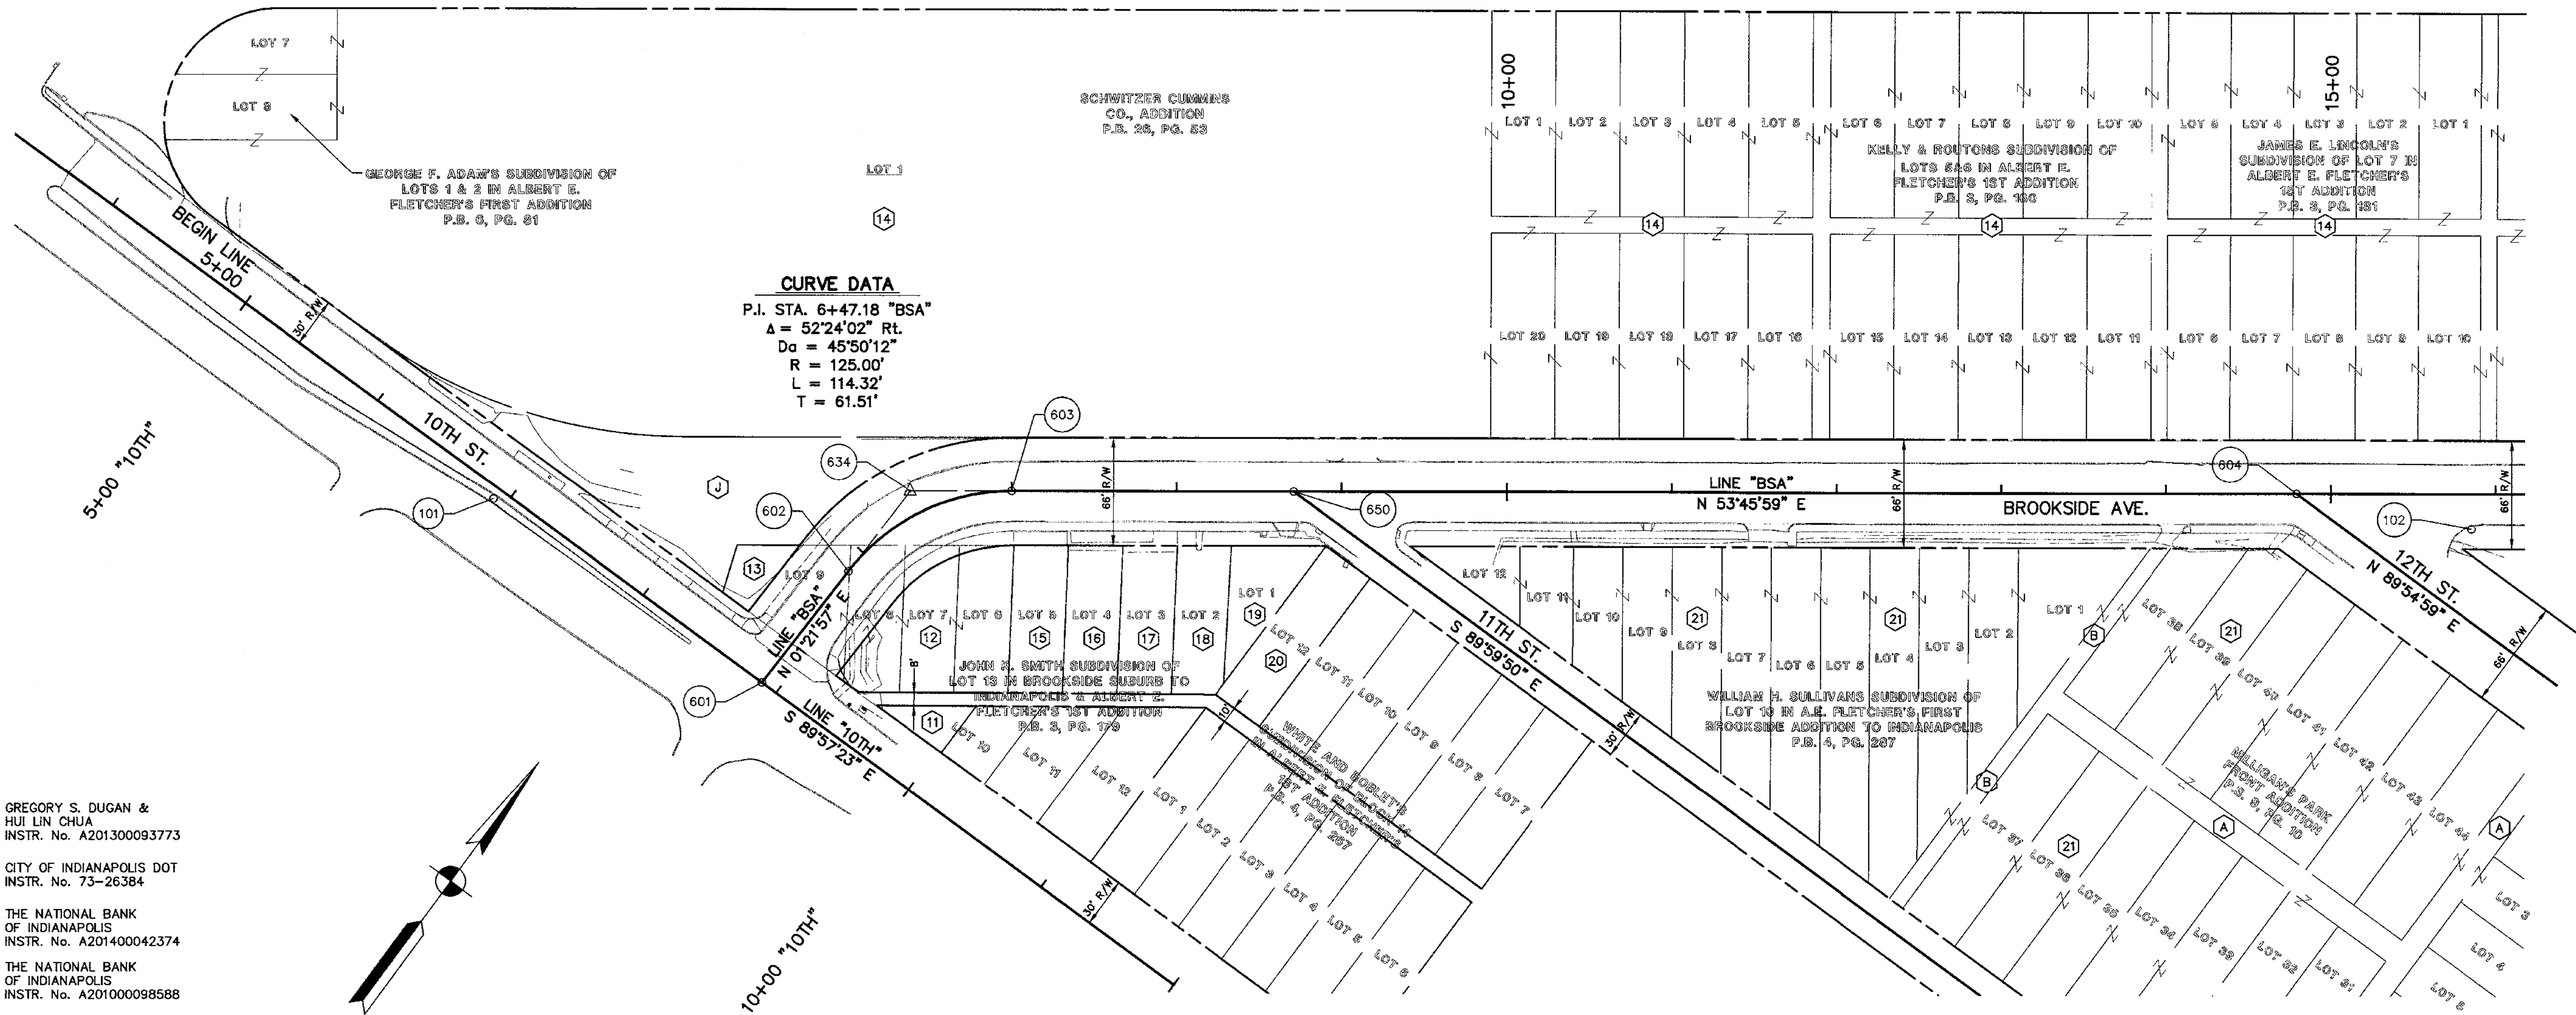

CURVE DATA
P.I. STA. 6+47.18 "BSA"
 $\Delta = 52^{\circ}24'02''$ Rt.
 $D_a = 45^{\circ}50'12''$
 $R = 125.00'$
 $L = 114.32'$
 $T = 61.51'$

SCALE 1"=50'

ALIGNMENT TABLE

POINT No.	NORTHING	EASTING	MONUMENT TYPE	DESCRIPTION
601	18,163.9712	15,115.2151	MAG NAIL SET	P.O.T. STA. 8+89.37 "10TH" P.O.T. STA. 5+00.00 "BSA"
602	18,249.6171	15,117.2571	CALCULATED POINT NO MON. SET	P.C. STA. 5+85.67 "BSA"
603	18,347.4645	15,168.3367	CALCULATED POINT NO MON. SET	P.T. STA. 6+99.89 "BSA"
604	18,808.0409	15,796.8805	MAG NAIL SET	P.O.T. STA. 14+79.20 "BSA"
634	18,311.1081	15,118.7231	MAG NAIL SET	P.I. STA. 6+47.18 "BSA"
650	18,448.6308	15,308.3929	CALCULATED POINT NO MON. SET	P.O.T. STA. 8+71.15 "BSA"

MONUMENT TABLE

POINT No.	NORTHING	EASTING	STATION	OFFSET	DESCRIPTION
101	18,157.3891	14,917.7723	STA. 6+91.93 "10TH"	6.73' RL	REBAR SET W/ RED "VSET" CAP (SURVEY CONTROL POINT)
102	18,853.9413	15,884.9410	STA. 15+85.45 "BSA"	20.95' RL	REBAR SET W/ RED "VSET" CAP (SURVEY CONTROL POINT)

NOTE:
THERE MAY BE INSTANCES THROUGH CURVES, OR WHERE
ADDING THE SEGMENT LENGTHS OF LINES VERSUS THE
OVERALL LENGTH, THERE APPEAR TO BE MATHEMATICAL
ERRORS (+/- 0.01 FEET). THESE APPARENT ERRORS
RESULT FROM NUMERIC ROUNDING, ARE CONSIDERED
NEGLECTABLE, AND, ARE THEREFORE NOT REVISED HEREIN.

LEGEND

	ALIGNMENT
	SECTION LINE
	RIGHT-OF-WAY
	RIGHT-OF-WAY EASEMENT
	APPROXIMATE PARCEL LINE
	LOT LINE
	SUPERSEDED LOT LINE
	EASEMENT LINE
	EXISTING FENCE
	EXISTING FLOWLINE
	EXISTING TOPOGRAPHY
	RECORD DIMENSION
	MEASURED DIMENSION
	PLAN DIMENSION
	CONTROL POINT
	FND., SET, OR CALC.
	APP. APPARENT
	EP EDGE OF PAVEMENT
	R/W RIGHT-OF-WAY
	EX. EXISTING
	M.C.S.O. MARION COUNTY SURVEYOR'S OFFICE

UNLESS NOTED OTHERWISE ALL MONUMENTS, FOUND OR SET, ARE LOCATED FLUSH WITH THE SURFACE


- 11 GREGORY S. DUGAN & HUI LIN CHUA
INSTR. No. A201300093773
- 12 CITY OF INDIANAPOLIS DOT
INSTR. No. 73-26384
- 13 THE NATIONAL BANK OF INDIANAPOLIS
INSTR. No. A201400042374
- 14 THE NATIONAL BANK OF INDIANAPOLIS
INSTR. No. A201000098588
- 15 GEORGE A. BERRY & RUTH A. BERRY
INSTR. No. 840013953
- 16 SHERMAN STEVENS
(PER GIS, DEED NOT FND.)
- 17 SHERMAN STEVENS
INSTR. No. A201100094869
- 18 GEORGE A. BERRY & RUTH A. BERRY, H/W
INSTR. No. 67-7312
- 19 GEORGE BERRY & RUTH BERRY, H/W
INSTR. No. 77-003144
- 20 GEORGE ARNOLD BERRY & RUTH ANN BERRY, H/W
INSTR. No. 73-76267
- 21 THE NATIONAL BANK OF INDIANAPOLIS
INSTR. No. A201000098588
- A VACATED ALLEY
DECLARATORY RESOLUTION 18047
D.R. 1993, PG. 575
- B VACATED ALLEY
DECLARATORY RESOLUTION 18106
INSTR. No. 64-22370
- J VACATION OF PART OF BROOKSIDE AVE.
INSTR. No. 77-001891
JANUARY 12, 1977
EASEMENTS RESERVED FOR ALL UTILITIES

SURVEY STARTED	12/31/2013
SURVEY COMPLETED	05/02/2014
ROUTE PLAT SHEETS	2 of 15

VS ENGINEERING, INC.
4275 N. HIGH SCHOOL RD. INDIANAPOLIS, INDIANA 46254
TEL. (317) 293-3542 FAX: (317) 293-4737

FIELD SURVEYOR STATEMENT


THIS SURVEY, TO THE BEST OF MY KNOWLEDGE AND BELIEF, IS
EXECUTED ACCORDING TO THE PROVISIONS OF 865 I.A.C. 1-12-20
THROUGH 1-12-26 REGARDING ROUTE SURVEYS, EXCEPT THAT ANY
DATA SHOWN REGARDING THE LOCATION OR DESCRIPTION OF THE
EXISTING PARCELS IS NOT A PART OF THIS SURVEY.

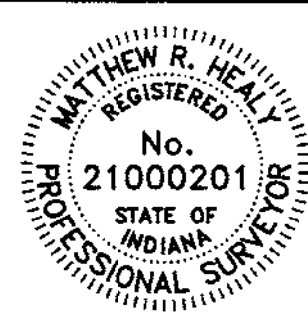

RECOMMENDED FOR APPROVAL
REGISTERED LAND SURVEYOR, FIELD
DRAWN: JAG CHECKED: MRH

CITY OF INDIANAPOLIS
DEPARTMENT OF PUBLIC WORKS
LOCATION CONTROL ROUTE SURVEY
LINE "BSA"

HORIZONTAL SCALE	DESIGNATION
1" = 50'	
VERTICAL SCALE	
N/A	
SURVEY BOOK	SHEETS
	4 of 47
CONTRACT	PROJECT
	PA-25-001

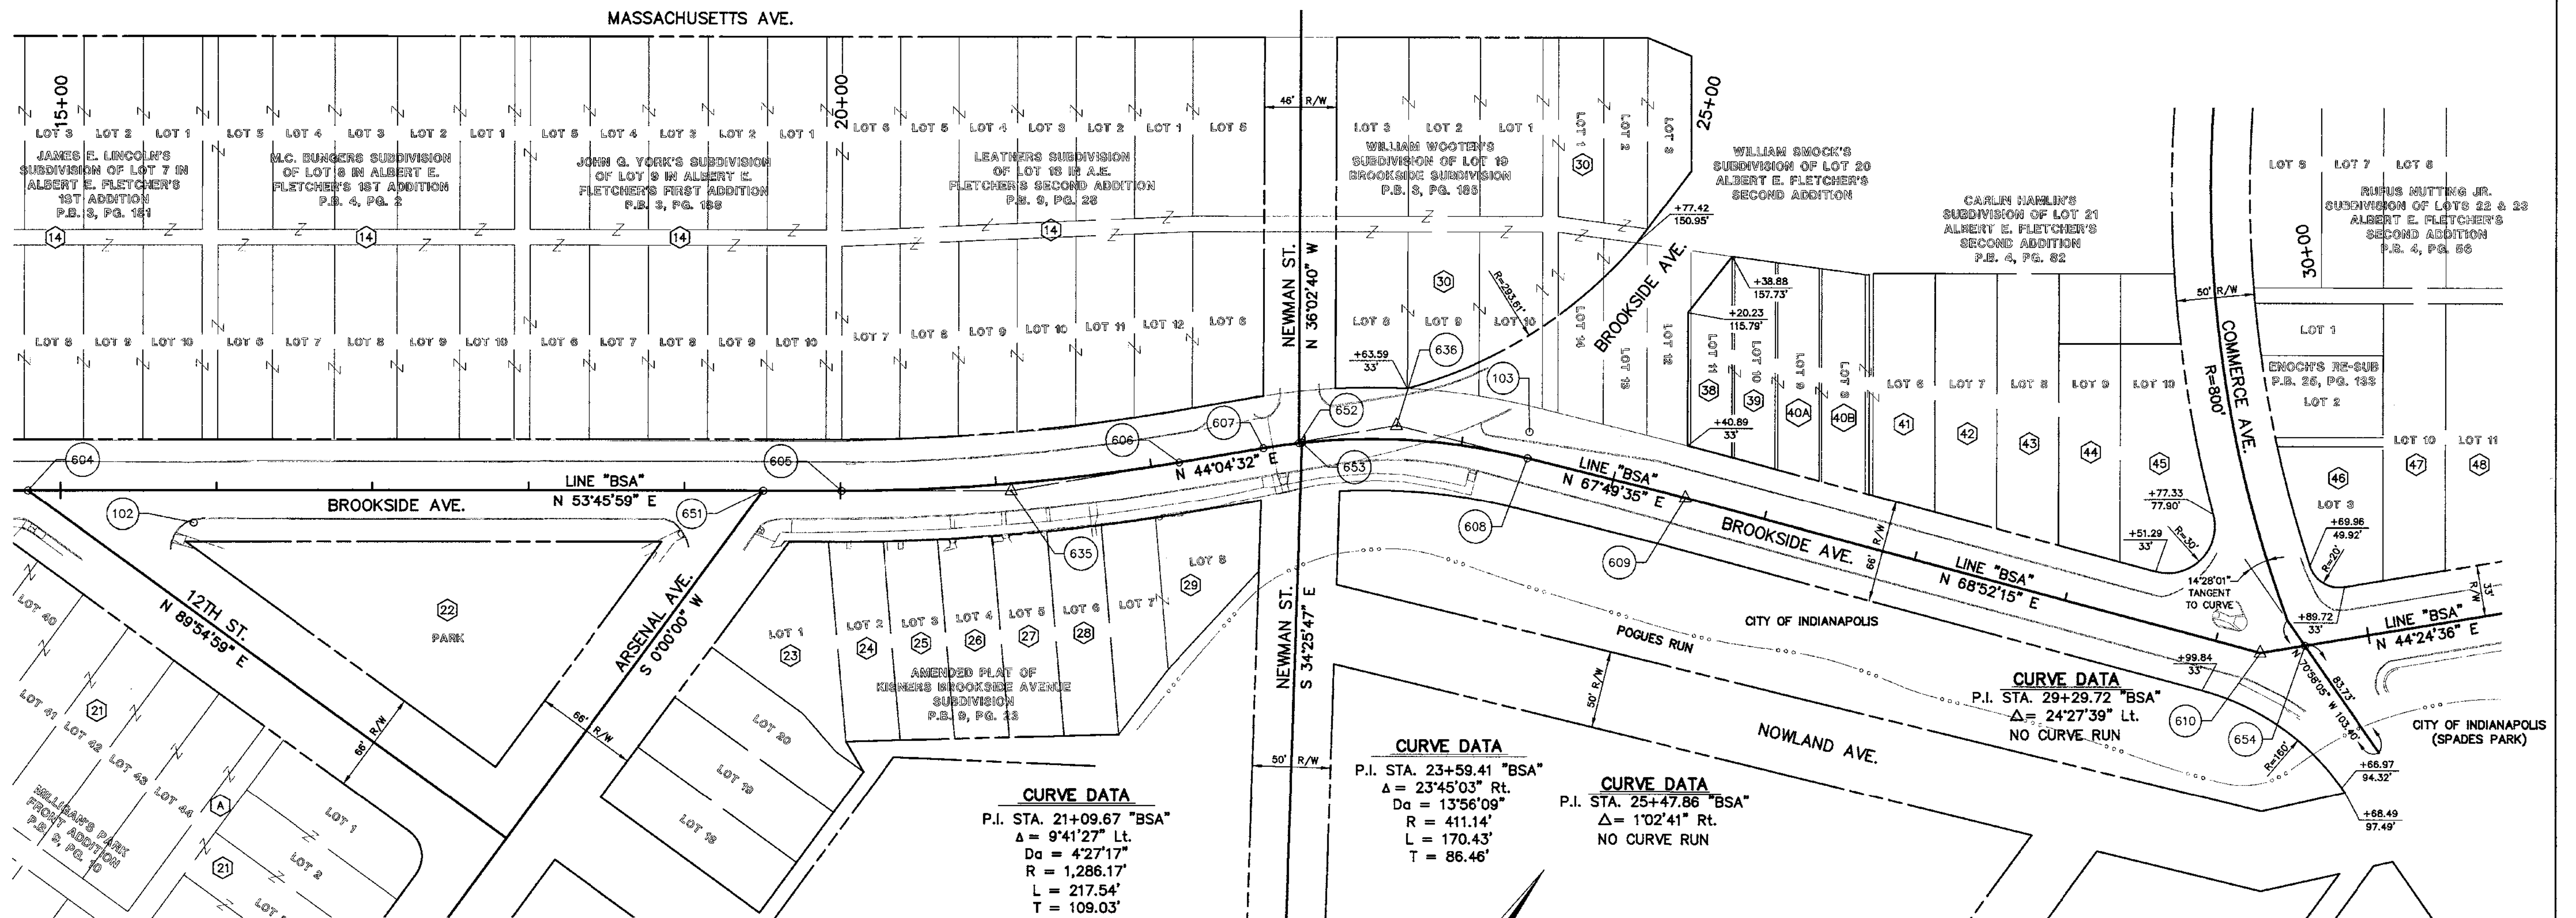


LEGEND

	ALIGNMENT
	SECTION LINE
	RIGHT-OF-WAY
	RIGHT-OF-WAY EASEMENT
	APPROXIMATE PARCEL LINE
	LOT LINE
	SUPERSEDED LOT LINE
	EASEMENT LINE
	EXISTING FENCE
	EXISTING FLOWLINE
	EXISTING TOPOGRAPHY
(R)	RECORD DIMENSION
(M)	MEASURED DIMENSION
(P)	PLAN DIMENSION
	CONTROL POINT
	FND., SET, OR CALC.
APP.	APPARENT
EP	EDGE OF PAVEMENT
R/W	RIGHT-OF-WAY
EX.	EXISTING
M.C.S.O.	MARION COUNTY SURVEYOR'S OFFICE

UNLESS NOTED OTHERWISE ALL MONUMENTS, FOUND OR SET, ARE LOCATED FLUSH WITH THE SURFACE

ALIGNMENT TABLE

POINT No.	NORTHING	EASTING	MONUMENT TYPE	DESCRIPTION
604	18,808.0409	15,796.8605	MAG NAIL SET	P.O.T. STA. 14+79.20 "BSA"
605	19,116.2522	16,217.4600	CALCULATED POINT NO MON. SET	P.C. STA. 20+00.64 "BSA"
606	19,256.0277	16,381.2473	CALCULATED POINT NO MON. SET	P.T. STA. 22+18.18 "BSA"
607	19,298.3782	16,419.3480	CALCULATED POINT NO MON. SET	P.C. STA. 22+72.96 "BSA"
608	19,393.1213	16,559.5511	CALCULATED POINT NO MON. SET	P.T. STA. 24+43.39 "BSA"
609	19,432.5497	16,658.2943	MAG NAIL SET	P.I. STA. 25+47.86 "BSA"
610	19,570.1986	17,012.4821	MAG NAIL SET	P.I. STA. 29+29.72 "BSA"
635	19,180.6977	16,305.4053	MAG NAIL SET	P.I. STA. 21+09.67 "BSA"
636	19,360.4911	16,479.4880	MAG NAIL SET	P.I. STA. 23+59.41 "BSA"
651	19,086.6398	16,177.0495	CALCULATED POINT NO MON. SET	P.O.T. STA. 19+50.54 "BSA"
652	19,314.5157	16,435.8762	CALCULATED POINT NO MON. SET	P.O.C. STA. 22+96.08 "BSA"
653	19,315.8180	16,437.2939	CALCULATED POINT NO MON. SET	P.O.C. STA. 22+97.98 "BSA"
654	19,590.8446	17,032.7073	CALCULATED POINT NO MON. SET	P.O.T. STA. 29+58.62 "BSA"

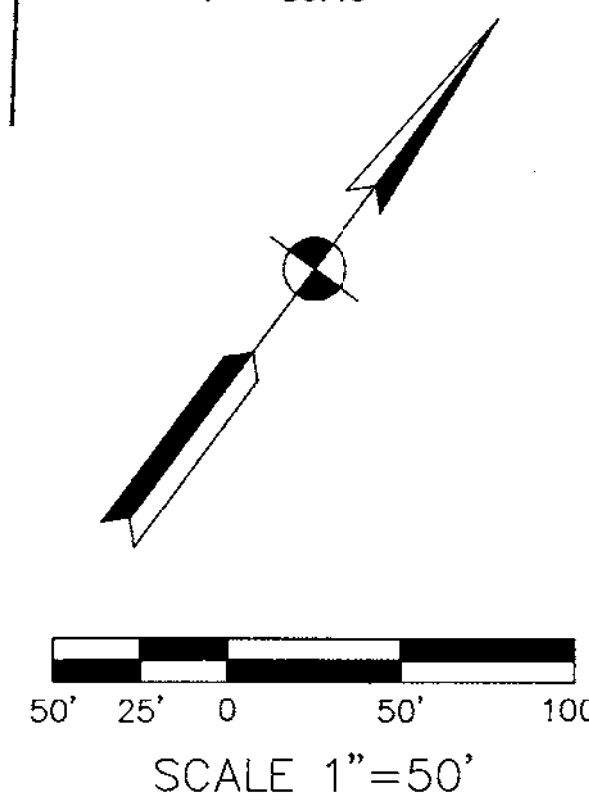

NOTE:
ALL EXISTING R/W ON THIS SHEET IS DESCRIBED FROM LINE "BSA" EXCEPT AS SHOWN.

MONUMENT TABLE

POINT No.	NORTHING	EASTING	STATION	OFFSET	DESCRIPTION
102	18,853.9413	15,894.9410	STA. 15+85.45 "BSA"	20.95' RL	REBAR SET W/ RED "VSEI" CAP (SURVEY CONTROL POINT)
103	19,407.5836	16,550.5798	STA. 24+40.65 "BSA"	16.79' LL	REBAR SET W/ RED "VSEI" CAP (SURVEY CONTROL POINT)

NOTE:
THERE MAY BE INSTANCES THROUGH CURVES, OR WHERE ADDING THE SEGMENT LENGTHS OF LINES VERSUS THE OVERALL LENGTH, THERE APPEAR TO BE MATHEMATICAL ERRORS (+/- 0.01 FEET). THESE APPARENT ERRORS RESULT FROM NUMERIC ROUNDING, ARE CONSIDERED NEGLIGIBLE, AND, ARE THEREFORE NOT REVISED HEREIN.

- 14 THE NATIONAL BANK OF INDIANAPOLIS INSTR. No. A201000098588
- 21 THE NATIONAL BANK OF INDIANAPOLIS INSTR. No. A201000098588
- 22 WINDSOR PARK NEIGHBORHOOD ASSOCIATION INC. INSTR. No. A201300063413
- 23 ROBERT L. KOSCH INSTR. No. 2001-0032180
- 24 RUSSELL P. MAY & LULA E. MAY, H/W INSTR. No. 840090879
- 25 MICHAEL ROJAS INSTR. No. 2004-0012433
- 26 DOROTHY JEAN LAY INSTR. No. 830094306
- 27 CHRISTOPHER C. HARPEL INSTR. No. A201100115438
- 28 OWEN DAVIS & MARGARET W. DAVIS, H/W INSTR. No. 79-58526
- 29 MUHAMMAD EEDOUS INSTR. No. A201300044556
- 30 THE FOUNDATION AGAINST COMPANION-ANIMAL EUTHANASIA, INC. INSTR. No. 1997-0181336
- 38 WILLIAM E. WISE INSTR. No. 81-00777
- 39 BETTY LAVERN LAUER, JULIA ANN BELCHER, BARBARA JEAN ZWICK (3/4 INTEREST) & DON WHITNEY, DENNIS WHITNEY, DOUG WHITNEY (1/4 INTEREST) INSTR. No. 900067732
- 40A PEGGY S. GRABLE INSTR. No. 2007-0150024
- 40B PEGGY S. GRABLE INSTR. No. 2007-0150023
- 41 JAMES D. GRABLE & PEGGY GRABLE, H/W INSTR. No. 910102859
- 42 CBA ENTERPRISES, LLC INSTR. No. A201100049773
- 43 MICHAEL LEHANE INSTR. No. 2001-0157894
- 44 CLAUDIA N. ESTRADA INSTR. No. A201200111968
- 45 DARLENE D. MARTIN INSTR. No. A201200071772
- 46 CHARMAINE GRABLE INSTR. No. 2002-0042593
- 47 BLANCHE LOUISE WELSHANS INSTR. No. 1994-0057239
- 48 BLANCHE L. WELSHANS INSTR. No. 1994-0080680
- A VACATED ALLEY DECLARATORY RESOLUTION 18047 D.R. 1993, PG. 575


DIRECTORY: F:\2013\13-2072 Route Run (Greenway)\SURVEY\DRAWINGS\LOBS\...
 DRAWN BY: JAG DATE: 06/27/14 SCALE: 1"=50'

SURVEY STARTED	12/31/2013
SURVEY COMPLETED	05/02/2014
ROUTE PLAT SHEETS	3 of 15

VS ENGINEERING, INC.
 4275 N. HIGH SCHOOL RD. INDIANAPOLIS, INDIANA 46254
 TEL. (317) 293-3542 FAX: (317) 293-4737

FIELD SURVEYOR STATEMENT

THIS SURVEY, TO THE BEST OF MY KNOWLEDGE AND BELIEF, IS EXECUTED ACCORDING TO THE PROVISIONS OF 865 I.A.C. 1-12-20 THROUGH 1-12-26 REGARDING ROUTE SURVEYS, EXCEPT THAT ANY DATA SHOWN REGARDING THE LOCATION OR DESCRIPTION OF THE EXISTING PARCELS IS NOT A PART OF THIS SURVEY.








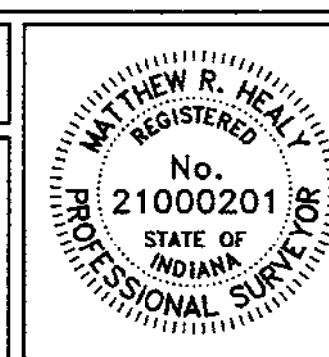


RECOMMENDED FOR APPROVAL: *[Signature]* 6/27/14
 REGISTERED LAND SURVEYOR, FIELD






DRAWN: JAG CHECKED: MRH

CITY OF INDIANAPOLIS
DEPARTMENT OF PUBLIC WORKS
LOCATION CONTROL ROUTE SURVEY
LINE "BSA"




























HORIZONTAL SCALE	DESIGNATION
1" = 50'	
VERTICAL SCALE	
N/A	
SURVEY BOOK	SHEETS
	5 of 47
CONTRACT	PROJECT
	PA-25-001

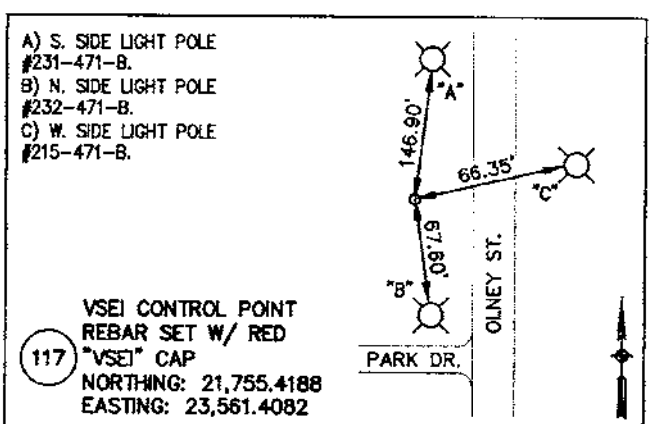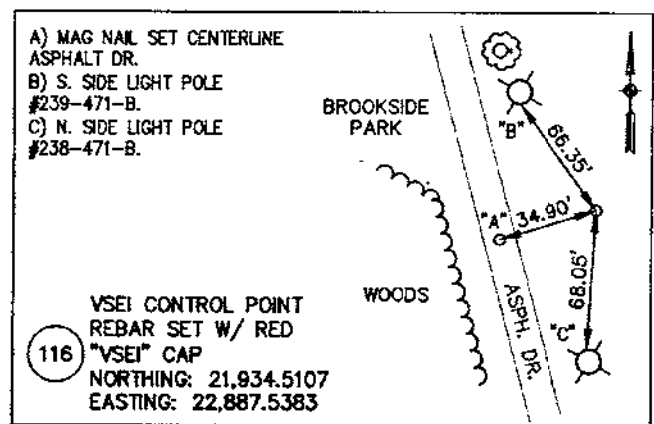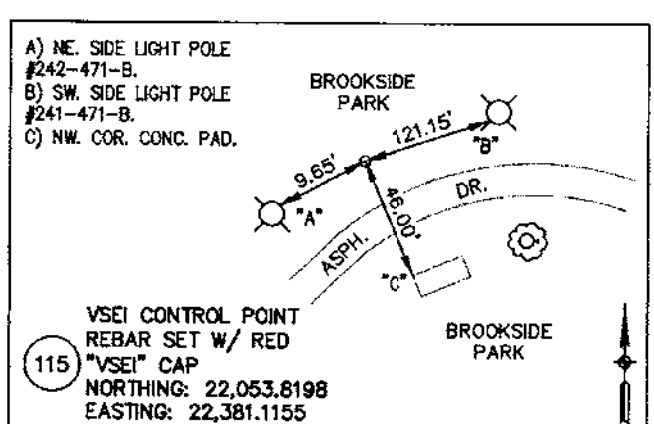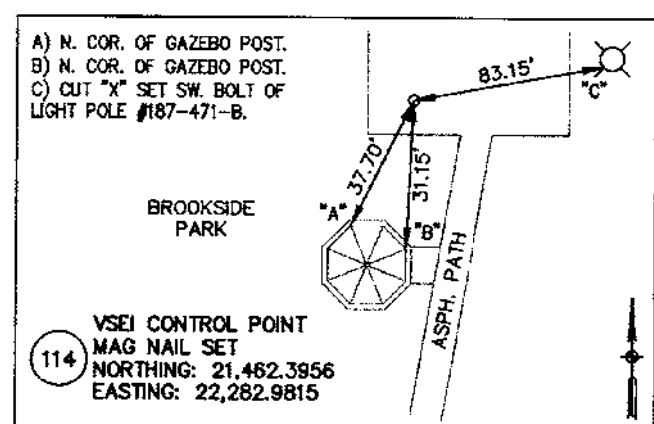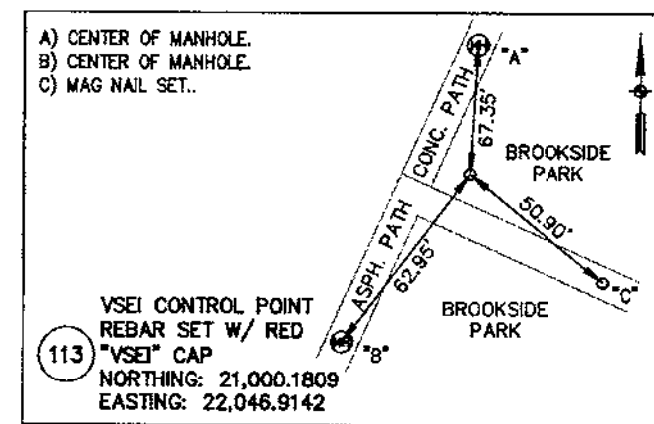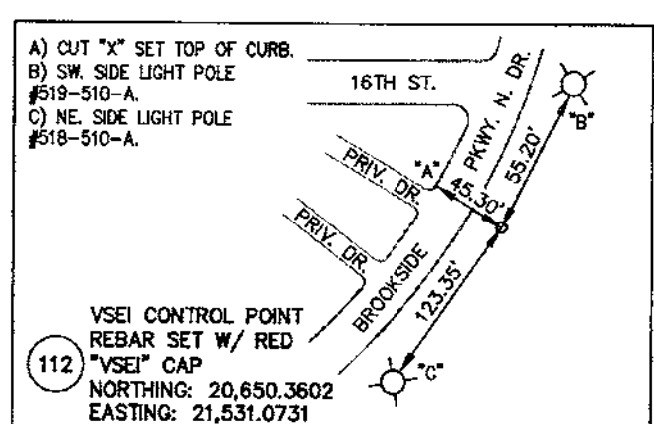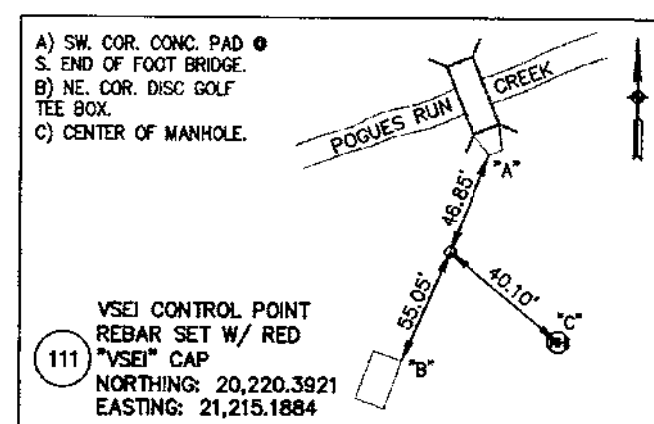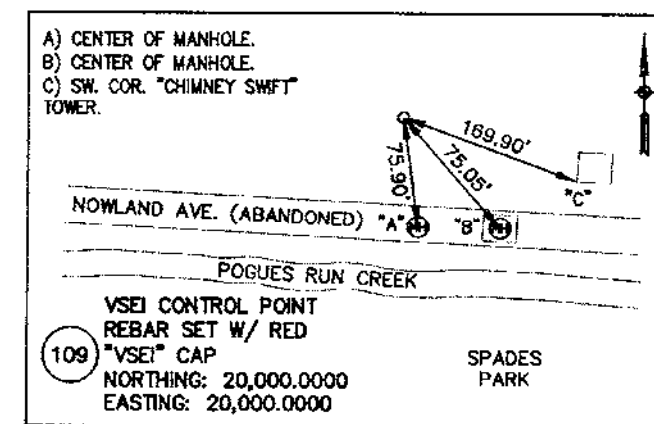

VSEI CONTROL POINT REFERENCES

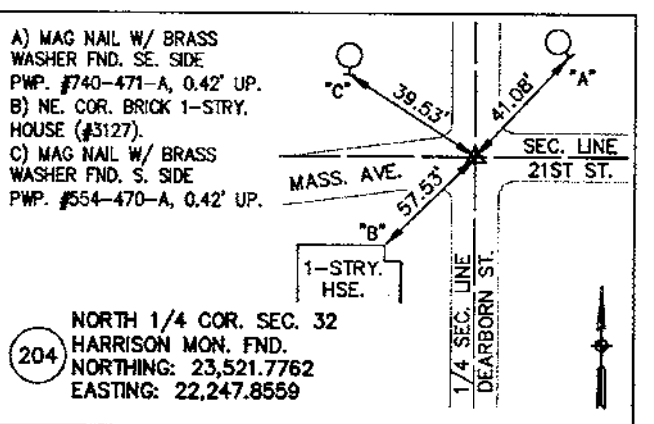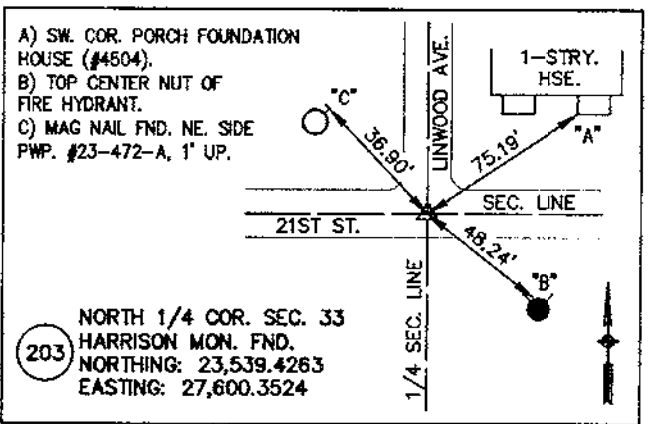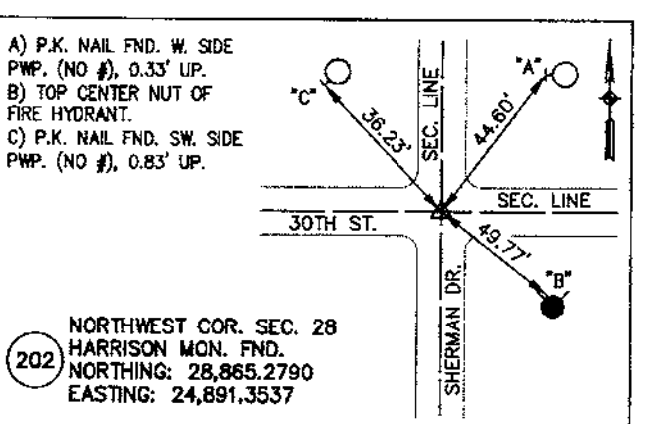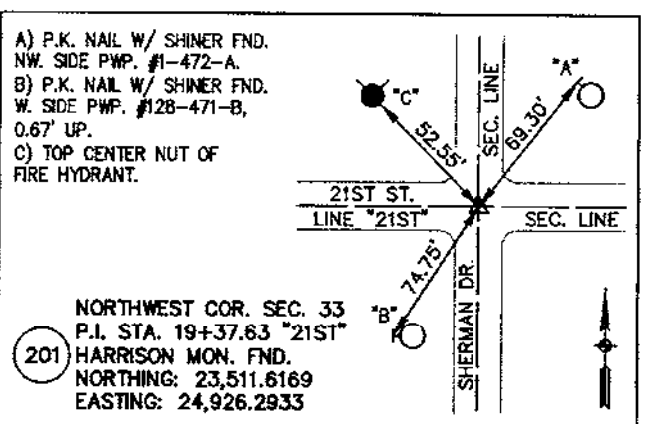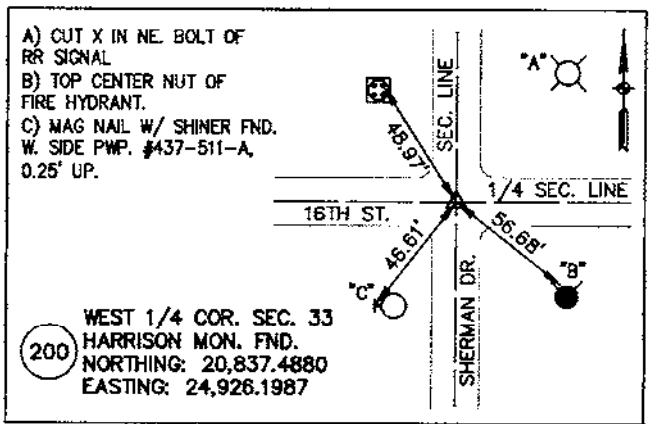

SECTION CORNER REFERENCES

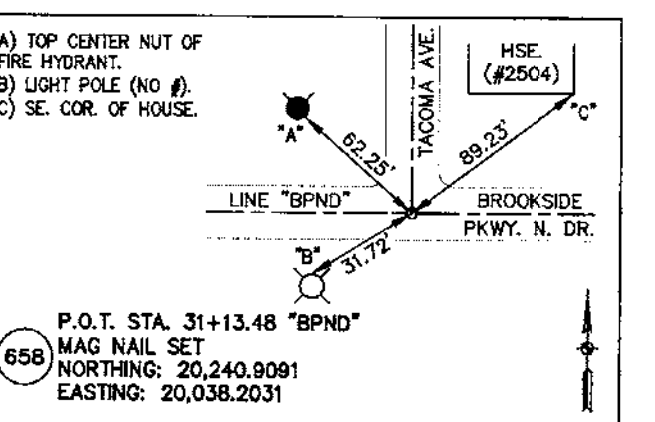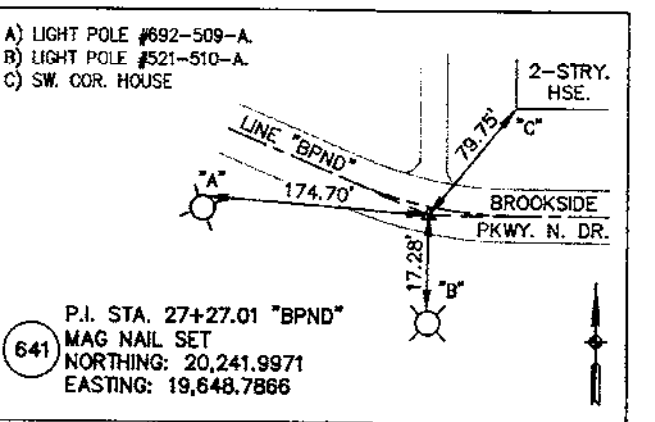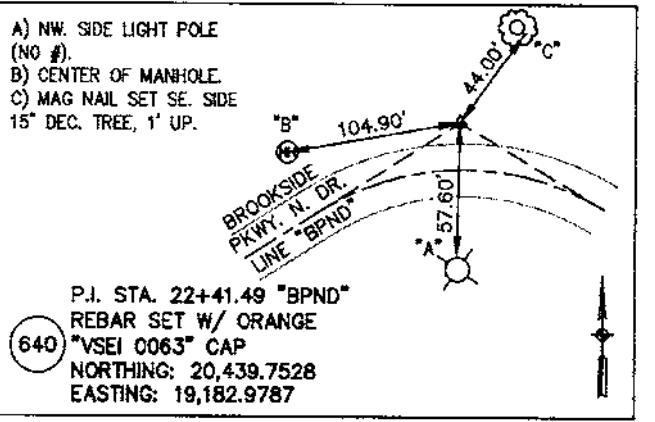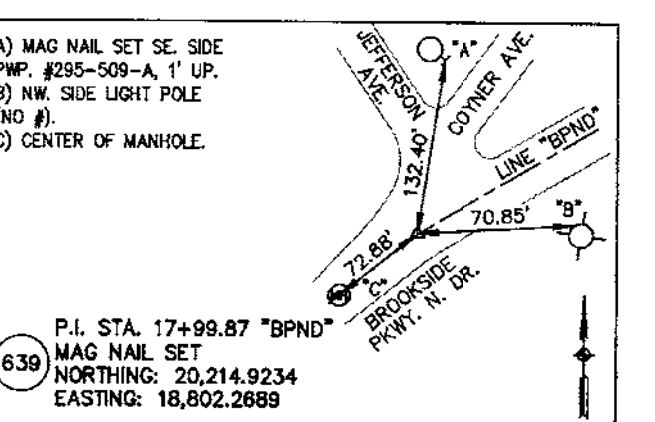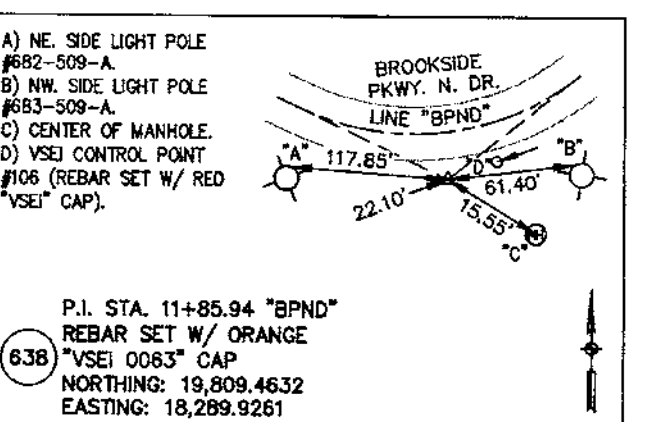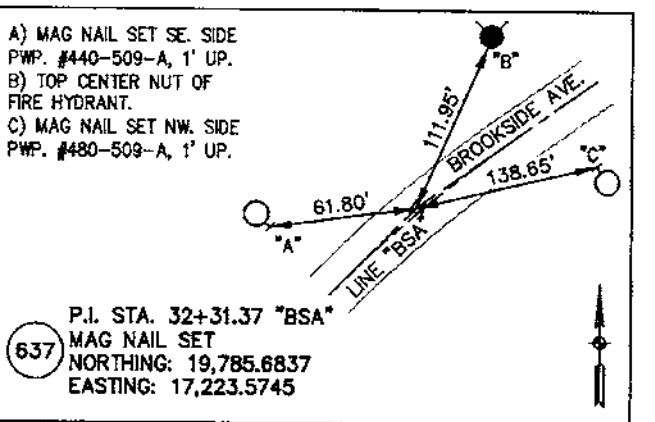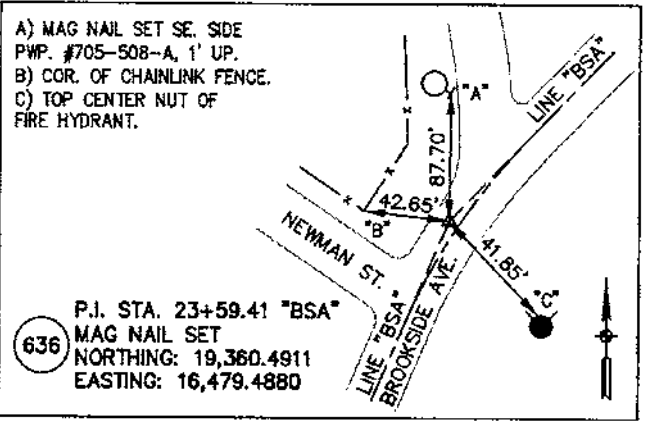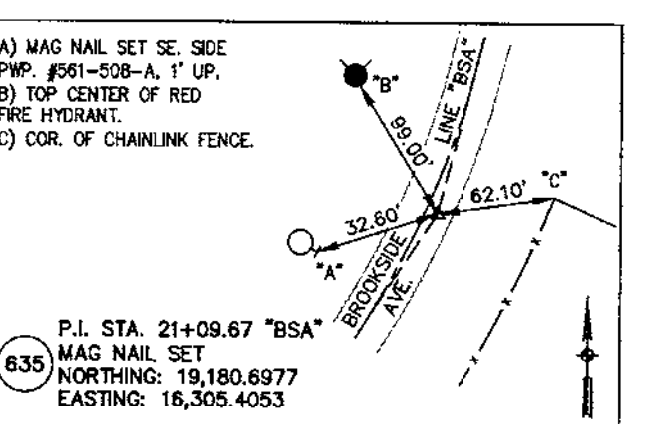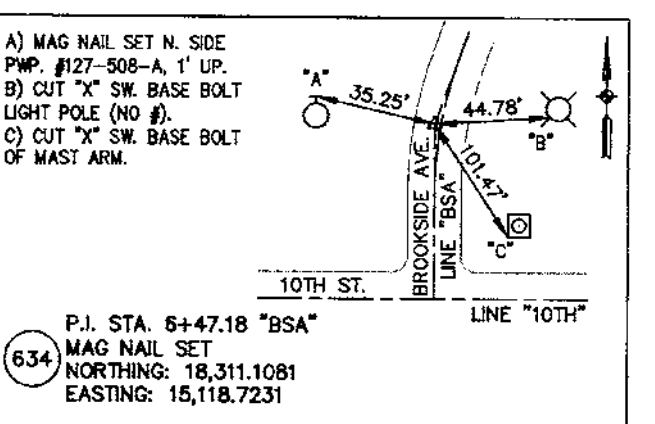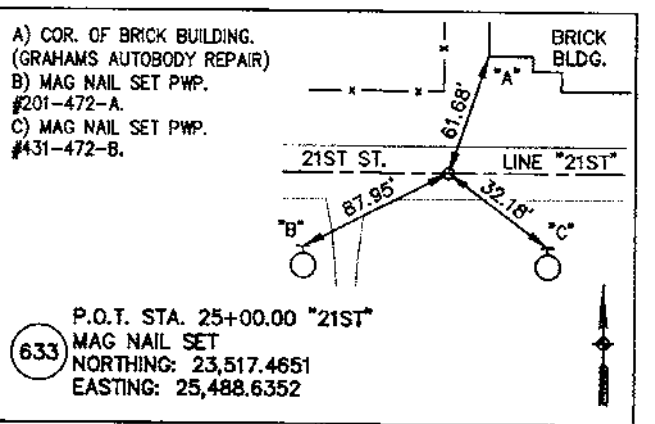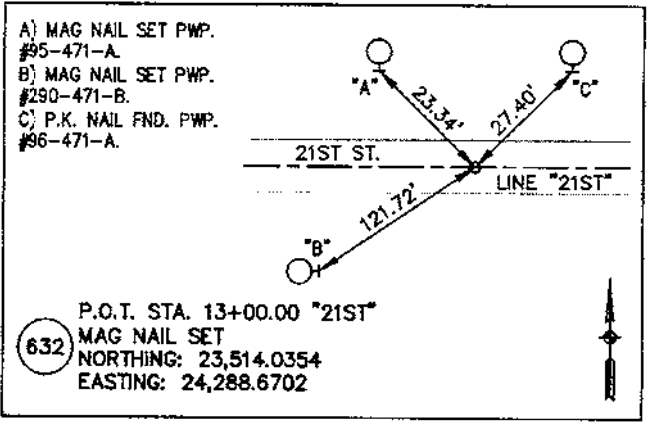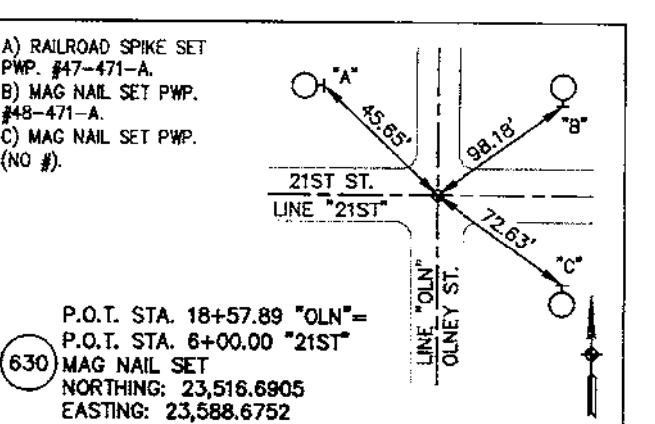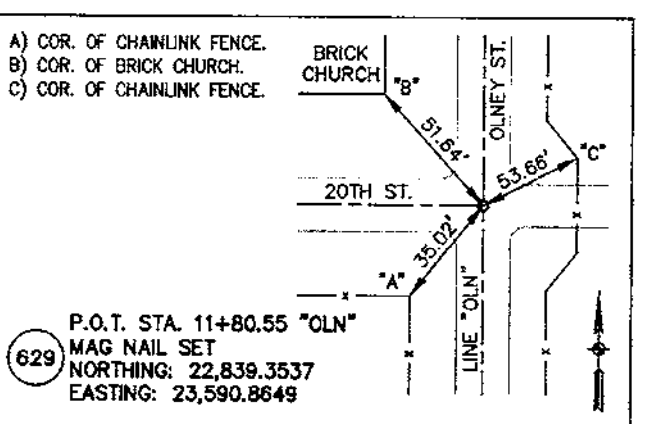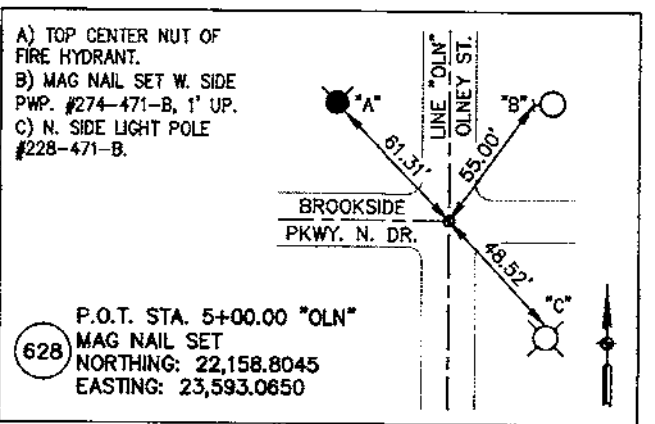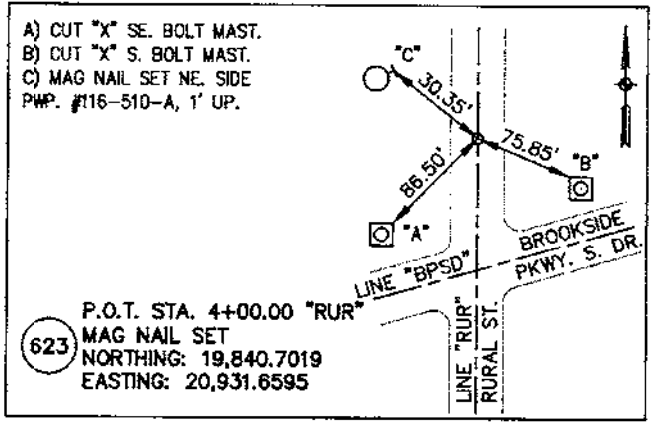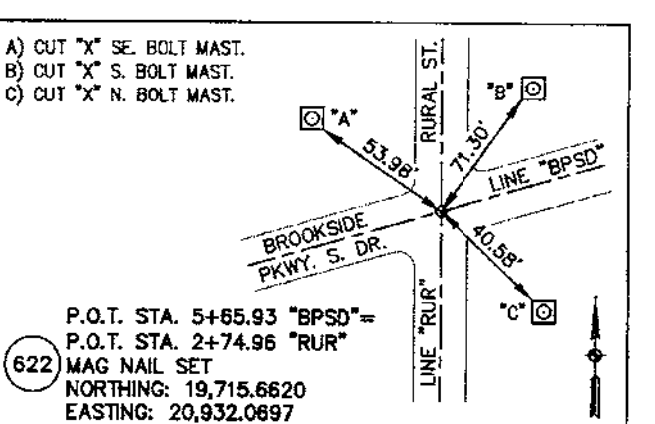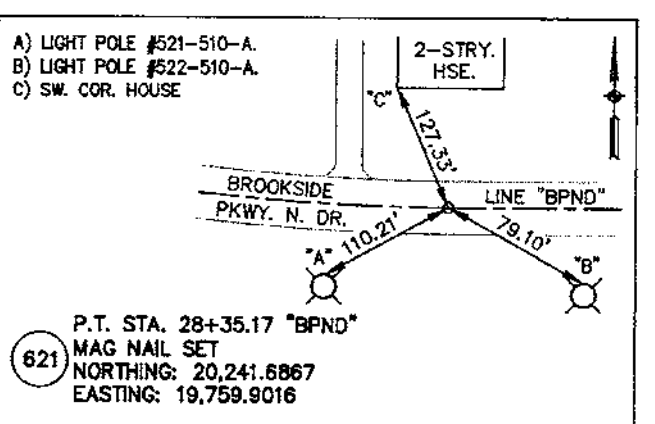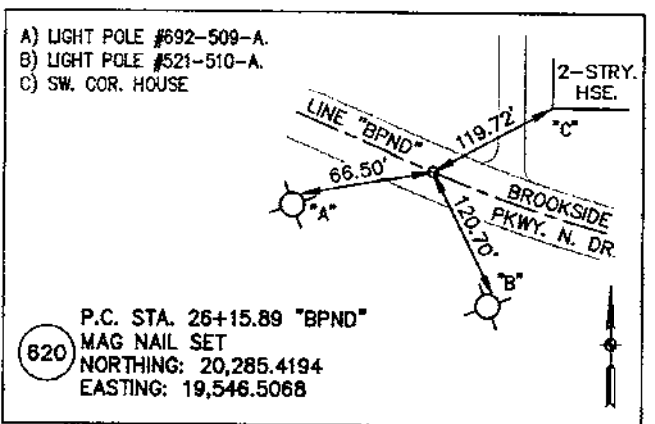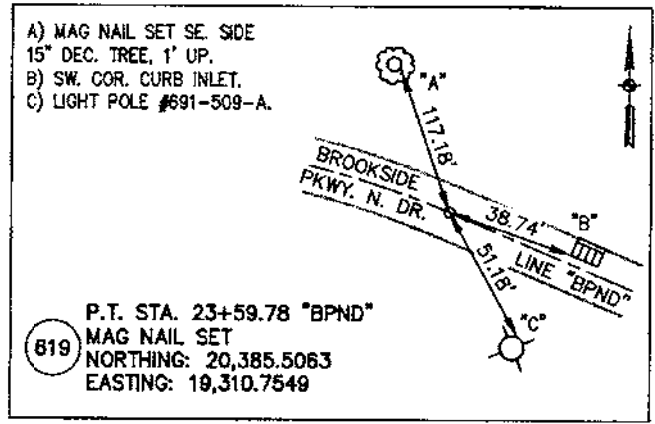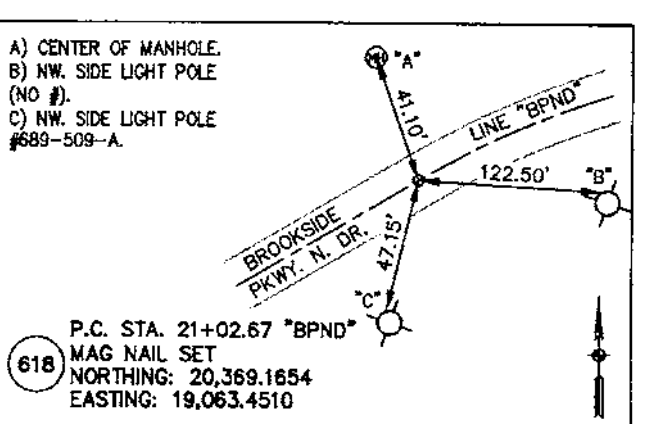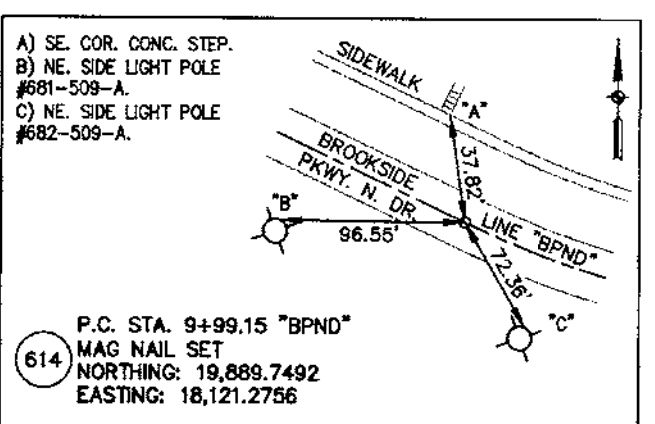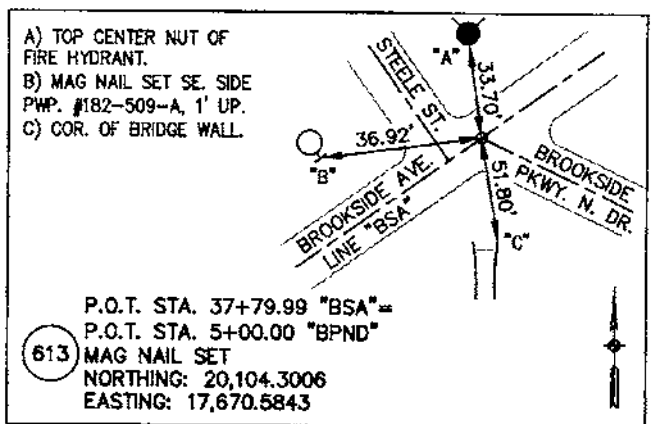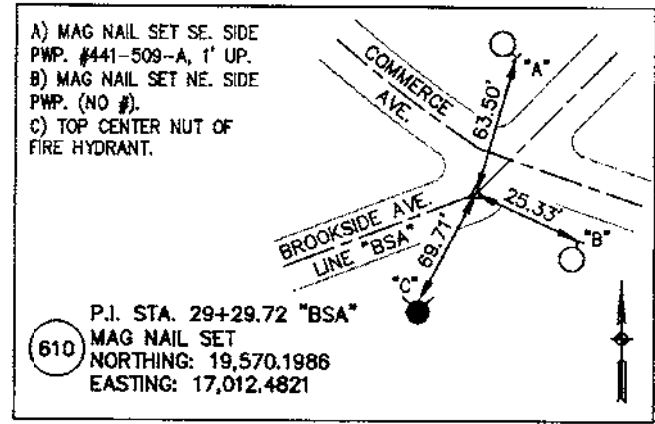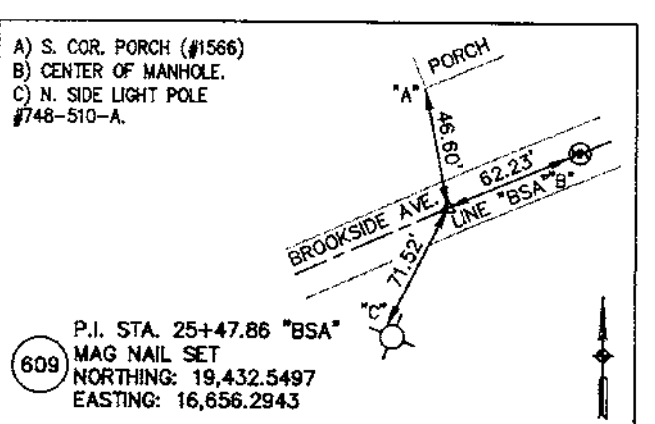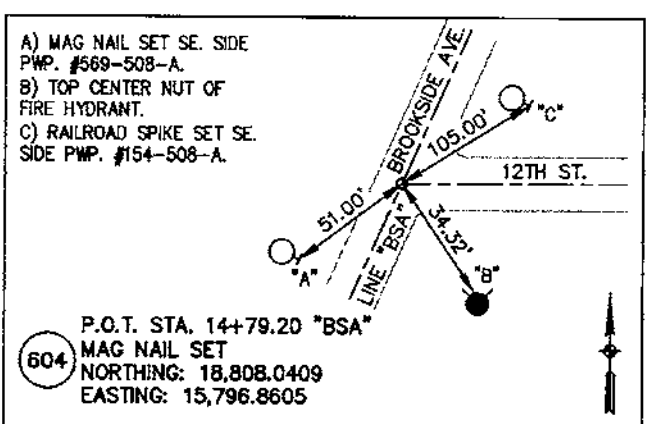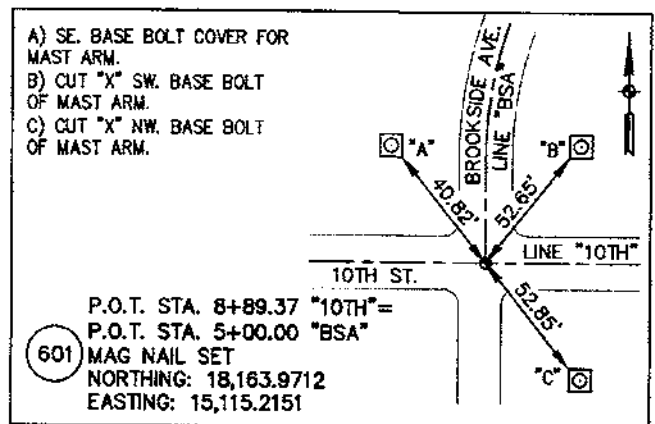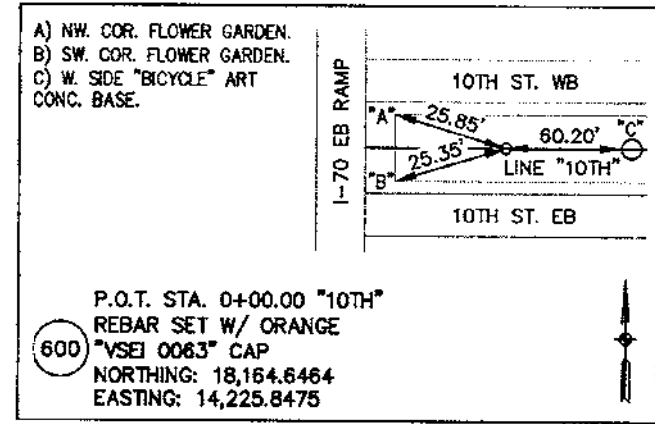

ALIGNMENT REFERENCES

VS ENGINEERING, INC.
4275 N. HIGH SCHOOL RD. INDIANAPOLIS, INDIANA 46254
TEL. (317) 293-3542 FAX: (317) 293-4737

FIELD SURVEYOR STATEMENT

THIS SURVEY, TO THE BEST OF MY KNOWLEDGE AND BELIEF, IS EXECUTED ACCORDING TO THE PROVISIONS OF 885 I.A.C. 1-12-26 THROUGH 1-12-26 REGARDING ROUTE SURVEYS, EXCEPT THAT ANY DATA SHOWN REGARDING THE LOCATION OR DESCRIPTION OF THE EXISTING PARCELS IS NOT A PART OF THIS SURVEY.



RECOMMENDED FOR APPROVAL
REGISTERED LAND SURVEYOR, FIELD
DRAWN: JAG CHECKED: MRH

CITY OF INDIANAPOLIS
DEPARTMENT OF PUBLIC WORKS
LOCATION CONTROL ROUTE SURVEY REFERENCES

HORIZONTAL SCALE	N/A	DESIGNATION
VERTICAL SCALE	N/A	
SURVEY BOOK	6	SHEETS
CONTRACT	of	47
		PROJECT
		PA-25-001

SURVEYOR'S REPORT

Route Survey of Pogues Run Greenway – Indianapolis, Indiana

General

This survey was prepared for the City of Indianapolis Department of Public Works to aid in the design of the Pogues Run Greenway. The proposed trail runs from the intersection of the Monon Trail and 10th Street, east along 10th Street, northeast along Brookside Avenue, easterly along Brookside Parkway North Drive, easterly and northeasterly through Spades and Brookside Parks, crossing Rural Street near its intersection with Brookside Parkway South Drive, north along Olney Street and finally east along 21st Street to the Pogues Run Art and Nature Park. The centerline of the streets the trail will follow and of many adjacent streets were established to determine the location of existing right-of-way lines along the trail route. Parcel lines and corners shown herein have been placed per observed physical evidence and/or record documents acquired from Marion County government agencies and are not to be construed as defining actual property lines and corners as in a retracement or original survey. Topographic information was gathered for use in the design of the proposed trail.

- All monument reference ties are shown on the Route Survey Plat.
- Should additional USPLSS corners be needed where none were found or perpetuated, they should be reestablished and tied into this survey.
- This project is located in Section 1, Township 15 North, Range 3 East; Section 6, Township 15 North, Range 4 East; Section 36, Township 16 North, Range 3 East; Sections 28, 29, 31, 32 and 33, Township 16 North Range 4 East in Center Township, Marion County, Indiana.

Horizontal Datum

The horizontal datum for this project is a local ground system based on the East Zone of the Indiana State Plane Coordinate System, NAD83(2011). Coordinates were established on primary Control Point Nos. 100–121 and section corners using a Topcon GNSS system and the InCORS Real-Time Network. Coordinates on secondary control points or monuments were established using total station or GPS locations. Coordinates were translated to the local system by establishing the ground coordinate for Control Point 109 as 20,000.00 North and 20,000.00 East. All other points were scaled from grid to ground about Control Point No. 109 using a combined (Grid to Ground) scale factor of 1.00004498. All coordinates and distances are ground values.

Vertical Datum

The vertical datum for this project is the North American Vertical Datum of 1988 (NAVD88). National Geodetic Survey (NGS) Station D 4 RESET 1978 was found in good condition at the intersection of 10th Street and Dorman Street. NGS Station E 4 was found in good condition at the CSX railroad overpass over Valley Avenue. A check between the two benchmarks via differential leveling yielded a difference of 0.01 foot from the difference calculated between the published elevations. All level circuits were performed to at least third order accuracy with an allowable error of $\pm 12\text{ mm } \sqrt{K}$, where K is the length of the circuit in kilometers. Temporary benchmarks were set along the route for easy retrieval during construction.

Alignments

The alignment of 10th Street was established by splitting the existing curbs east of Oriental Street and projecting the centerline west. Between I–65 and Oriental Street, the pavement of 10th Street is too irregular to establish a best–fit centerline.

The alignment of Brookside Avenue from 10th Street to Hamilton Avenue was established by splitting the existing curbs and information from multiple plats. The plats did not give curve data (e.g. radius, degree of curve, tangent lengths, etc.). The curve at 6+47.18 "BSA" was established by best fit to the existing pavement and choosing an even radius to the nearest 25 feet. Lot dimensions and right–of–way widths were used to determine the radius of the curves at 21+09.67 "BSA", 23+59.41 "BSA" and 32+31.37 "BSA".

The alignment of Brookside Parkway North Drive from Brookside Avenue to Tacoma Avenue was established by splitting the existing curbs. Brookside Parkway North Drive is not shown on any of the adjacent plats with the exception of the 400 feet before Tacoma Avenue. Land was purchased or condemned by the City of Indianapolis in 1916 and 1917 for a Parkway and Boulevard. Records for such purchases were researched and found as listed on the plat. Those lots where the specific record was not found are shown per City of Indianapolis DOT right–of–way maps provided by the Marion County Surveyor's Office (see more detailed discussion below). Curves along the centerline of Brookside Parkway North Drive were best fit to the existing pavement by choosing an even radius to the nearest 50 feet.

The alignment of Rural Street was established by splitting the existing curbs.

The alignment of Brookside Parkway South Drive was established by splitting the existing curbs.

The alignment of Olney Street from Brookside Parkway North Drive to 21st Street was established by splitting the existing curbs.

The alignment of 21st Street from just west of Olney Street to Sherman Avenue is established along the section line dividing Sections 29 and 32 and along the line dividing Sections 28 and 33 from Sherman Avenue east.

The centerline of other streets adjacent to the proposed trail were also established from curb splits, platted distances and information found on City of Indianapolis DOT right–of–way maps provided by the Marion County Surveyor's Office. This includes Massachusetts Avenue, 11th Street, 12th Street, Arsenal Avenue, Newman Street, Commerce Avenue, Nowland Avenue, Steele Street, Hamilton Avenue, Samoa Avenue, Jefferson Avenue, Coyer Avenue, Tacoma Avenue, 13th Street, Oxford Street, Brookside Parkway North Drive (between Losalle Street and Olney Street), and 20th Street.

Right–of–Way

Right–of–way along the trail route and adjacent streets is shown per recorded subdivision plats. There are areas that have been widened, vacated or new streets opened as listed on the plat. Some areas of note are listed below:

- Everything north of 10th Street and west of the CSX railroad overpass is believed to be public right–of–way for Lewis Street, Monon Trail and I–65/I–70. The right–of–way of CSX railroad at 10th Street is shown per Cleveland, Cincinnati, Chicago & St. Louis Railway Company, Indianapolis Division Main Line Right–of–way and Track Map, Sheet No. 5 VI.
- Brookside Avenue continued southwest to 10th Street per the plats of Schwitzer Cummins Co. Addition and John K. Smith Subdivision. Part of Brookside Avenue was vacated per Instrument No. 77001891. The City of Indianapolis Department of Transportation purchased Lots 6 – 9 of Smiths Subdivision (Instrument No. 73–26384). A portion of Lot 9 was conveyed to National Bank of Indianapolis in Instrument No. 201400042374. The right–of–way of Brookside Avenue is shown as 66 feet wide (to match the rest of Brookside Avenue), but the City of Indianapolis does own the portions of Lots 6 – 9 in Smiths Subdivision that lie outside of the right–of–way as shown.
- The right–of–way along the connecting road from Brookside Avenue to Massachusetts Avenue (northeast of Newman Street) is platted per the deeds for the adjoining parcels and agrees well with the location of the roadway, sidewalks and other improvements.
- Lot 52 in Milligan Park Addition (the area occupied by Pogues Run between Brookside Avenue and Nowland Avenue) is not shown as a parcel in the City GIS. The area is owned by the City of Indianapolis Parks Department per a Temporary Right–of–way Grant, Instrument No. 72–66146.
- Brookside Parkway North Drive from Brookside Avenue to Jefferson Avenue was opened by the City of Indianapolis Board of Park Commissioners in 1916 by Parkway Resolution No. 44, recorded in Town Lot Record 570, pages 329 – 331. A listing of full and partial lot takings was included in the resolution. Some of the actual deeds for the takings from specific lots were found and are listed on the plat. The rest of the takings are plotted per dimensions on City of Indianapolis DOT right–of–way maps provided by the Marion County Surveyor's Office and referenced to Parkway Resolution No. 44.
- Portions of Spades and Brookside Parks were originally platted. The lots in these areas are not shown. Some of the deeds for these areas were obtained with the help of Paul Smith at the City Real Estate Office. The deeds for these areas are not listed on the plat.
- The south right–of–way of Brookside Parkway South Drive is platted per the deeds for the adjoining parcels and agrees well with the location of the roadway, sidewalks and other improvements. City of Indianapolis DOT right–of–way maps show additional right–of–way in the southeast quadrant of the intersection of Brookside Parkway South Drive and Rural Street.
- Sherman Avenue was widened 30 feet to the east per Dec. Res. 17118
- 21st Street was widened per Dec. Res. No. 17955 recorded in Deed Record 2126 page 165. This included the land at the northwest corner 21st Street & Sherman Drive and both sides of 21st Street, east of Sherman Drive as shown on the plat.
- The rights–of–way of the railroads near the intersection of 21st Street and Sherman Drive are shown per a combination of deeds, City DOT right–of–way maps, and the Indianapolis Union Railway Company Belt Railroad Station Map – Lands Sheet No. SL 12 V2. All railroad property within the project limits, as shown on the plat was acquired by New York Central Lines, LLC by Instrument No. 1999–0151430.

USPLSS Corners

Five monuments were found and accepted as the location of USPLSS corners:

- (200) Quarter Corner common to Sections 32 & 33 T16N R4E
- Harrison Monument found per the Marion County Surveyor's Office records.
- (201) Corner common to Sections 28, 29, 32 & 33 T16N R4E
- Harrison Monument found per the Marion County Surveyor's Office records.
- (202) Corner common to Sections 20, 21, 28 & 29 T16N R4E
- Harrison Monument found per the Marion County Surveyor's Office records.
- (203) Quarter Corner common to Sections 28 & 33 T16N R4E
- Harrison Monument found per the Marion County Surveyor's Office records.
- (204) Quarter Corner common to Section 29 & 32 T16N R4E
- Harrison Monument found per the Marion County Surveyor's Office records.

The locations of these five monuments were accepted as the best evidence of the corners that they represent.

Uncertainties

The following opinions regarding the uncertainty in the location of the points found or set and the lines established by this survey are offered:

Relative Positional Accuracy

The relative positional accuracy of points found, set or calculated this survey due to random errors in measurement is ± 0.07 feet plus 50 parts per million which does not exceed ± 0.50 feet.

SURVEYOR'S REPORT CONTINUED

Route Survey of Pogues Run Greenway – Indianapolis, Indiana

Record Monuments

Other than the five USPLSS corners listed above, no record monuments were recovered this survey. No uncertainties do to record monuments are noted.

Occupation/Possession

Throughout most of the project area the curbs, sidewalks and other improvements generally agree with the location of right–of–way lines as shown this survey ± 1.0 foot. There are some areas where larger discrepancies exist as noted below:

- Landscaping and other improvements cover part of Lot 94 of Milligan's Brook Park Addition (east corner of Brookside Avenue and Brookside Parkway North Drive) and it appears to be occupied by the owner of Lot 93 (Parcel 64 on the plat). This lot was taken by the City for the opening of Brookside Parkway (T.L.R. 570, pages 329 – 331). The deed for Parcel 64 covers Lot 93 except that part conveyed to the City. There is no mention of Lot 94 in said deed.
- Occupation from the owner of Lot 102 of Milligan's Brook Park Addition (the corner of Brookside Parkway North Drive and Hamilton Avenue) extends to the sidewalk, but the right–of–way (as plotted from DOT right–of–way maps) is up to 9 feet away from the sidewalk.

PROJECT COORDINATE CHART

POINT No.	LOCAL NORTHING	LOCAL EASTING	SPC NORTHING	SPC EASTING	DESCRIPTION
100	18,165.6863	14,313.5255	1,651,353.9070	195,050.5100	REBAR SET W/ RED "VSEI" CAP (SURVEY CONTROL POINT)
101	18,157.3891	14,917.7723	1,651,355.6300	195,654.7280	REBAR SET W/ RED "VSEI" CAP (SURVEY CONTROL POINT)
102	18,853.9413	15,894.9410	1,652,052.1480	196,631.8490	REBAR SET W/ RED "VSEI" CAP (SURVEY CONTROL POINT)
103	19,407.5836	16,550.5798	1,652,605.7630	197,287.4560	REBAR SET W/ RED "VSEI" CAP (SURVEY CONTROL POINT)
104	19,667.4035	17,143.4150	1,652,865.5700	197,880.2620	REBAR SET W/ RED "VSEI" CAP (SURVEY CONTROL POINT)
105	20,086.4798	17,631.3301	1,653,294.6250	198,368.1530	REBAR SET W/ RED "VSEI" CAP (SURVEY CONTROL POINT)
106	19,831.2476	18,293.6158	1,653,029.4060	199,030.4080	REBAR SET W/ RED "VSEI" CAP (SURVEY CONTROL POINT)
107	20,308.7935	18,916.0687	1,653,506.9280	199,652.8280	REBAR SET W/ RED "VSEI" CAP (SURVEY CONTROL POINT)
108	20,454.9208	19,365.5862	1,653,653.0480	200,102.3230	REBAR SET W/ RED "VSEI" CAP (SURVEY CONTROL POINT)
109	20,000.0000	20,000.0000	1,653,198.1500	200,736.7050	REBAR SET W/ RED "VSEI" CAP (SURVEY CONTROL POINT)
110	19,737.7847	20,878.4478	1,652,935.9480	201,615.1080	REBAR SET W/ RED "VSEI" CAP (SURVEY CONTROL POINT)
111	20,220.3921	21,215.1884	1,653,418.5310	201,951.8320	REBAR SET W/ RED "VSEI" CAP (SURVEY CONTROL POINT)
112	20,650.3602	21,531.0731	1,653,848.4770	202,267.7000	REBAR SET W/ RED "VSEI" CAP (SURVEY CONTROL POINT)
113	21,000.1809	22,046.9142	1,654,198.2800	202,783.5150	REBAR SET W/ RED "VSEI" CAP (SURVEY CONTROL POINT)
114	21,462.3956	22,282.9815	1,654,560.4710	203,019.5700	MAG NAIL SET
115	22,053.8198	22,381.1155	1,655,251.8650	203,117.6990	REBAR SET W/ RED "VSEI" CAP (SURVEY CONTROL POINT)
116	21,934.6107	22,887.5383	1,655,132.5620	203,624.0660	REBAR SET W/ RED "VSEI" CAP (SURVEY CONTROL POINT)
117	21,756.4188	23,561.4082	1,654,963.4780	204,297.9290	REBAR SET W/ RED "VSEI" CAP (SURVEY CONTROL POINT)
118	22,754.3480	23,610.2838	1,655,952.3540	204,346.8000	REBAR SET W/ RED "VSEI" CAP (SURVEY CONTROL POINT)
119	23,542.0434	23,560.4254	1,656,740.0080	204,266.9440	REBAR SET W/ RED "VSEI" CAP (SURVEY CONTROL POINT)
120	23,536.5913	24,545.0854	1,656,734.5550	205,281.5510	REBAR SET W/ RED "VSEI" CAP (SURVEY CONTROL POINT)
121	23,551.0438	25,229.8582	1,656,749.0070	205,966.0880	REBAR SET W/ RED "VSEI" CAP (SURVEY CONTROL POINT)
200	20,837.4880	24,926.1987	1,654,035.5940	205,662.6450	HARRISON MON. FOUND
201	23,511.6169	24,926.2933	1,656,709.5820	205,662.7390	HARRISON MON. FOUND
202	28,865.2790	24,891.3537	1,662,062.9620	205,627.8010	HARRISON MON. FOUND
203	23,539.4263	27,600.3524	1,656,737.3880	208,336.8530	HARRISON MON. FOUND
204	23,521.7762	22,247.8559	1,656,719.7430	202,984.4440	HARRISON MON. FOUND
600	18,164.6464	14,225.8475	1,651,362.8870	194,962.8360	REBAR SET W/ ORANGE "VSEI 0053" CAP
601	18,163.9712	15,115.2151	1,651,362.2120	195,852.1610	MAG NAIL SET

SPC = STATE PLANE COORDINATES - INDIANA EAST ZONE, NAD83(2011)

DIRECTORY: F:\2013\13-3072 Pogues Run Greenway\SURVEY\URAM\US\USPSP
DISKFILE: 01 - USPLSS - 13-3072 Pogues Run Greenway - SN 1549
DATE: 8/27/2014 10:45:00

SURVEY STARTED	
12/31/2013	
SURVEY COMPLETED	
05/02/2014	
ROUTE PLAT SHEETS	
15	of 15



VS ENGINEERING, INC.
4275 N. HIGH SCHOOL RD. INDIANAPOLIS, INDIANA 46254
TEL. (317) 293–3542 FAX: (317) 293–4737

FIELD SURVEYOR STATEMENT

THIS SURVEY, TO THE BEST OF MY KNOWLEDGE AND BELIEF, IS EXECUTED ACCORDING TO THE PROVISIONS OF 865 I.A.C. 1–12–20 THROUGH 1–12–26 REGARDING ROUTE SURVEYS, EXCEPT THAT ANY DATA SHOWN REGARDING THE LOCATION OR DESCRIPTION OF THE EXISTING PARCELS IS NOT A PART OF THIS SURVEY.



RECOMMENDED FOR APPROVAL



[Signature]
REGISTERED LAND SURVEYOR, FIELD


DRAWN: JAG

CHECKED: MRH


CITY OF INDIANAPOLIS
DEPARTMENT OF PUBLIC WORKS
LOCATION CONTROL ROUTE SURVEY
SURVEYOR'S REP. & COORD. TABLE

HORIZONTAL SCALE	DESIGNATION
N/A	
VERTICAL SCALE	
N/A	
SURVEY BOOK	SHEETS
	7 of 47
CONTRACT	PROJECT
	PA-25-001

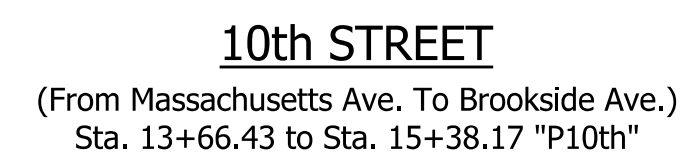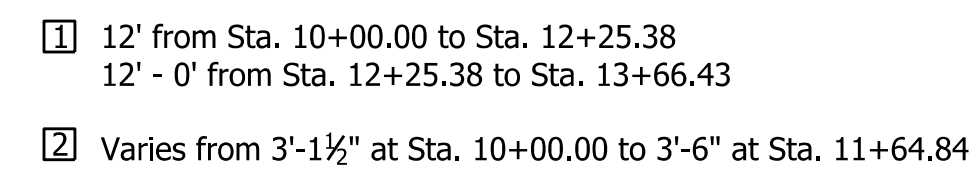

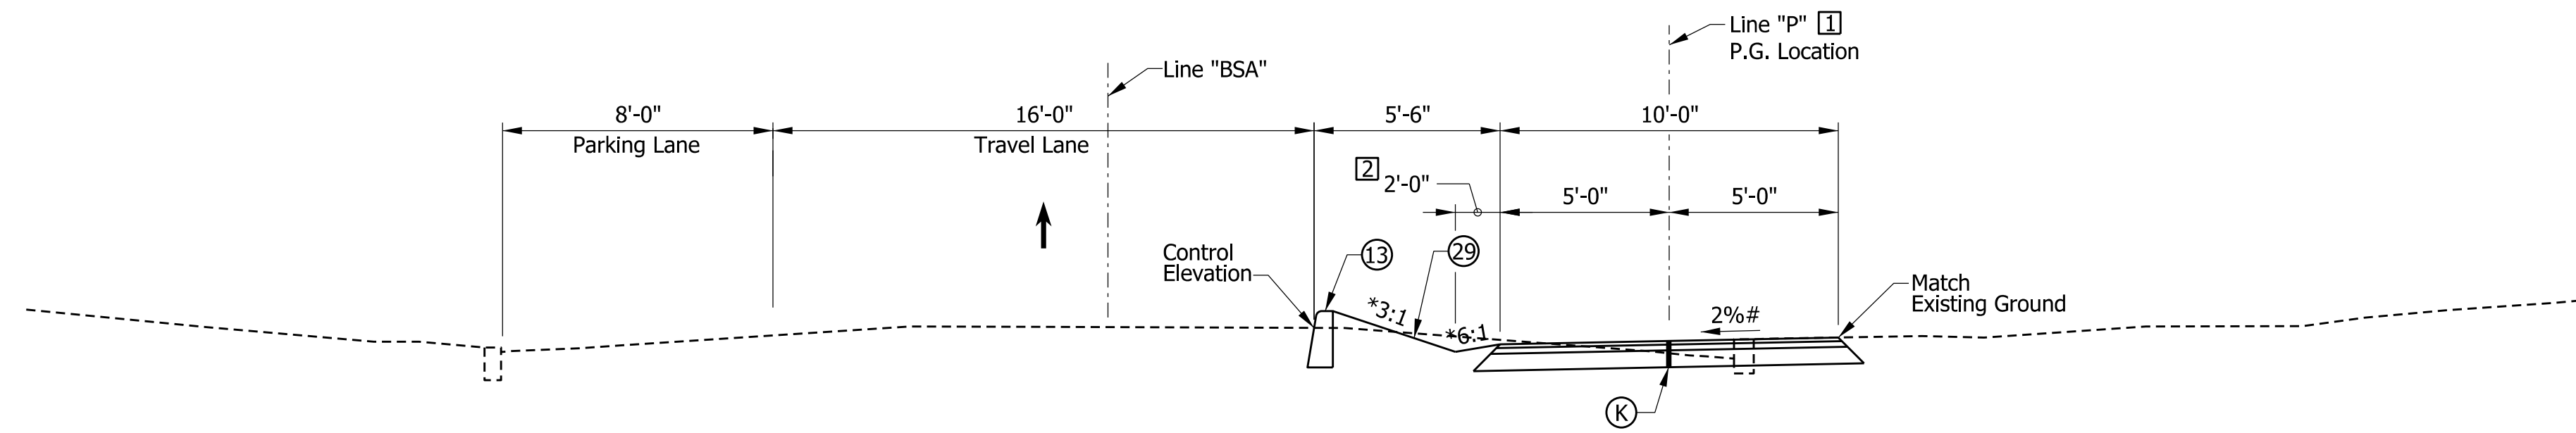

BROOKSIDE AVENUE
(From 10th St. to 12th St.)
Sta. 20+13.27 to Sta. 29+59.97 "P"

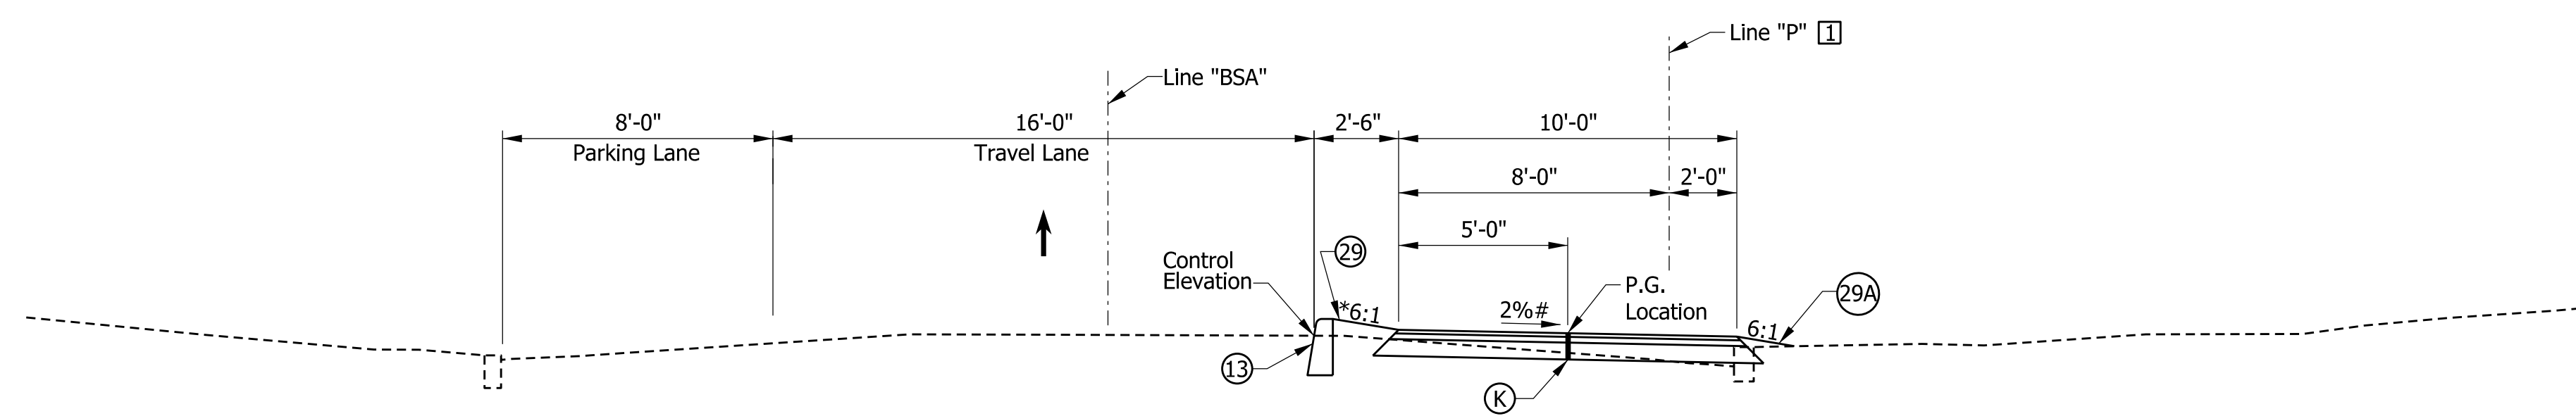

BROOKSIDE AVENUE
(From 12th St. to Arsenal Ave.)
Sta. 30+57.27 to Sta. 33+81.96 "P"


1 of Trail
P.G. Elevation Based
on Control Elevation

2 Varies From 2'-0" at Sta. 22+00.00 to 1'-0" at Sta. 23+50.00 "P"
1'-0" From Sta. 23+50.00 to Sta. 29+59.97 "P"

* Unless Noted Otherwise on Cross Sections

See Slope Transition Table (Next Sheet) and Cross Sections

- (K) 140 Lb/Yd HMA Surface Type A on 220lb/yd HMA Intermediate, Type A 6" of Compacted Aggregate No. 53. Base
- (13) Concrete Curb, 6" (Unless Specified Otherwise)
- (C) Sidewalk, Concrete, 4"
- (29) Seed Mix, Type "U"
- (29A) Mulch

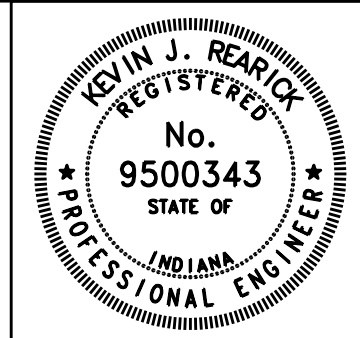


RECOMMENDED FOR APPROVAL		4-16-2015 DATE
DESIGNED: VA	DRAWN: JSS	
CHECKED: ACD	CHECKED: VA	

CITY OF INDIANAPOLIS
DEPARTMENT OF PUBLIC WORKS


TYPICAL SECTIONS

HORIZONTAL SCALE	BRIDGE FILE
1" = 4'-0"	
VERTICAL SCALE	DESIGNATION
SURVEY BOOK	SHEETS
	9 of 47
CONTRACT	PROJECT
	PA-25-001

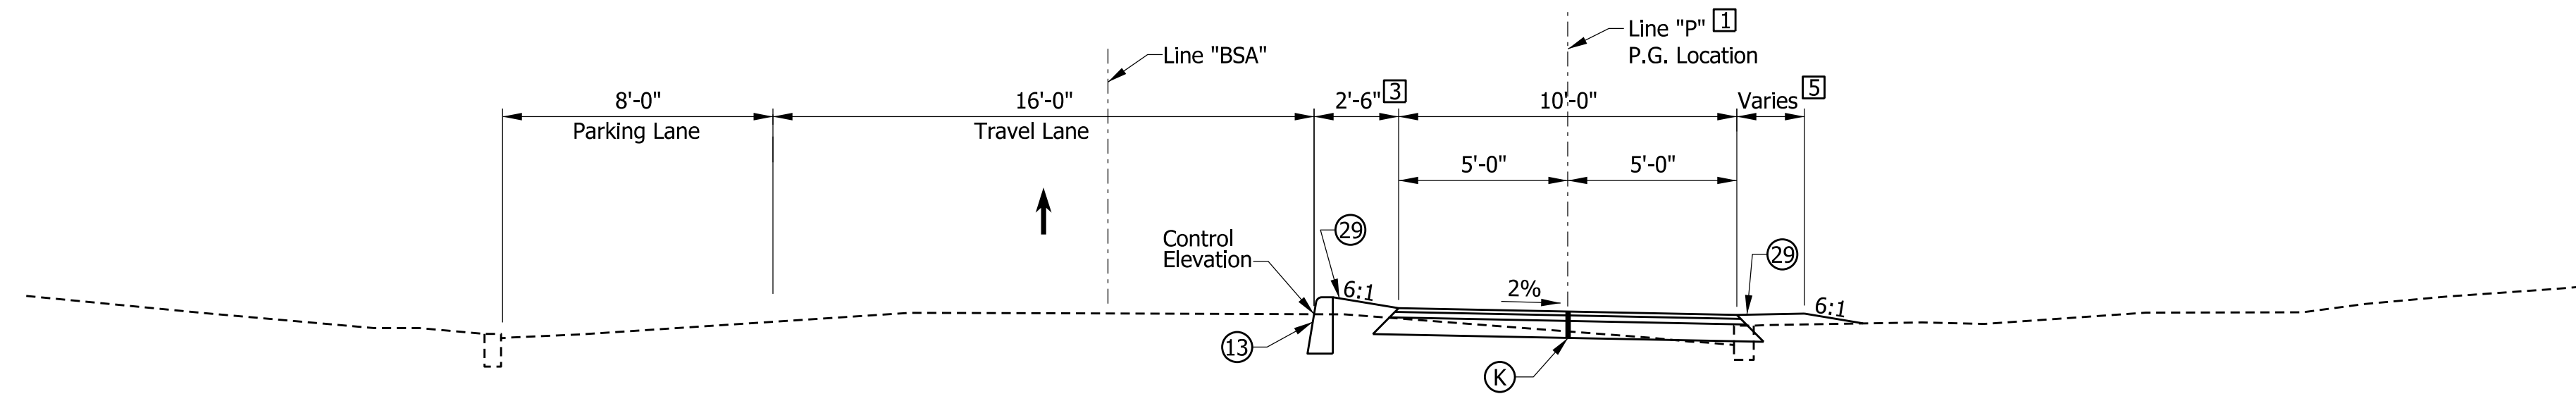

BROOKSIDE AVENUE
(From Arsenal Ave. to Brookside Ave.)
Sta. 34+40.26 to Sta. 38+00.00 "P"


- [3] 2'-6" from Sta. 34+40.26 to Sta. 37+51.94
Varies from 2'-6" at Sta. 37+51.94 to 4'-4" at Sta. 38+00.00
- [5] 2'-0" from Sta. 32+50.00 to Sta. 34+00.00

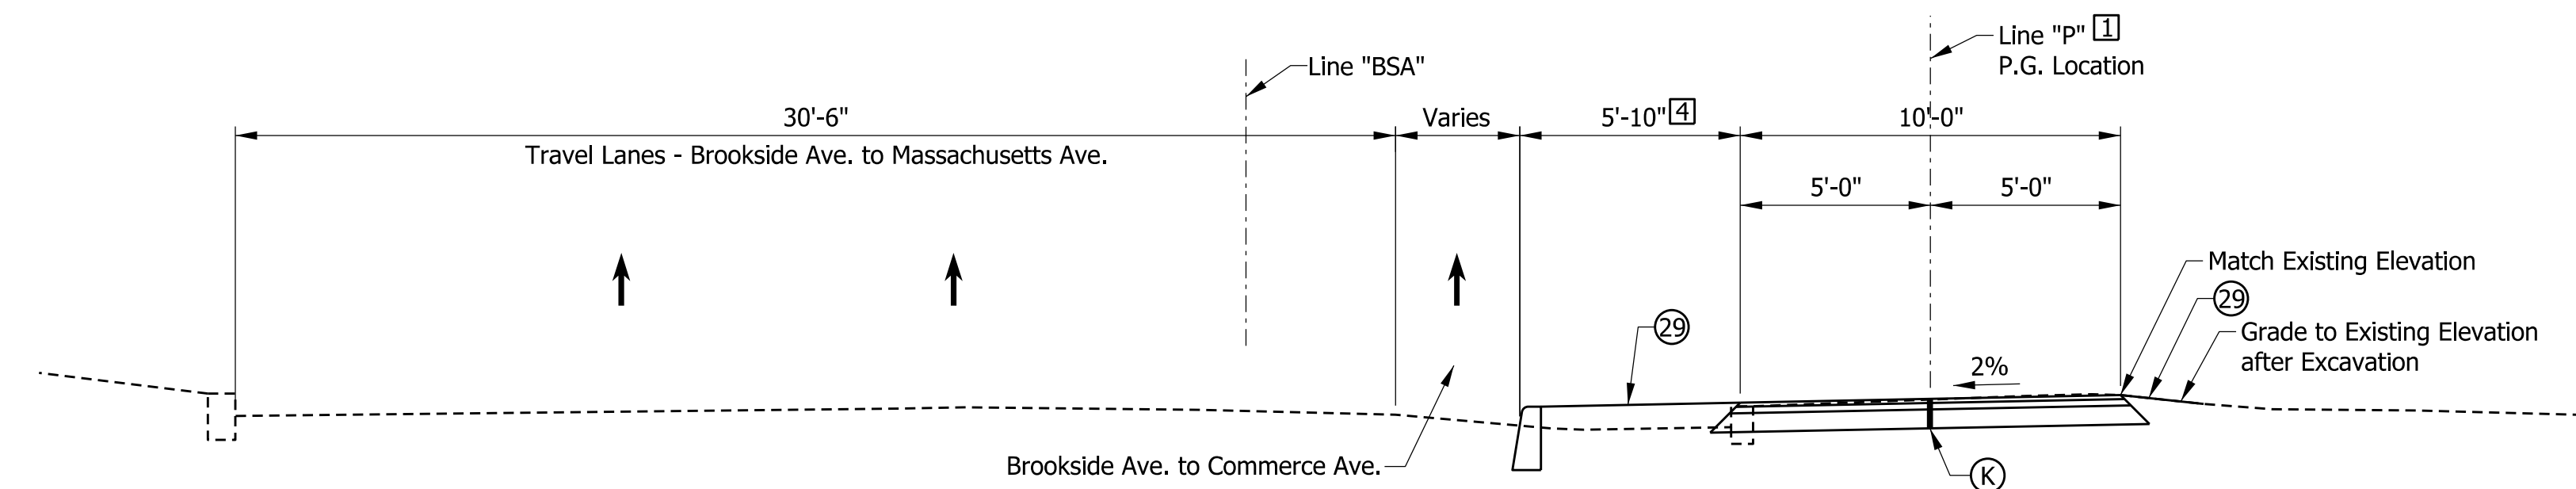

BROOKSIDE AVENUE
(From Arsenal Ave. to Brookside Ave.)
Sta. 38+00.00 to Sta. 39+31.63 "P"

- [4] Varies from 4'-4" at Sta. 38+00.00 to 5'-10" at 38+40.00
Varies from 5'-10" at 38+40.00 to 4'-11" at Sta. 39+31.63

SLOPE TRANSITION TABLE			
FROM STA.	SLOPE	TO STA.	SLOPE
LINE "P"		LINE "P"	
21+50	2% Lt.	22+00	0.50% Lt.
30+50	2% Lt.	31+00	2% Rt.
37+00	2% Rt.	37+50	2% Lt.
38+50	2% Lt.	39+50	1% Lt.
40+00	1% Lt.	41+00	1% Rt.
41+00	1% Rt.	41+50	2% Rt.
43+50	2% Rt.	44+00	2% Lt.

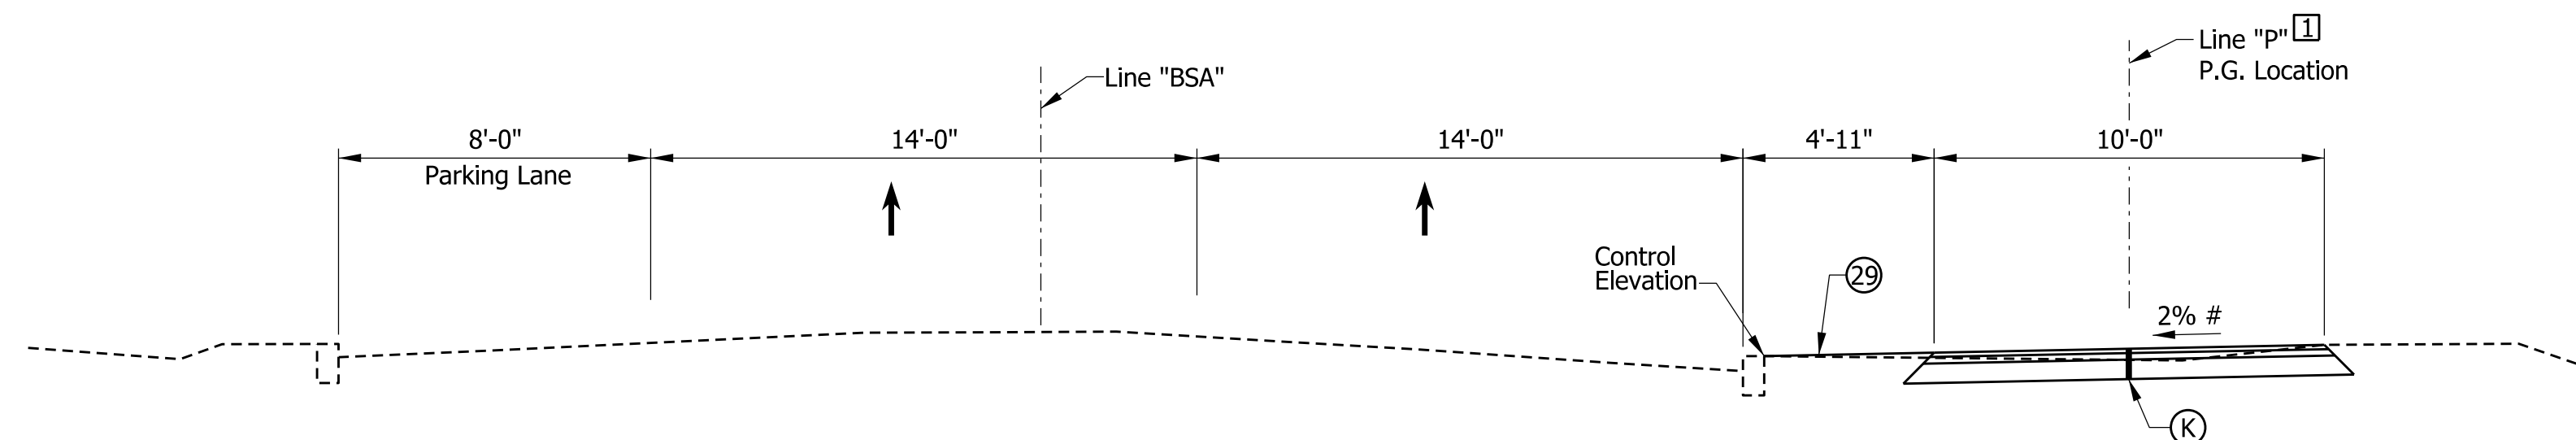


BROOKSIDE AVENUE
(From Brookside Ave. to Commerce Ave.)
Sta. 39+31.63 to Sta. 44+12.52 "P"

[1] ϕ of Trail
P.G. Elevation Based
on Control Elevation

* Unless Noted Otherwise on Cross Sections
See Slope Transition Table & Cross Sections

- (K) 140 Lb/Yd HMA Surface Type A on 220lb/yd HMA Intermediate, Type A 6" of Compacted Aggregate No. 53. Base
- (13) Concrete Curb, 6" (Unless Specified Otherwise)
- (29) Seed Mix, Type "U"
- (29A) Mulch
- (C) Sidewalk, Concrete, 4"

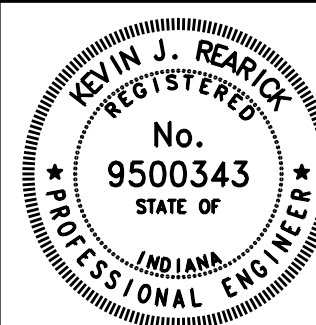


RECOMMENDED FOR APPROVAL		4-16-2015 DATE
DESIGNED: VA	DRAWN: JSS	
CHECKED: ACD	CHECKED: VA	


CITY OF INDIANAPOLIS
DEPARTMENT OF PUBLIC WORKS

TYPICAL SECTIONS

HORIZONTAL SCALE	BRIDGE FILE
1" = 4'-0"	
VERTICAL SCALE	DESIGNATION
SURVEY BOOK	SHEETS
	10 of 47
CONTRACT	PROJECT
	PA-25-001

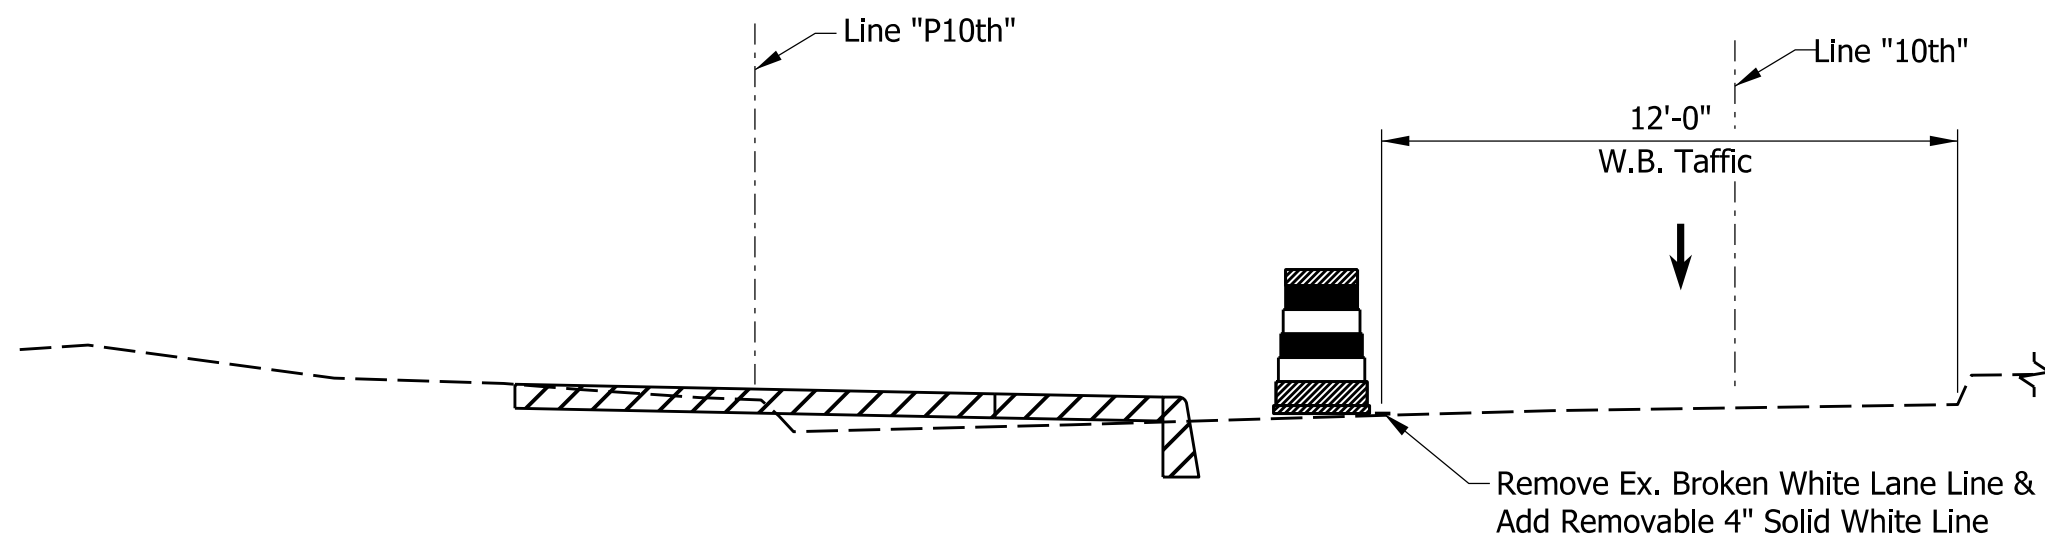

10th STREET
PHASE 1

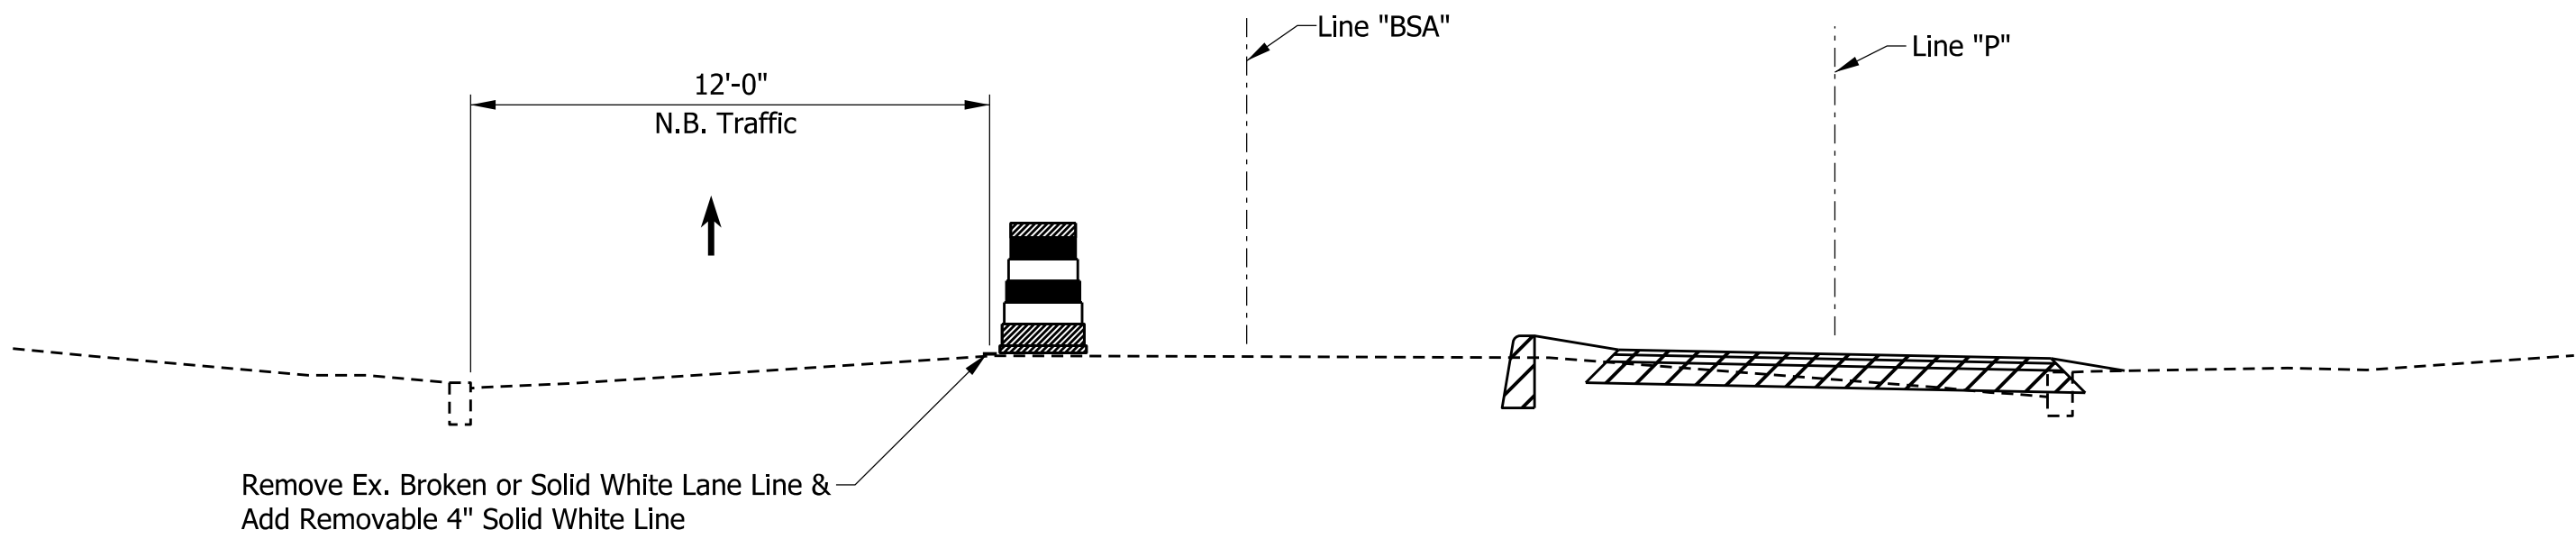

BROOKSIDE AVENUE
PHASE 1

SEQUENCE OF OPERATION



PHASE 1

1. Remove Existing Pavement Markings and add Snowplowable Raised Pavement Markers. Install Removable Temporary Pavement Markings.
2. Construct Proposed Curb & Trail while maintaining one lane of traffic on W.B. 10th St. & on N.B. Brookside Ave.

PHASE 1A

1. Install Removable Temporary Pavement Markings.
2. Construct the Trail and Curb Ramp on the Northwest Quadrant of 10th St. & Brookside Ave.
3. Remove Temporary Pavement Markings.
4. Install Permanent Pavement Markings.

MAINTENANCE OF TRAFFIC QUANTITIES				
Pay Item Description	Unit	Phase		TOTAL
		1	1A	
MAINTAINING TRAFFIC	LS	1	1	1
CONSTRUCTION SIGN, A	EACH	23	3	23
CONSTRUCTION SIGN, B	EACH	15	2	15
FLASHING ARROW SIGN	DAYS	60	0	60
LINE, REMOVE	LFT	2430		2430
TEMPORARY PAVEMENT MARKING, 4 IN.	LFT	2430	70	2500

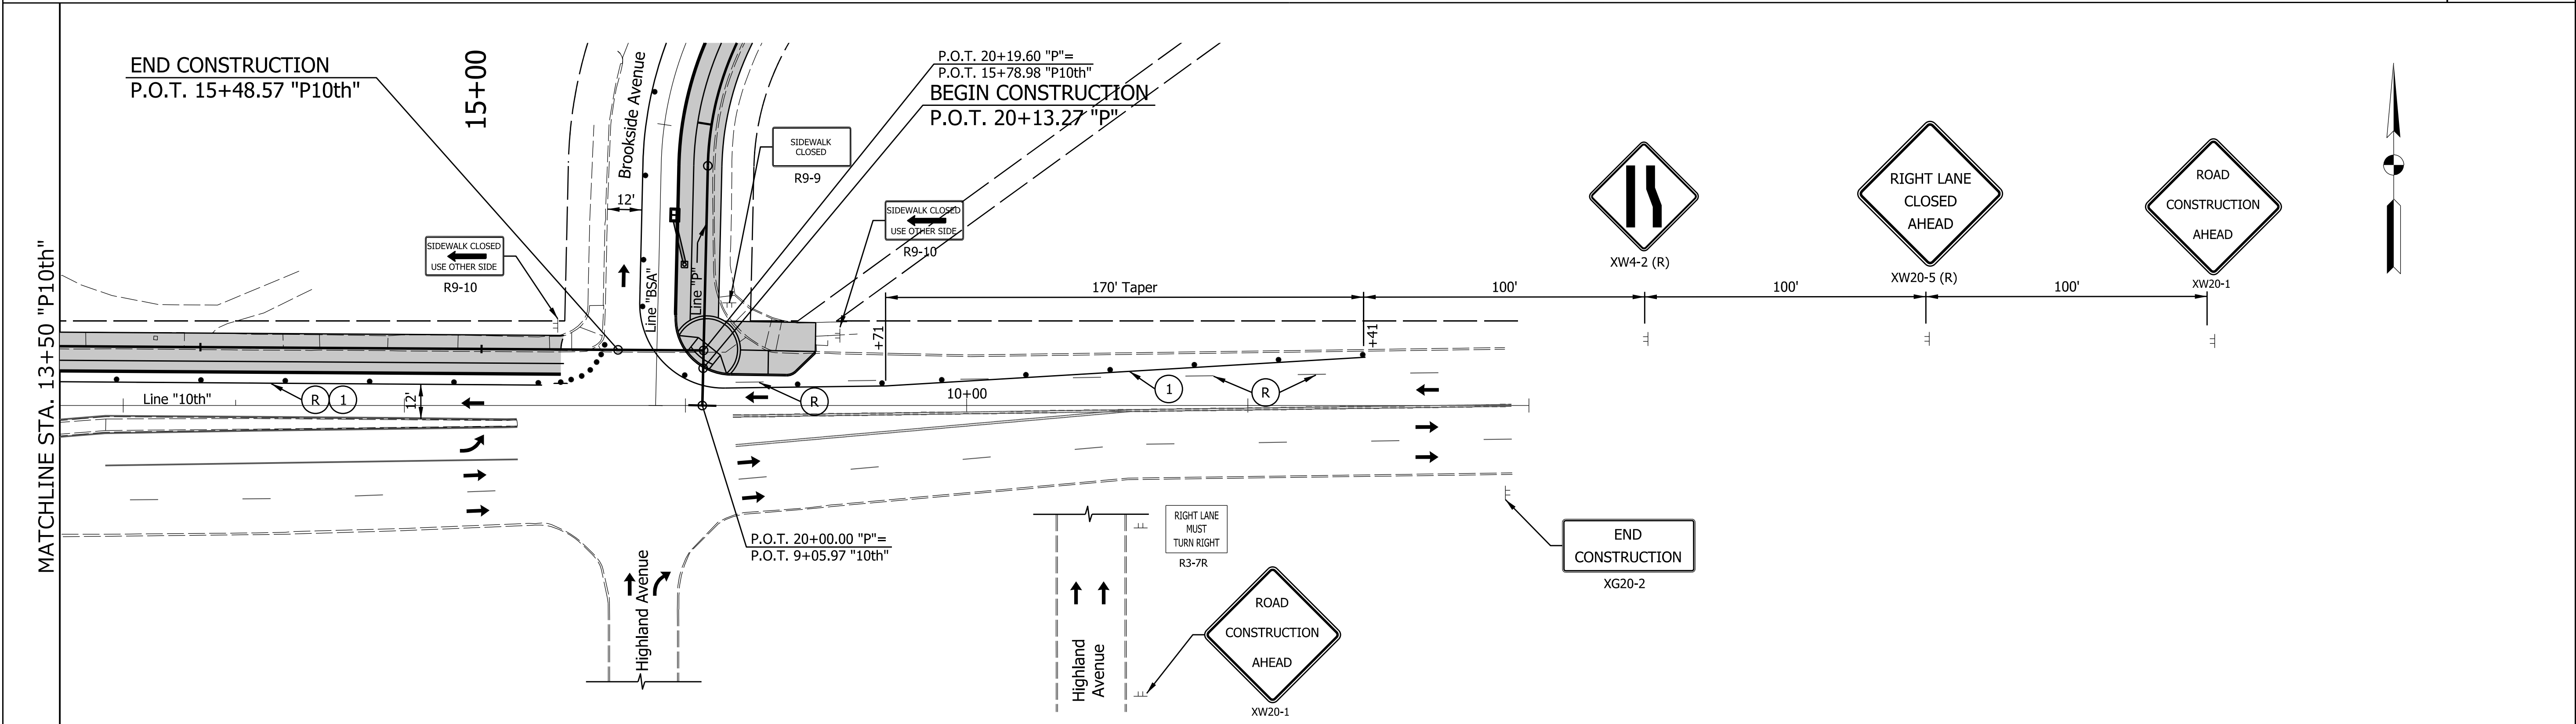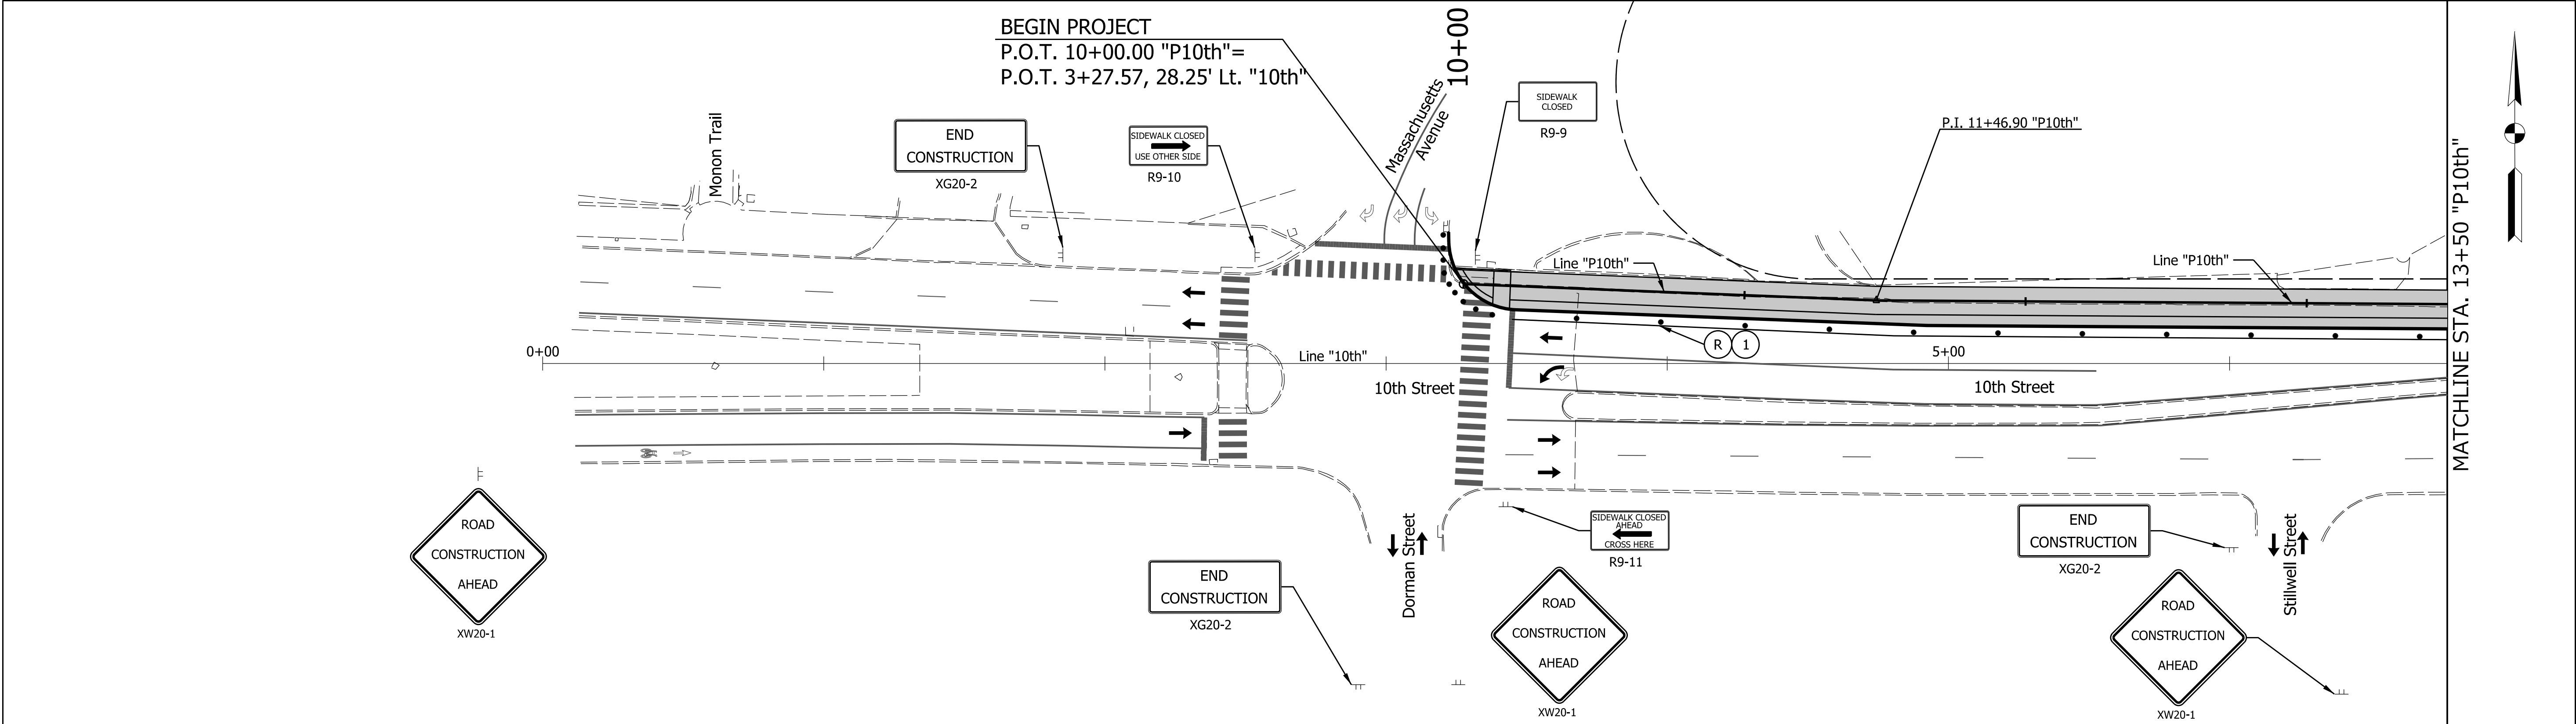

LEGEND

① Temp. Pavm't Marking, Removable, Solid, White, 4"

② Existing Pavement Marking or Temporary Pavement Marking from Previous Phase

③ Existing Pavement Marking or Temporary Pavement Marking to be Removed

← Direction of Traffic

• Standard Drum

■ Proposed Construction

RECOMMENDED FOR APPROVAL: *[Signature]* DESIGN ENGINEER 4-16-2015 DATE


DESIGNED: VA DRAWN: JSS

CHECKED: ACD CHECKED: VA

CITY OF INDIANAPOLIS
DEPARTMENT OF PUBLIC WORKS

MAINTENANCE OF TRAFFIC
PHASE 1

HORIZONTAL SCALE	BRIDGE FILE
1" = 30'	DESIGNATION
VERTICAL SCALE	
SURVEY BOOK	SHEETS
CONTRACT	12 of 47
	PROJECT
	PA-25-001

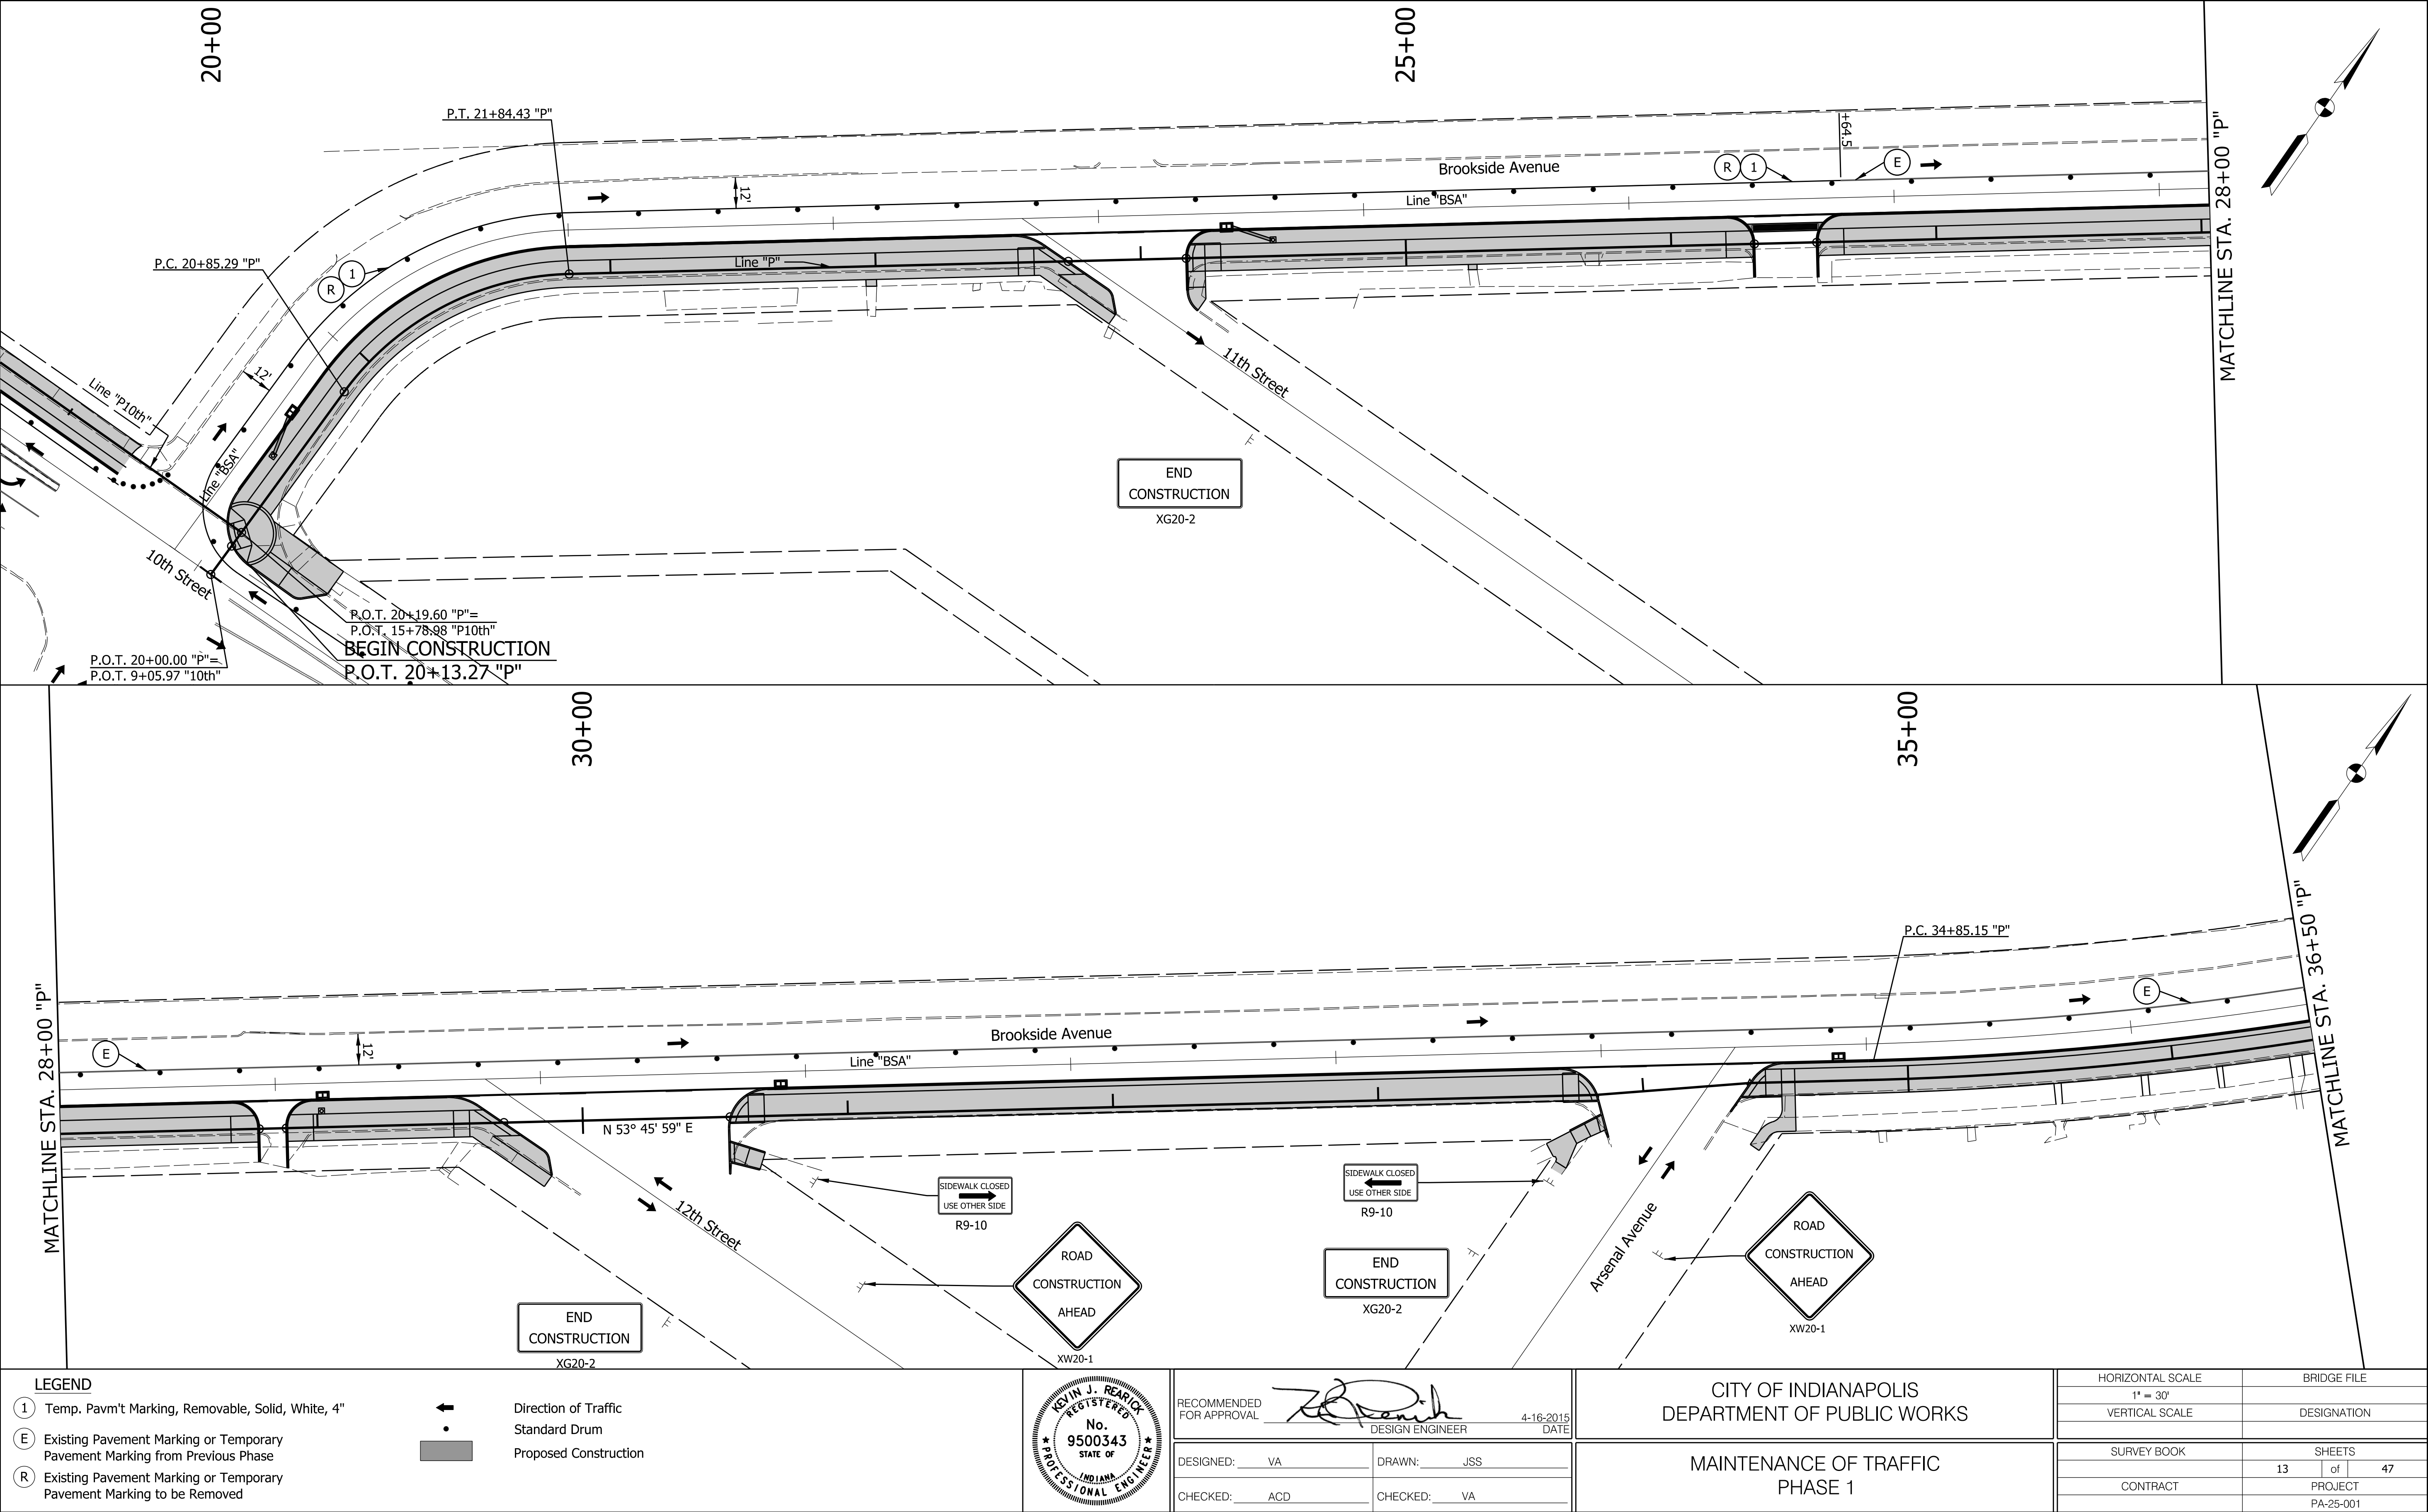

LEGEND

①

Temp. Pavm't Marking, Removable, Solid, White, 4"

Ⓔ

Existing Pavement Marking or Temporary Pavement Marking from Previous Phase

Ⓓ

Existing Pavement Marking or Temporary Pavement Marking to be Removed

→

Direction of Traffic

•

Standard Drum

■

Proposed Construction

KEVIN J. REAGAN

REGISTERED

No. 9500343

STATE OF INDIANA

PROFESSIONAL ENGINEER

RECOMMENDED FOR APPROVAL

DESIGN ENGINEER

4-16-2015

DATE

DESIGNED: VA

DRAWN: JSS

CHECKED: ACD

CHECKED: VA


CITY OF INDIANAPOLIS

DEPARTMENT OF PUBLIC WORKS

MAINTENANCE OF TRAFFIC

PHASE 1

HORIZONTAL SCALE	BRIDGE FILE
1" = 30'	
VERTICAL SCALE	DESIGNATION
SURVEY BOOK	SHEETS
	13 of 47
CONTRACT	PROJECT
	PA-25-001

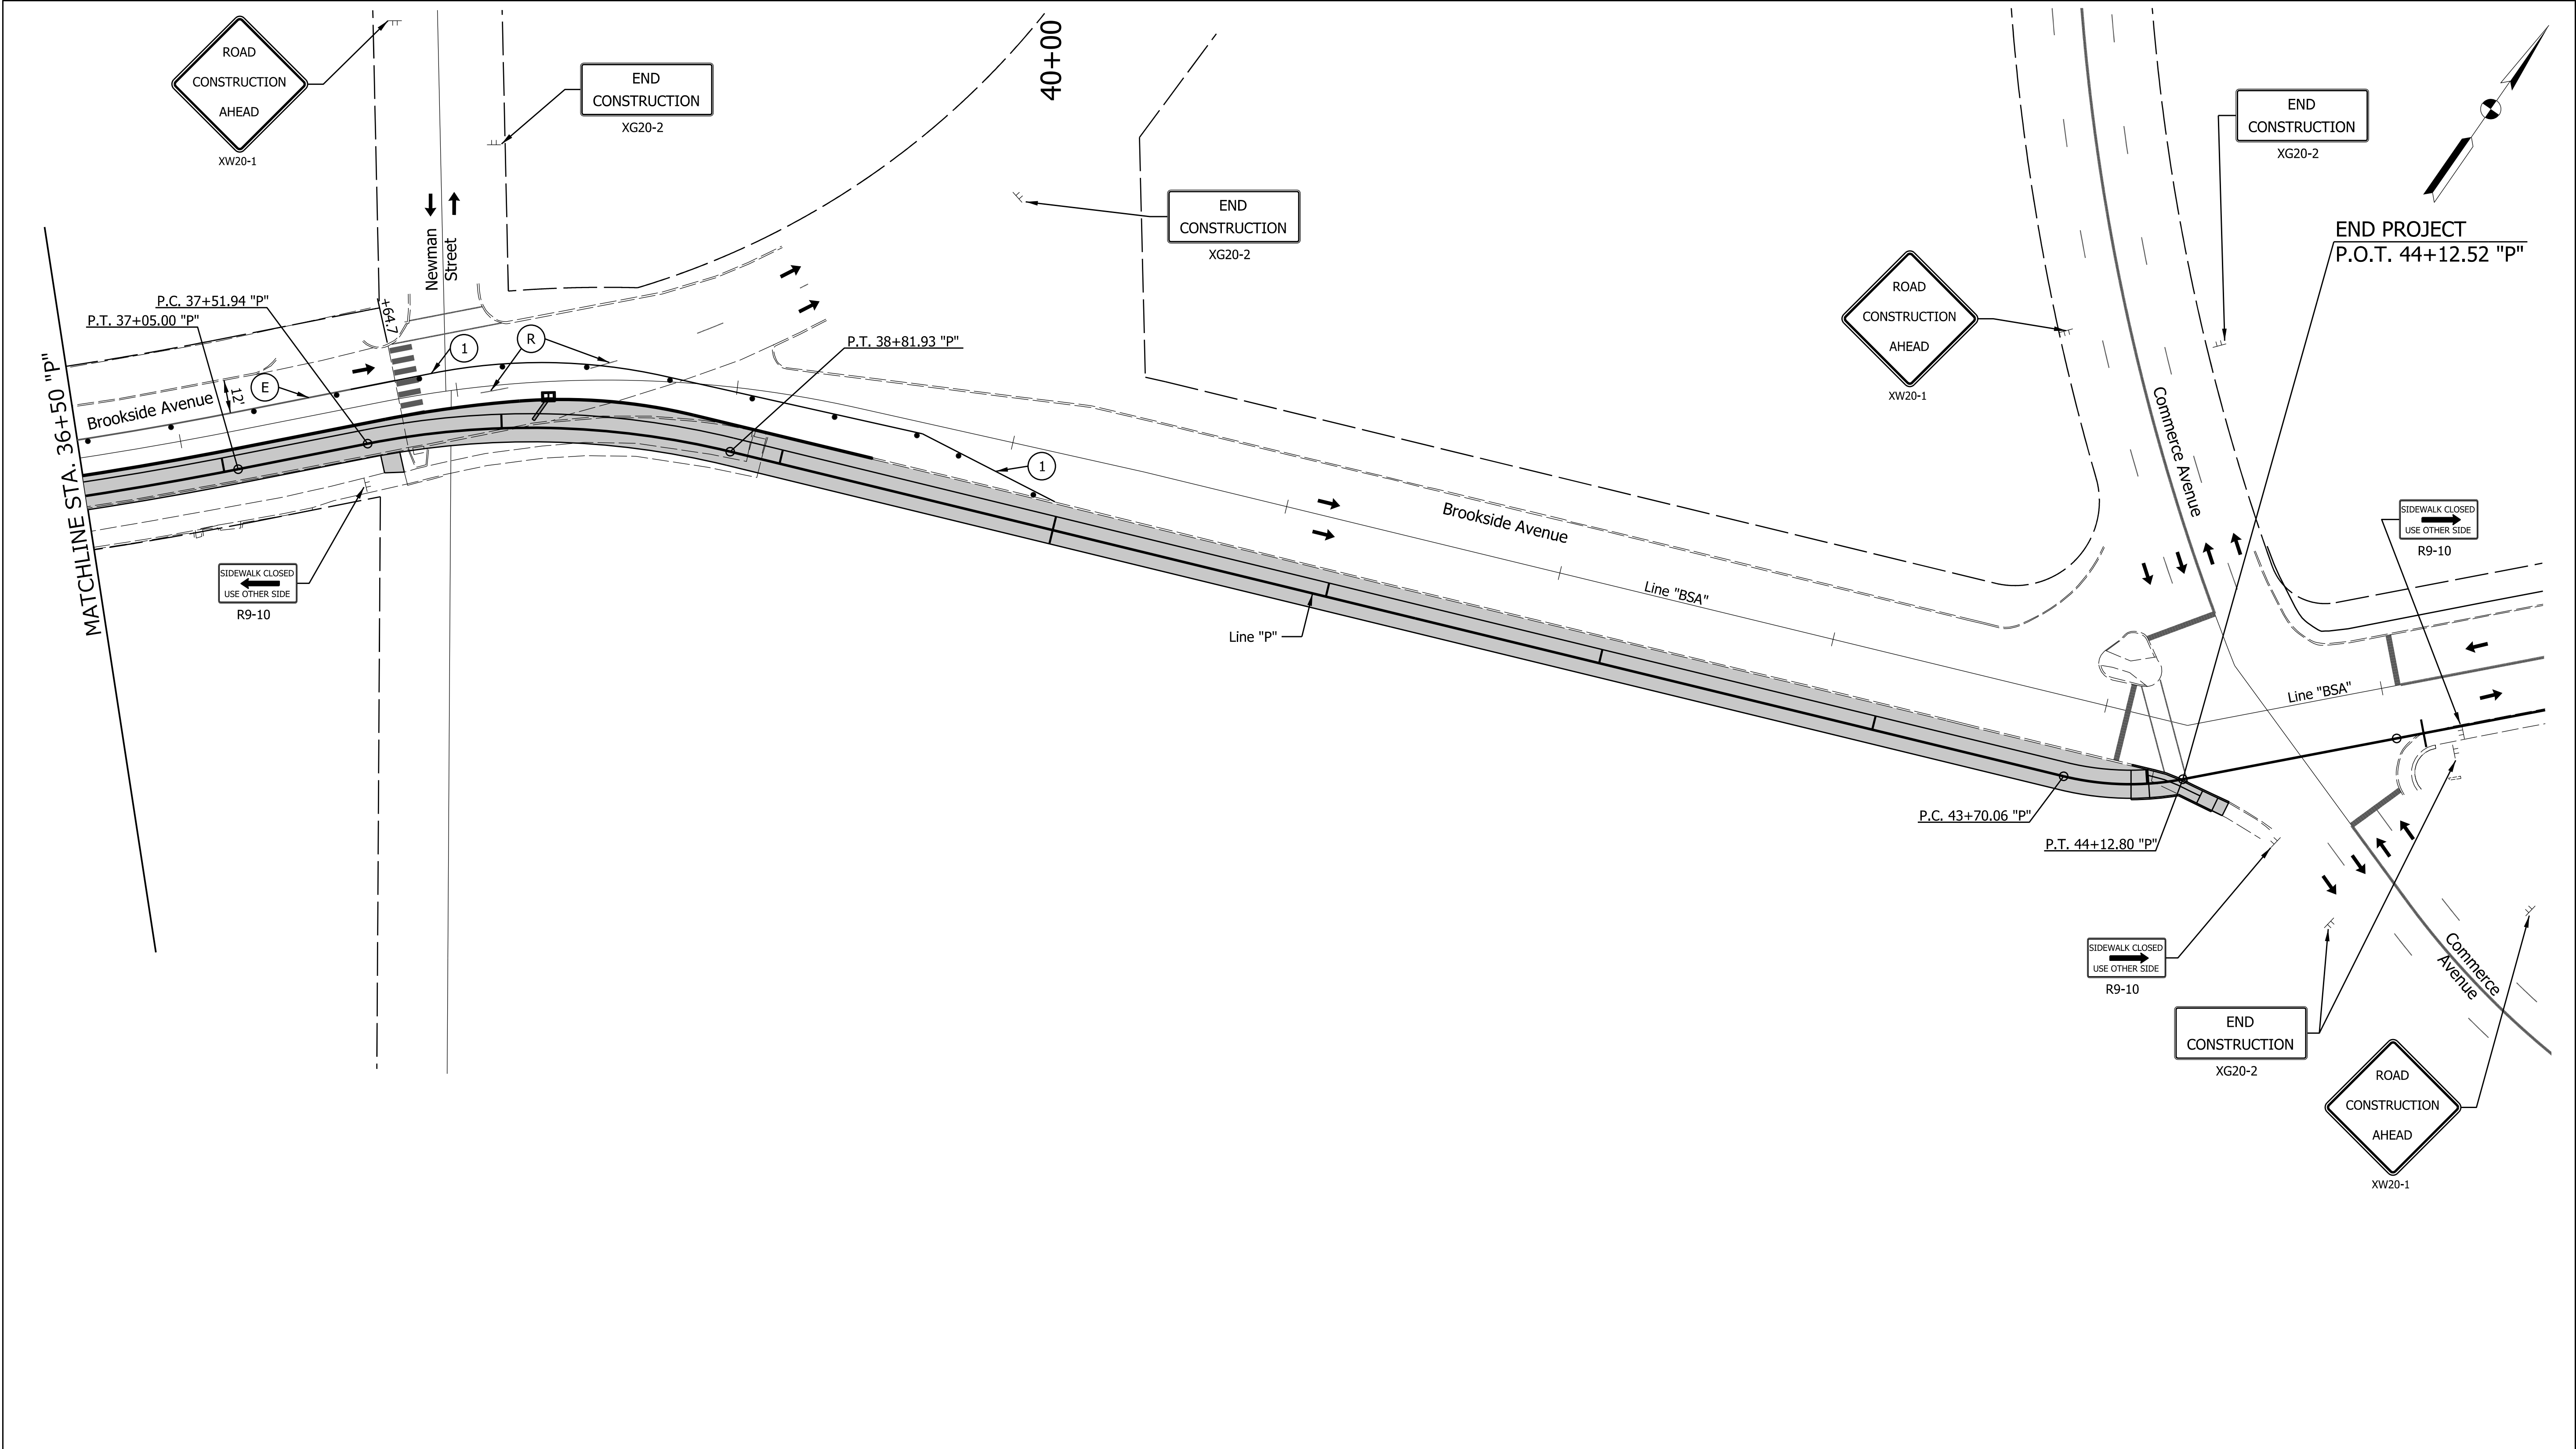

LEGEND

①

Temp. Pavm't Marking, Removable, Solid, White, 4"

➡

Direction of Traffic

⬢

Standard Drum

⬢

Proposed Construction

ⓔ


Existing Pavement Marking or Temporary Pavement Marking from Previous Phase

Ⓡ

Existing Pavement Marking or Temporary Pavement Marking to be Removed

KEVIN J. REAGAN
REGISTERED
No. 9500343
STATE OF INDIANA
PROFESSIONAL ENGINEER

RECOMMENDED FOR APPROVAL

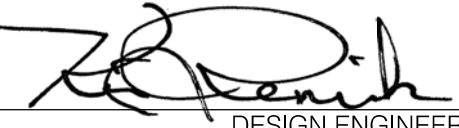

DESIGN ENGINEER

4-16-2015
DATE

DESIGNED: VA

DRAWN: JSS

CHECKED: ACD

CHECKED: VA

CITY OF INDIANAPOLIS
DEPARTMENT OF PUBLIC WORKS

MAINTENANCE OF TRAFFIC
PHASE 1

HORIZONTAL SCALE

1" = 30'

VERTICAL SCALE

BRIDGE FILE

DESIGNATION

SURVEY BOOK

CONTRACT



SHEETS

14 of 47

PROJECT


PA-25-001


V:\Projects\IIN62\Planning and Urban Design\Projects\27813 Pogues Run Greenway\30 Sheet\Drawings\10 BaseSets\Sht MOT_30_03.dgn

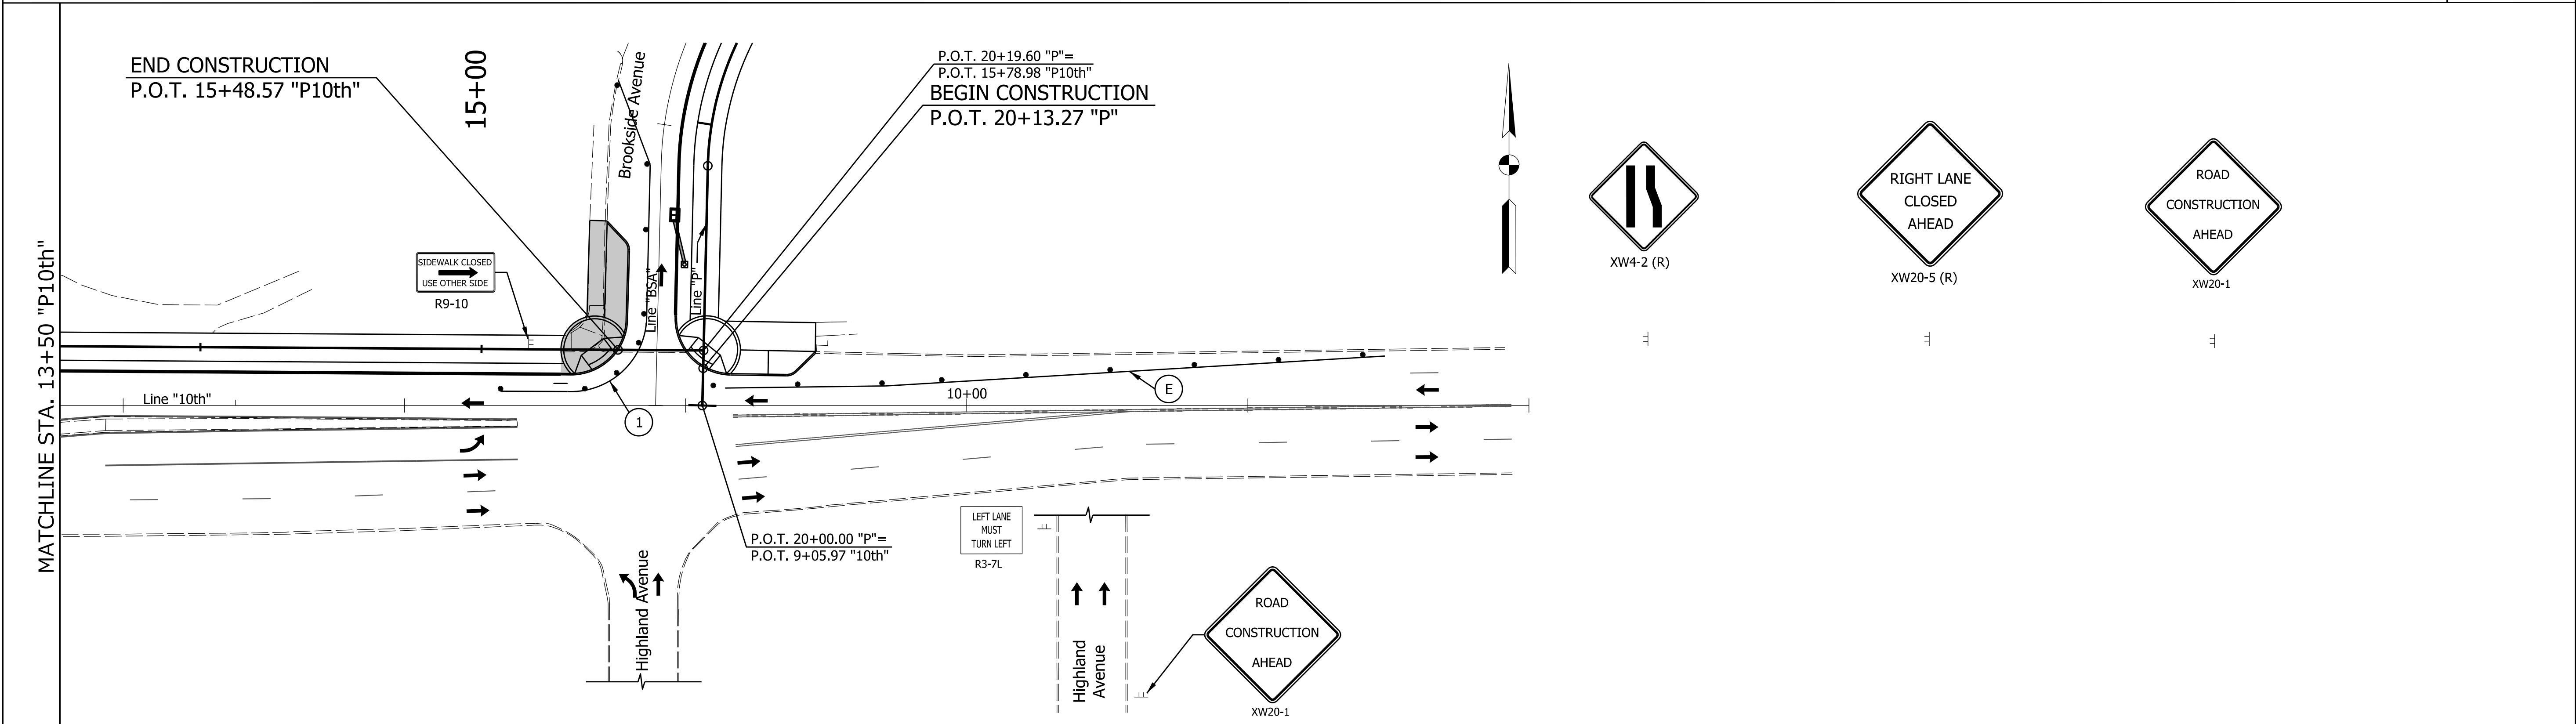
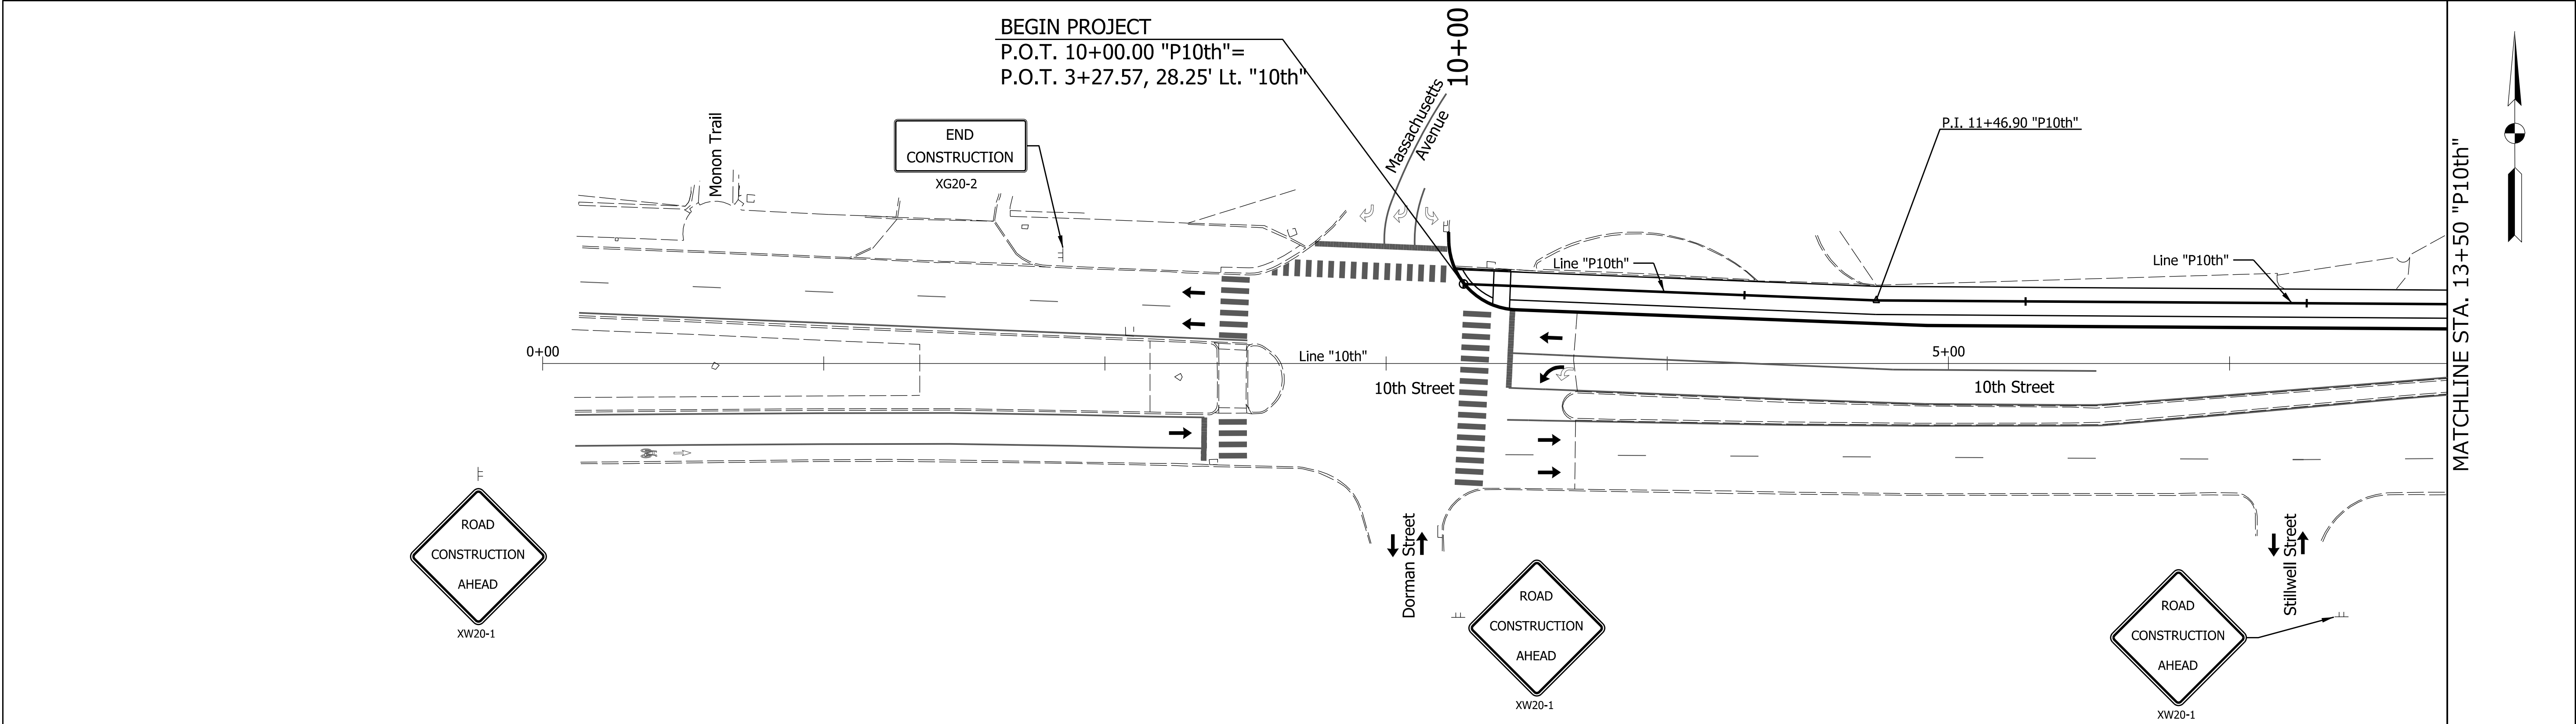


LEGEND			RECOMMENDED FOR APPROVAL  4-16-2015 DESIGN ENGINEER DATE		CITY OF INDIANAPOLIS DEPARTMENT OF PUBLIC WORKS		HORIZONTAL SCALE 1" = 30'		BRIDGE FILE	
① Temp. Pavm't Marking, Removable, Solid, White, 4"	 Direction of Traffic  Standard Drum  Proposed Construction		DESIGNED: <u>VA</u> DRAWN: <u>JSS</u>		MAINTENANCE OF TRAFFIC PHASE 1A		VERTICAL SCALE		DESIGNATION	
② Existing Pavement Marking or Temporary Pavement Marking from Previous Phase			CHECKED: <u>ACD</u> CHECKED: <u>VA</u>				SURVEY BOOK		SHEETS 15 of 47	
③ Existing Pavement Marking or Temporary Pavement Marking to be Removed						CONTRACT		PROJECT PA-25-001		



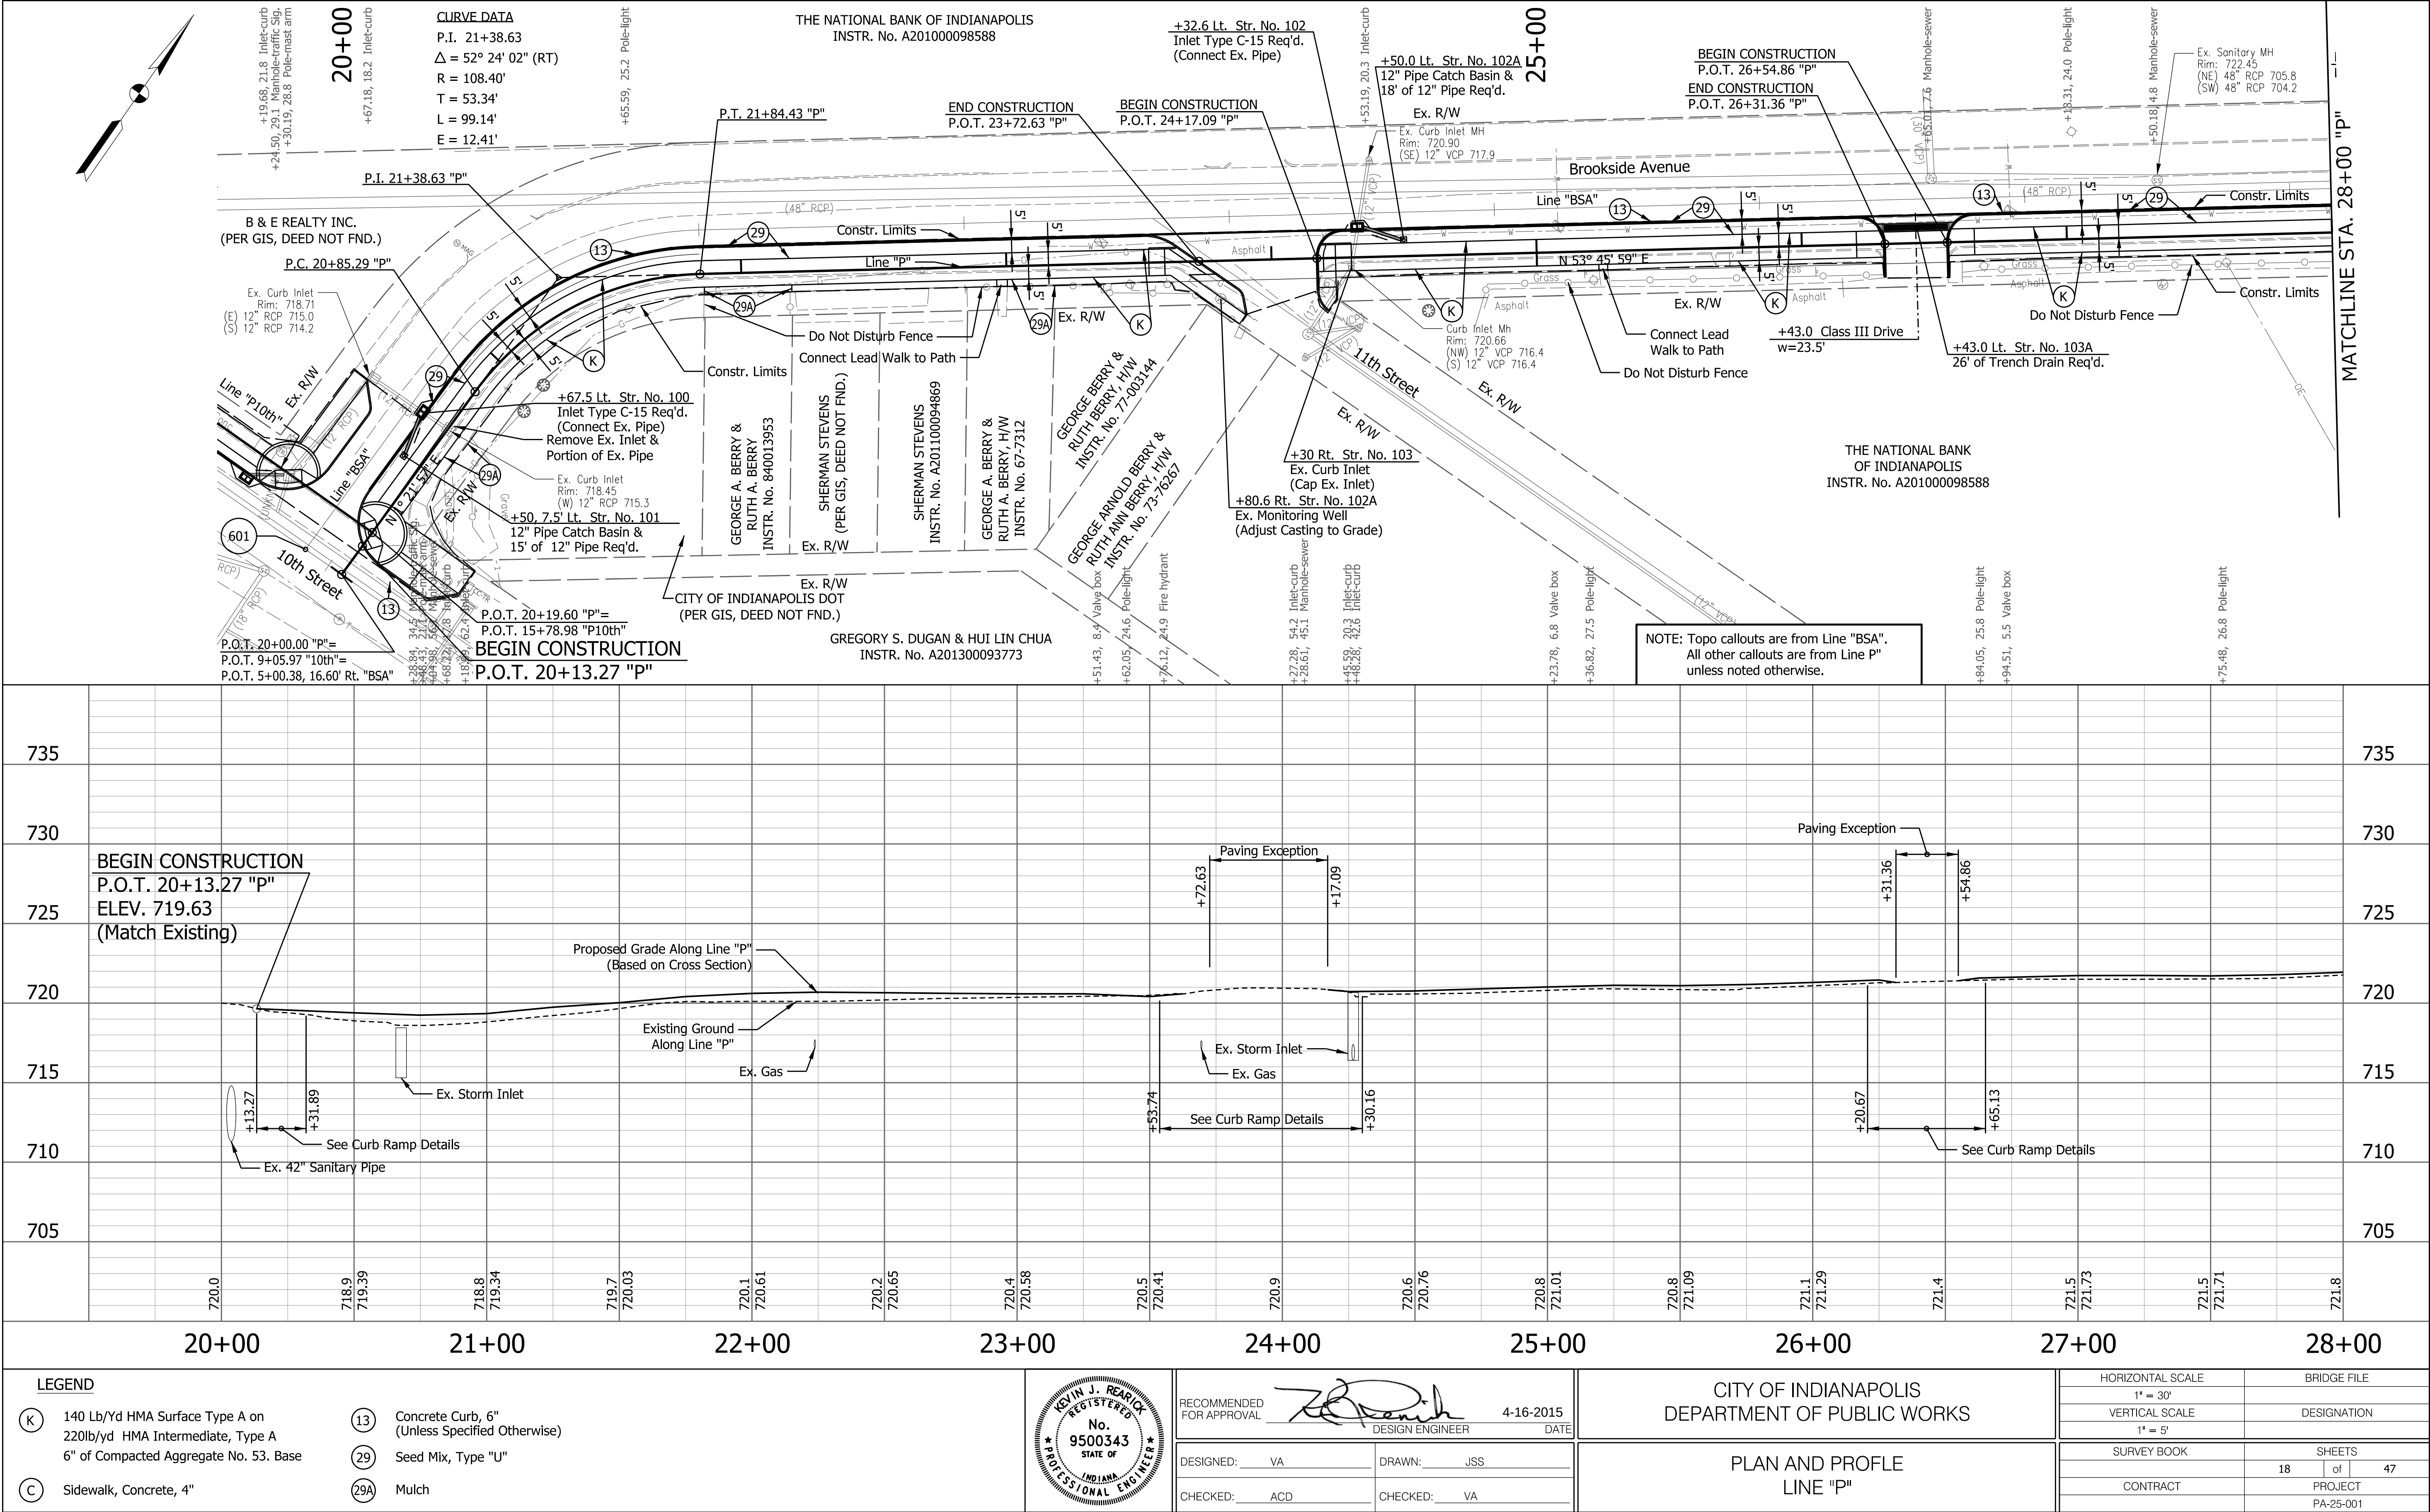

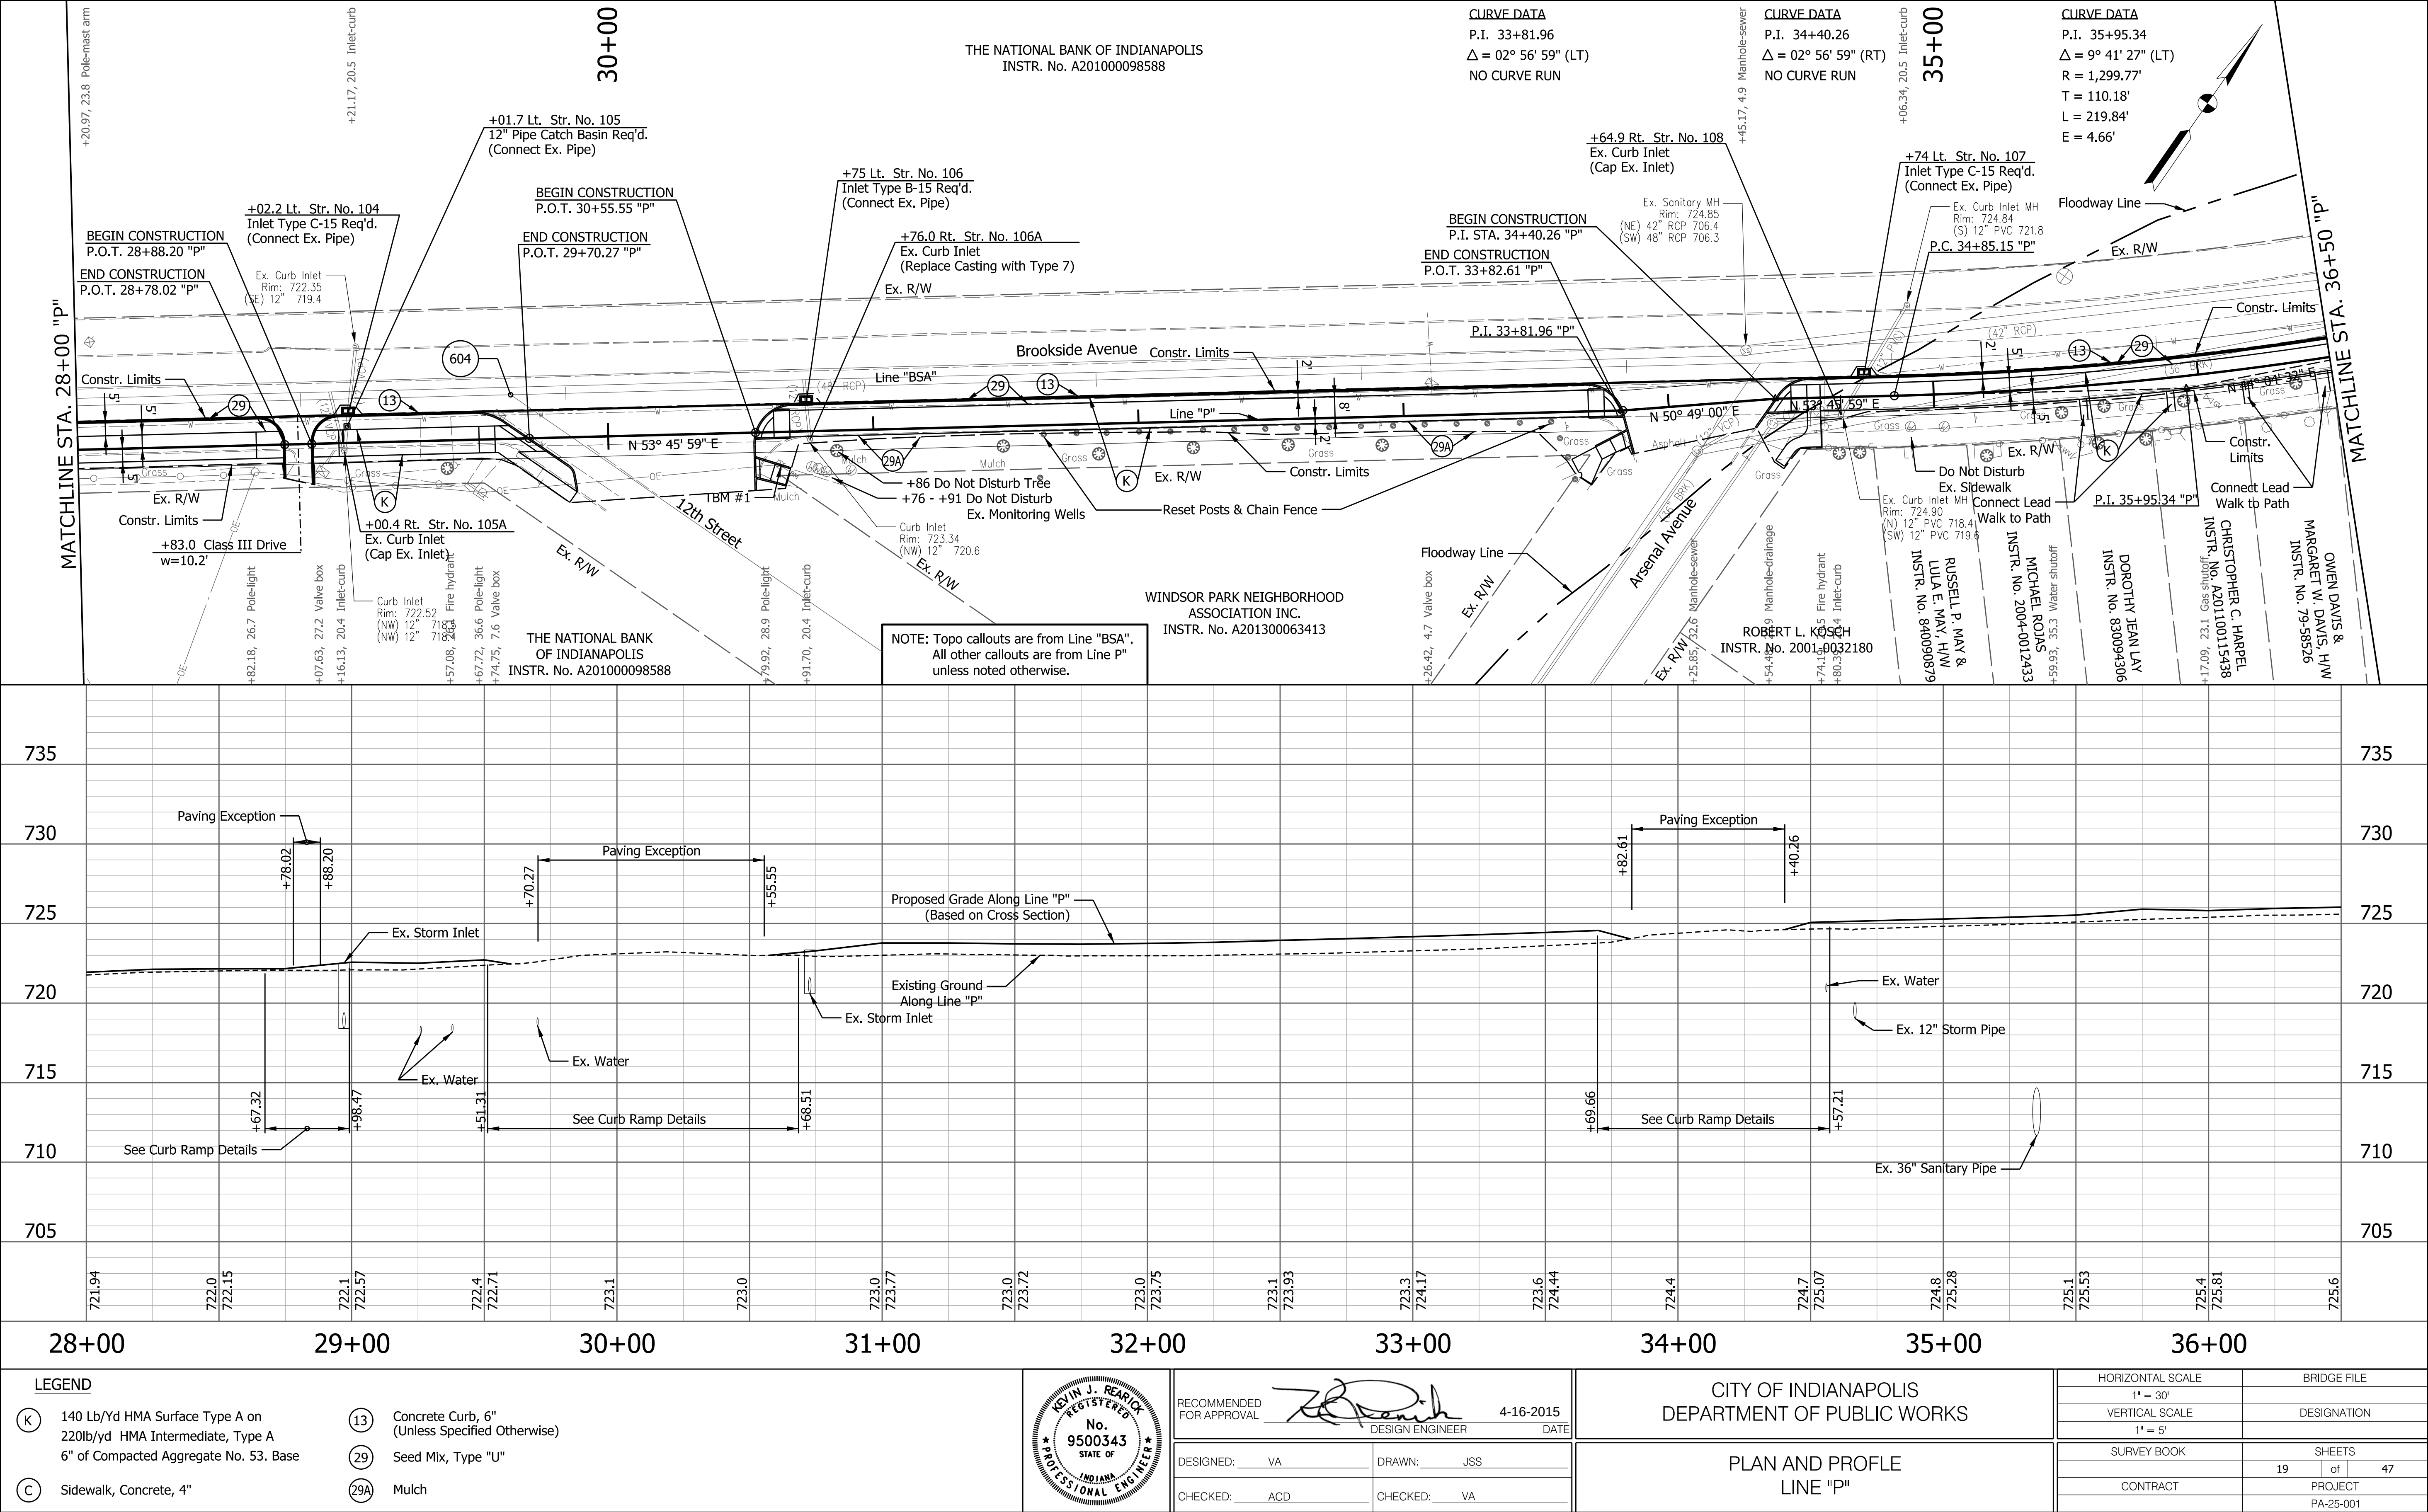

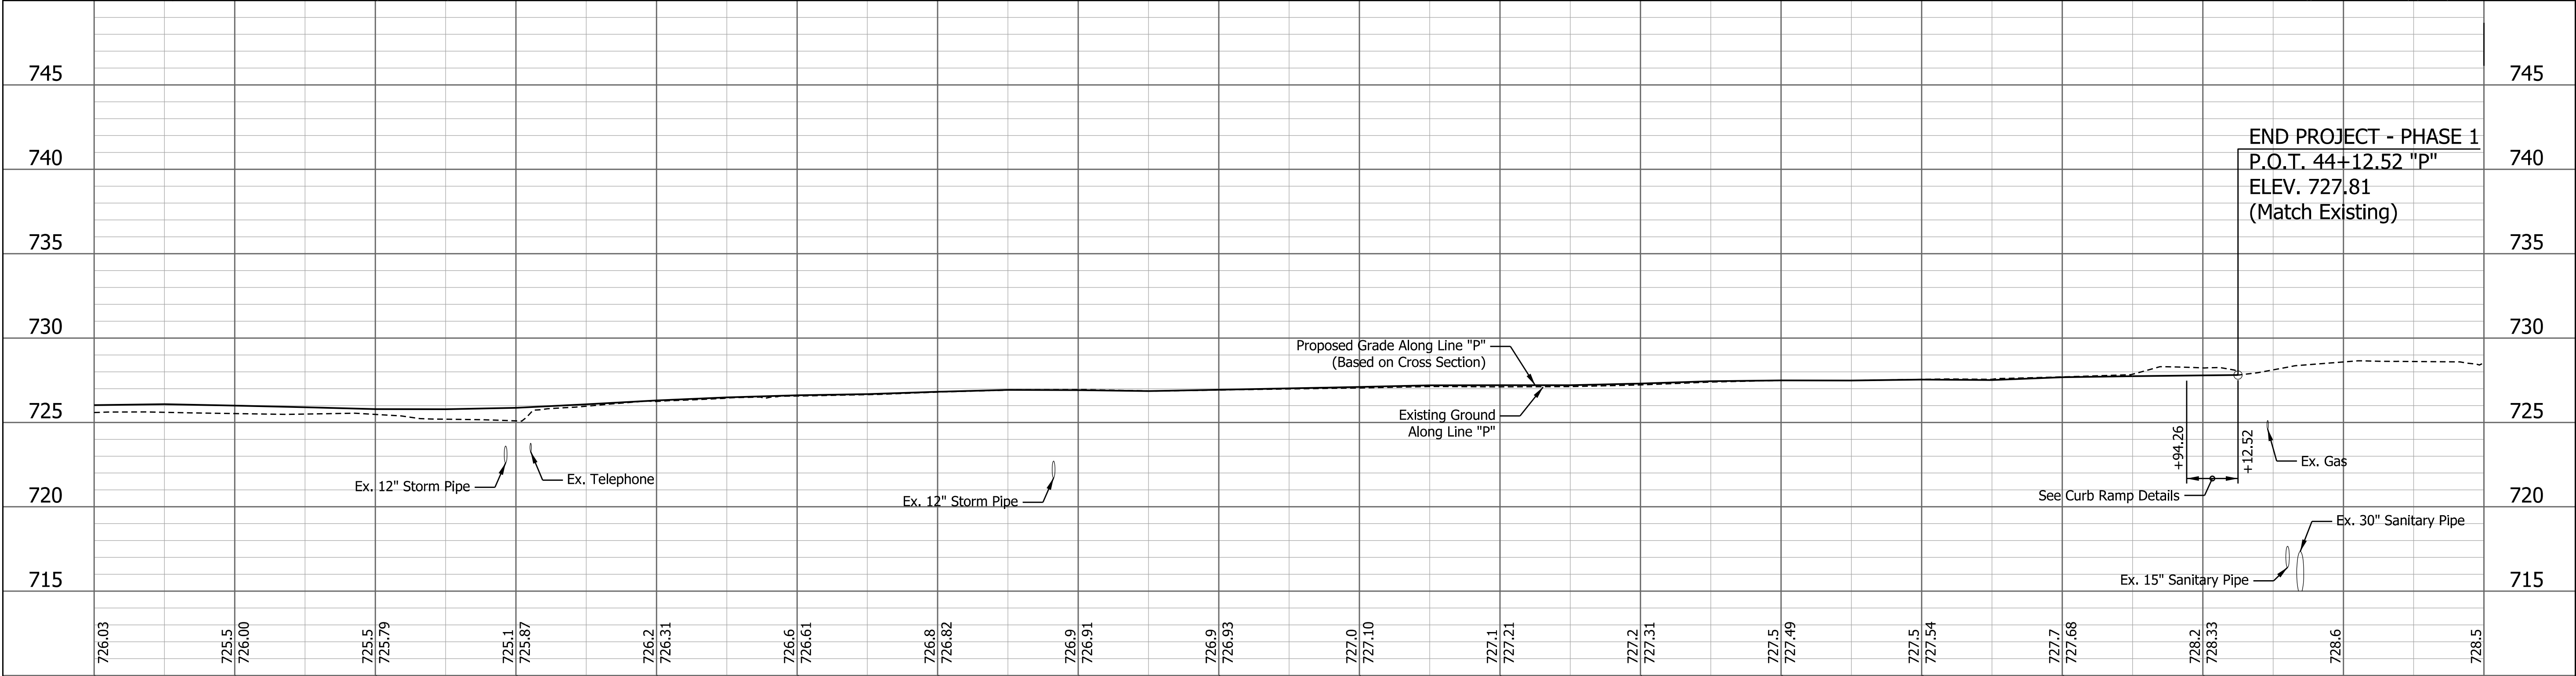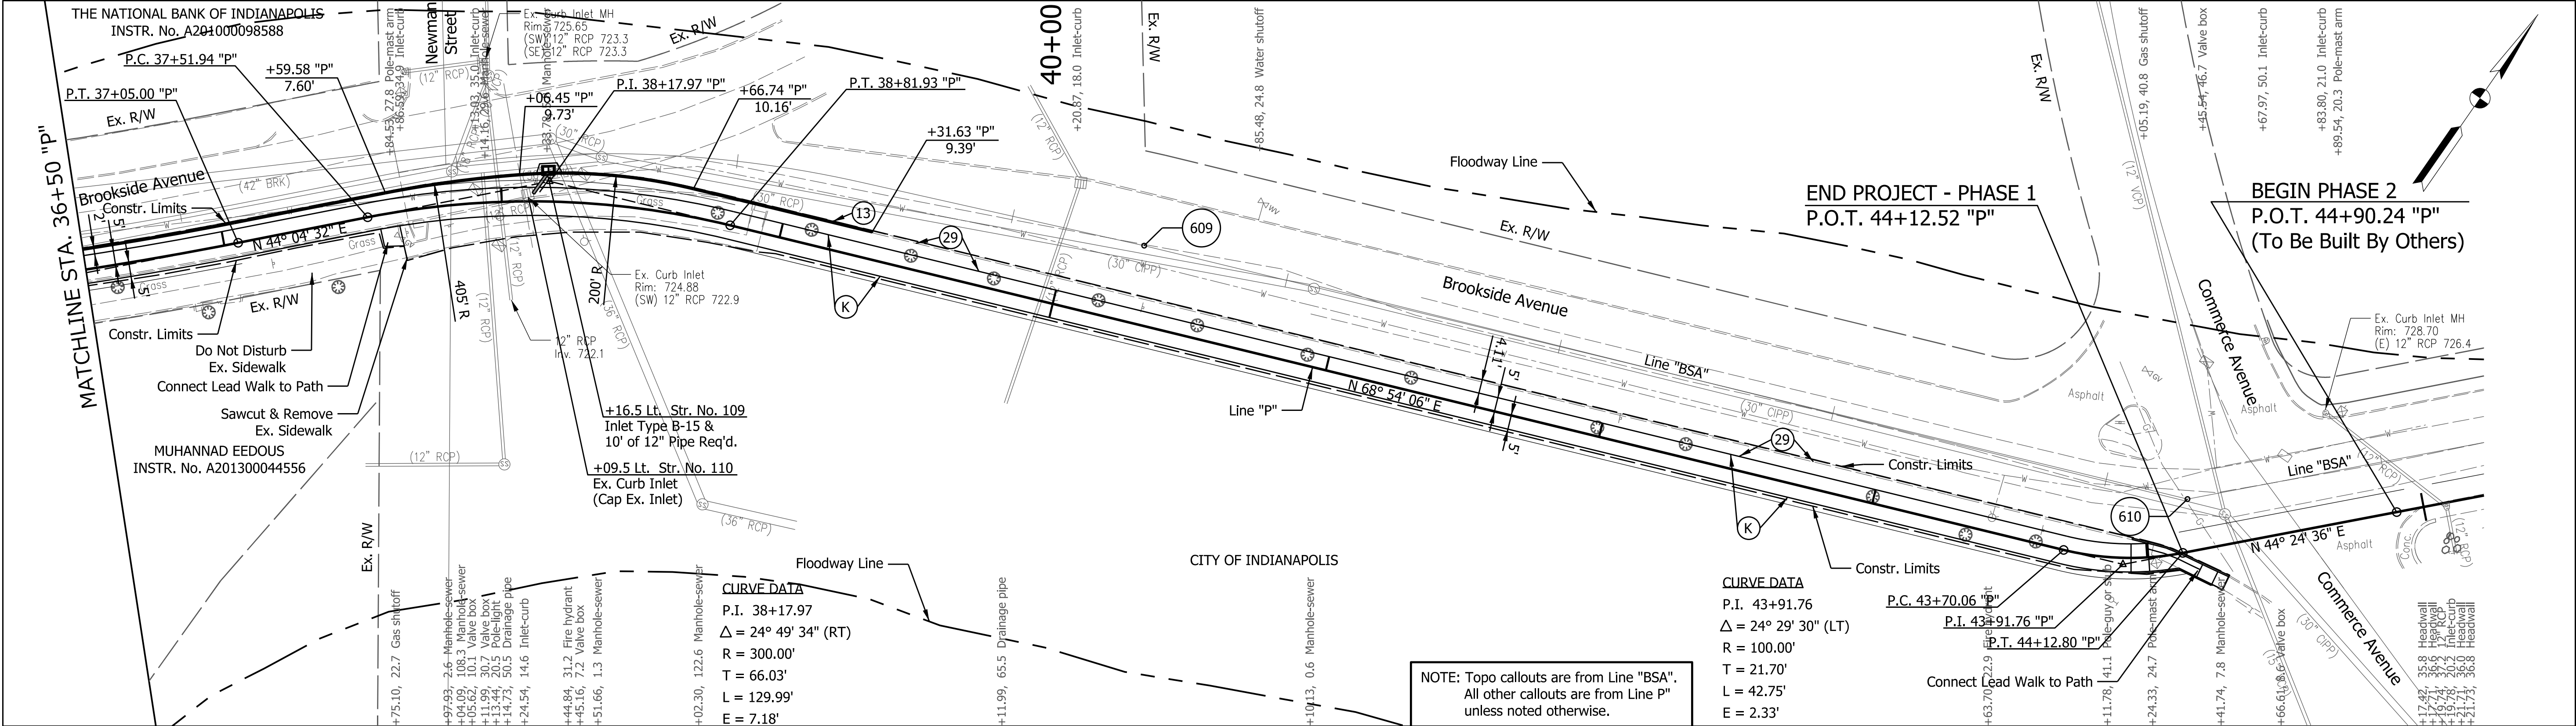

LEGEND

(K)

140 Lb/Yd HMA Surface Type A on 220lb/yard HMA Intermediate, Type A 6" of Compacted Aggregate No. 53. Base

(C)

Sidewalk, Concrete, 4"

(13)

Concrete Curb, 6" (Unless Specified Otherwise)

(29)

Seed Mix, Type "U"

(29A)

Mulch

KEVIN J. REAGAN

REGISTERED

No. 9500343

STATE OF INDIANA

PROFESSIONAL ENGINEER

RECOMMENDED FOR APPROVAL

DESIGN ENGINEER

4-16-2015

DATE

DESIGNED: VA

DRAWN: JSS

CHECKED: ACD

CHECKED: VA

CITY OF INDIANAPOLIS

DEPARTMENT OF PUBLIC WORKS

PLAN AND PROFILE

LINE "P"

HORIZONTAL SCALE

1" = 30'

VERTICAL SCALE

1" = 5'

SURVEY BOOK

CONTRACT

BRIDGE FILE

DESIGNATION


SHEETS


20 of 47

PROJECT

PA-25-001

V:\Projects\11IN621\Planning and Urban Design\Projects\27813 Pogues Run Greenway\30 Sheet\Drawings\10 BaseSets\Sht PlanProfile_30_05.dgn

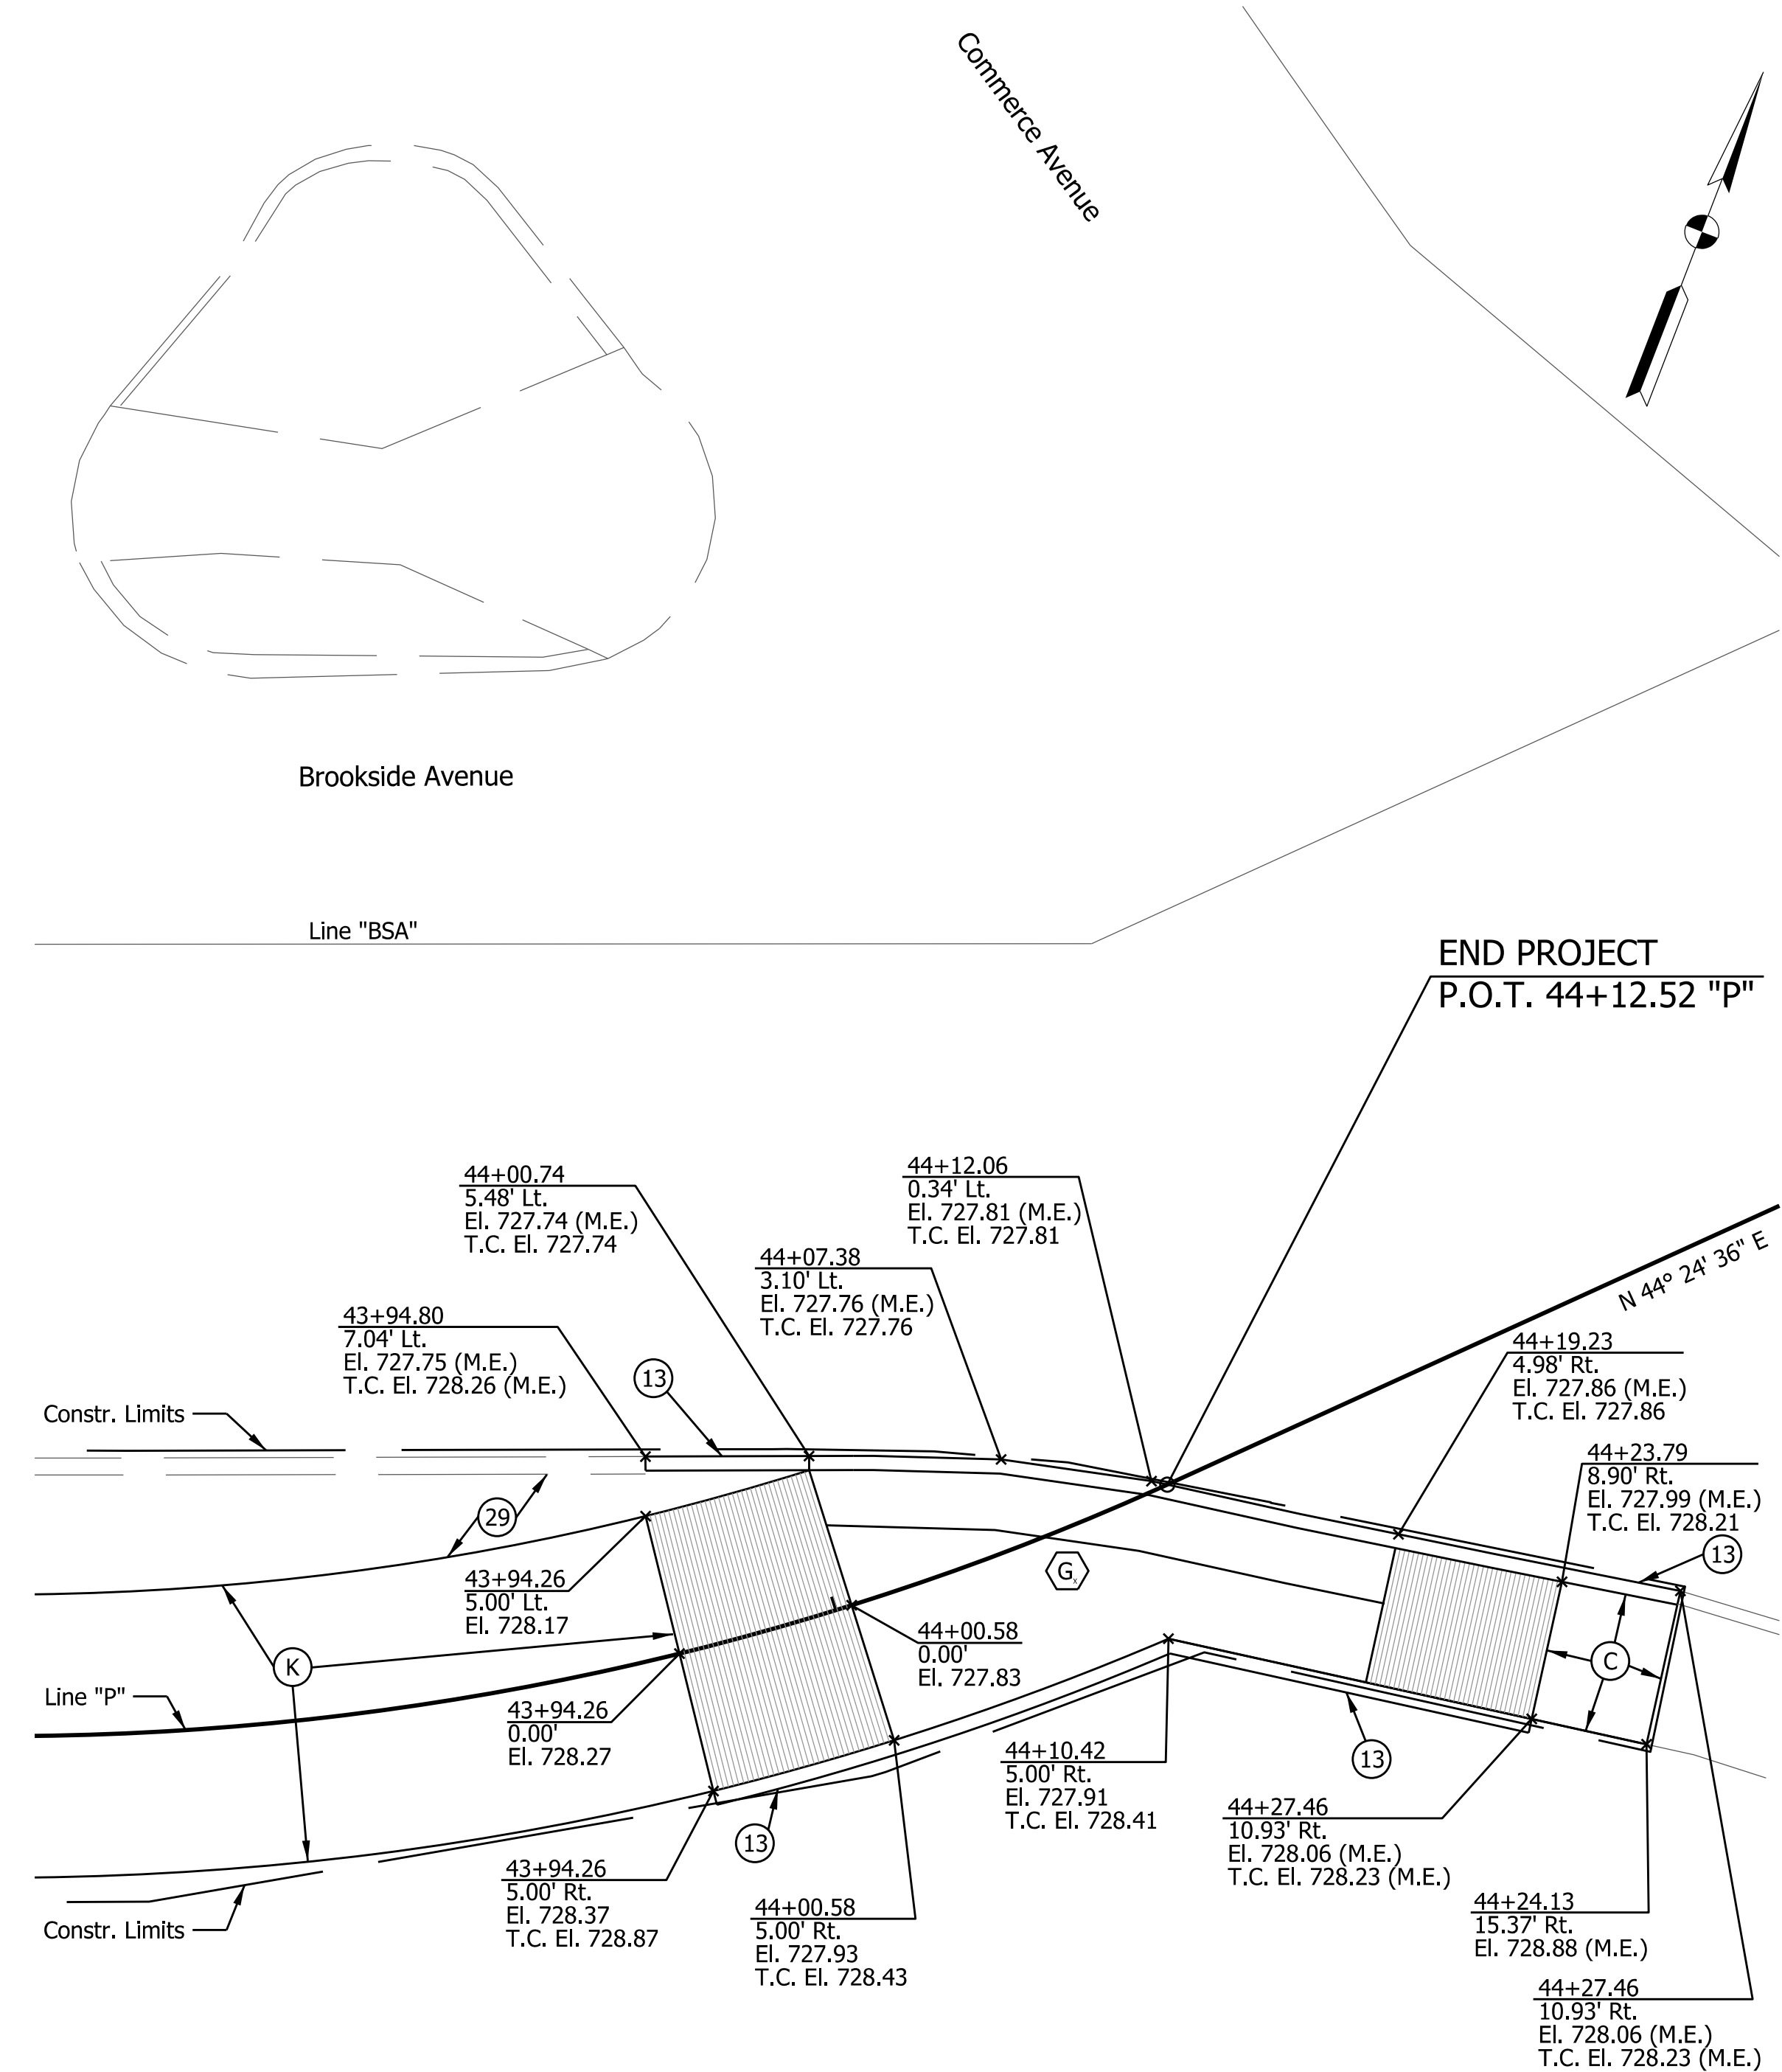

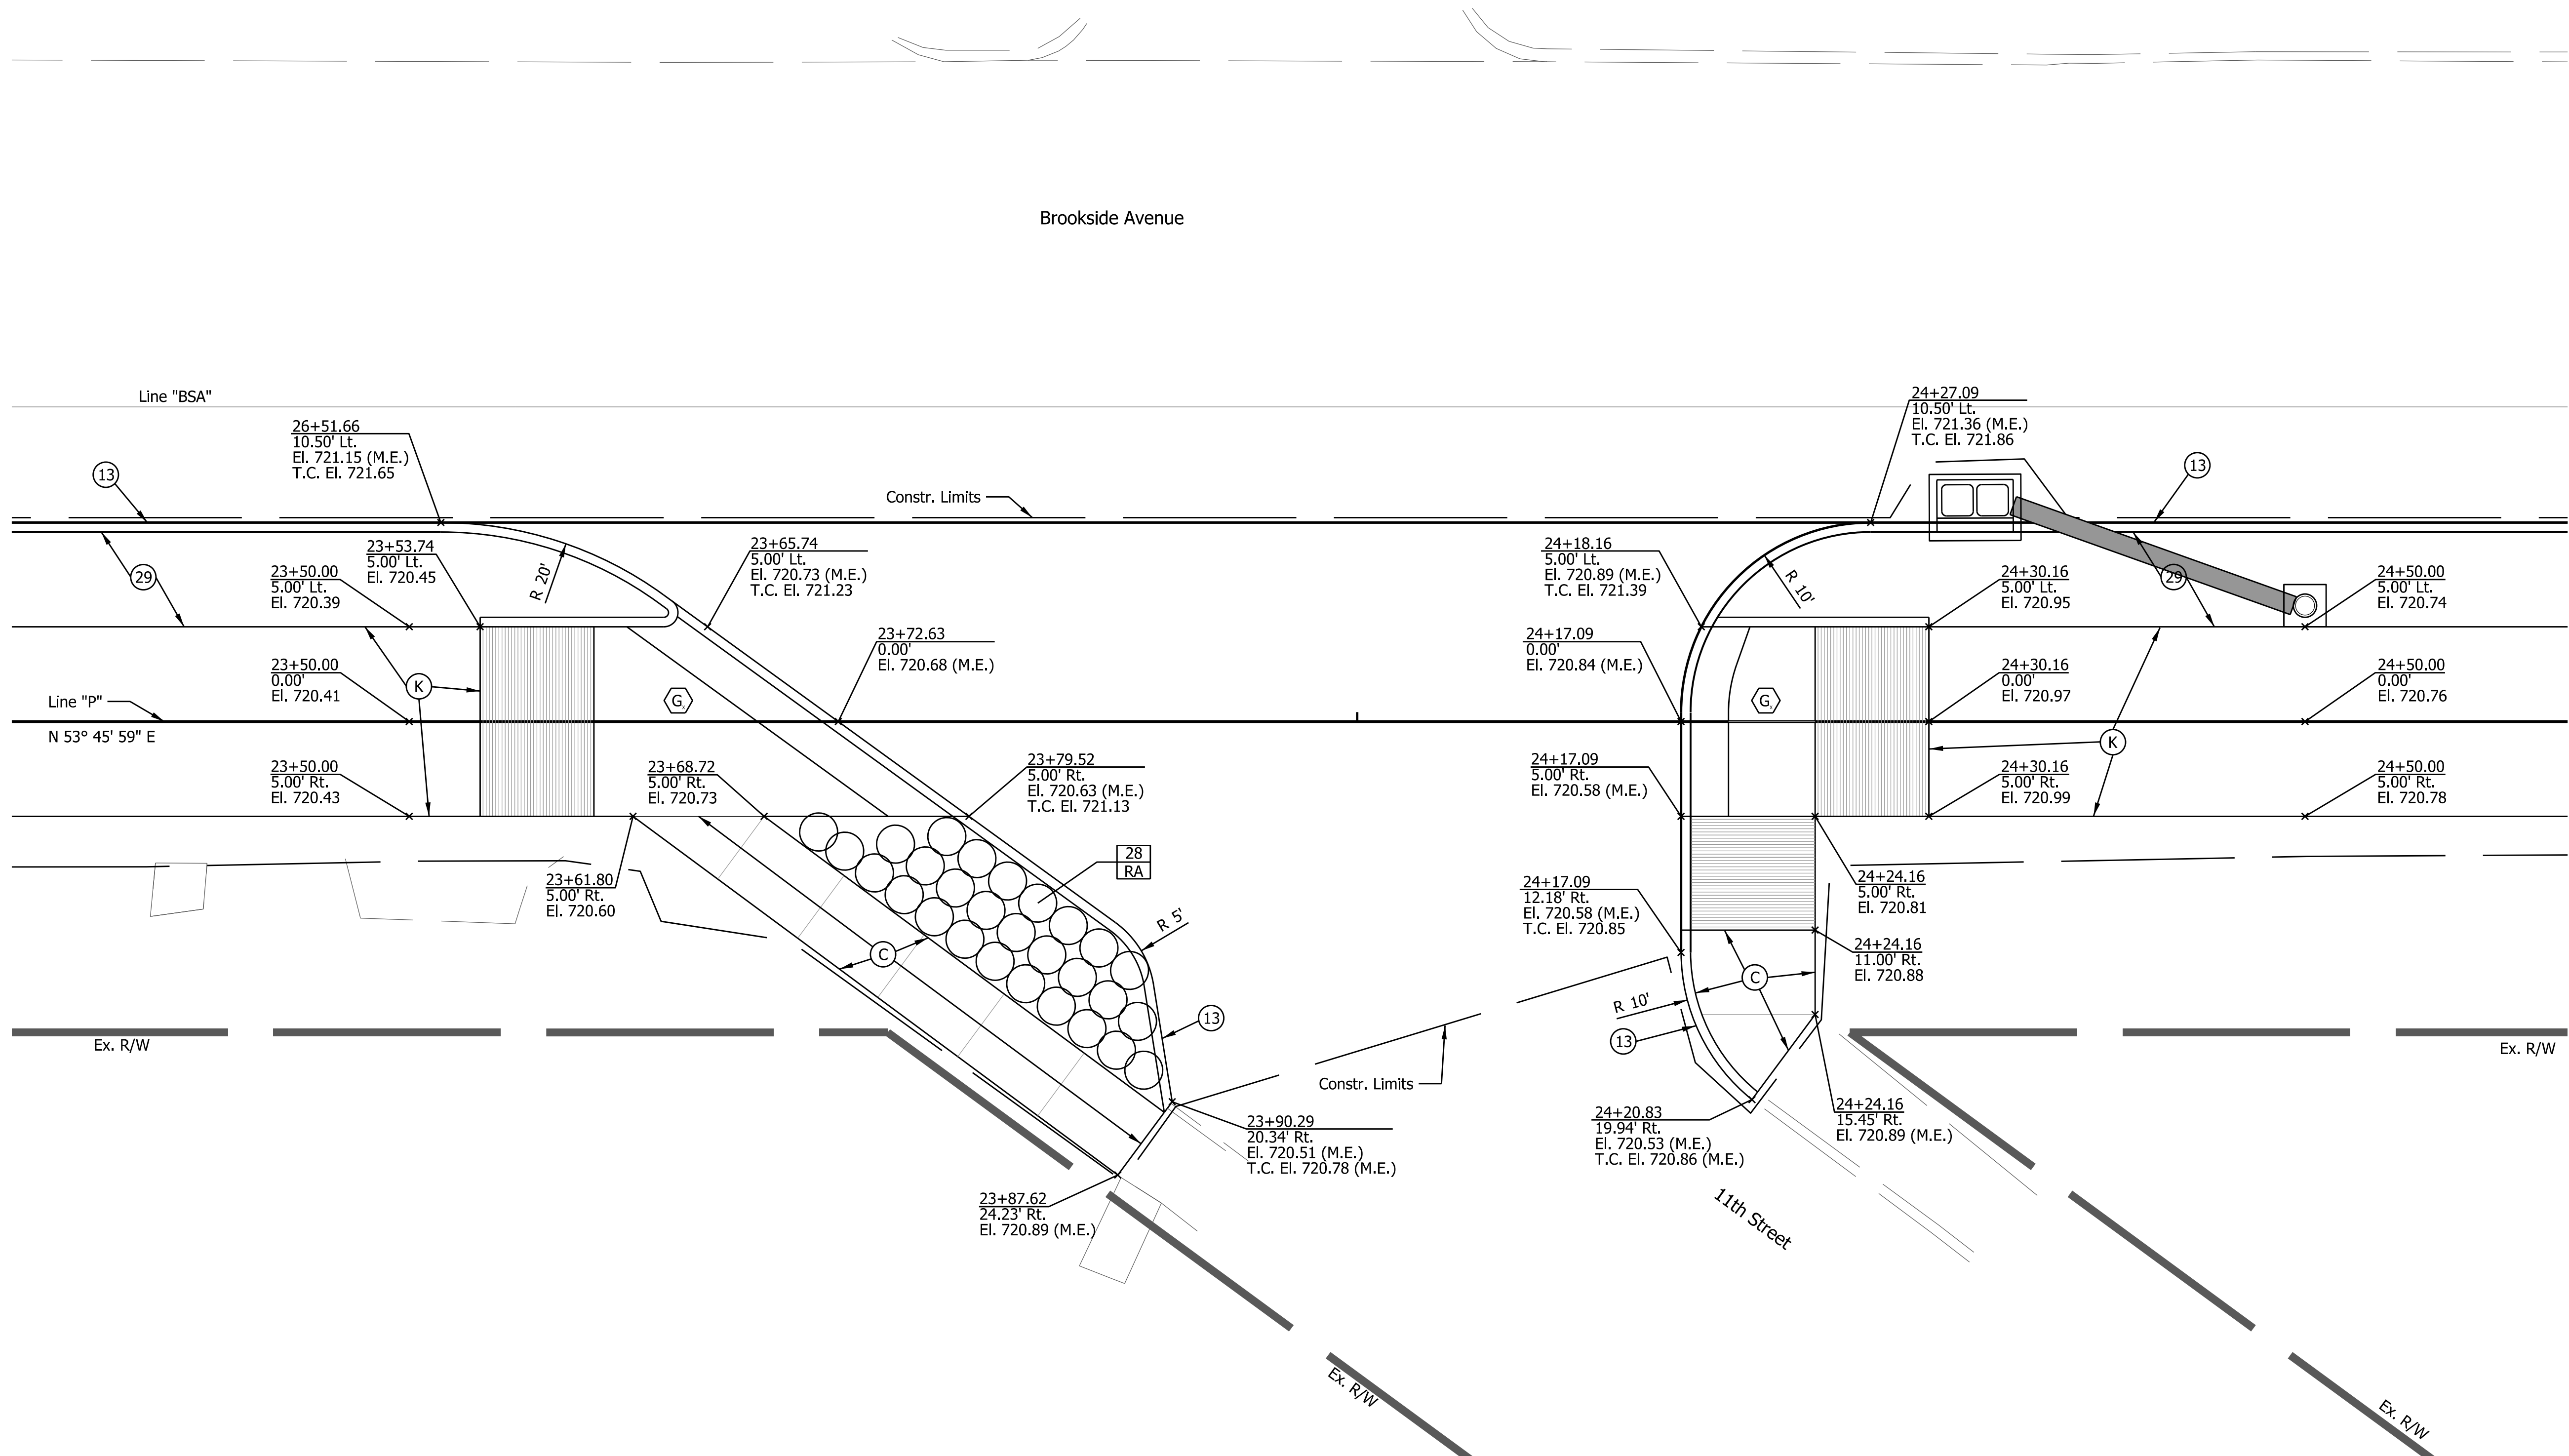

LEGEND

- | | | |
|--|---|---|
| (K) 140 Lb/Yd HMA Surface Type A on 220lb/yard HMA Intermediate, Type A 6" of Compacted Aggregate No. 53. Base | (13) Concrete Curb, 6" (Unless Specified Otherwise) | (G) Curb Ramp, Concrete (Type Indicated by Letter) |
| (C) Sidewalk, Concrete, 4" | (29) Seed Mix, Type "U" | (G) Modified Curb Ramp, Concrete (Type Indicated by Letter) |
| (D) Drive, Concrete | (29A) Mulch | (# XX) Plant Code & Quantity |




RECOMMENDED FOR APPROVAL		DESIGN ENGINEER	4-16-2015	DATE
DESIGNED: VA	DRAWN: JSS	CHECKED: ACD	CHECKED: VA	



CITY OF INDIANAPOLIS
DEPARTMENT OF PUBLIC WORKS

CONSTRUCTION DETAIL
CURB RAMP DETAIL


HORIZONTAL SCALE	BRIDGE FILE
1"=5'	DESIGNATION
VERTICAL SCALE	
SURVEY BOOK	SHEETS
CONTRACT	23 of 47
	PROJECT
	PA-25-001

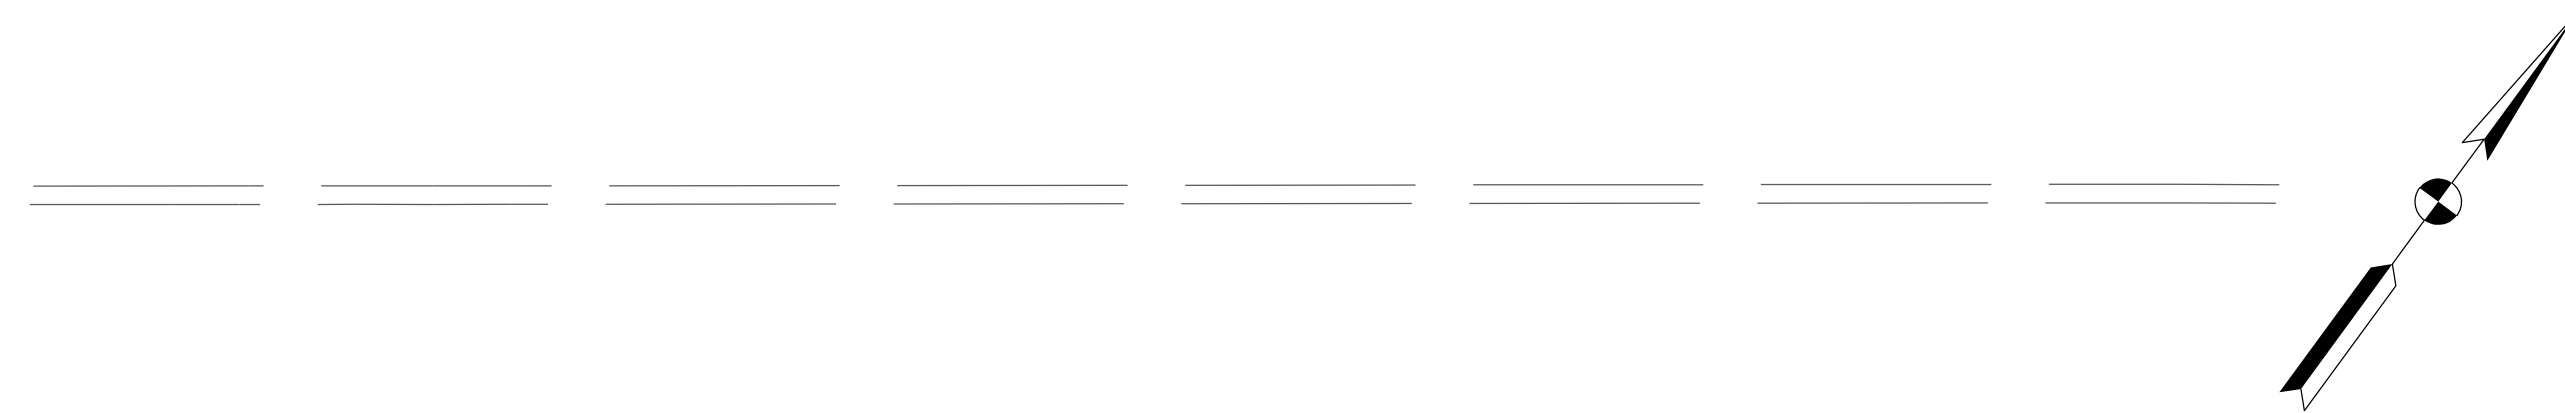

Brookside Avenue

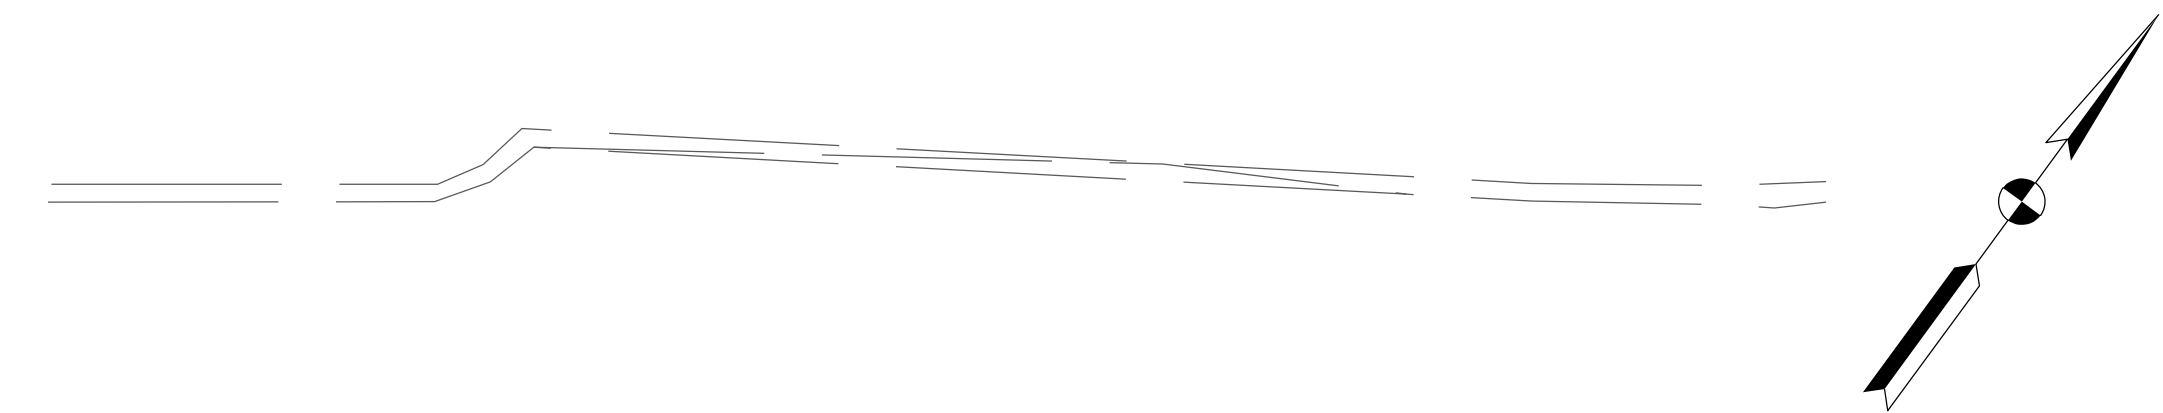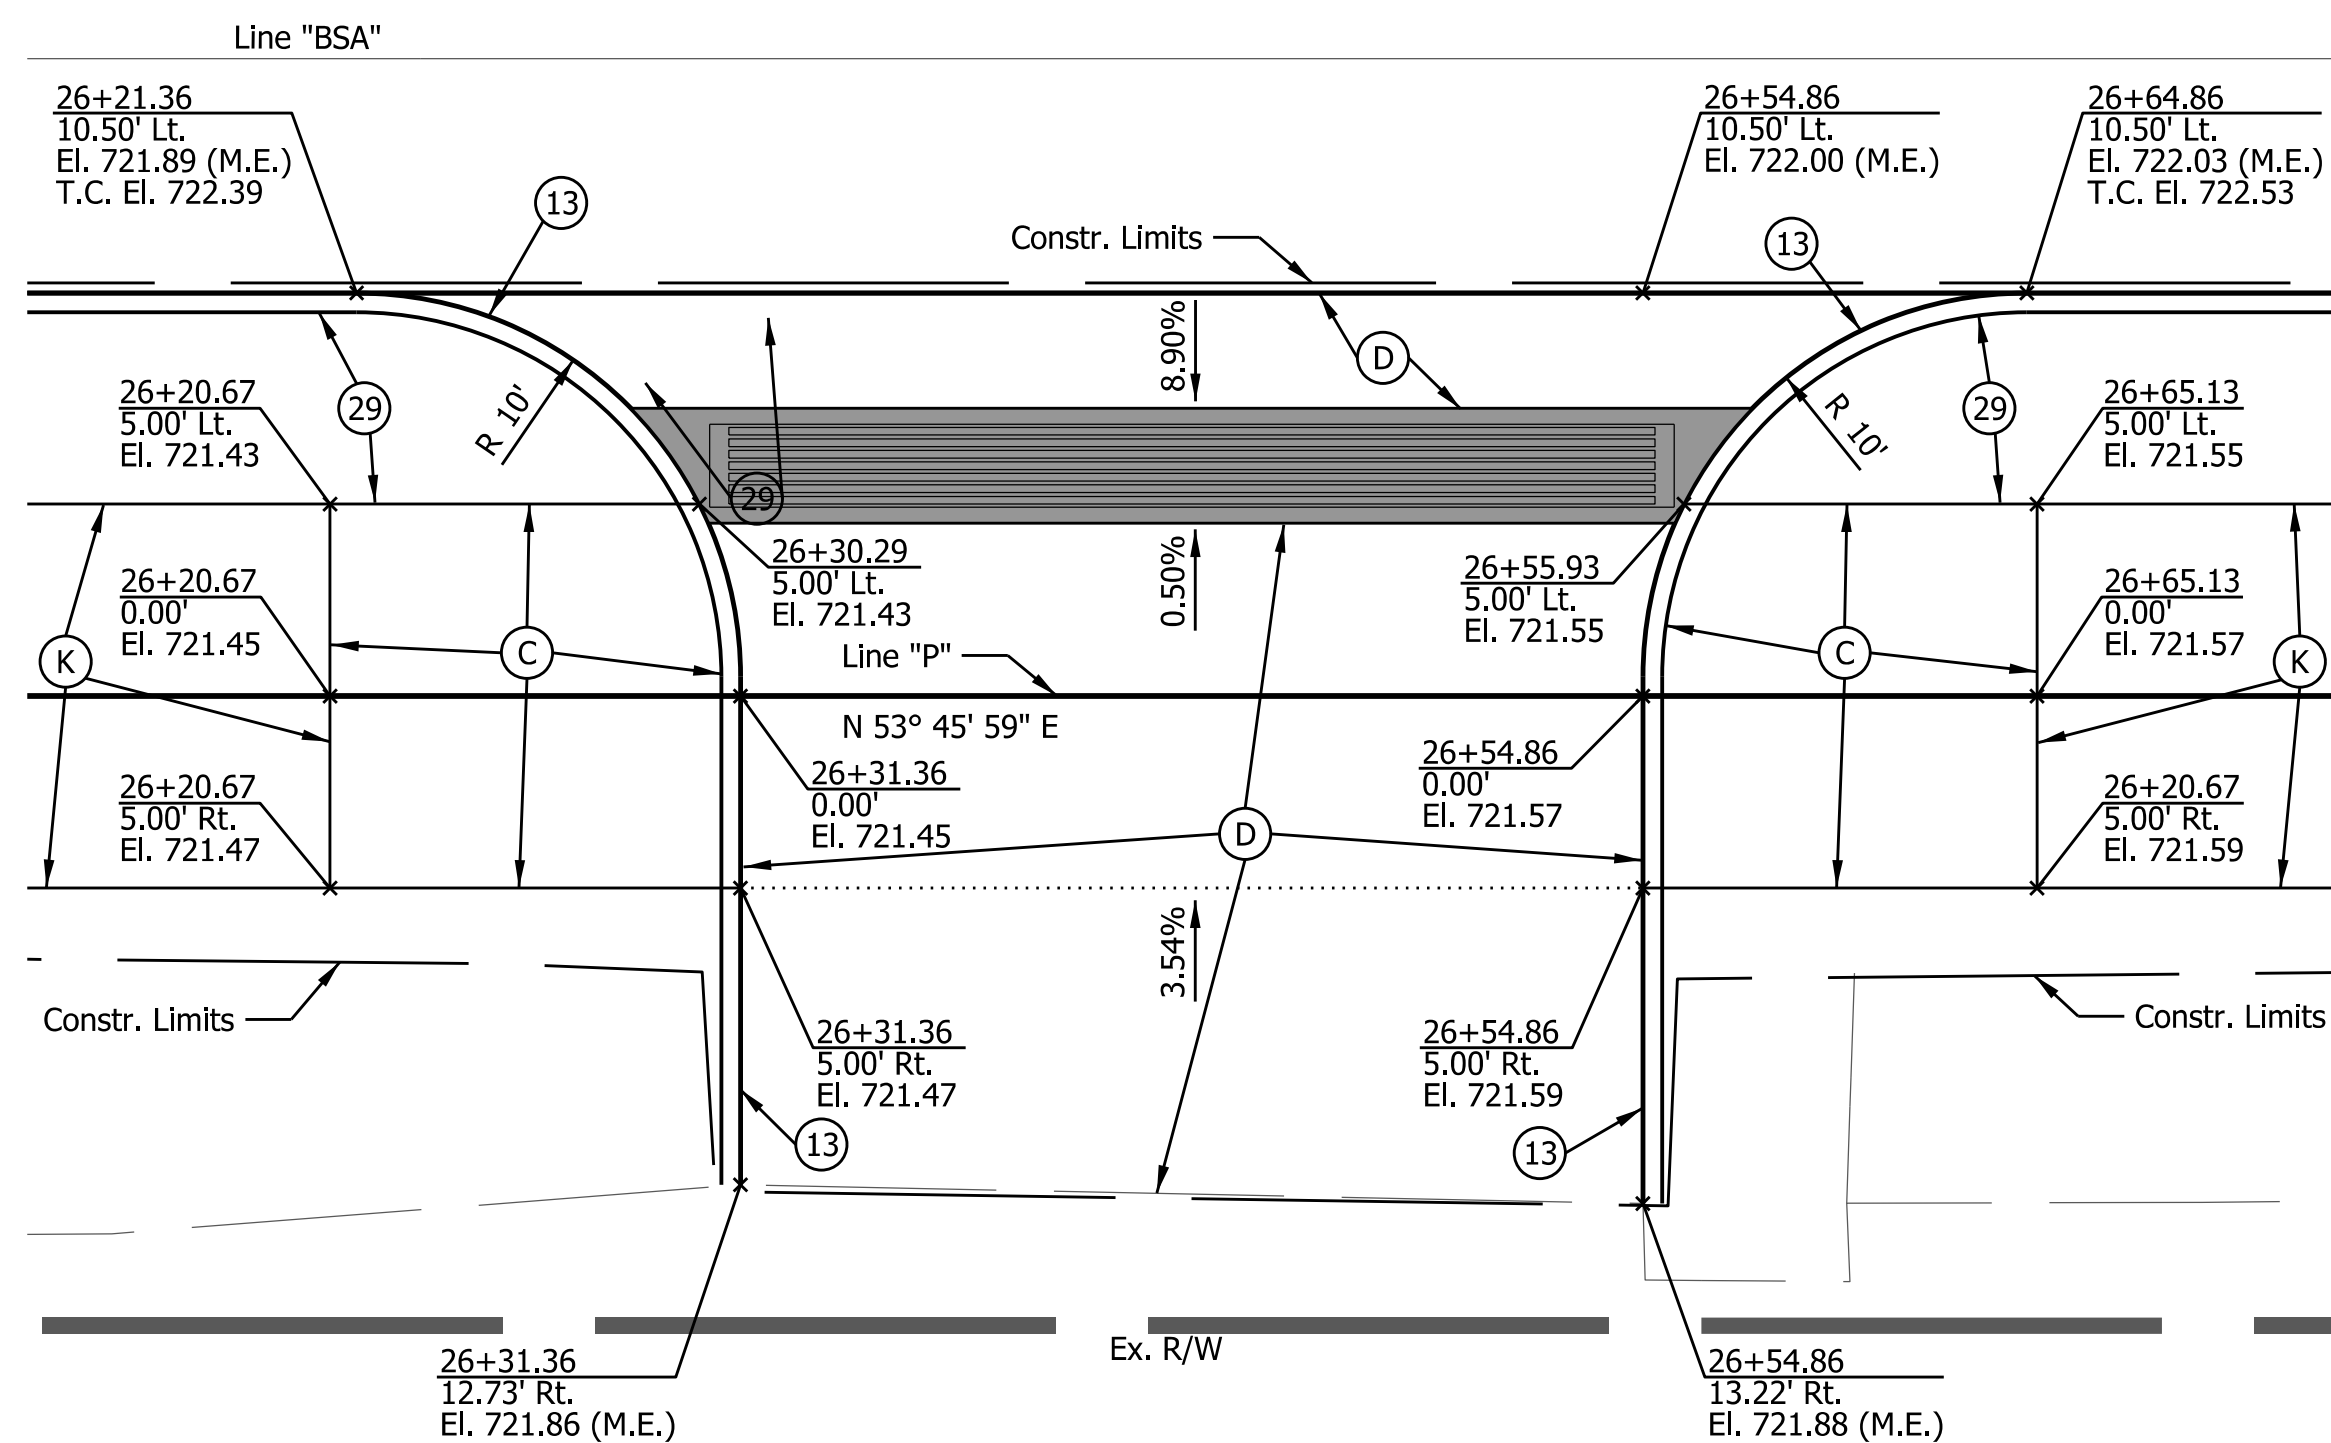

Brookside Avenue

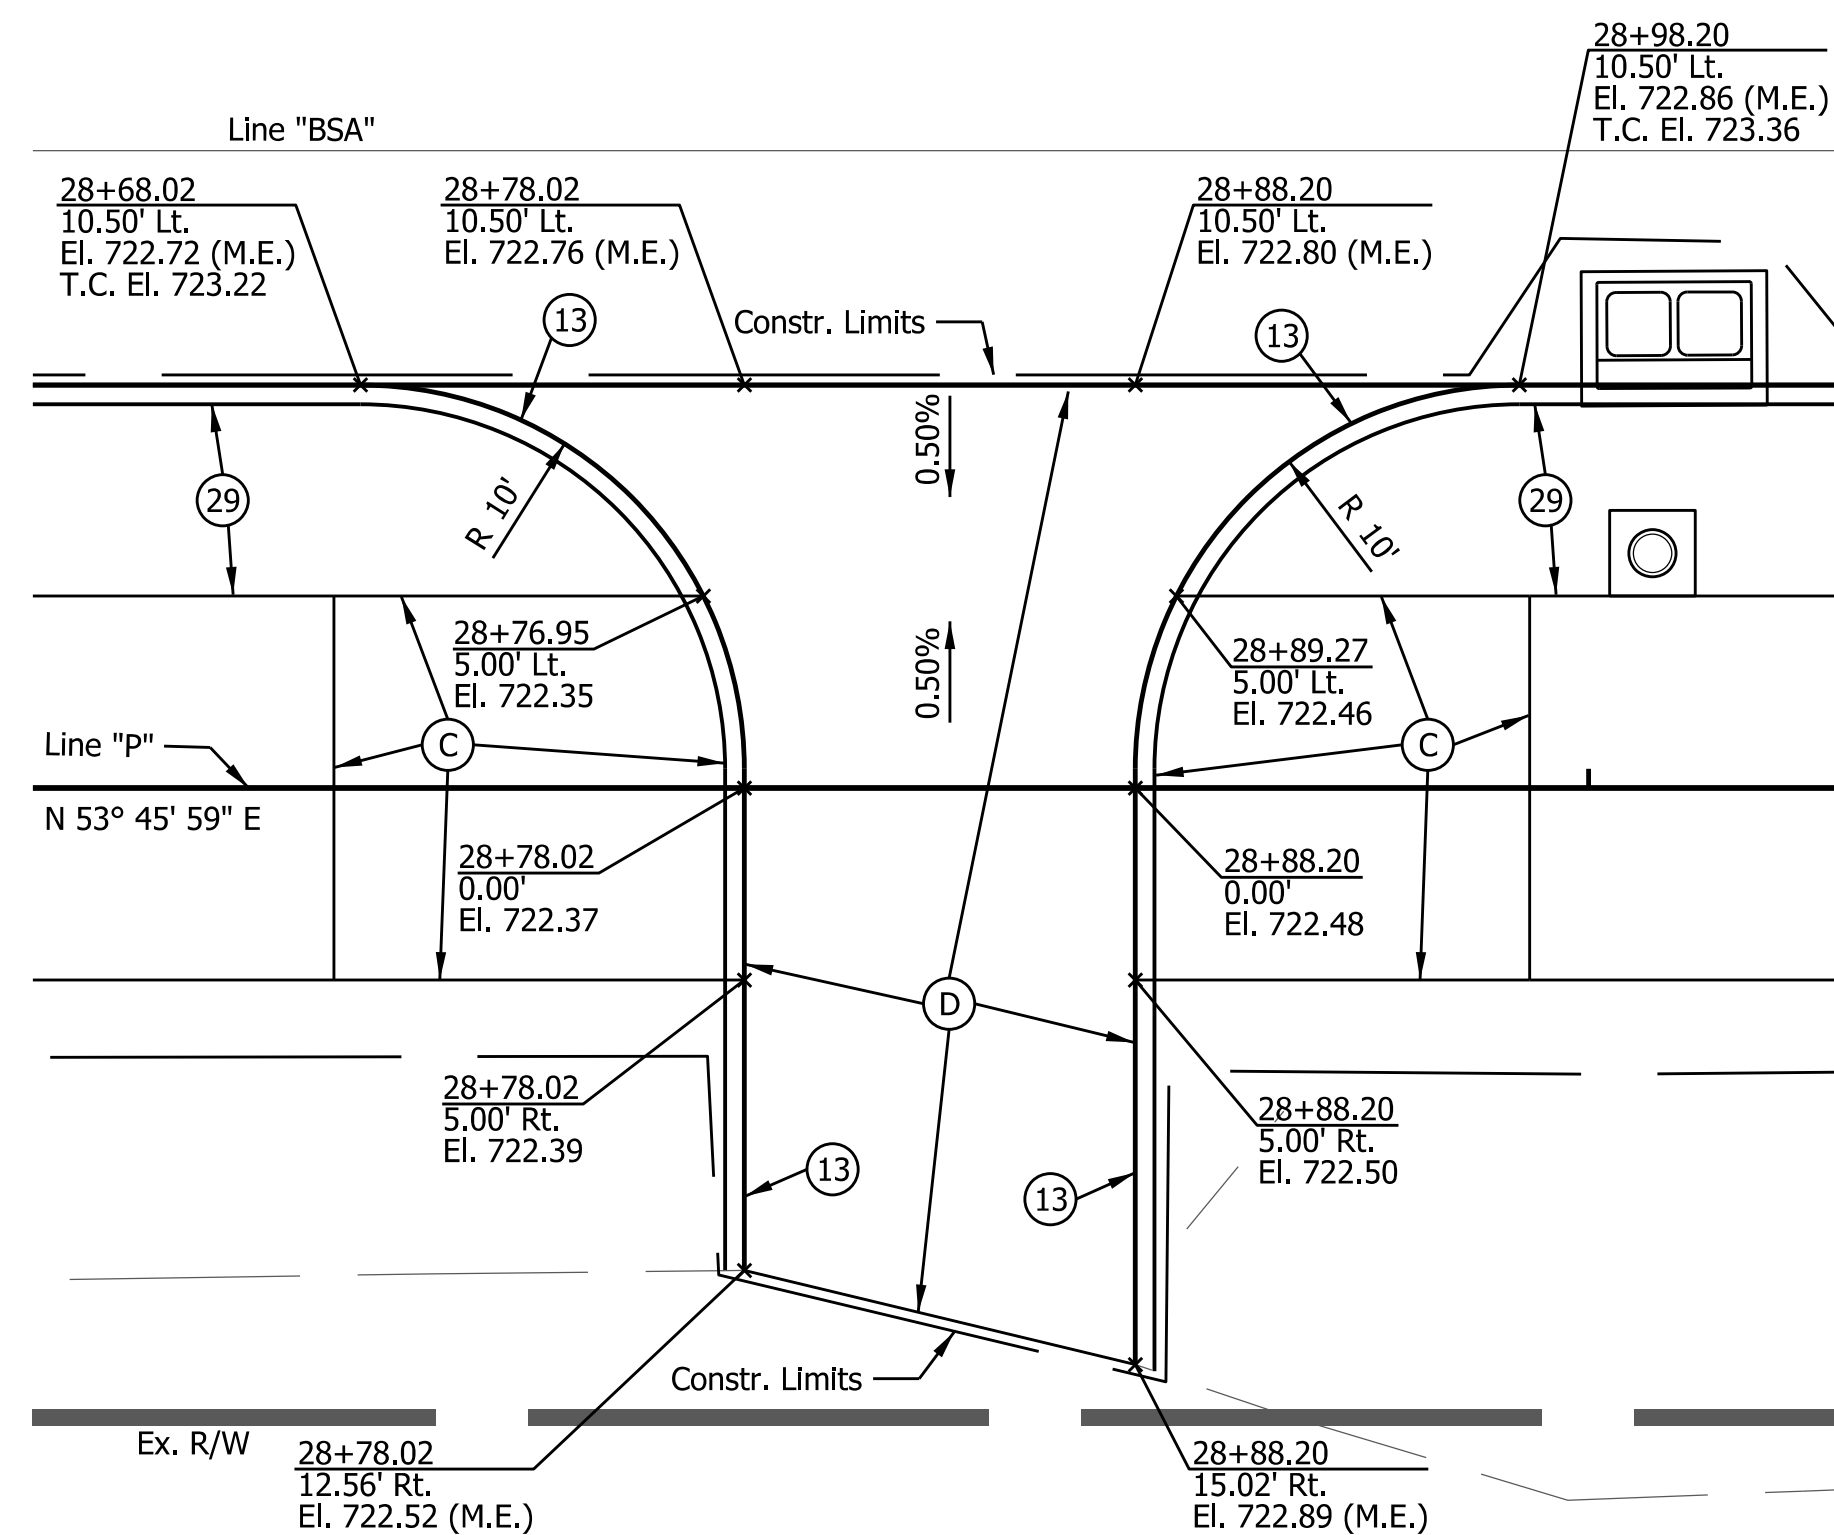

LEGEND

- | | | |
|---|--|---|
| (K) 140 Lb/Yd HMA Surface Type A on 220lb/yd HMA Intermediate, Type A 6\" of Compacted Aggregate No. 53. Base | (13) Concrete Curb, 6\" (Unless Specified Otherwise) | (C) Curb Ramp, Concrete (Type Indicated by Letter) |
| (C) Sidewalk, Concrete, 4\" | (29) Seed Mix, Type \"U\" | (C) Modified Curb Ramp, Concrete (Type Indicated by Letter) |
| (D) Drive, Concrete | (29A) Mulch | # XX Plant Code & Quantity |




RECOMMENDED FOR APPROVAL		4-16-2015 DATE
DESIGNED: VA	DRAWN: JSS	
CHECKED: ACD	CHECKED: VA	

CITY OF INDIANAPOLIS
DEPARTMENT OF PUBLIC WORKS

CONSTRUCTION DETAIL
CURB RAMP DETAIL

HORIZONTAL SCALE	BRIDGE FILE
1\"=5'	
VERTICAL SCALE	DESIGNATION
SURVEY BOOK	SHEETS
CONTRACT	24 of 47
	PROJECT
	PA-25-001

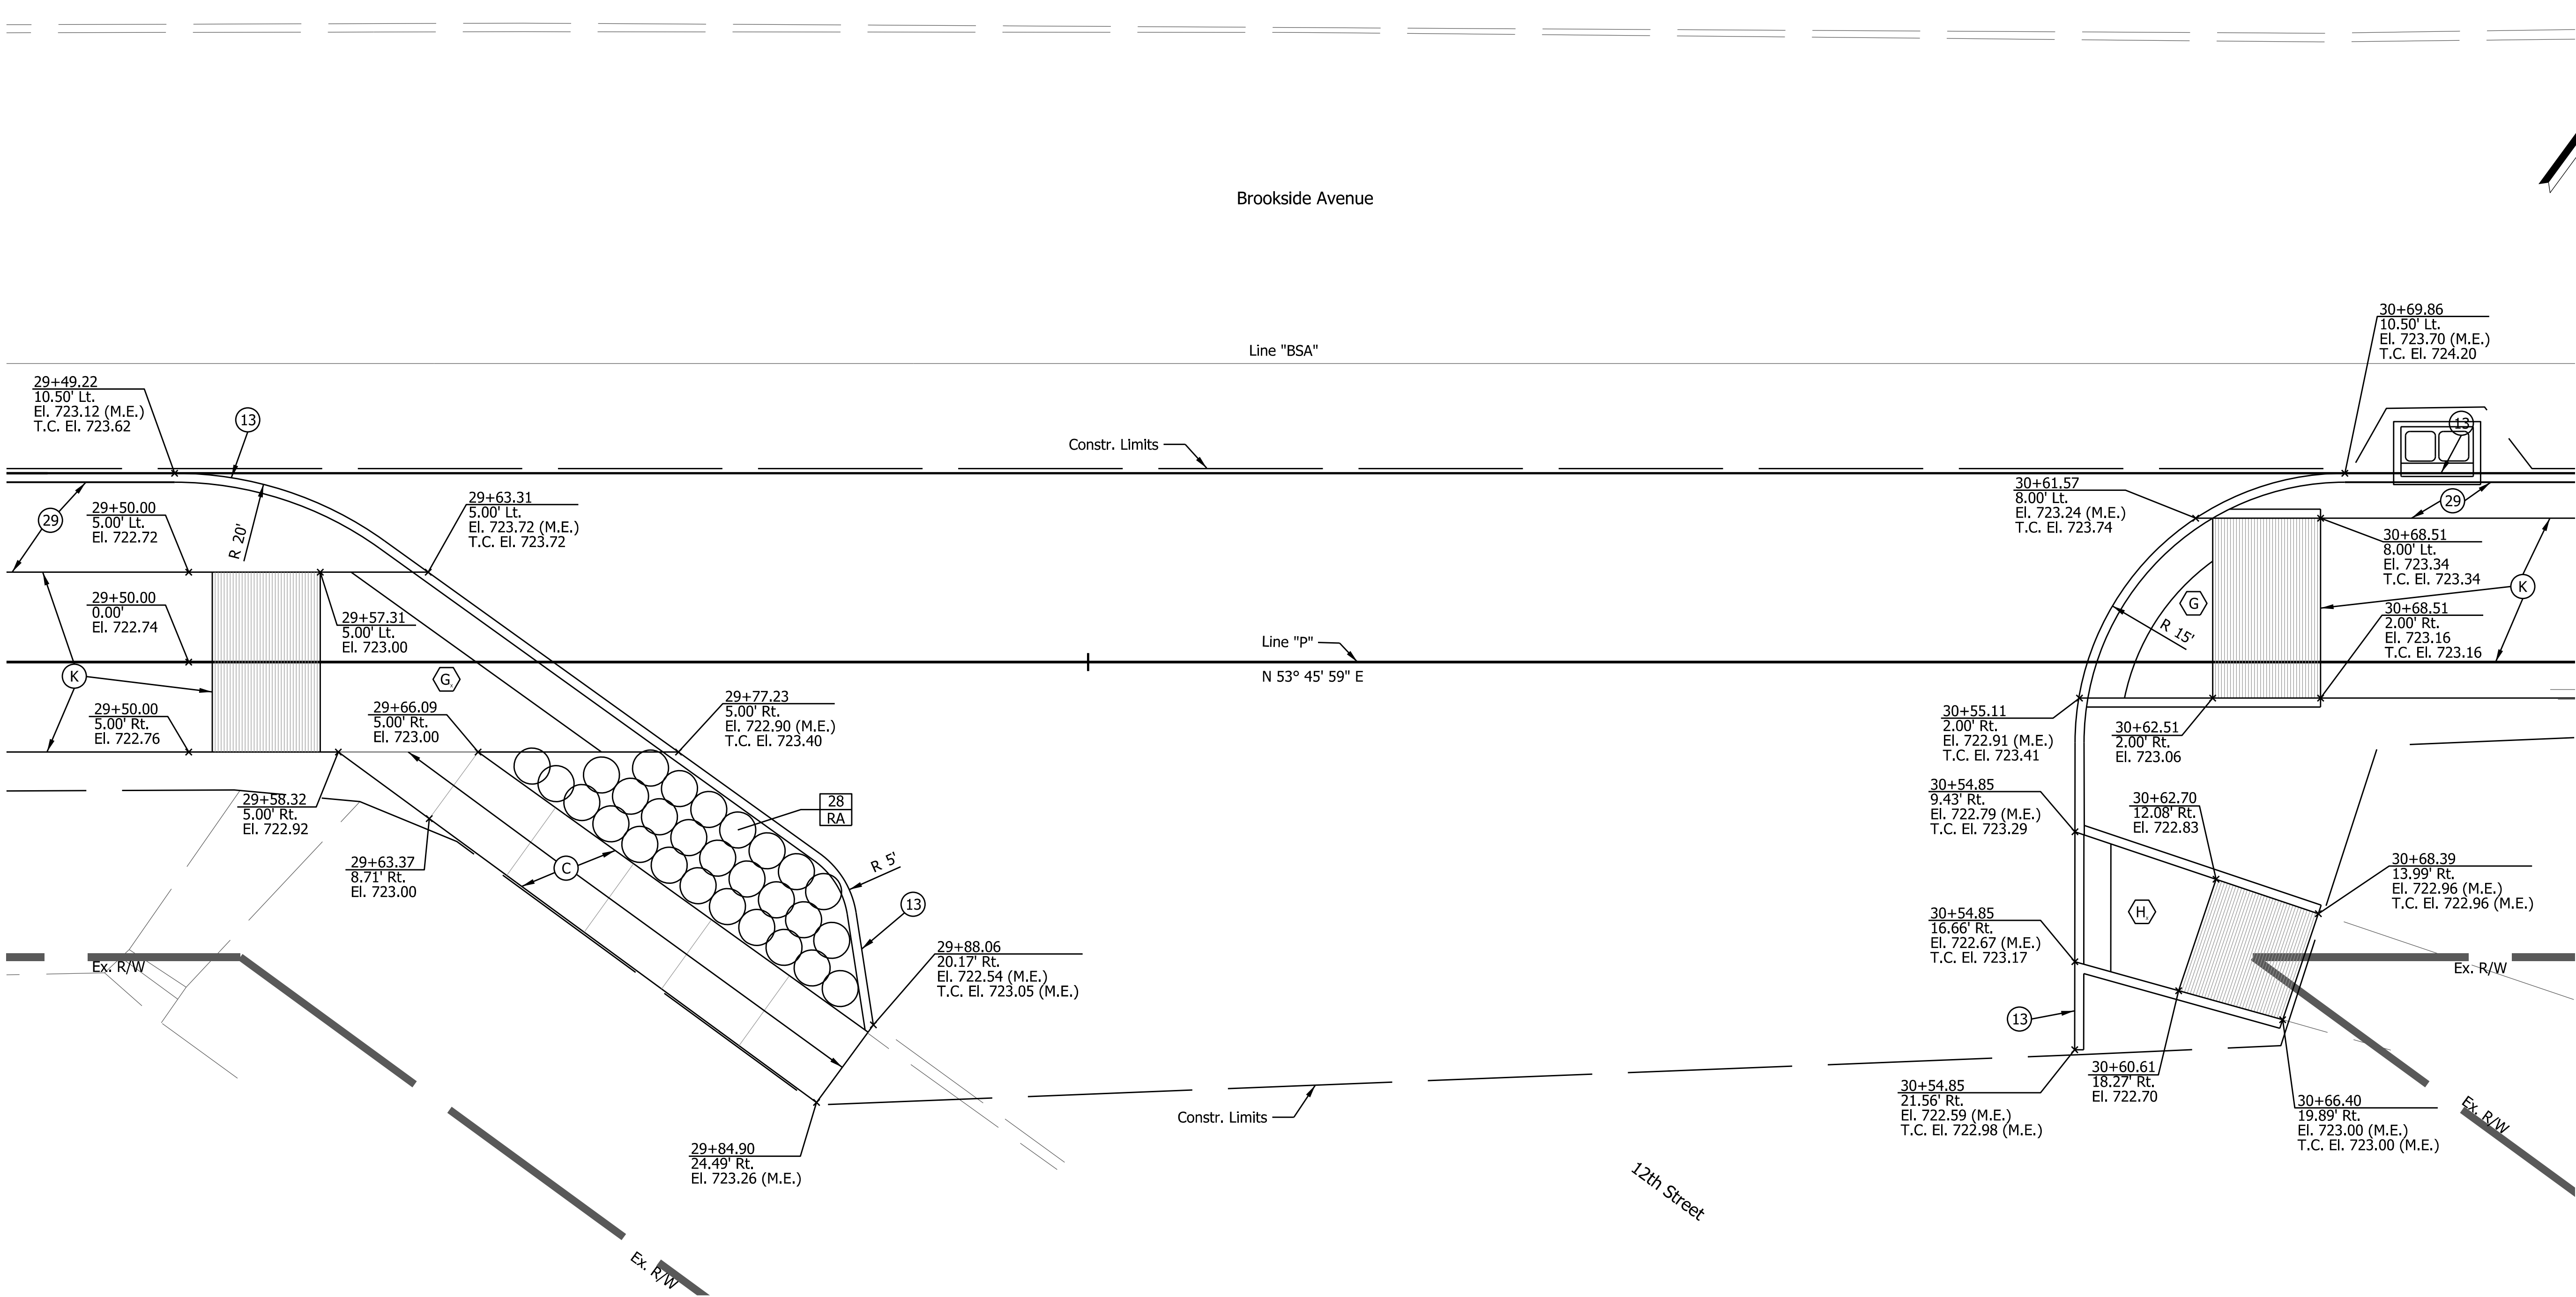

LEGEND

- | | | |
|---|--|---|
| (K) 140 Lb/Yd HMA Surface Type A on 220lb/yard HMA Intermediate, Type A 6\" of Compacted Aggregate No. 53. Base | (13) Concrete Curb, 6\" (Unless Specified Otherwise) | (G) Curb Ramp, Concrete (Type Indicated by Letter) |
| (C) Sidewalk, Concrete, 4\" | (29) Seed Mix, Type \"U\" | (H) Modified Curb Ramp, Concrete (Type Indicated by Letter) |
| (D) Drive, Concrete | (29A) Mulch | (# XX) Plant Code & Quantity |




RECOMMENDED FOR APPROVAL		4-16-2015
DESIGNED: VA	DRAWN: JSS	DATE
CHECKED: ACD	CHECKED: VA	

CITY OF INDIANAPOLIS
DEPARTMENT OF PUBLIC WORKS


CONSTRUCTION DETAIL
CURB RAMP DETAIL

HORIZONTAL SCALE	BRIDGE FILE
1\"=5'	
VERTICAL SCALE	DESIGNATION
SURVEY BOOK	SHEETS
CONTRACT	25 of 47
	PROJECT
	PA-25-001

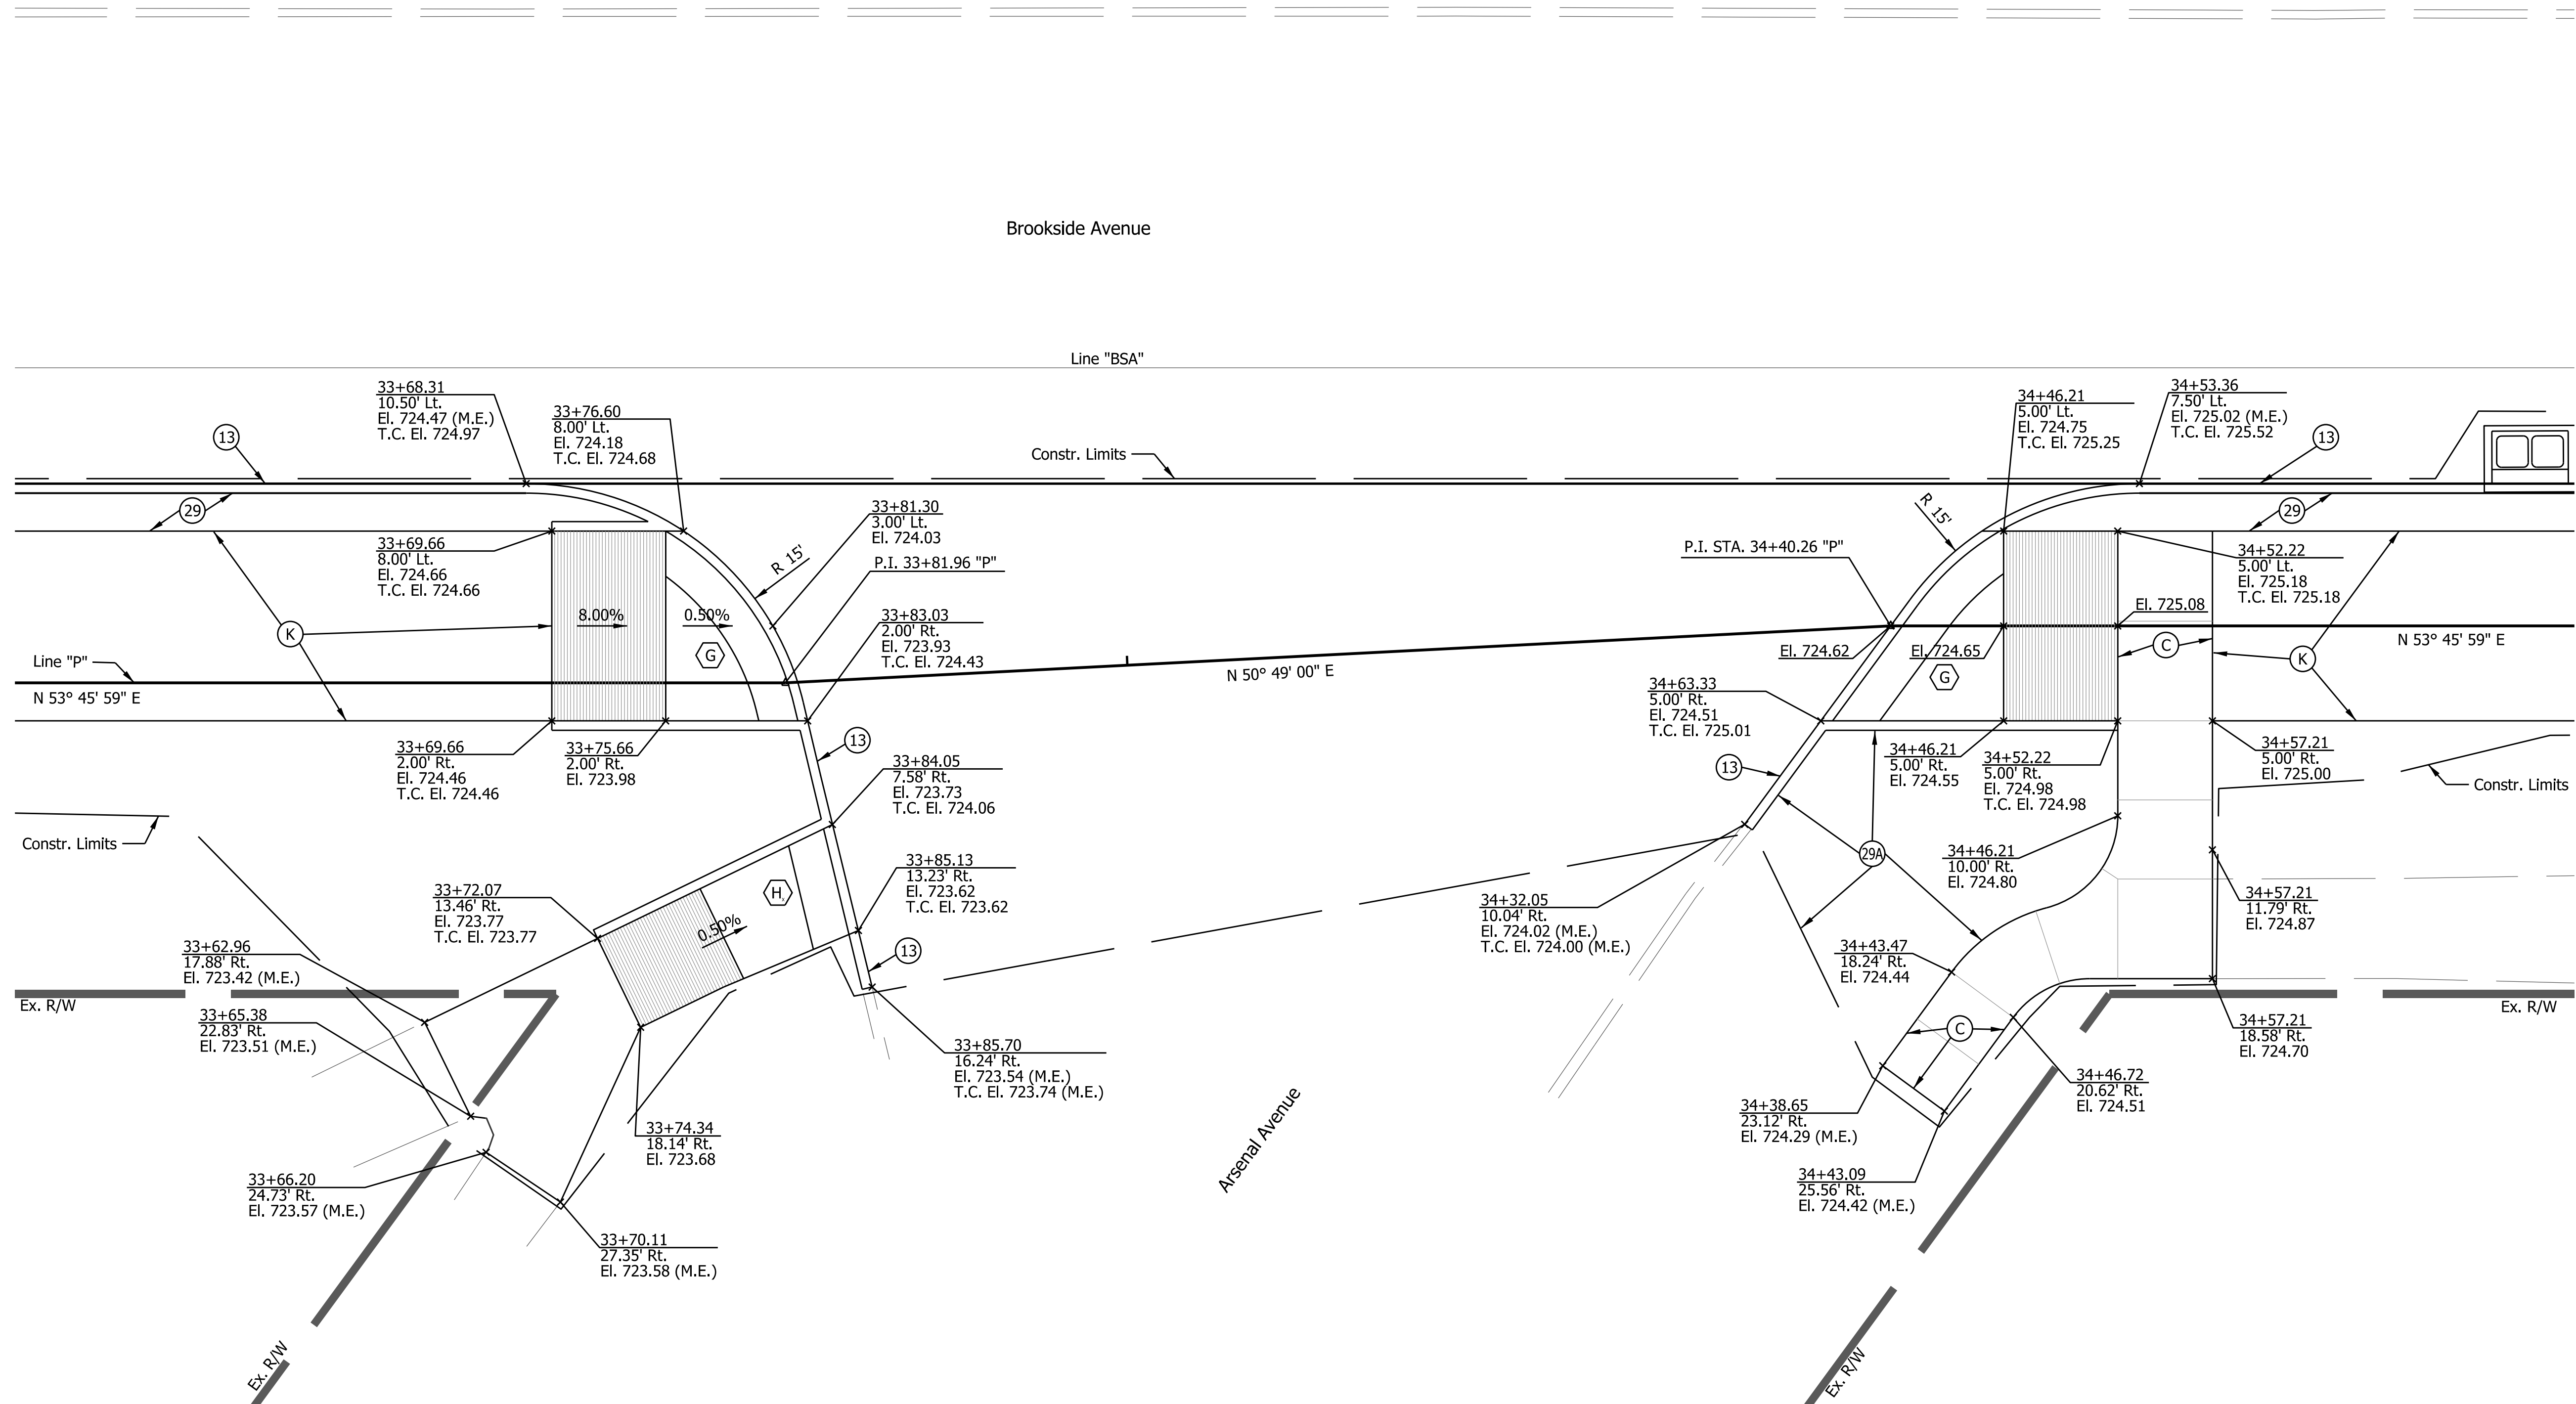

LEGEND

- | | | |
|--|---|---|
| (K) 140 Lb/Yd HMA Surface Type A on 220lb/yard HMA Intermediate, Type A 6" of Compacted Aggregate No. 53. Base | (13) Concrete Curb, 6" (Unless Specified Otherwise) | (G) Curb Ramp, Concrete (Type Indicated by Letter) |
| (C) Sidewalk, Concrete, 4" | (29) Seed Mix, Type "U" | (H) Modified Curb Ramp, Concrete (Type Indicated by Letter) |
| (D) Drive, Concrete | (29A) Mulch | (# XX) Plant Code & Quantity |

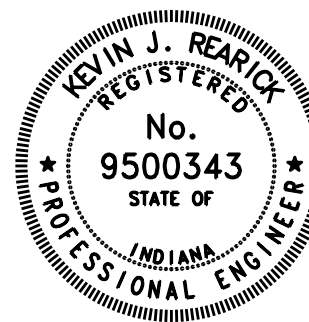


RECOMMENDED FOR APPROVAL		4-16-2015 DATE
DESIGNED: VA	DRAWN: JSS	
CHECKED: ACD	CHECKED: VA	

CITY OF INDIANAPOLIS
DEPARTMENT OF PUBLIC WORKS


CONSTRUCTION DETAIL
CURB RAMP DETAIL

HORIZONTAL SCALE	BRIDGE FILE
1"=5'	
VERTICAL SCALE	DESIGNATION
SURVEY BOOK	SHEETS
CONTRACT	26 of 47
	PROJECT
	PA-25-001

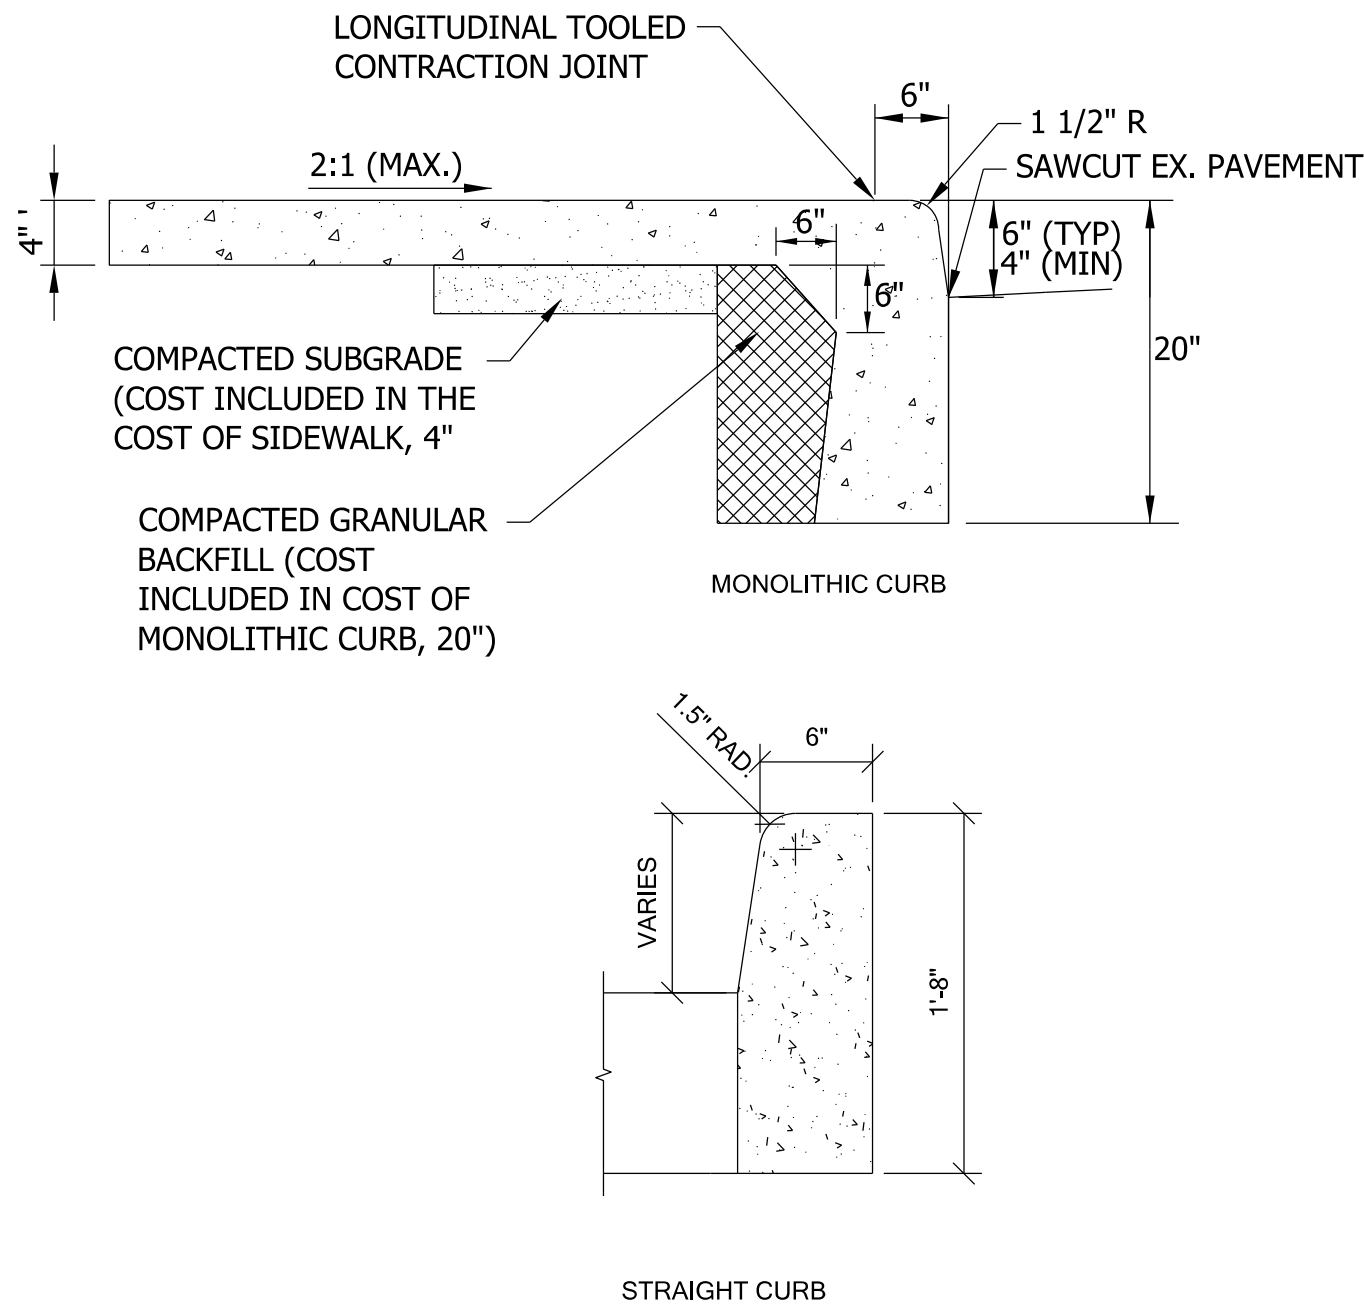


CURB DETAILS

NO SCALE

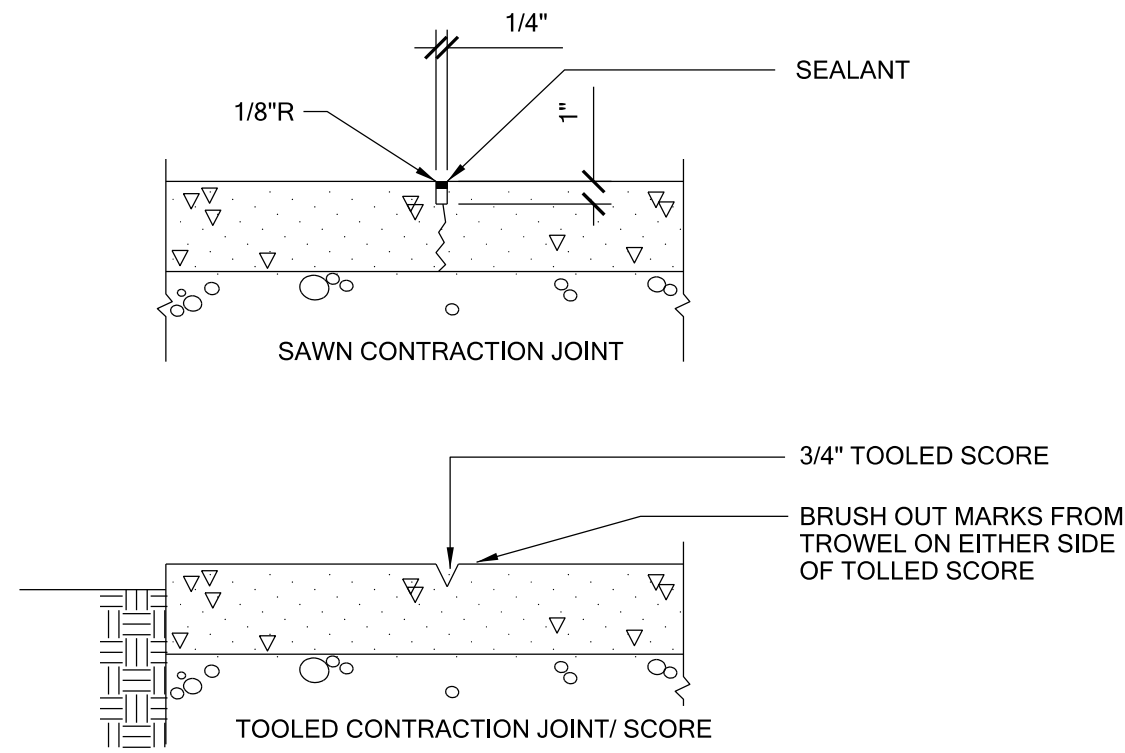



CONCRETE JOINTS

NO SCALE

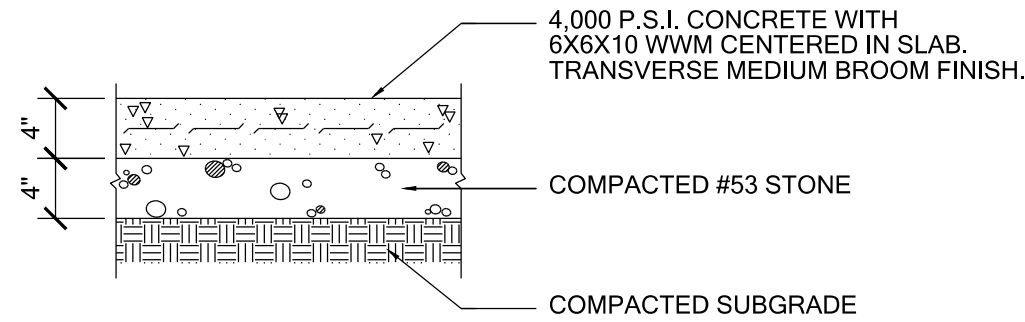


CONCRETE PAVEMENT

NO SCALE

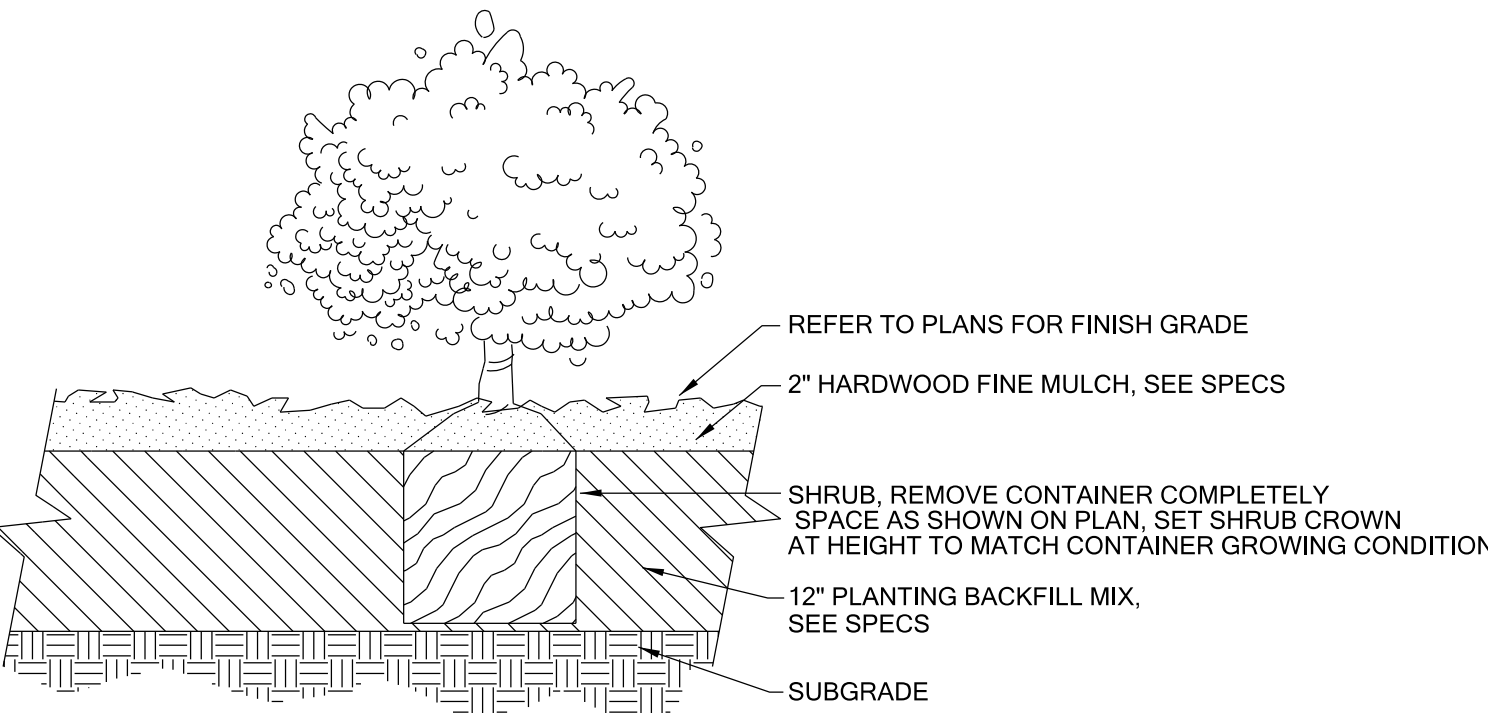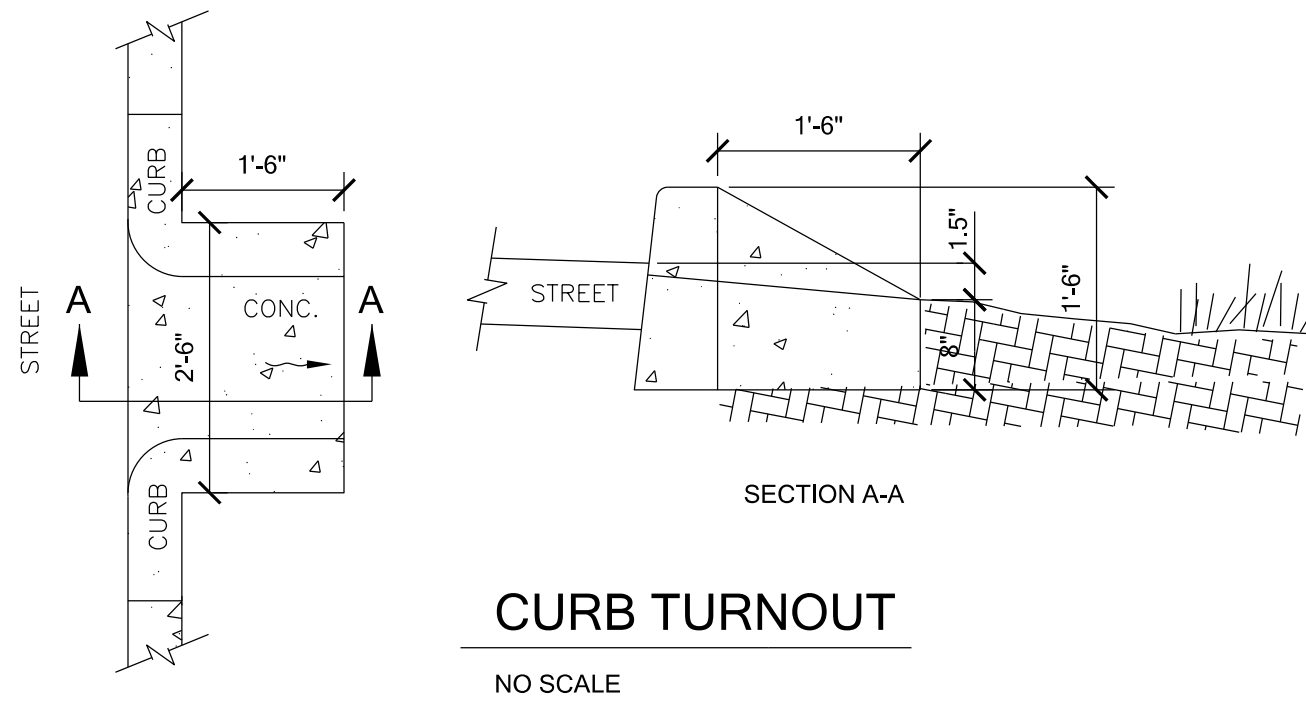

SHRUB PLANTING

NO SCALE

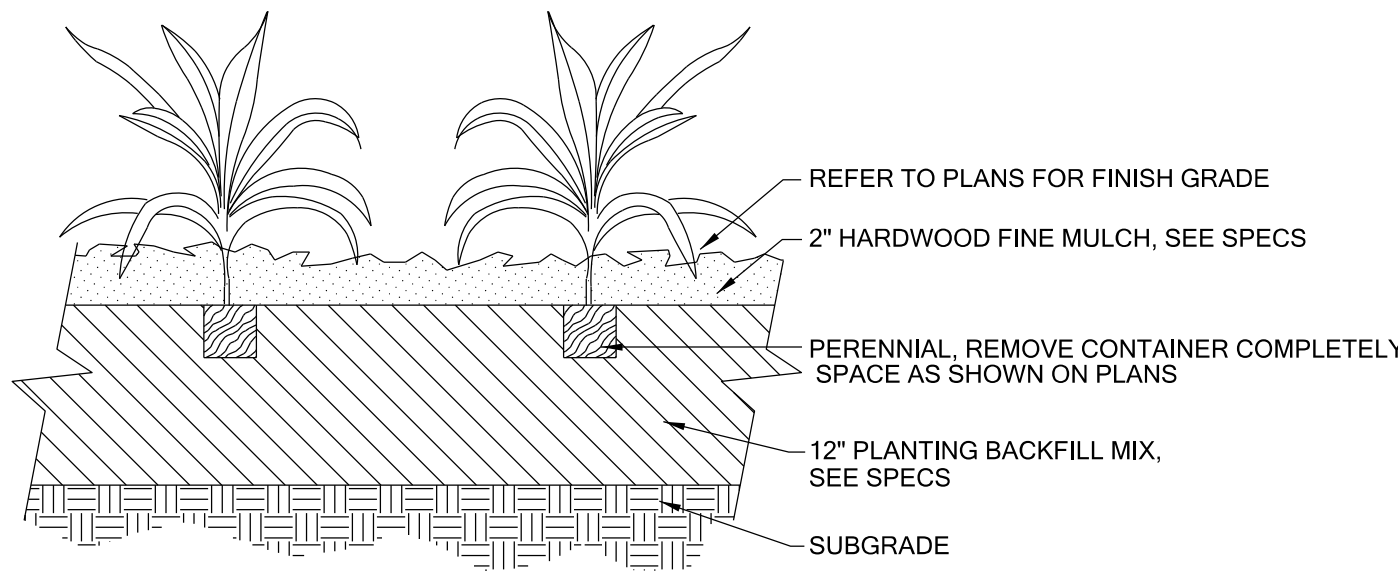

PERENNIAL PLANTING

NO SCALE



RECOMMENDED FOR APPROVAL

DESIGN ENGINEER

4-16-2015
DATE

DESIGNED: VA

DRAWN: JSS

CHECKED: ACD

CHECKED: VA

CITY OF INDIANAPOLIS
DEPARTMENT OF PUBLIC WORKS

SITE DETAILS

HORIZONTAL SCALE

BRIDGE FILE

VERTICAL SCALE

DESIGNATION


SURVEY BOOK

SHEETS


CONTRACT

PROJECT


PA-25-001

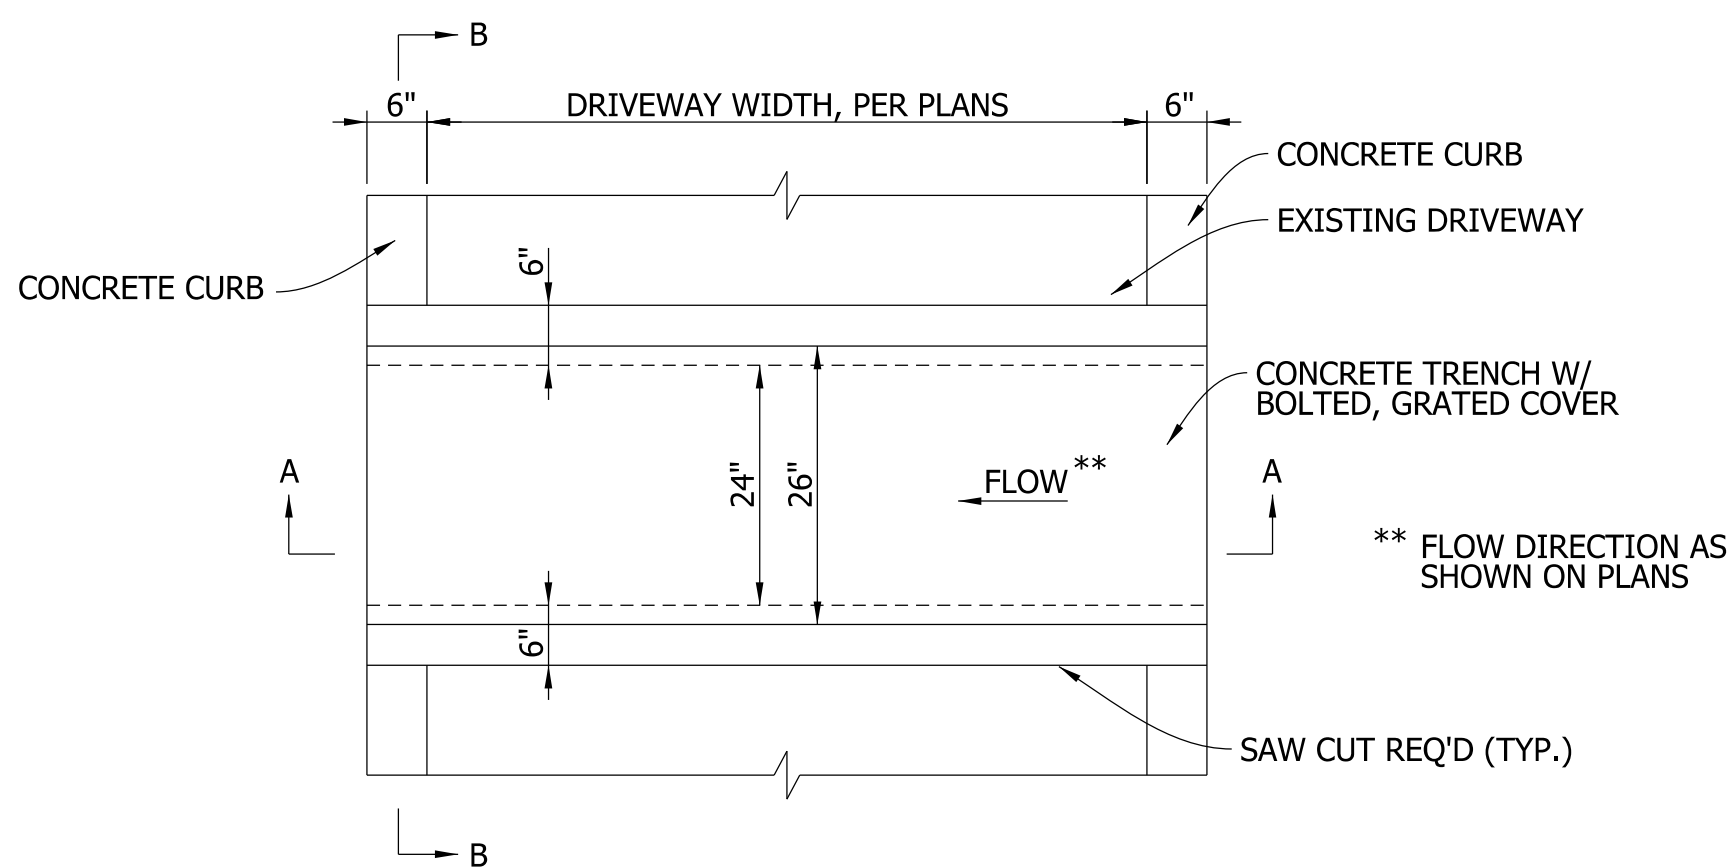

PLAN VIEW

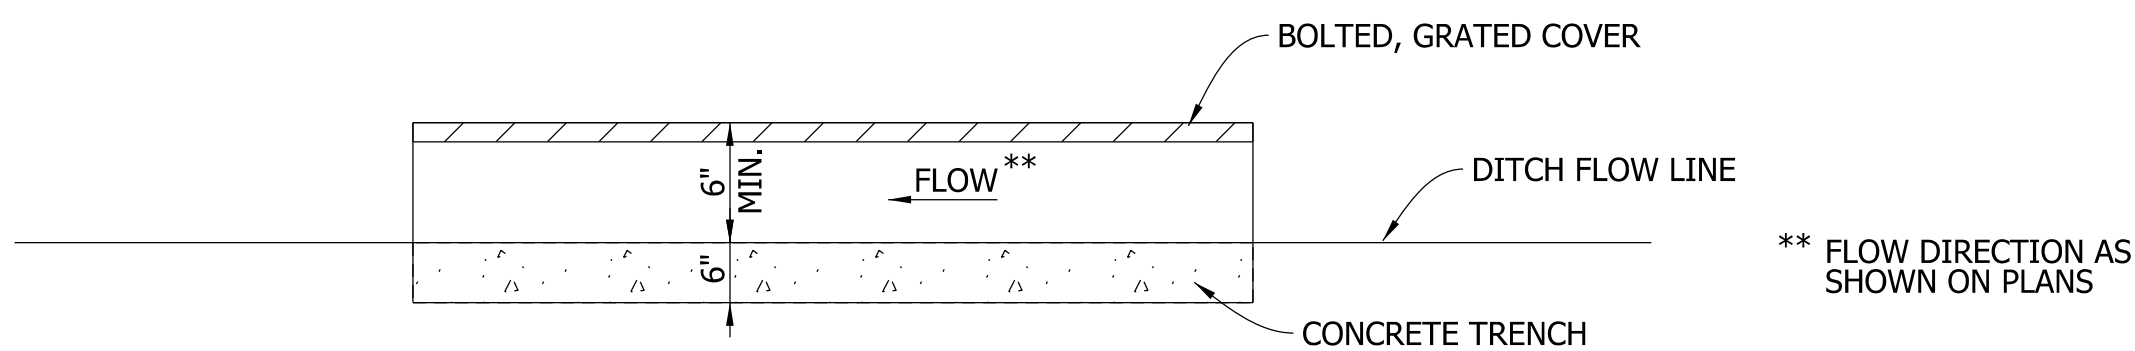


SECTION A-A

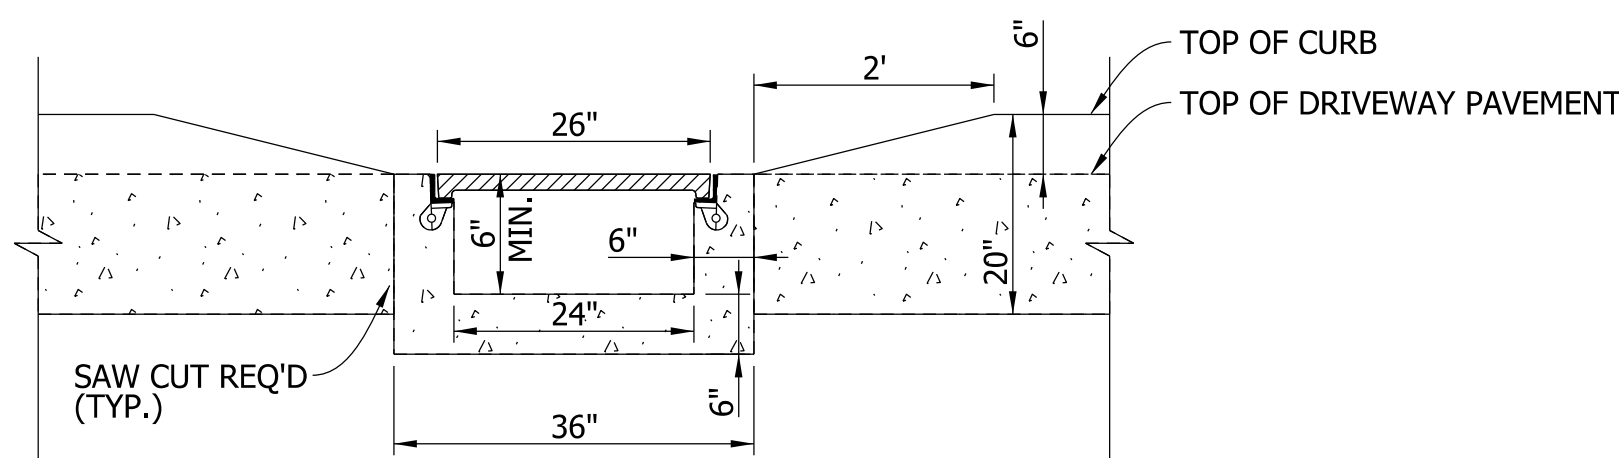

SECTION B-B

TRENCH DRAIN

N.T.S.

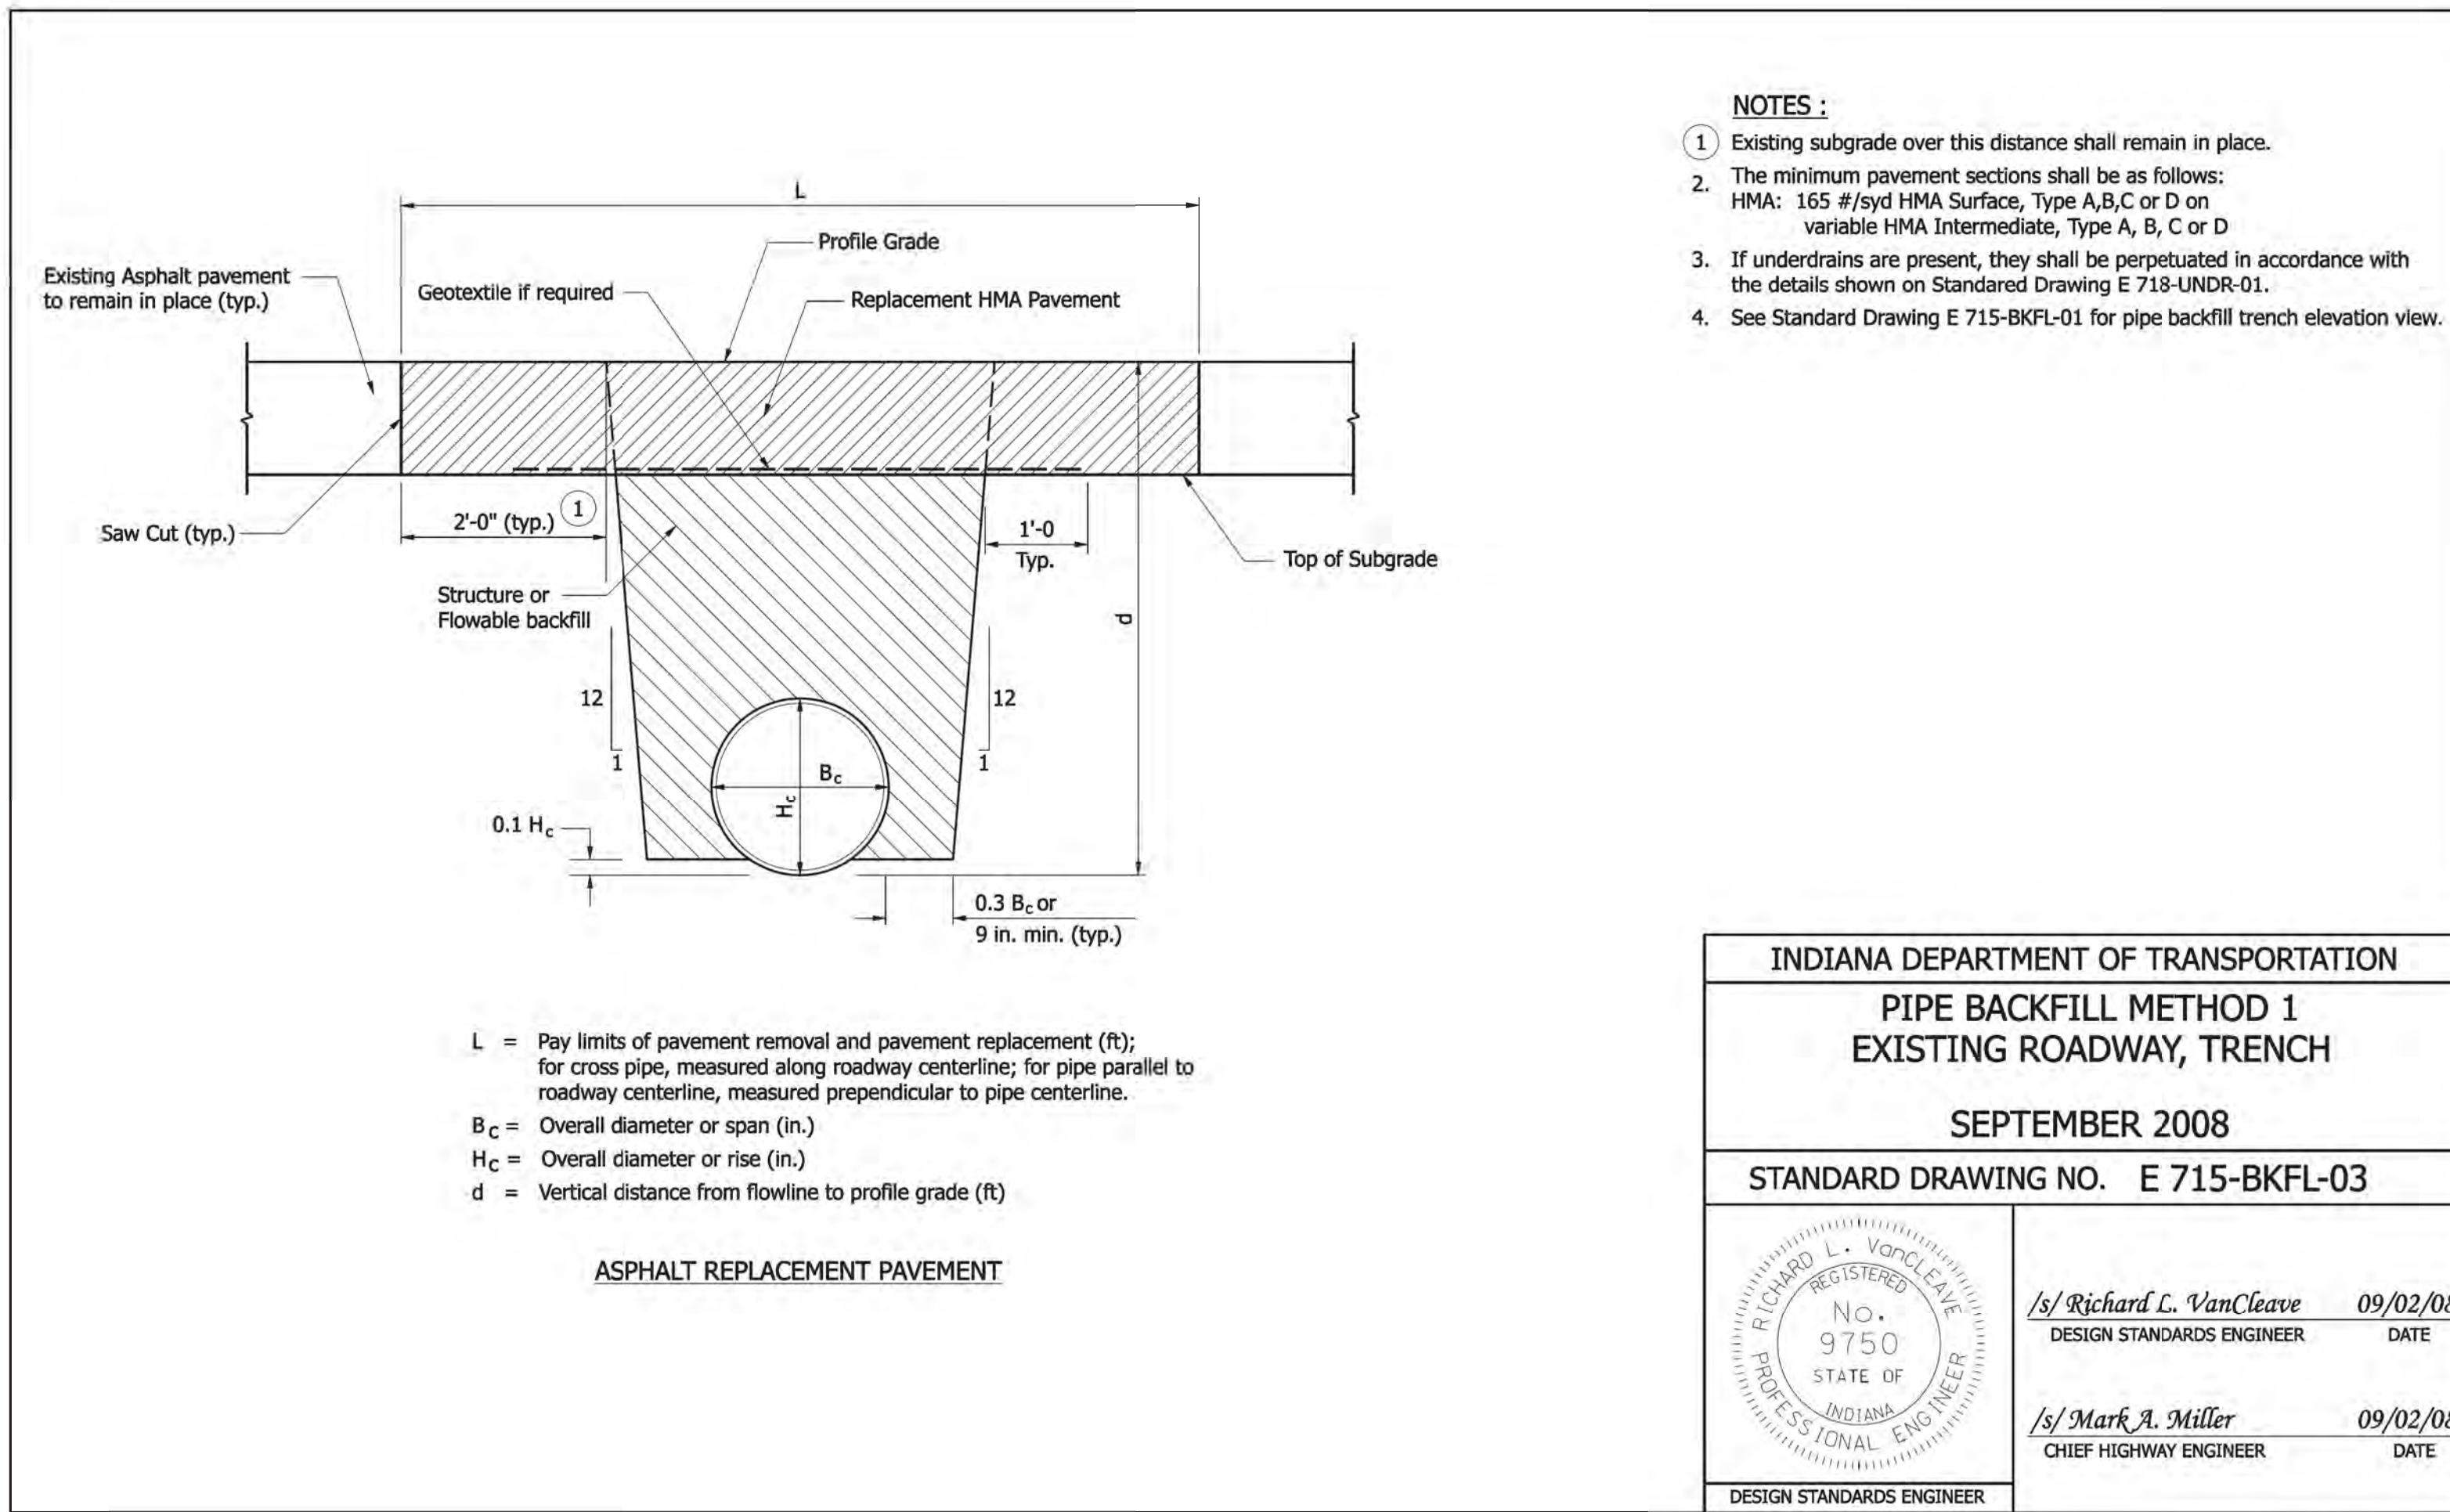

INDIANA DEPARTMENT OF TRANSPORTATION	
PIPE BACKFILL METHOD 1 EXISTING ROADWAY, TRENCH	
SEPTEMBER 2008	
STANDARD DRAWING NO. E 715-BKFL-03	
	/s/ Richard L. VanCleave 09/02/08 DESIGN STANDARDS ENGINEER DATE
	/s/ Mark A. Miller 09/02/08 CHIEF HIGHWAY ENGINEER DATE
DESIGN STANDARDS ENGINEER	





RECOMMENDED FOR APPROVAL		4-16-2015 DATE
DESIGNED: VA	DRAWN: JSS	
CHECKED: ACD	CHECKED: VA	


CITY OF INDIANAPOLIS
DEPARTMENT OF PUBLIC WORKS

MISCELLANEOUS DETAILS


HORIZONTAL SCALE	BRIDGE FILE
VERTICAL SCALE	DESIGNATION
SURVEY BOOK	SHEETS
CONTRACT	28 of 47
	PROJECT
	PA-25-001

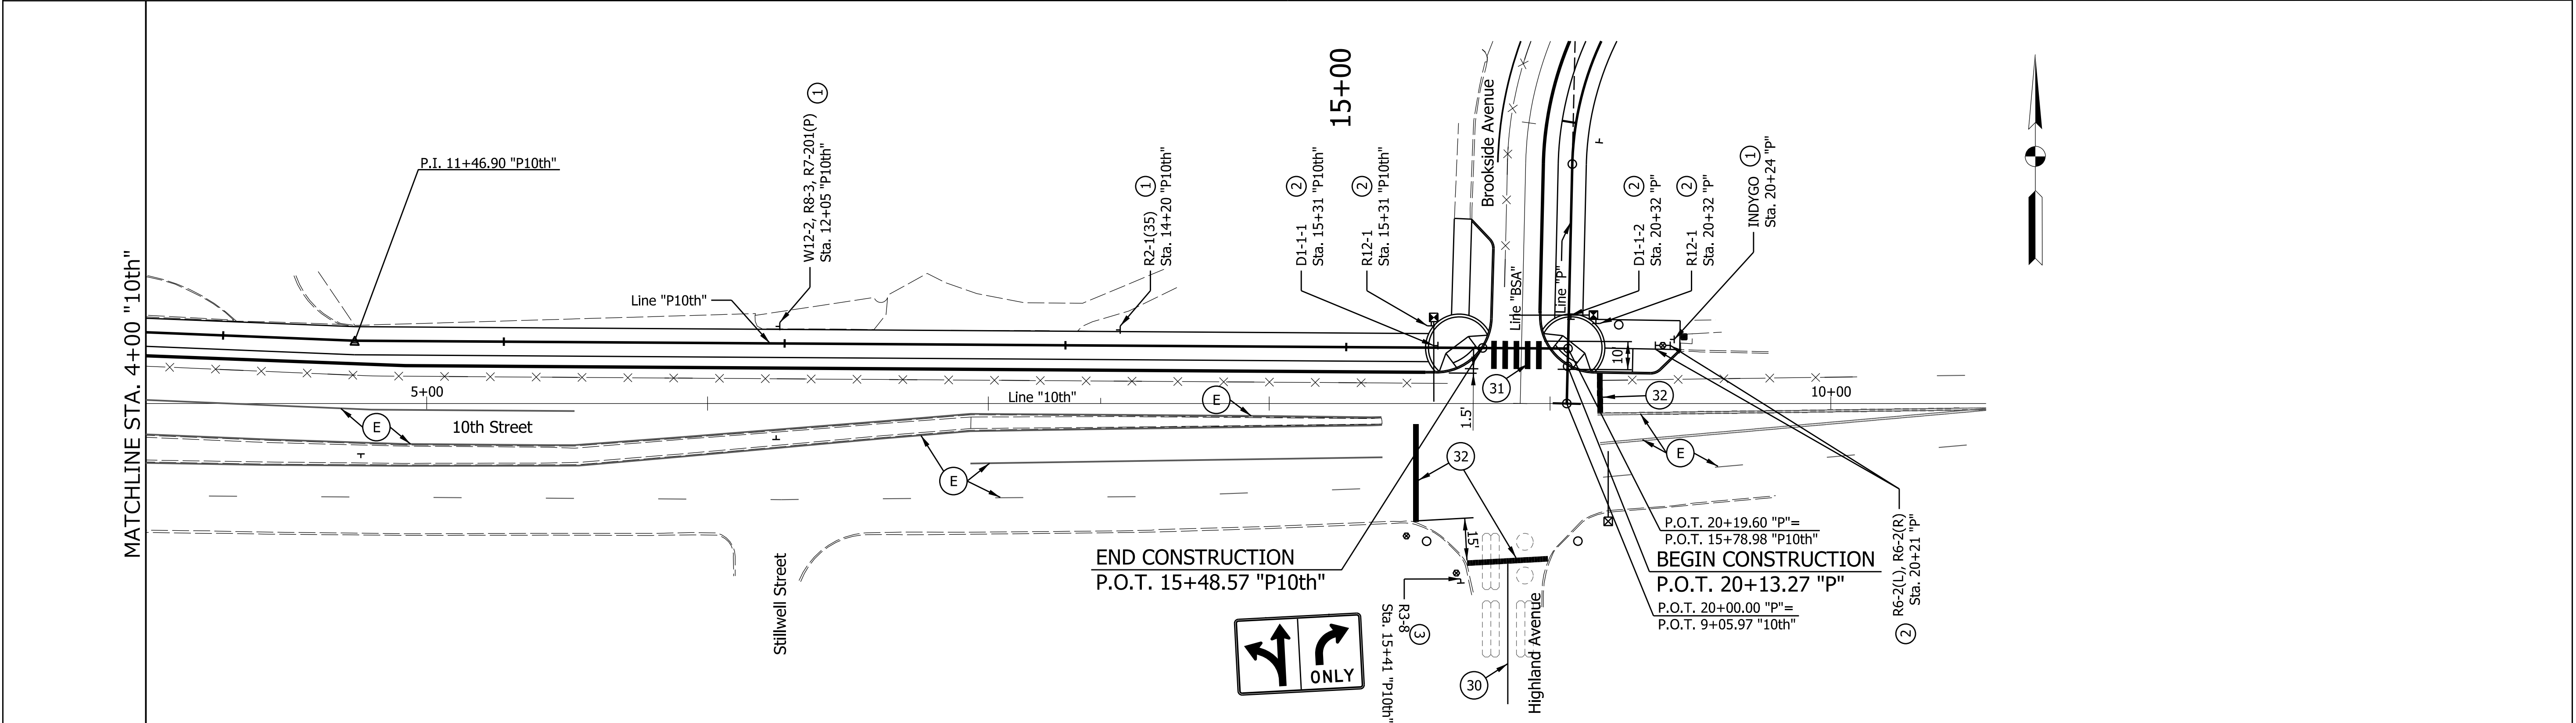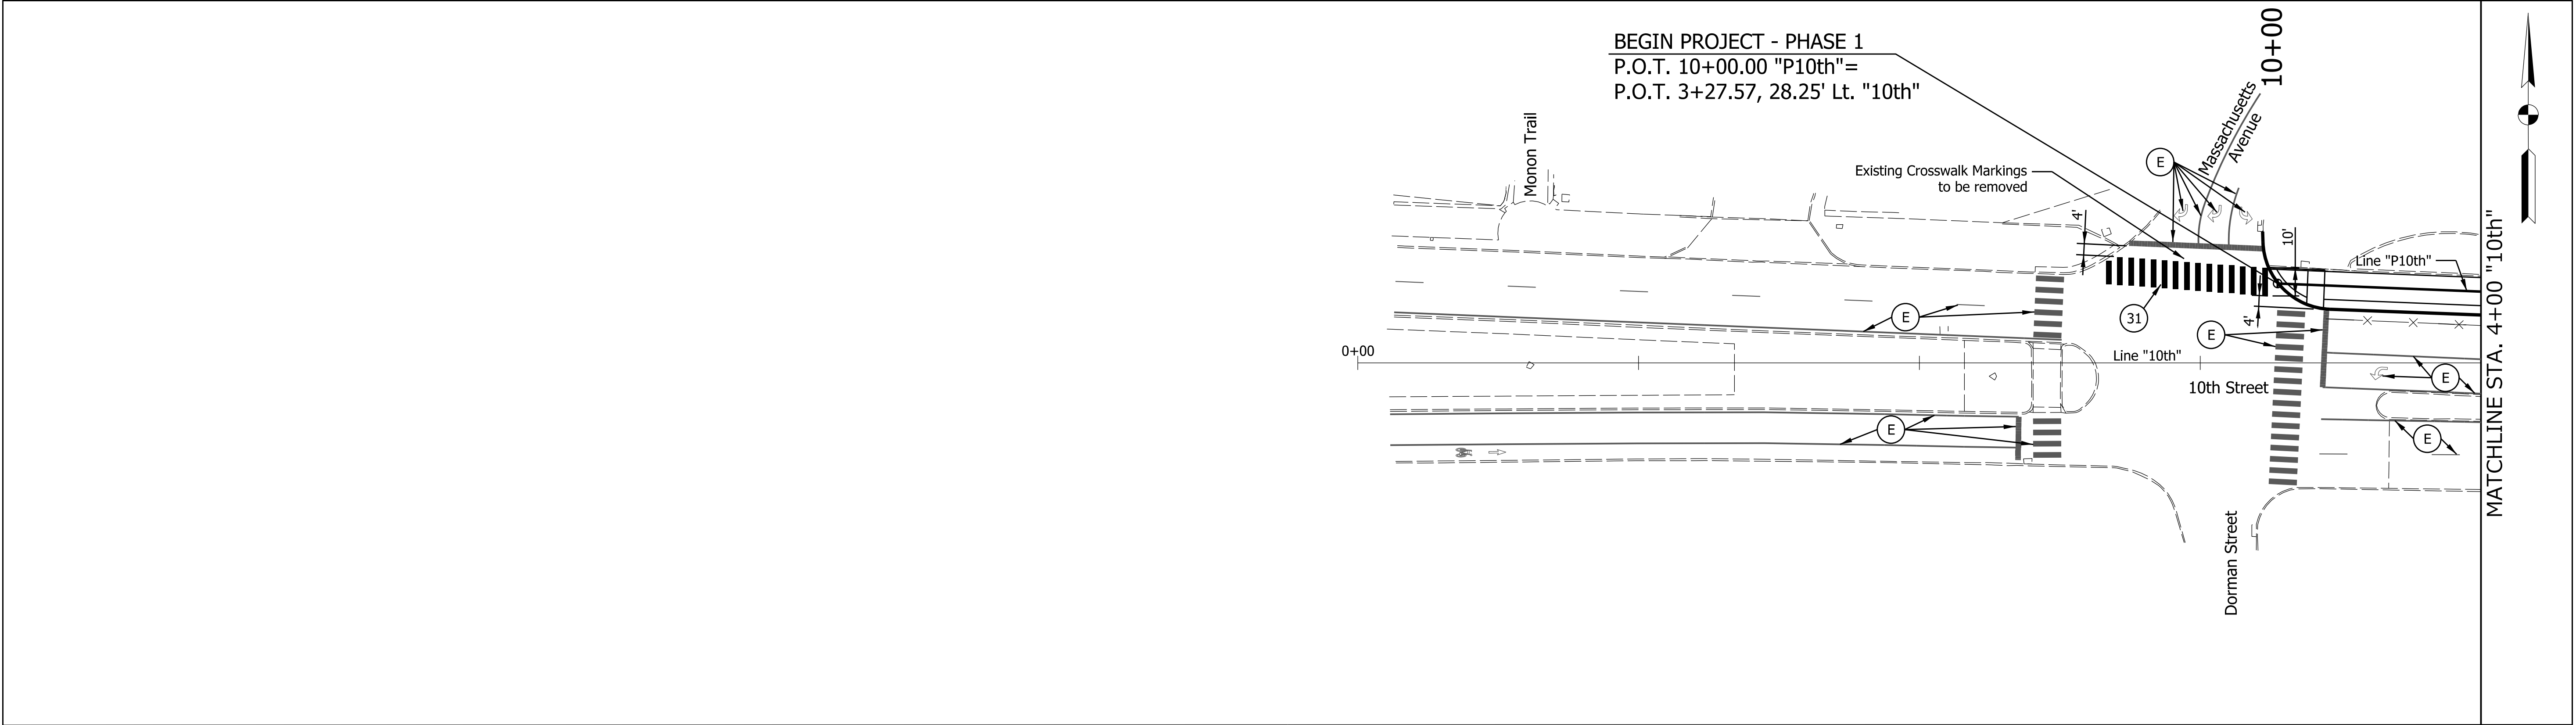

LEGEND			CITY OF INDIANAPOLIS DEPARTMENT OF PUBLIC WORKS		HORIZONTAL SCALE 1" = 30'	BRIDGE FILE
1	No Changes Required to Existing Sign and Supports	30	Line, Solid, White, 4"	E	Existing Pavement Marking, to Remain	DESIGNATION
2	Existing Sign to be Relocated on New Supports	31	Transverse Marking, Crosswalk Line, White, 24"	—X—	Existing Pavement Marking Removal	SURVEY BOOK
3	Proposed Sign on New Supports	32	Stop Line, White, 24"			SHEETS 29 of 47
			PAVEMENT MARKING & SIGN DETAILS LINE "P10th"		CONTRACT	PROJECT PA-25-001

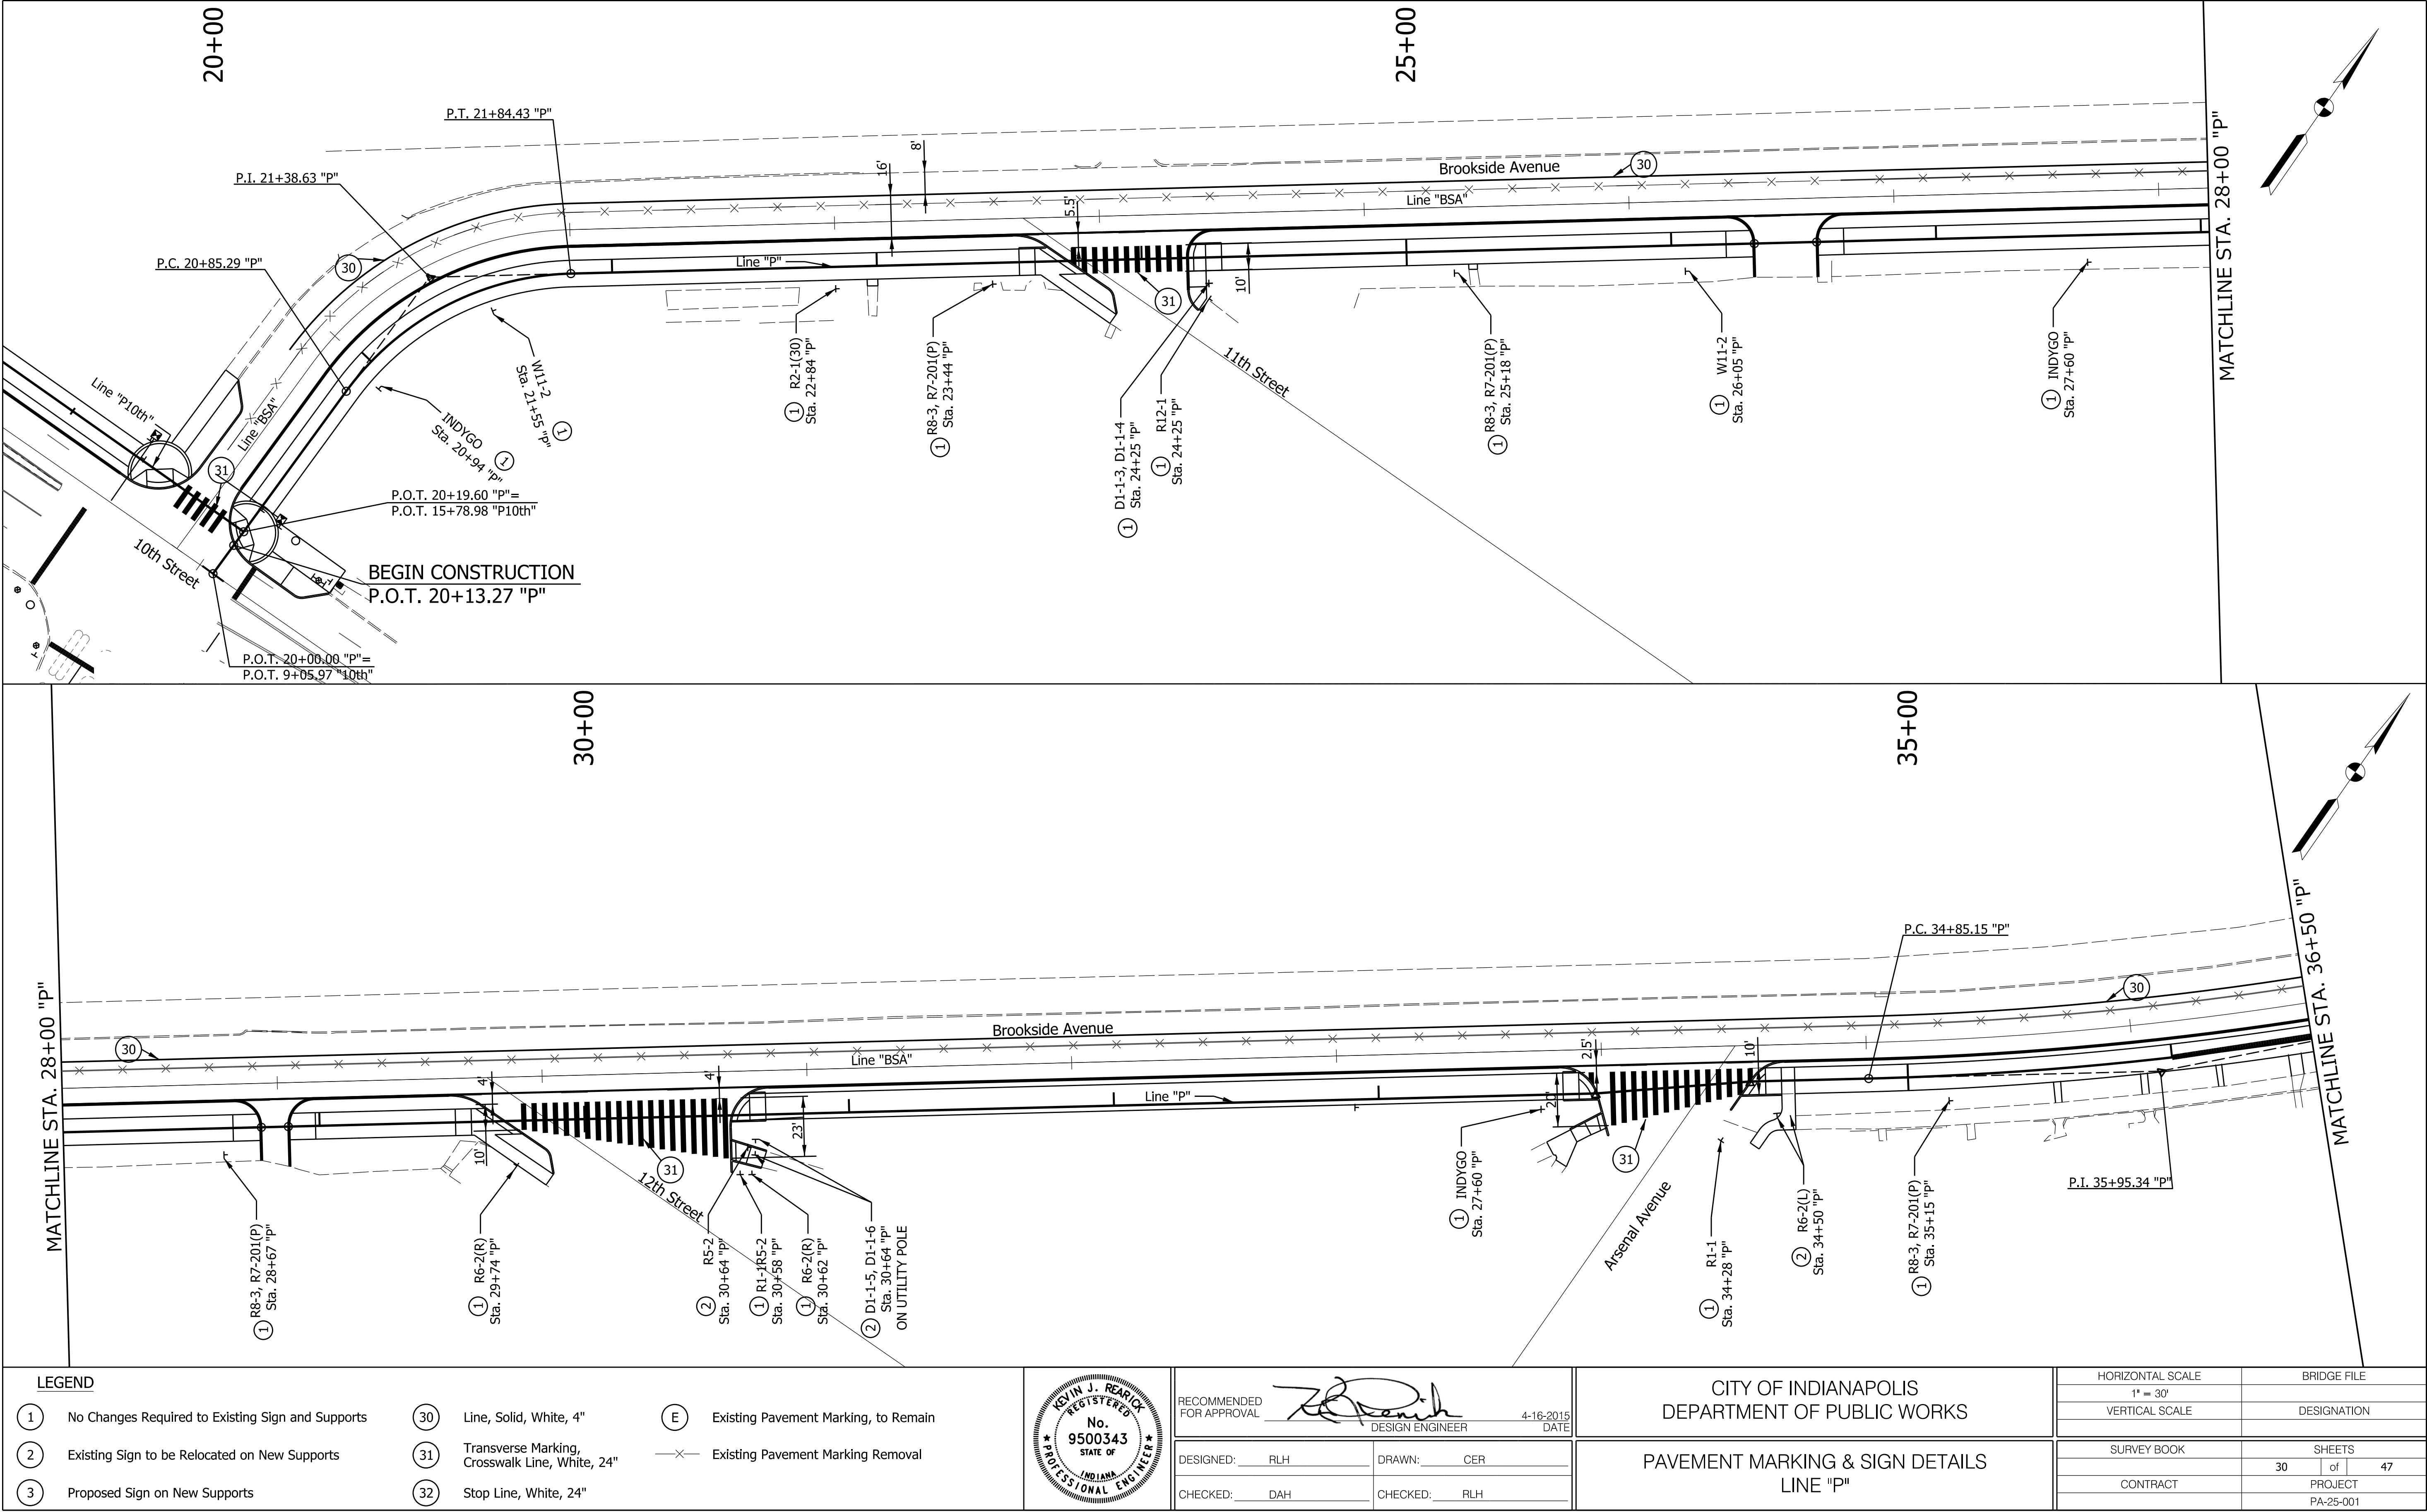


LEGEND			
①	No Changes Required to Existing Sign and Supports	③①	Line, Solid, White, 4"
②	Existing Sign to be Relocated on New Supports	③②	Transverse Marking, Crosswalk Line, White, 24"
③	Proposed Sign on New Supports	③③	Stop Line, White, 24"
④		④	Existing Pavement Marking, to Remain
⑤		⑤	Existing Pavement Marking Removal


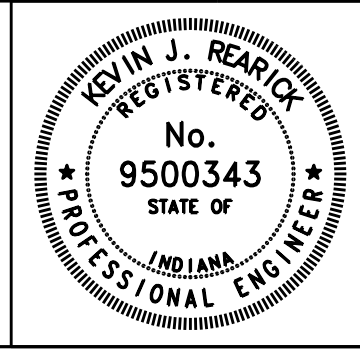


RECOMMENDED FOR APPROVAL		DESIGN ENGINEER	4-16-2015	DATE
DESIGNED:	RLH	DRAWN:	CER	
CHECKED:	DAH	CHECKED:	RLH	

CITY OF INDIANAPOLIS DEPARTMENT OF PUBLIC WORKS
PAVEMENT MARKING & SIGN DETAILS LINE "P"

HORIZONTAL SCALE 1" = 30'	BRIDGE FILE
VERTICAL SCALE	DESIGNATION
SURVEY BOOK	SHEETS
CONTRACT	30 of 47
	PROJECT
	PA-25-001

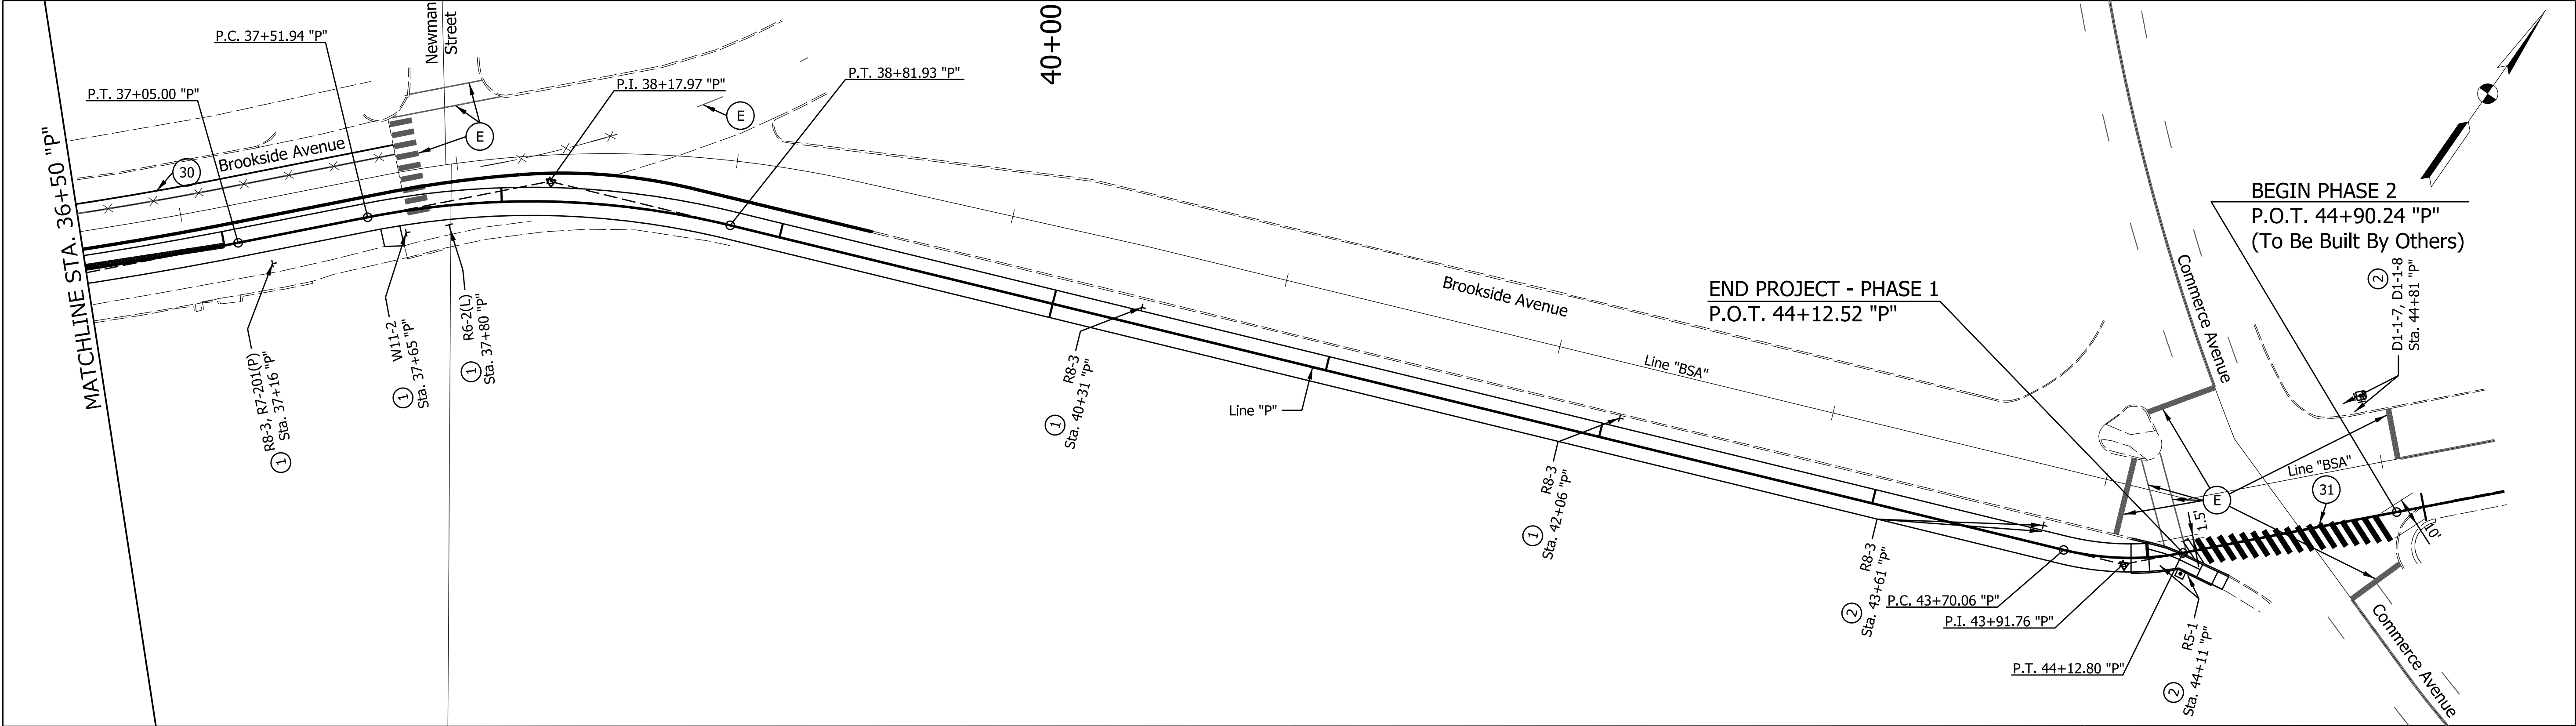

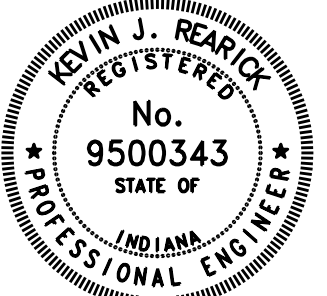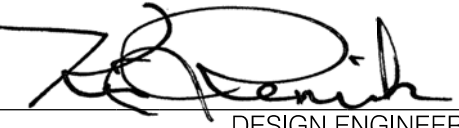LEGEND				RECOMMENDED FOR APPROVAL  DESIGN ENGINEER 4-16-2015 DATE	CITY OF INDIANAPOLIS DEPARTMENT OF PUBLIC WORKS	HORIZONTAL SCALE 1" = 30'		BRIDGE FILE	
①	No Changes Required to Existing Sign and Supports	③①				VERTICAL SCALE		DESIGNATION	
②	Existing Sign to be Relocated on New Supports	③②				SURVEY BOOK		SHEETS	
③	Proposed Sign on New Supports					CONTRACT		31 of 47 PROJECT PA-25-001	



SIGN COLOR CHART

NO SCALE



POGUES RUN LOGO
NO SCALE

NOTES:

1. TRAIL NAME PANEL SHOWN AS EXAMPLE ONLY. ACTUAL PANEL SHALL CONFORM TO SIGN DETAILS AND READ "POGUES RUN TRAIL", PANEL BACKGROUND COLOR SHALL BE TRAIL YELLOW.
2. SIGNS SHALL CONFORM TO INDY PARKS AND RECREATION TRAIL SIGN STANDARDS.
3. SEE TECHNICAL SPECIFICATIONS FOR DETAILED MATERIALS, SUBMITTAL, AND FABRICATION REQUIREMENTS.

NO.	MILE MARKERS		EMERGENCY CODE
	MILE	Km	
1	0.00	0.0	POØA
2	0.25	0.4	POØB
3	0.50	0.8	POØC





RECOMMENDED FOR APPROVAL		4-16-2015
DESIGN ENGINEER		DATE
DESIGNED: RLH	DRAWN: CER	
CHECKED: DAH	CHECKED: RLH	

CITY OF INDIANAPOLIS
DEPARTMENT OF PUBLIC WORKS



SIGN DETAILS

HORIZONTAL SCALE	BRIDGE FILE		
VERTICAL SCALE	DESIGNATION		
SURVEY BOOK	SHEETS		
	32	of	47
CONTRACT	PROJECT		
	PA-25-001		

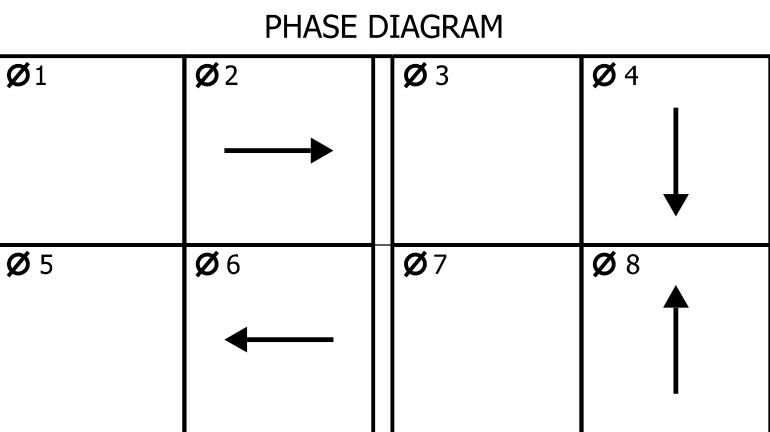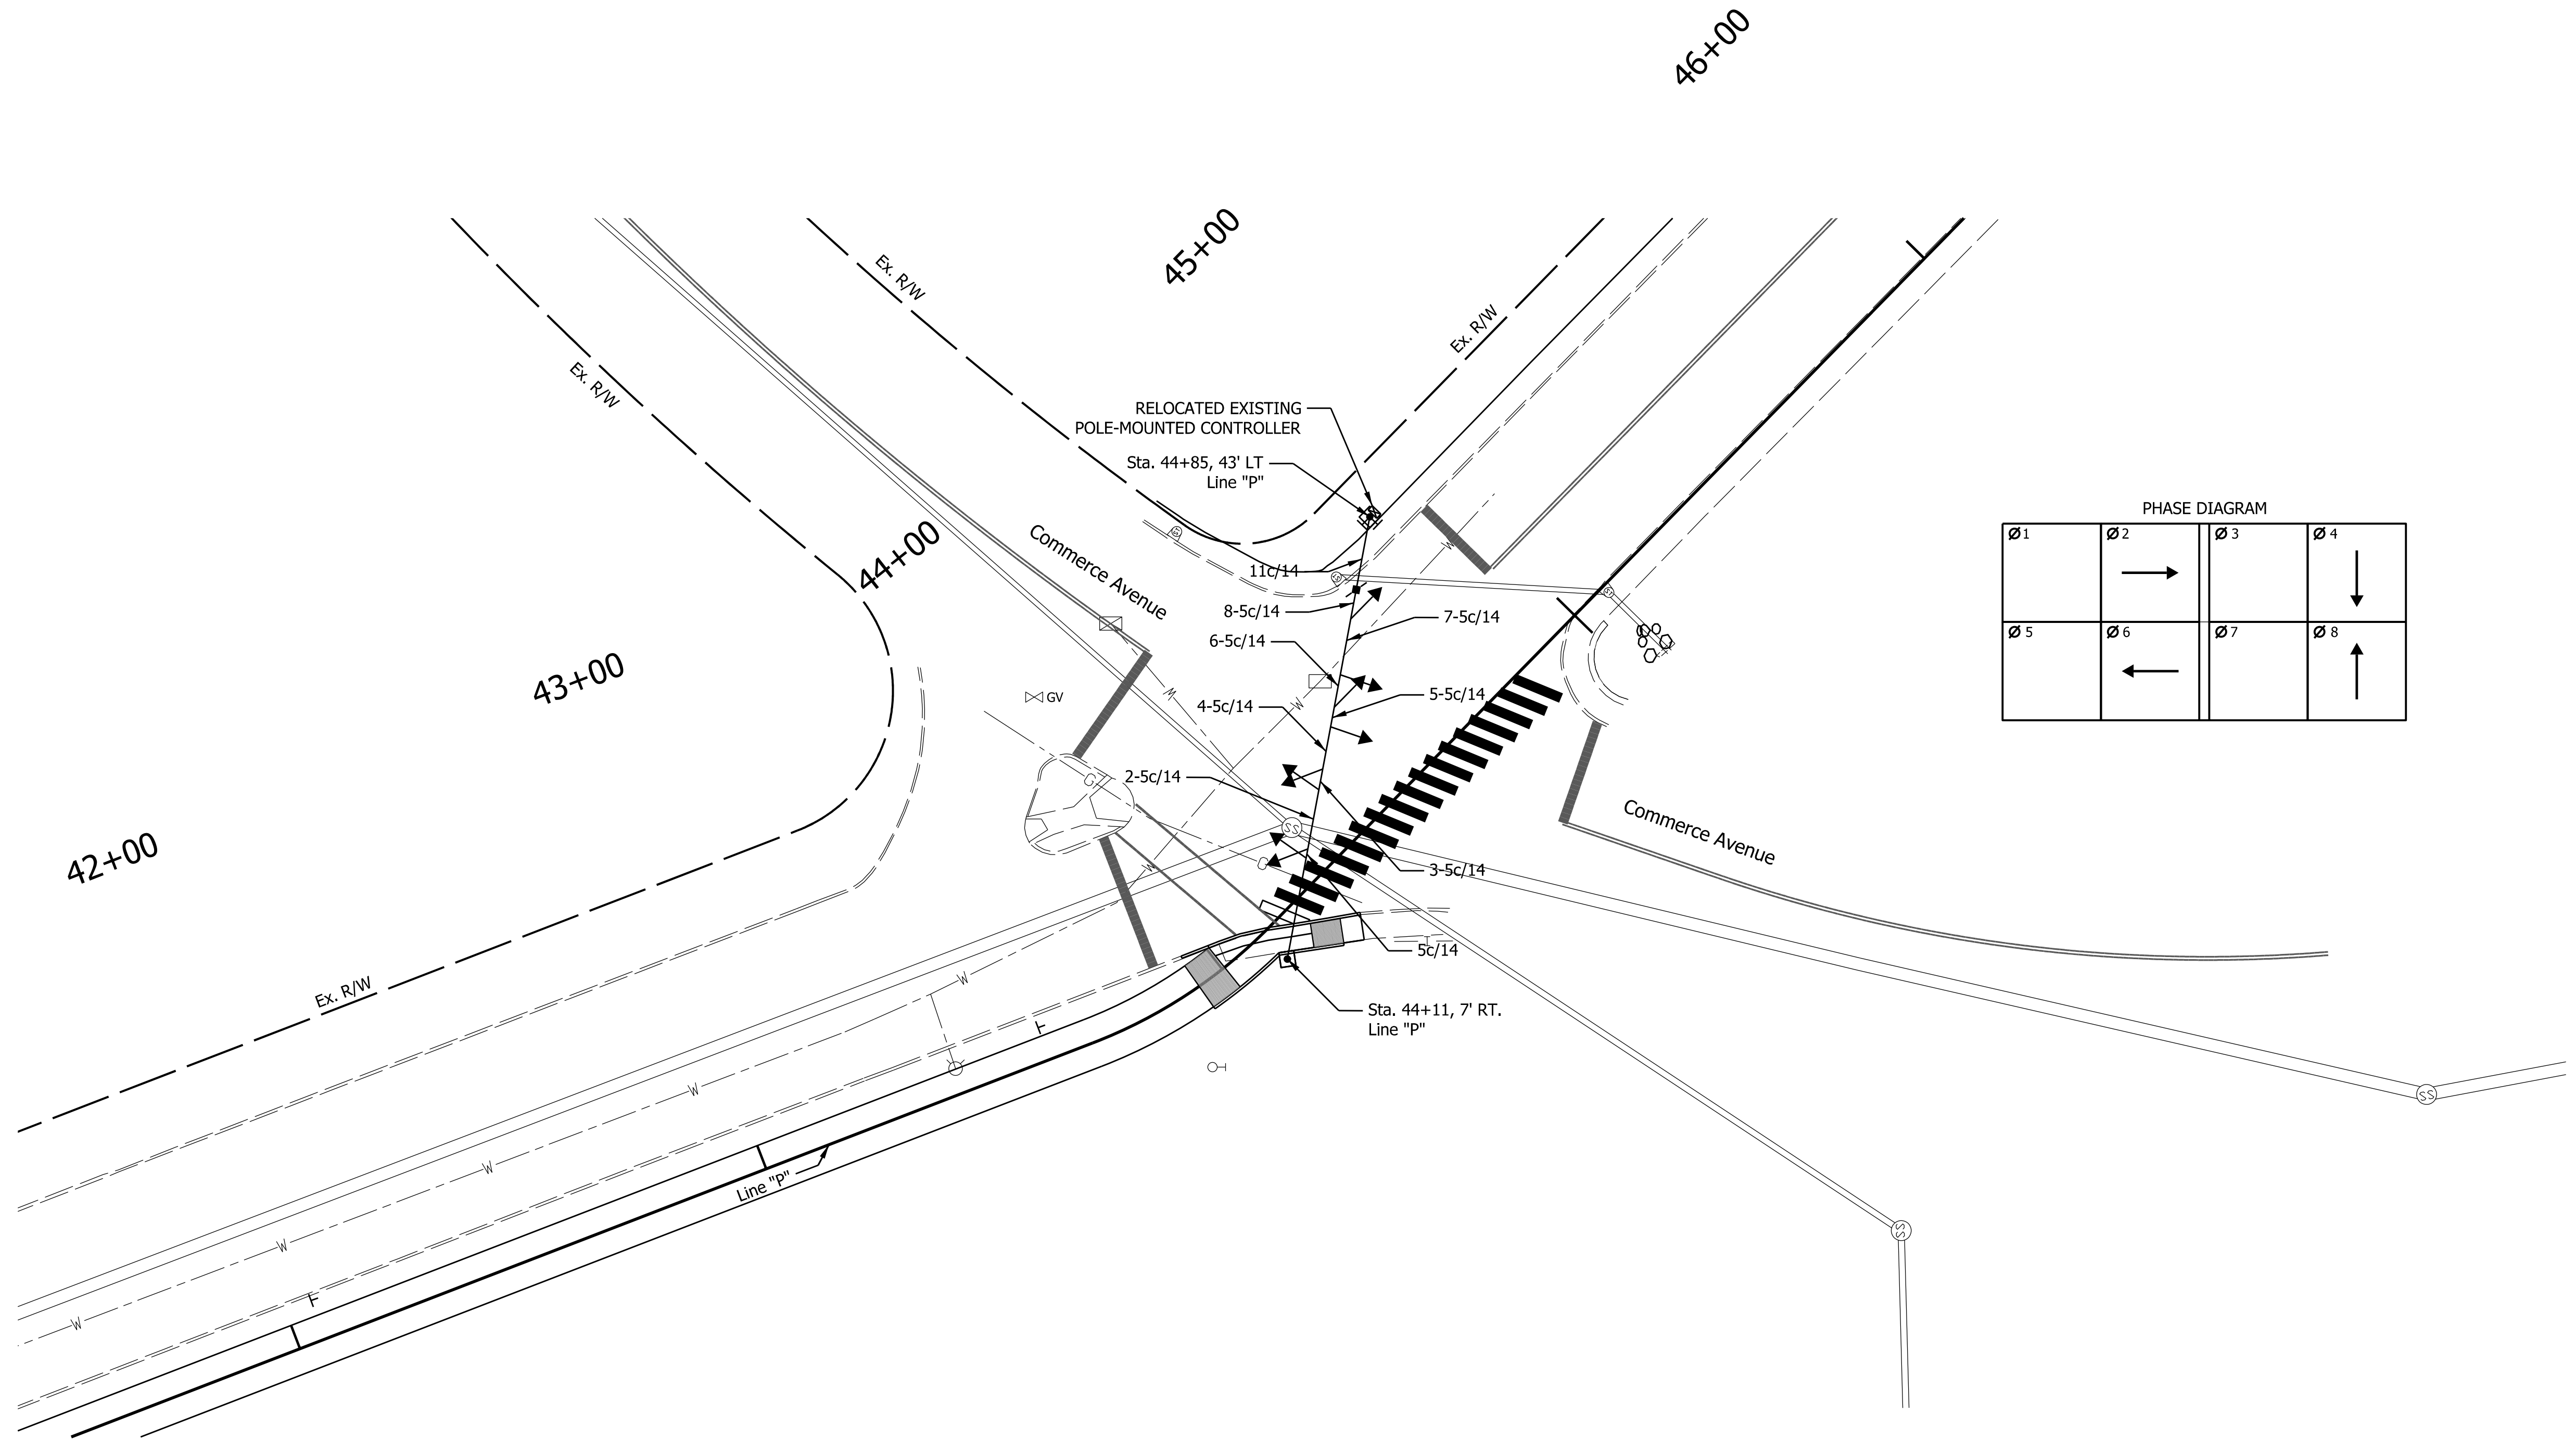


Note:
Remove existing signal equipment.

LEGEND			RECOMMENDED FOR APPROVAL DESIGN ENGINEER 4-16-2015 DATE	CITY OF INDIANAPOLIS DEPARTMENT OF PUBLIC WORKS	HORIZONTAL SCALE	BRIDGE FILE
STEEL STRAIN POLE & FOUNDATION	2" GALVANIZED STEEL CONDUIT				1" = 20'	
SIGNAL CANTILEVER STRUCTURE & FOUNDATION	EX. CONTROLLER AND CABINET ON EX. FOUNDATION				VERTICAL SCALE	DESIGNATION
SIGNAL PEDESTAL ON "A" FOUNDATION	EX. SIGNAL CANTILEVER STRUCTURE & FOUNDATION				N/A	
PEDESTRIAN SIGNAL HEAD WITH PUSH BUTTON, INTERNATIONAL SYMBOLS, 18"	EX. POLE MOUNTED CABINET	---	EX. 2" CONDUIT	SIGNAL MODERNIZATION E. BROOKSIDE AVE. & COMMERCE AVE.	SURVEY BOOK	SHEETS
DISCONNECT HANGER	EX. SIGNAL PEDESTAL ON "A" FOUNDATION	EX. SIGNAL HANDHOLE	EX. PEDESTRIAN SIGNAL HEAD		CONTRACT	34 of 47
					PROJECT PA-25-001	

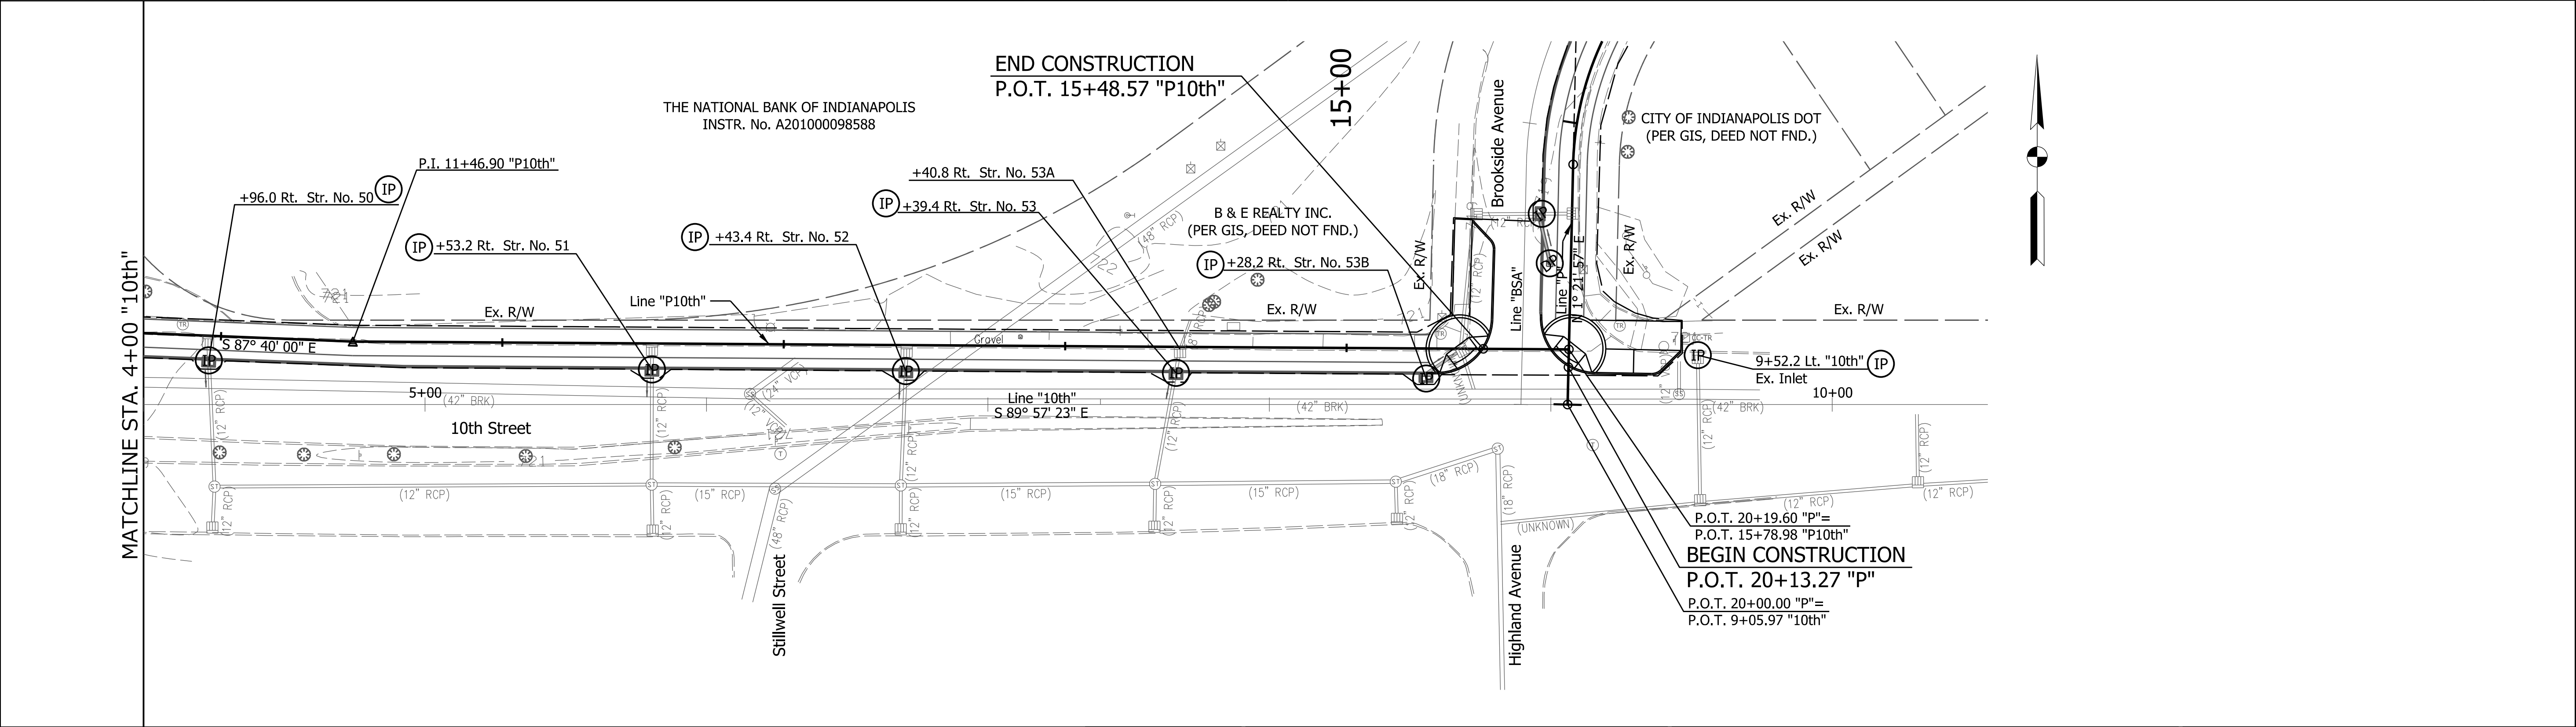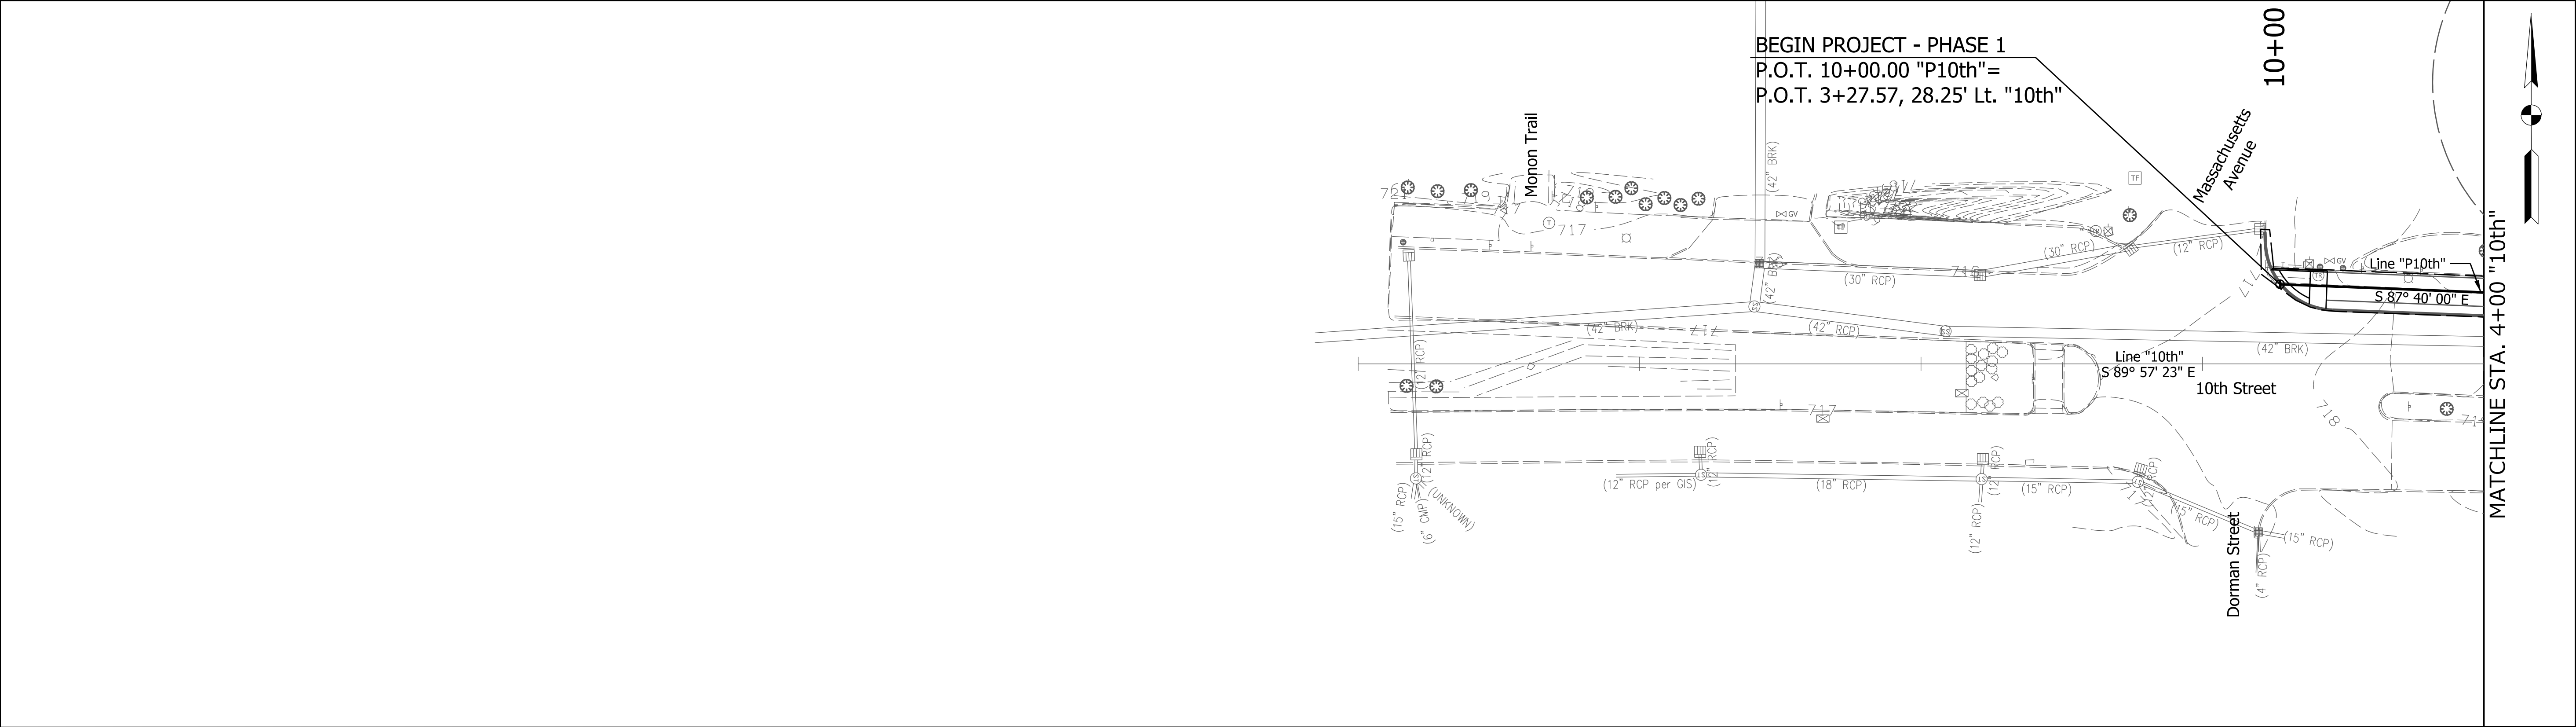


LEGEND —SF— - Silt Fence IP - Inlet Protection DP - Ditch Inlet Protection		RECOMMENDED FOR APPROVAL DESIGN ENGINEER 4-16-2015 DATE	CITY OF INDIANAPOLIS DEPARTMENT OF PUBLIC WORKS TEMPORARY EROSION CONTROL DETAILS LINE "P10th"	HORIZONTAL SCALE	BRIDGE FILE
				1" = 30'	
				VERTICAL SCALE	DESIGNATION
		DESIGNED: VA CHECKED: ACD	DRAWN: JSS CHECKED: VA	SURVEY BOOK	SHEETS
				CONTRACT	35 of 47
					PROJECT PA-25-001

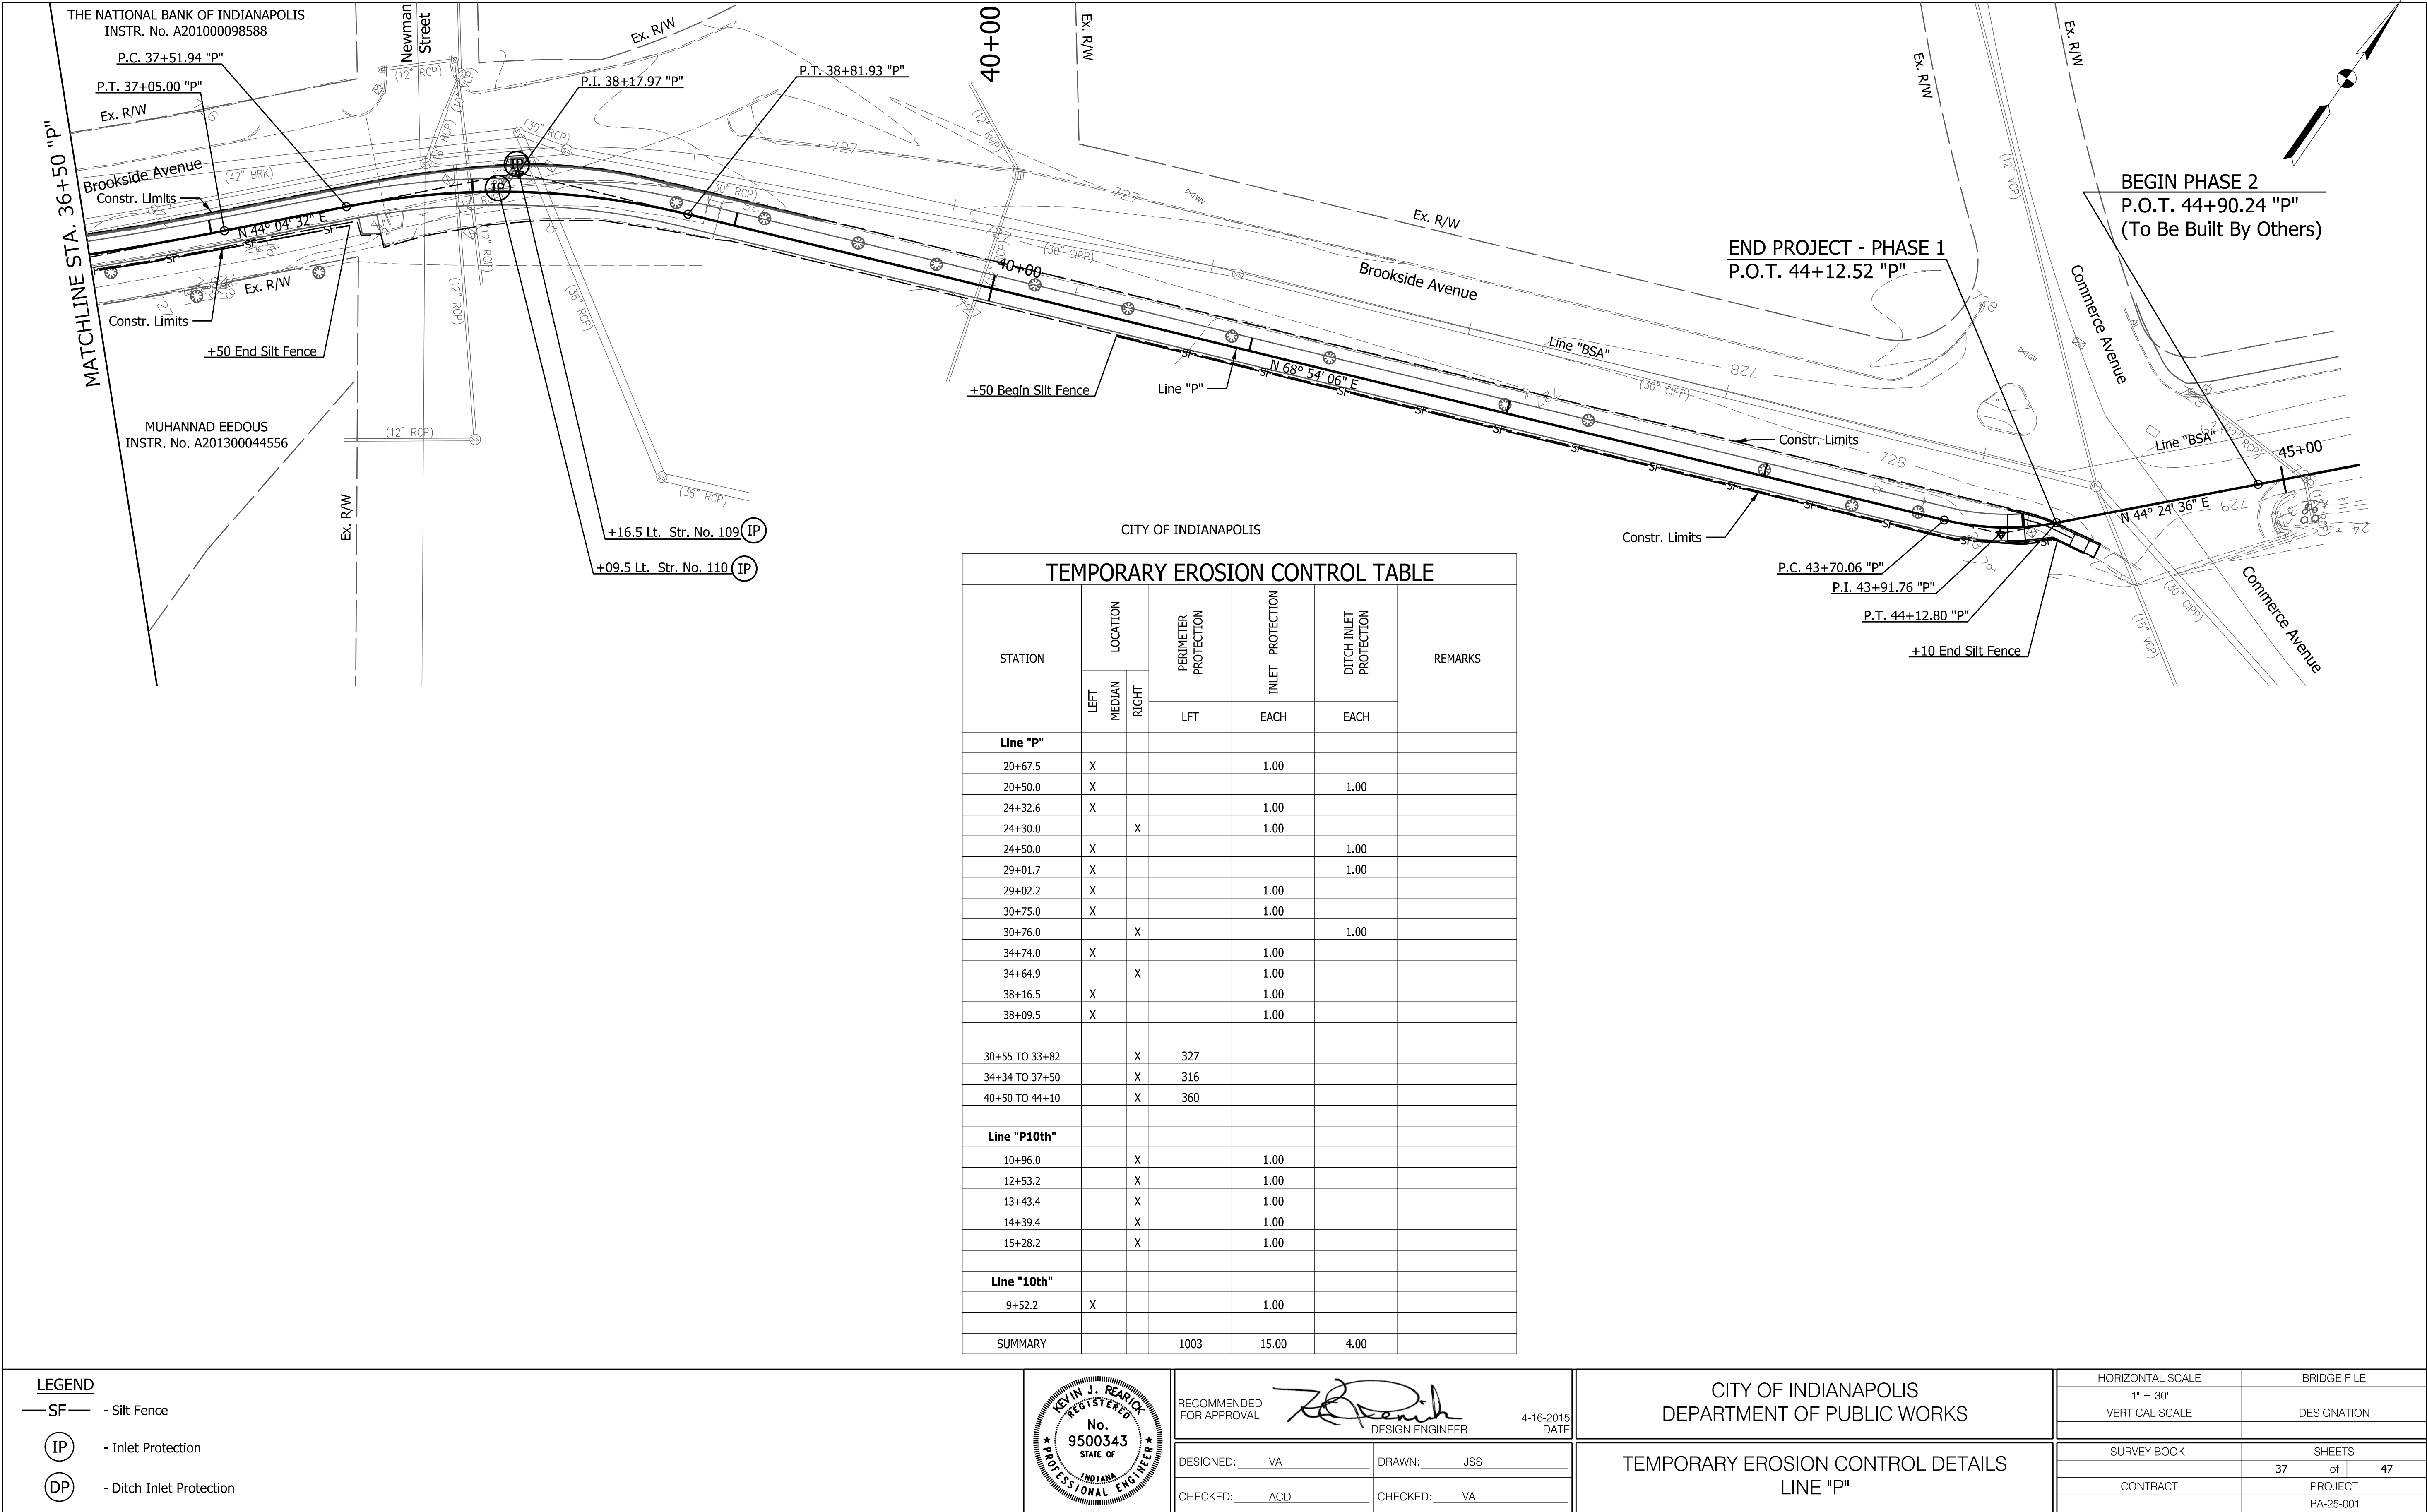

TEMPORARY EROSION CONTROL TABLE							
STATION	LOCATION			PERIMETER PROTECTION	INLET PROTECTION	DITCH INLET PROTECTION	REMARKS
	LEFT	MEDIAN	RIGHT				
				LFT	EACH	EACH	
Line "P"							
20+67.5	X				1.00		
20+50.0	X					1.00	
24+32.6	X				1.00		
24+30.0			X		1.00		
24+50.0	X					1.00	
29+01.7	X					1.00	
29+02.2	X				1.00		
30+75.0	X				1.00		
30+76.0			X			1.00	
34+74.0	X				1.00		
34+64.9			X		1.00		
38+16.5	X				1.00		
38+09.5	X				1.00		
30+55 TO 33+82			X	327			
34+34 TO 37+50			X	316			
40+50 TO 44+10			X	360			
Line "P10th"							
10+96.0			X		1.00		
12+53.2			X		1.00		
13+43.4			X		1.00		
14+39.4			X		1.00		
15+28.2			X		1.00		
Line "10th"							
9+52.2	X				1.00		
SUMMARY				1003	15.00	4.00	

- LEGEND**
- SF— - Silt Fence
 - (IP) - Inlet Protection
 - (DP) - Ditch Inlet Protection

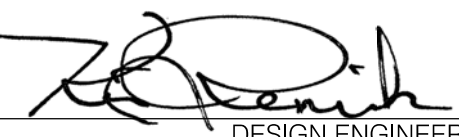

RECOMMENDED FOR APPROVAL  4-16-2015
DESIGN ENGINEER DATE

DESIGNED: VA DRAWN: JSS
CHECKED: ACD CHECKED: VA

CITY OF INDIANAPOLIS
DEPARTMENT OF PUBLIC WORKS

TEMPORARY EROSION CONTROL DETAILS
LINE "P"

HORIZONTAL SCALE	BRIDGE FILE
1" = 30'	DESIGNATION
VERTICAL SCALE	
SURVEY BOOK	SHEETS
CONTRACT	37 of 47
	PROJECT
	PA-25-001

STRUCTURE DATA																													
STRUCTURE NUMBER	LOCATION				SIZE	PIPE TYPE	MANHOLE, CATCH BASIN, INLET, OR SPECIALTY STRUCTURE	LENGTH	SKEW	COVER	FLOWLINE		CASTING	SERVICE LIFE	SITE DESIGNATION	pH	BACKFILL METHOD	STRUCTURAL BACKFILL	RIVETMENT RIPRAP	CONCRETE CLASS A, FOR STRUCTURES	PIPE END SECTION	GRATED BOX END SECTION			SAFETY METAL END SECTION			CONNECT TO STR.	REMARKS
	STATION	LEFT	RIGHT	CROSS							UP STREAM	DOWN STREAM										ELEV.	ELEV.	ELEV.	yr	yd3	Ton		
	LINE "P"				in			ft	DEG.	ft	ELEV.	ELEV.	ELEV.	yr				yd3	Ton	yd3	EACH	TYPE	SLOPE	EACH	SLOPE	EACH			
100	20+67.5	X				Inlet B-15					715.19																	Connect Ex. Pipe	
101	20+50.0	X			12	Pipe Catch Basin	15				717.10	717.00															100		
102	24+32.6	X				Inlet C-15					716.98																	Connect Ex. Pipe	
102A	24+50.0	X			12	Pipe Catch Basin	18																				102		
103	24+30.0		X			Ex. Curb Inlet					716.40																	Cap Ex. Inlet	
103A	26+43.0	X				Trench Drain	26																						
104	29+02.2	X				Inlet C-15					718.88																	Connect Ex. Pipe	
105	29+01.7	X				Pipe Catch Basin																						Connect Ex. Pipe	
105A	29+00.4		X			Ex. Curb Inlet					718.50																	Cap Ex. Inlet	
106	30+75.0	X				Inlet B-15					715.75																	Connect Ex. Pipe	
106A	30+76.0		X			Ex. Curb Inlet																						Replace Casting w/ Type 7	
107	34+74.0	X				Inlet C-15					719.78																	Connect Ex. Pipe	
108	34+64.9		X			Ex. Curb Inlet					718.40																	Cap Ex. Inlet	
109	38+04.0	X			12	Inlet B-15	8				723.00	722.90															110		
110	38+09.5	X				Ex. Curb Inlet					722.90																	Cap Ex. Inlet	
	LINE "P10th"																												
50	10+96.0		X			Inlet J-10					716.09																	Connect Ex. Pipe	
51	12+53.2		X			Inlet J-10					717.13																	Connect Ex. Pipe	
52	13+43.4		X			Inlet J-10					716.83																	Connect Ex. Pipe	
53	14+39.4		X			Inlet K-10					715.48																	Connect Ex. Pipe	
53A	14+40.8		X			Ex. Curb Inlet																						Cap Ex. Inlet	
53B	15+43.0		X			Inlet A-2																						Connect Ex. Pipes	
53C	15+40.6		X			Ex. Curb Inlet																						Cap Ex. Inlet	

KEYIN J. REAGAN

REGISTERED

No.


9500343

STATE OF

INDIANA

PROFESSIONAL ENGINEER

RECOMMENDED FOR APPROVAL

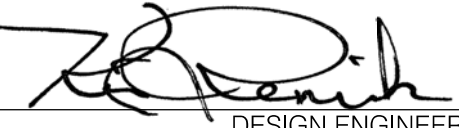

DESIGN ENGINEER

4-16-2015

DATE

CITY OF INDIANAPOLIS

DEPARTMENT OF PUBLIC WORKS

STRUCTURE DATA TABLE

HORIZONTAL SCALE

BRIDGE FILE

VERTICAL SCALE

DESIGNATION

SURVEY BOOK

SHEETS







38 of 47

CONTRACT

PROJECT






PA-25-001

PATH AND FILENAME: V:\Pr
 MODEL NAME: Default
 DATE PLOTTED: 4/16/2015
 TIME PLOTTED: 5:26:15 PM

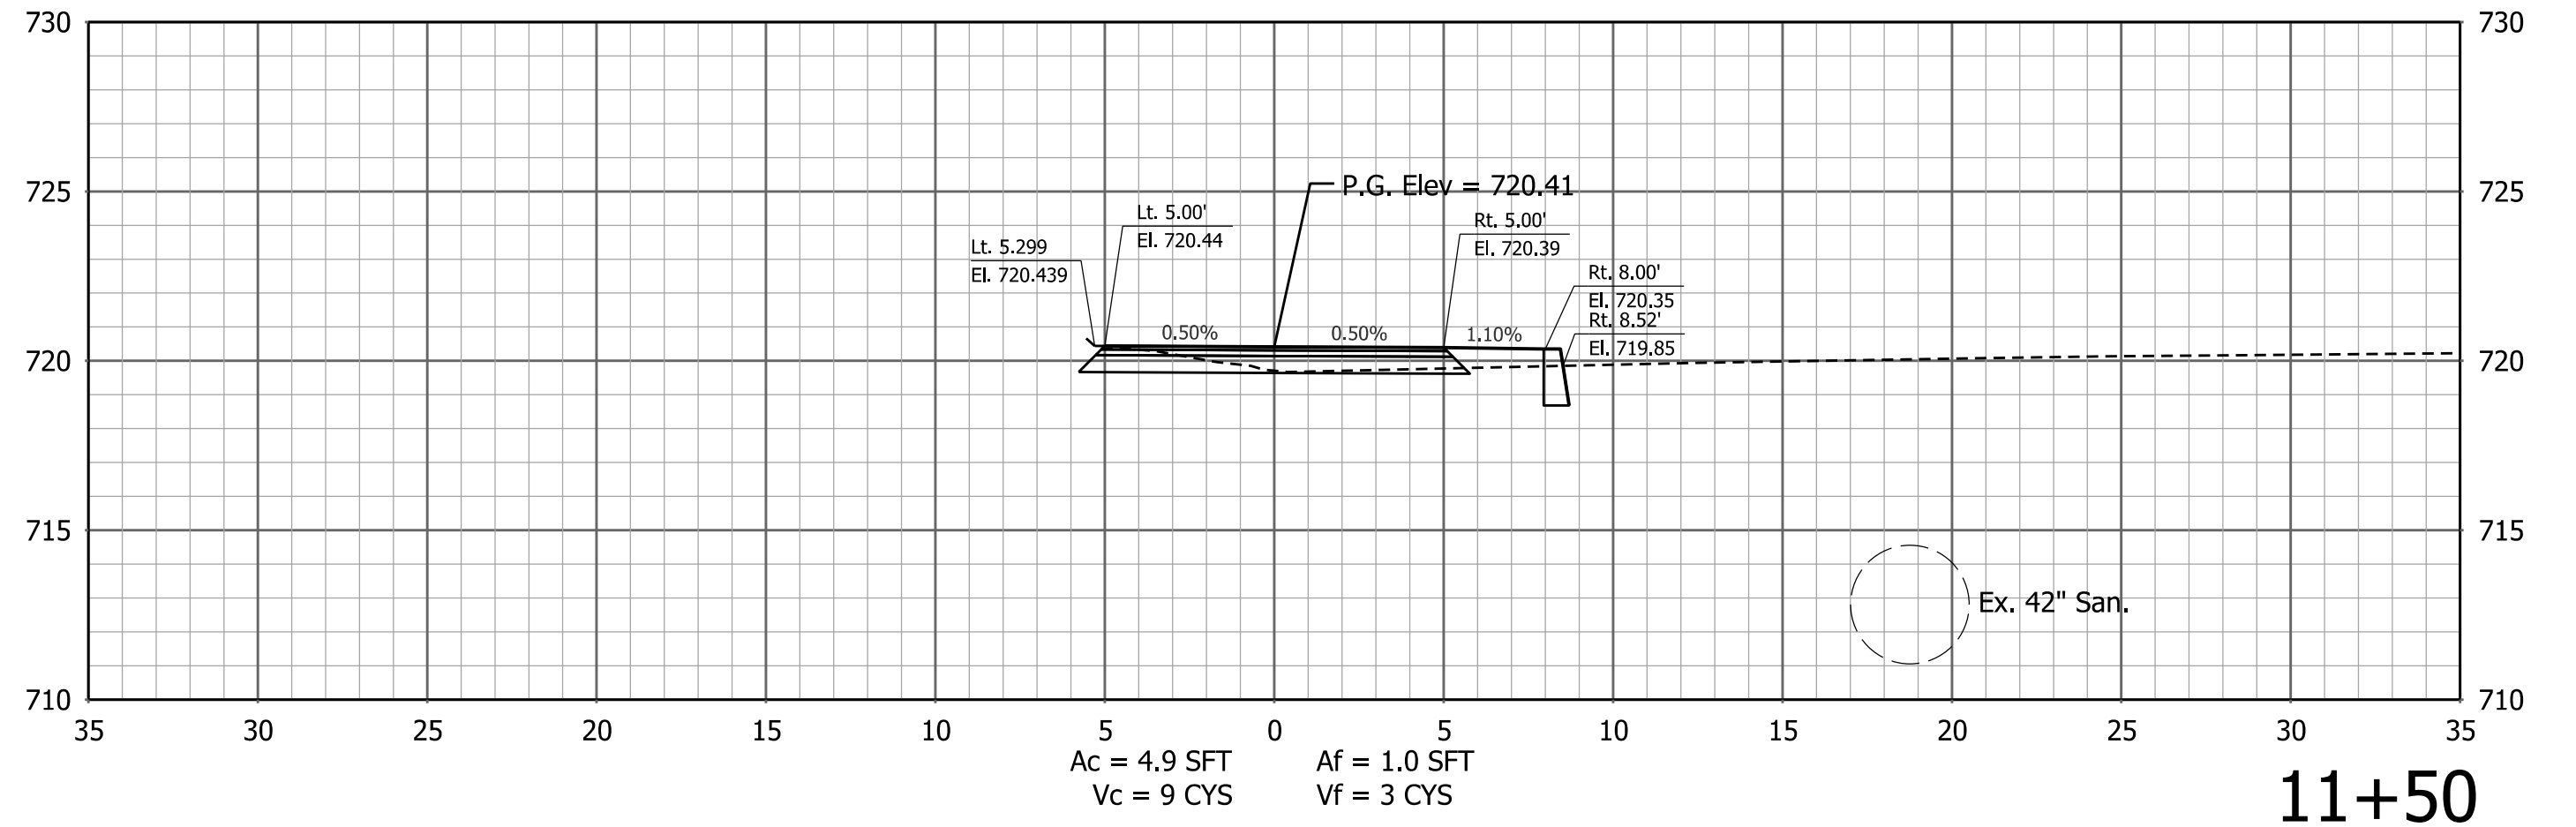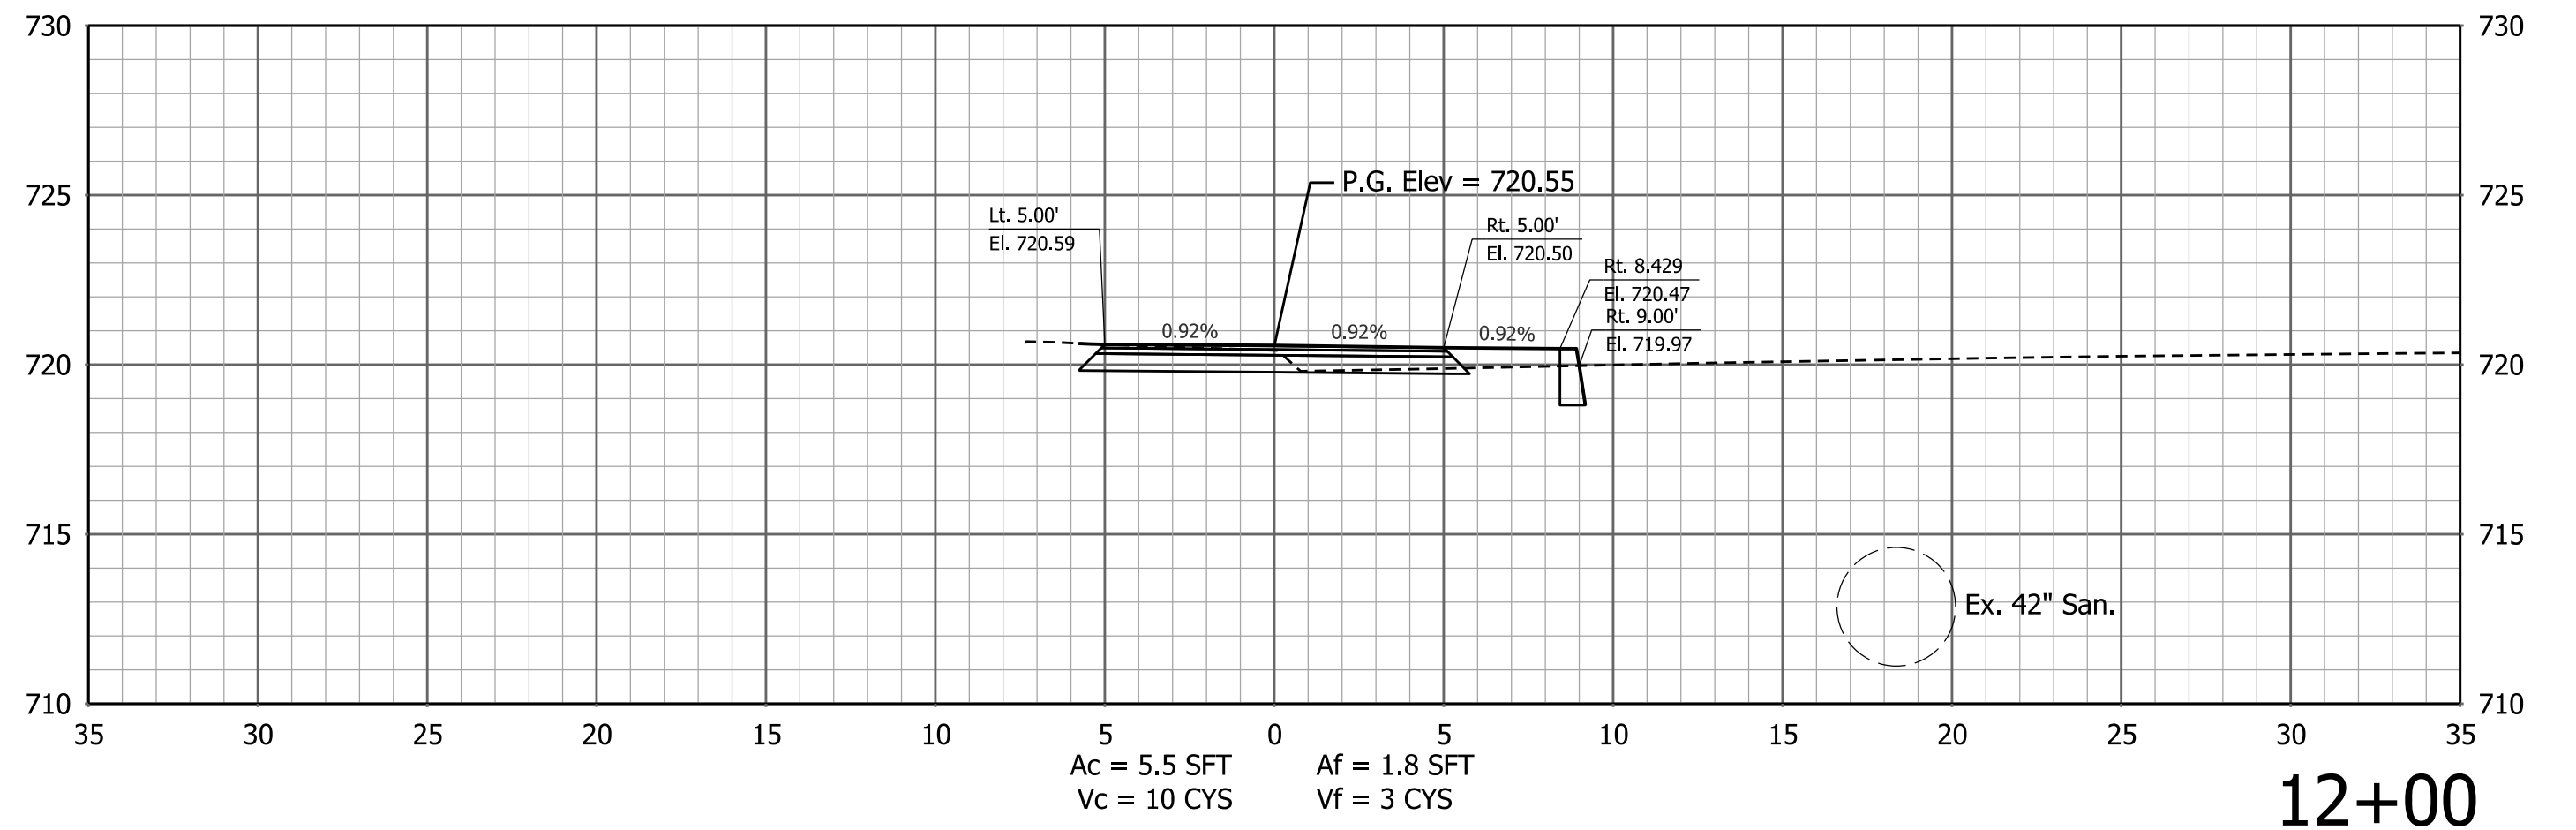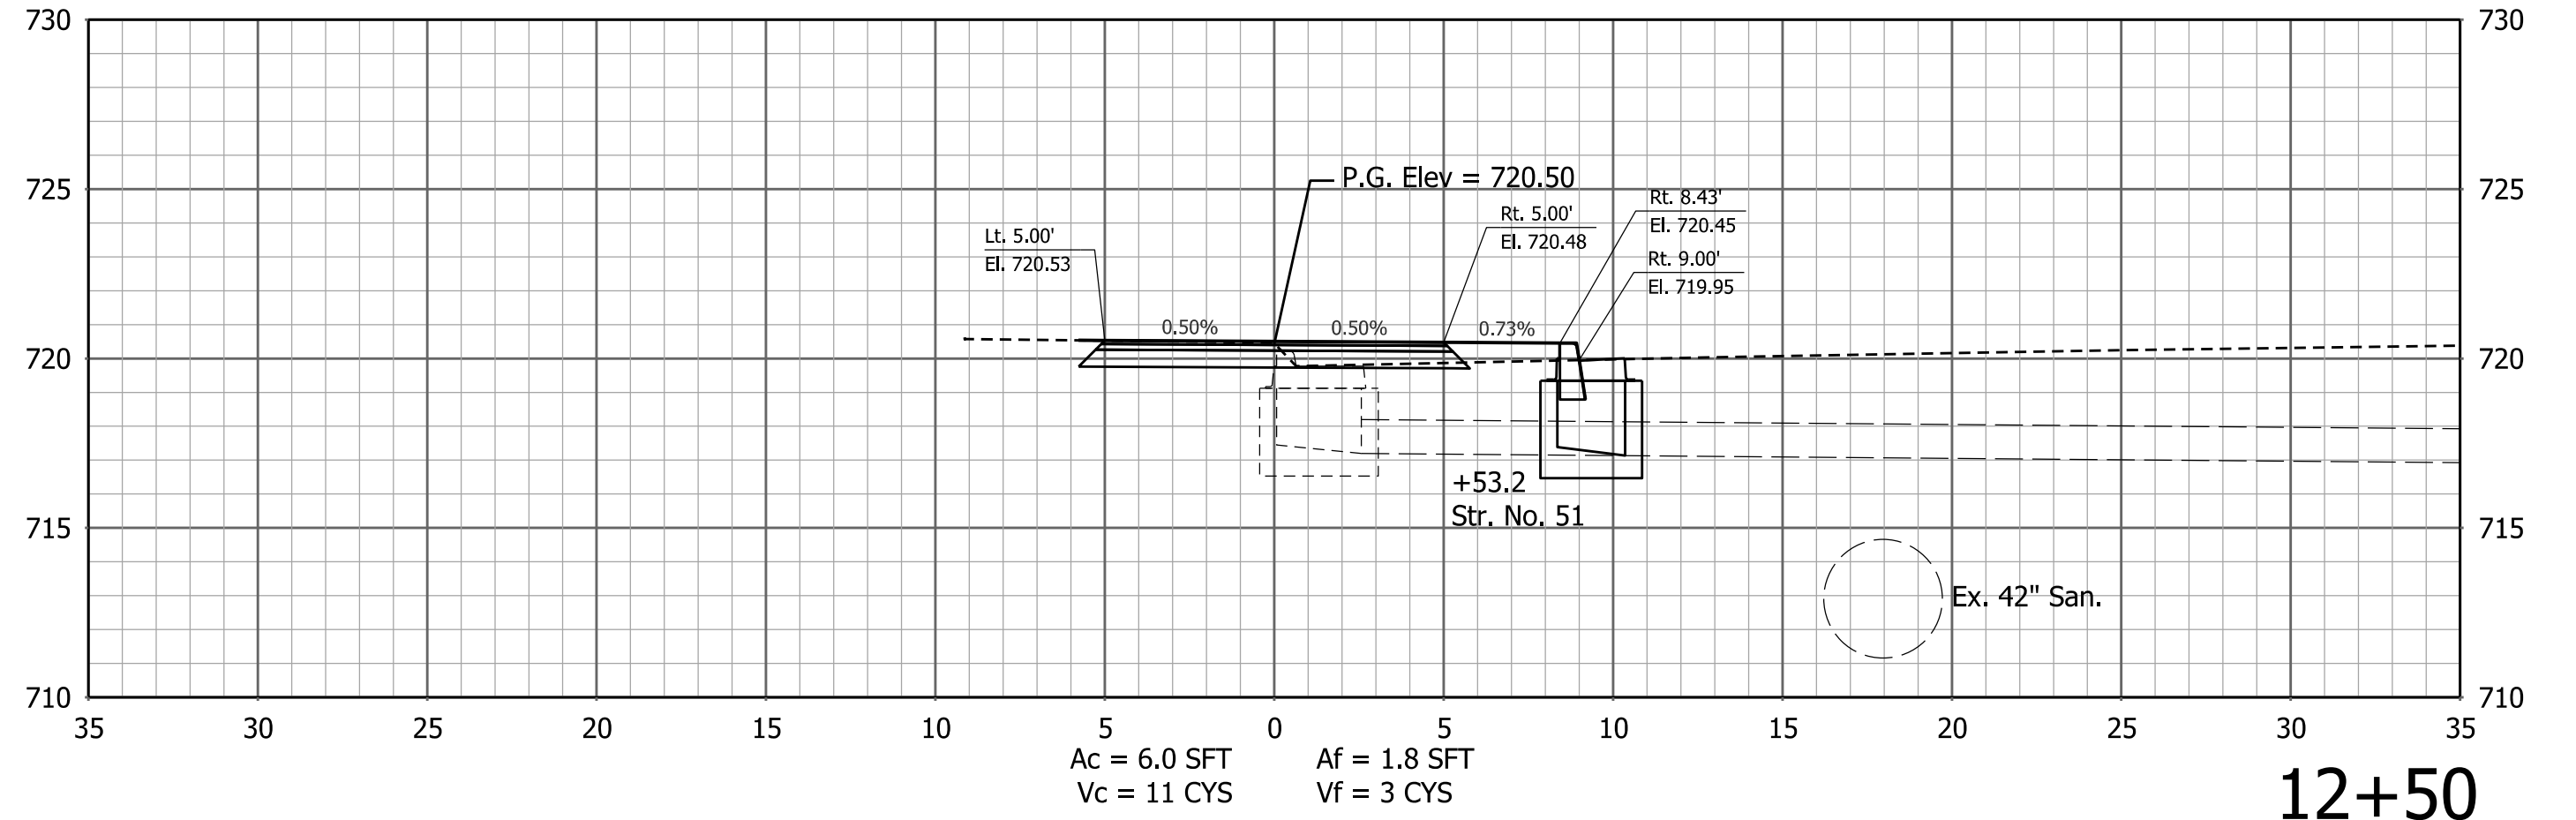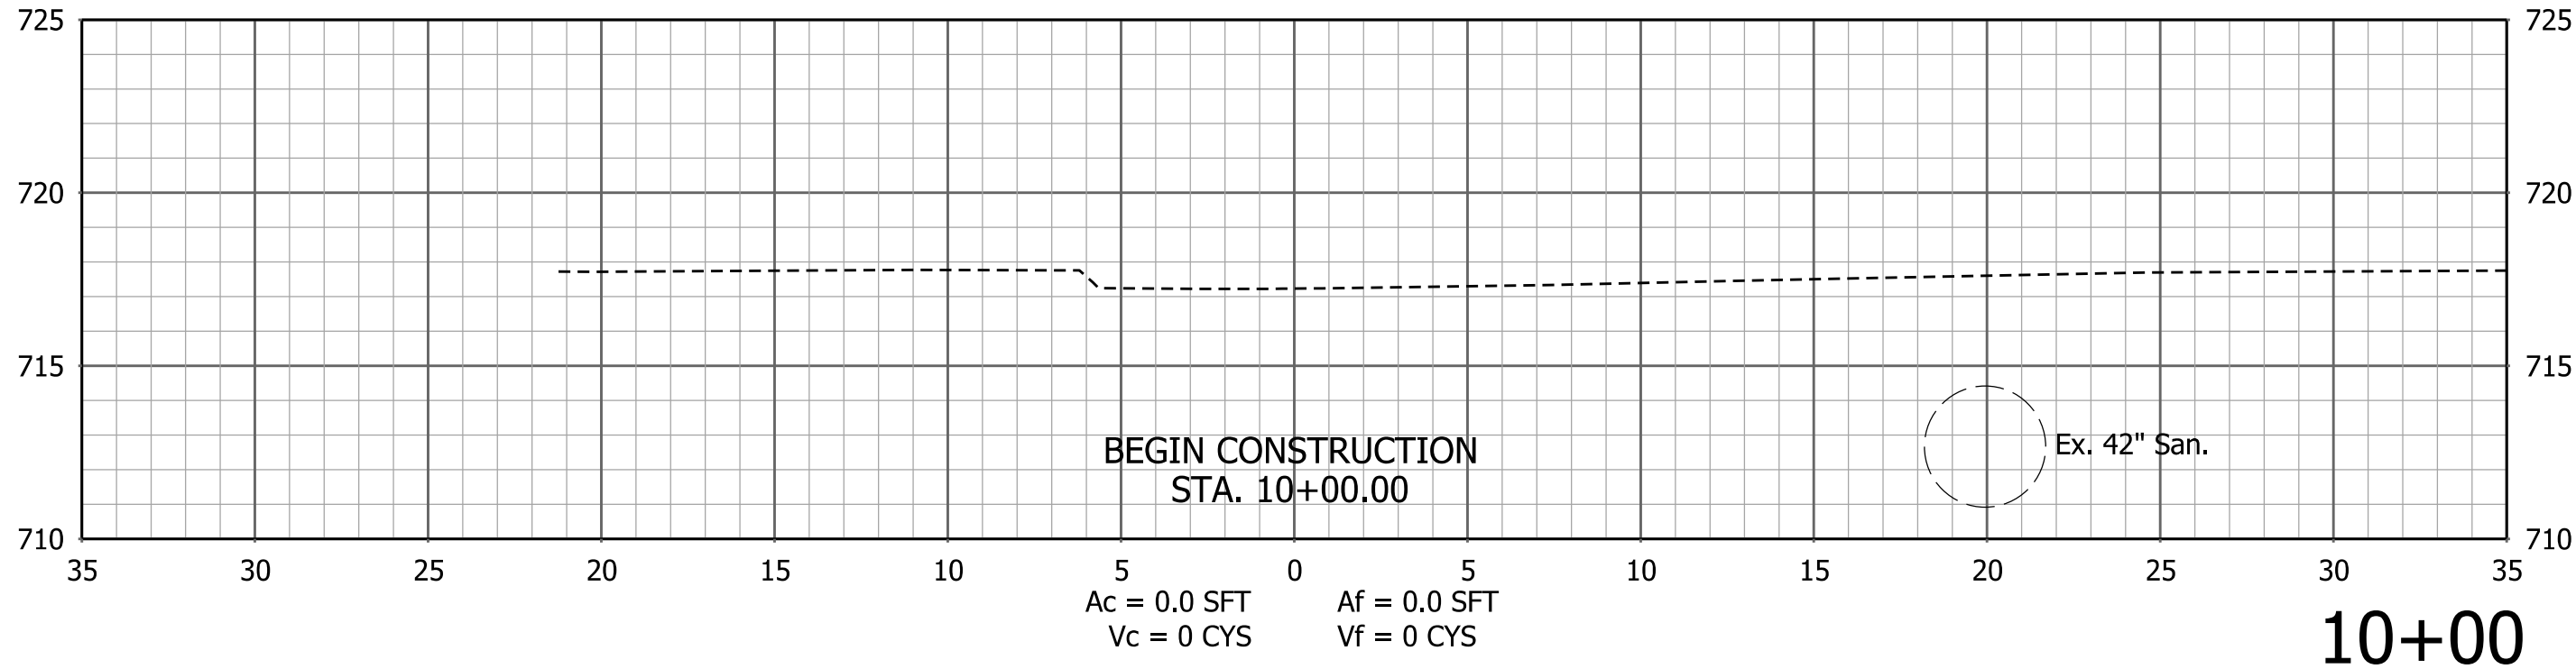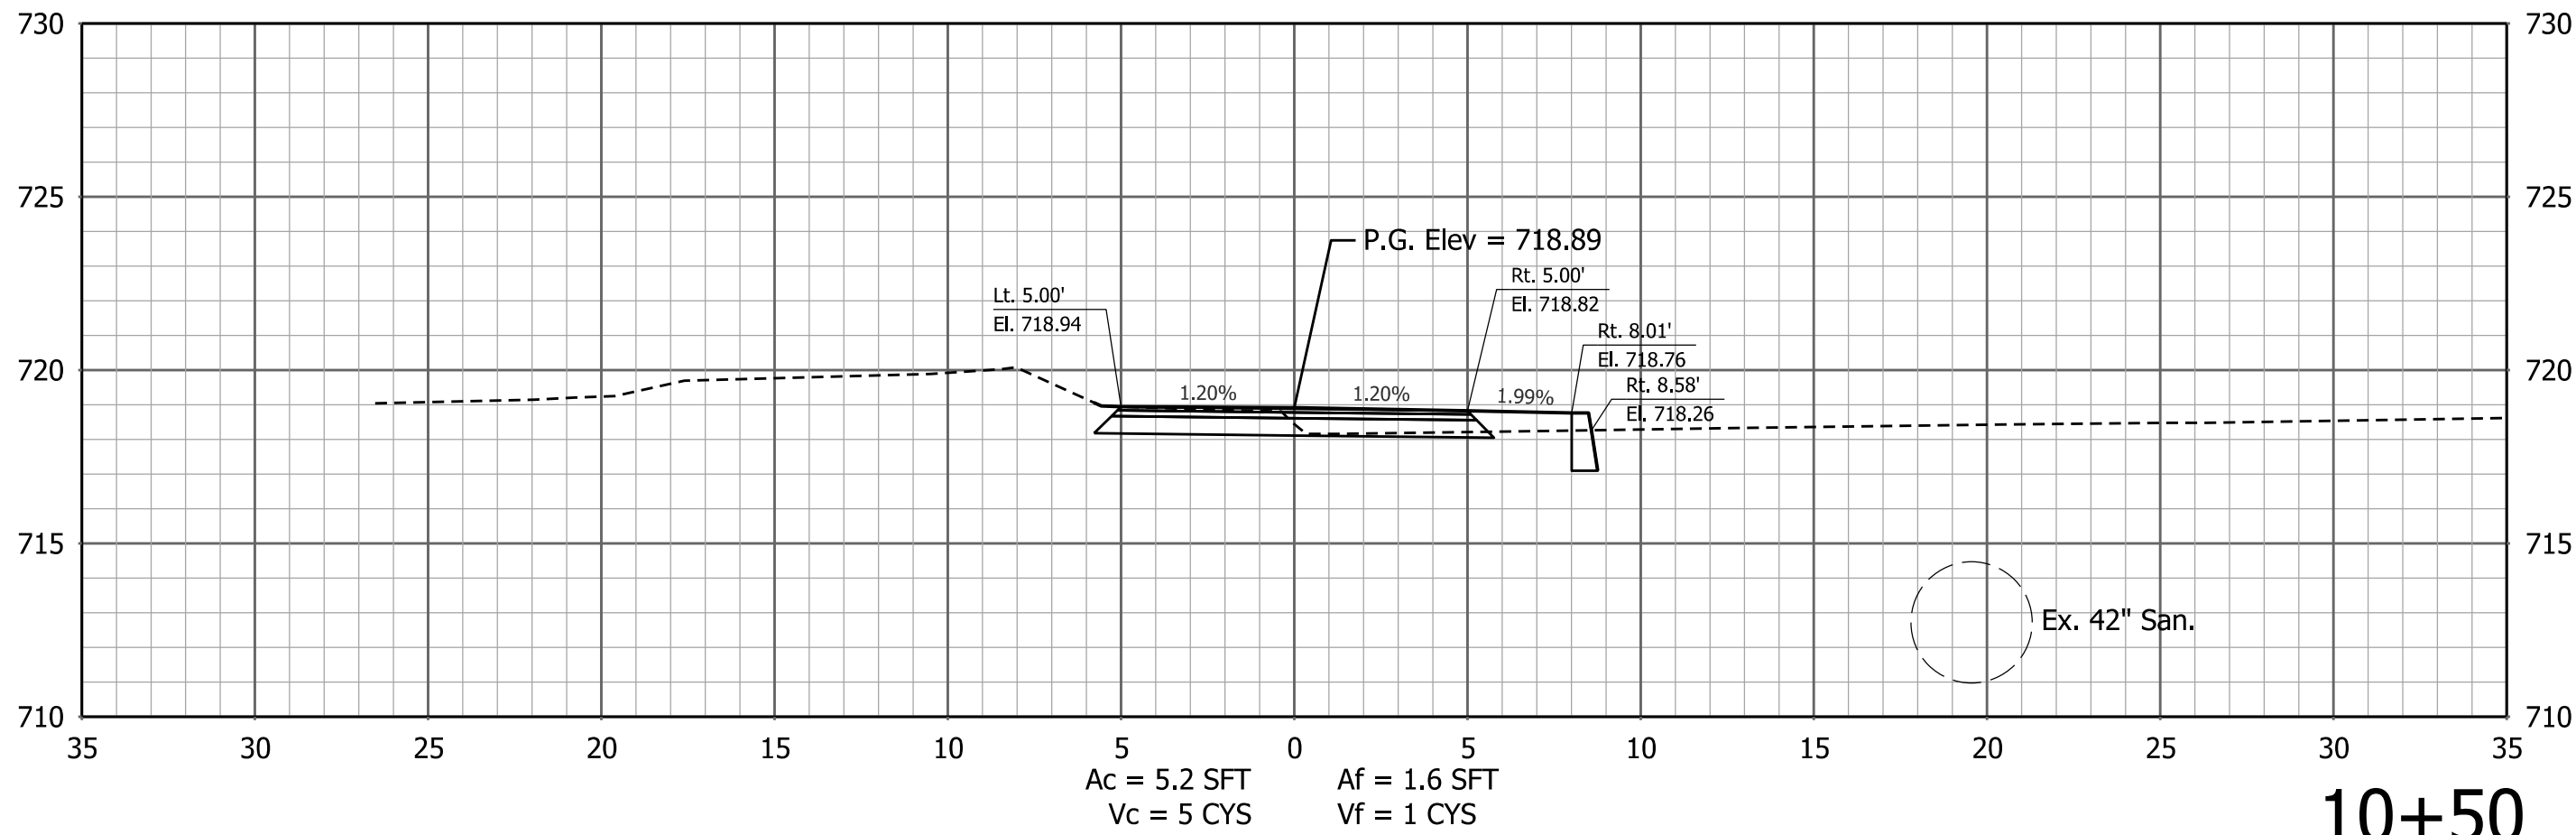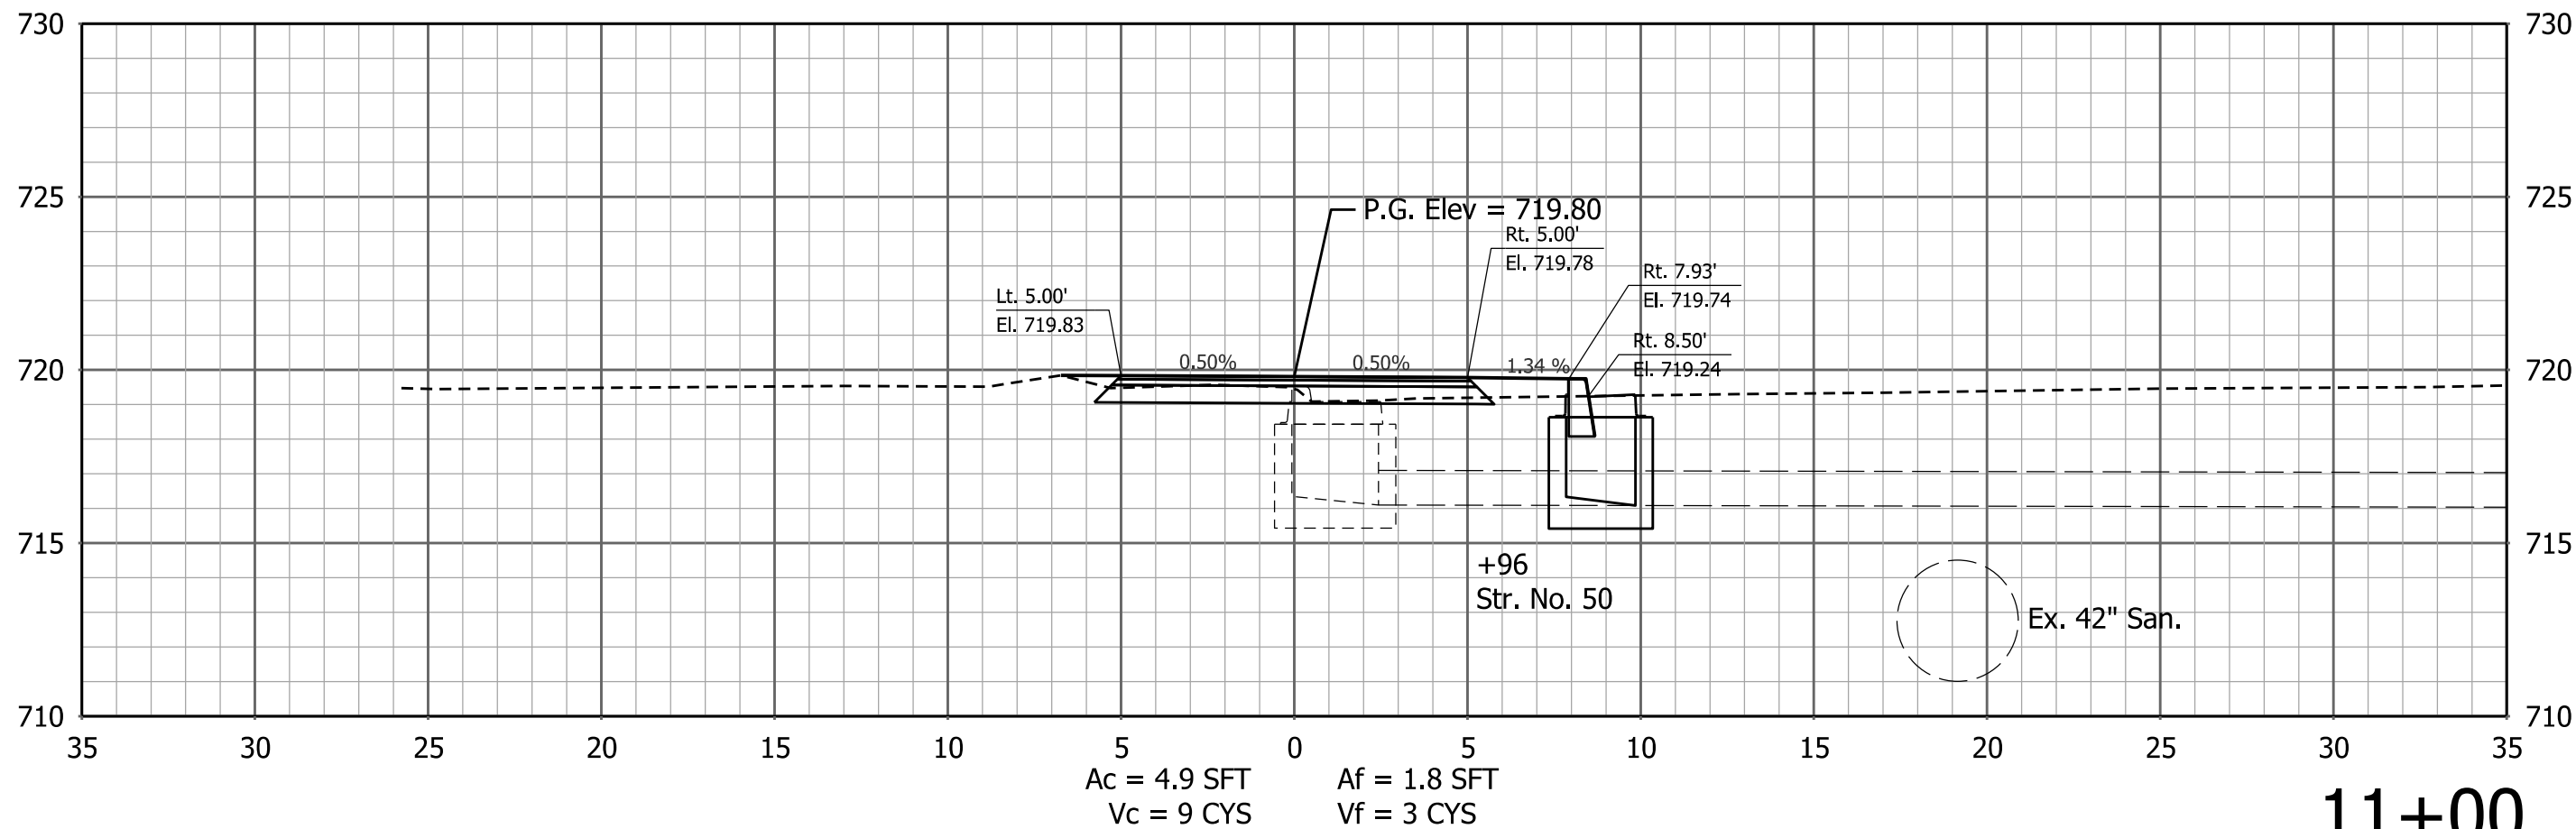







RECOMMENDED FOR APPROVAL _____ DESIGN ENGINEER _____ DATE _____	CITY OF INDIANAPOLIS DEPARTMENT OF PUBLIC WORKS		SCALE	BRIDGE FILE		
			1" = 5'			
			DESIGNATION			
DESIGNED: _____ VA _____	DRAWN: _____ JSS _____	CROSS SECTIONS LINE "P10th"	SURVEY BOOK	SHEETS		
CHECKED: _____ ACD _____	CHECKED: _____ VA _____			XS 39	of	XS 47
			CONTRACT	PROJECT PA-25-001		

PATH AND FILENAME: V:\Projects\IIN62\Planning and Urban Design\Projects\27813 Pogues Run Greenway\30 SheetDrawings\40 CrossSections\Sht Xsec 5_02.dgn
MODEL NAME: Default
DATE PLOTTED: 4/16/2015
TIME PLOTTED: 5:26:16 PM

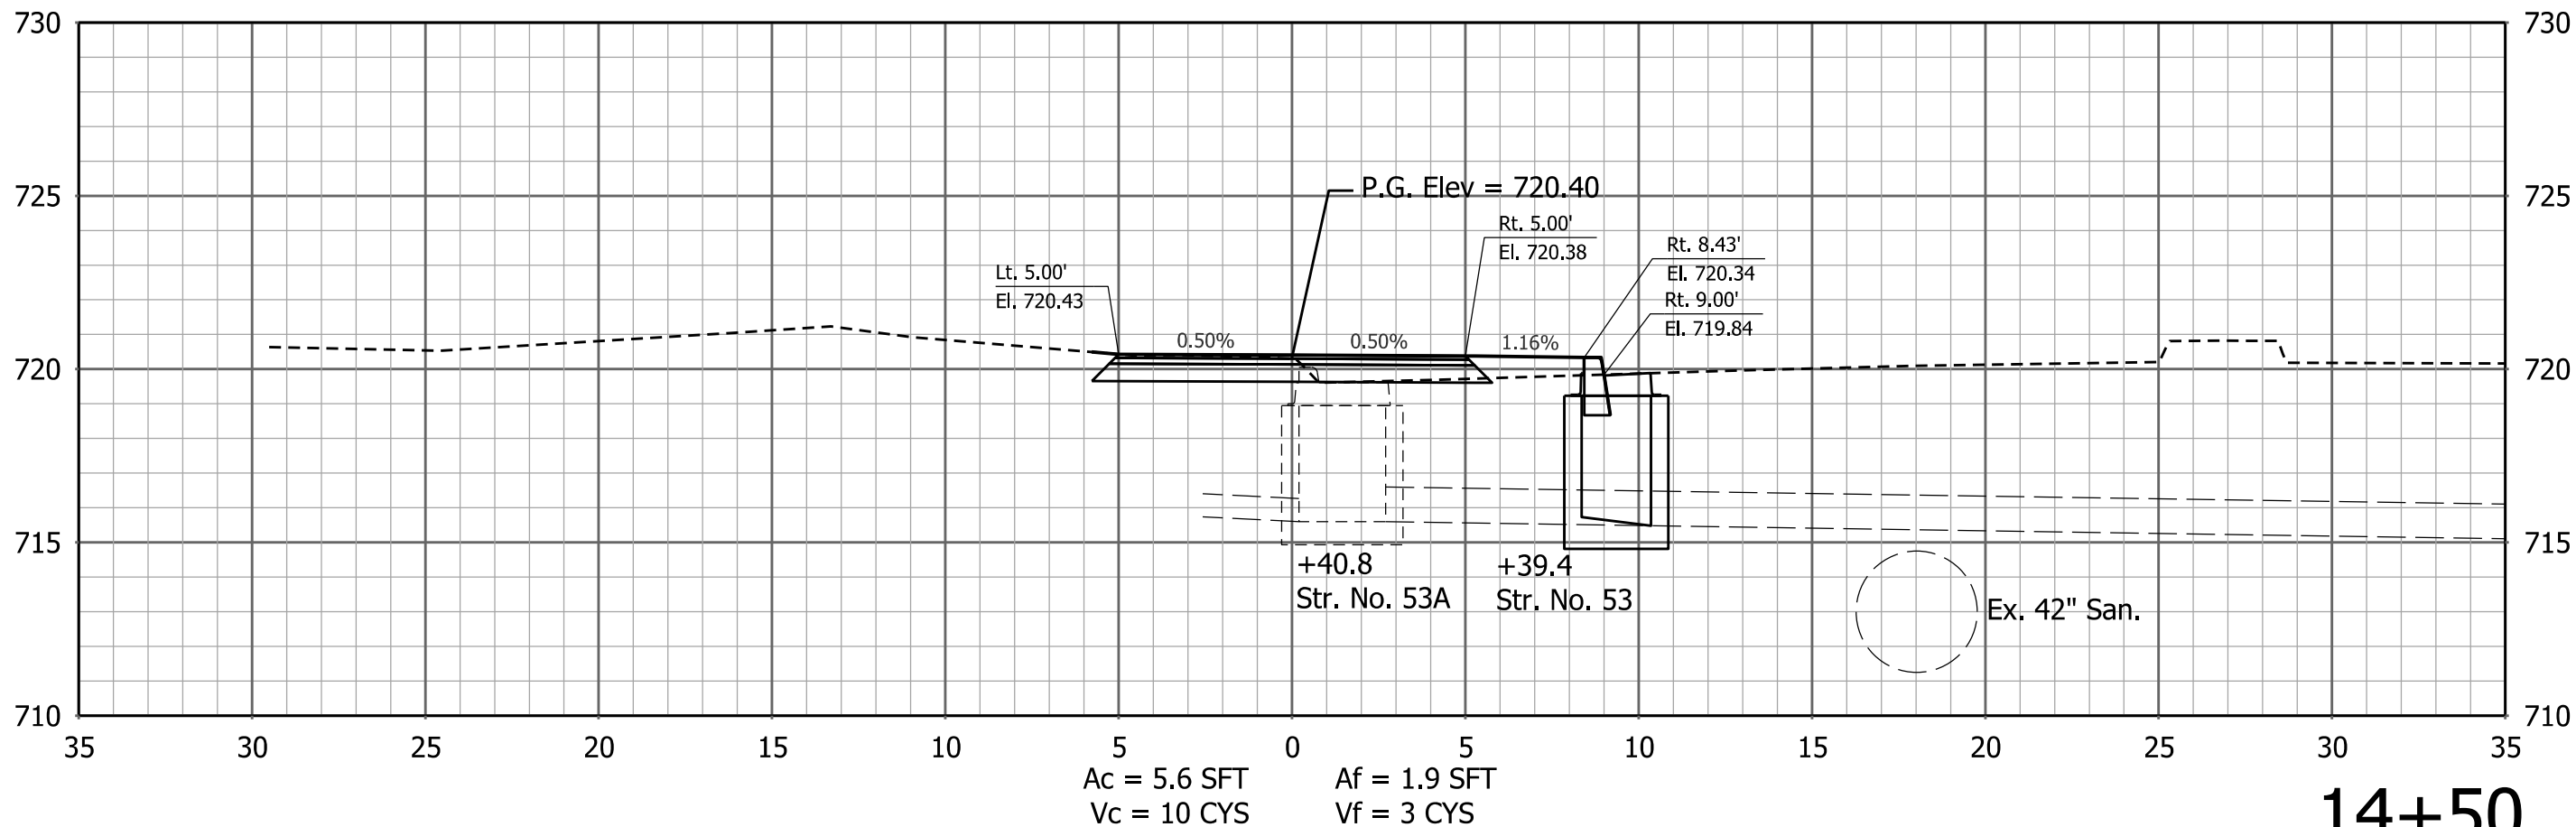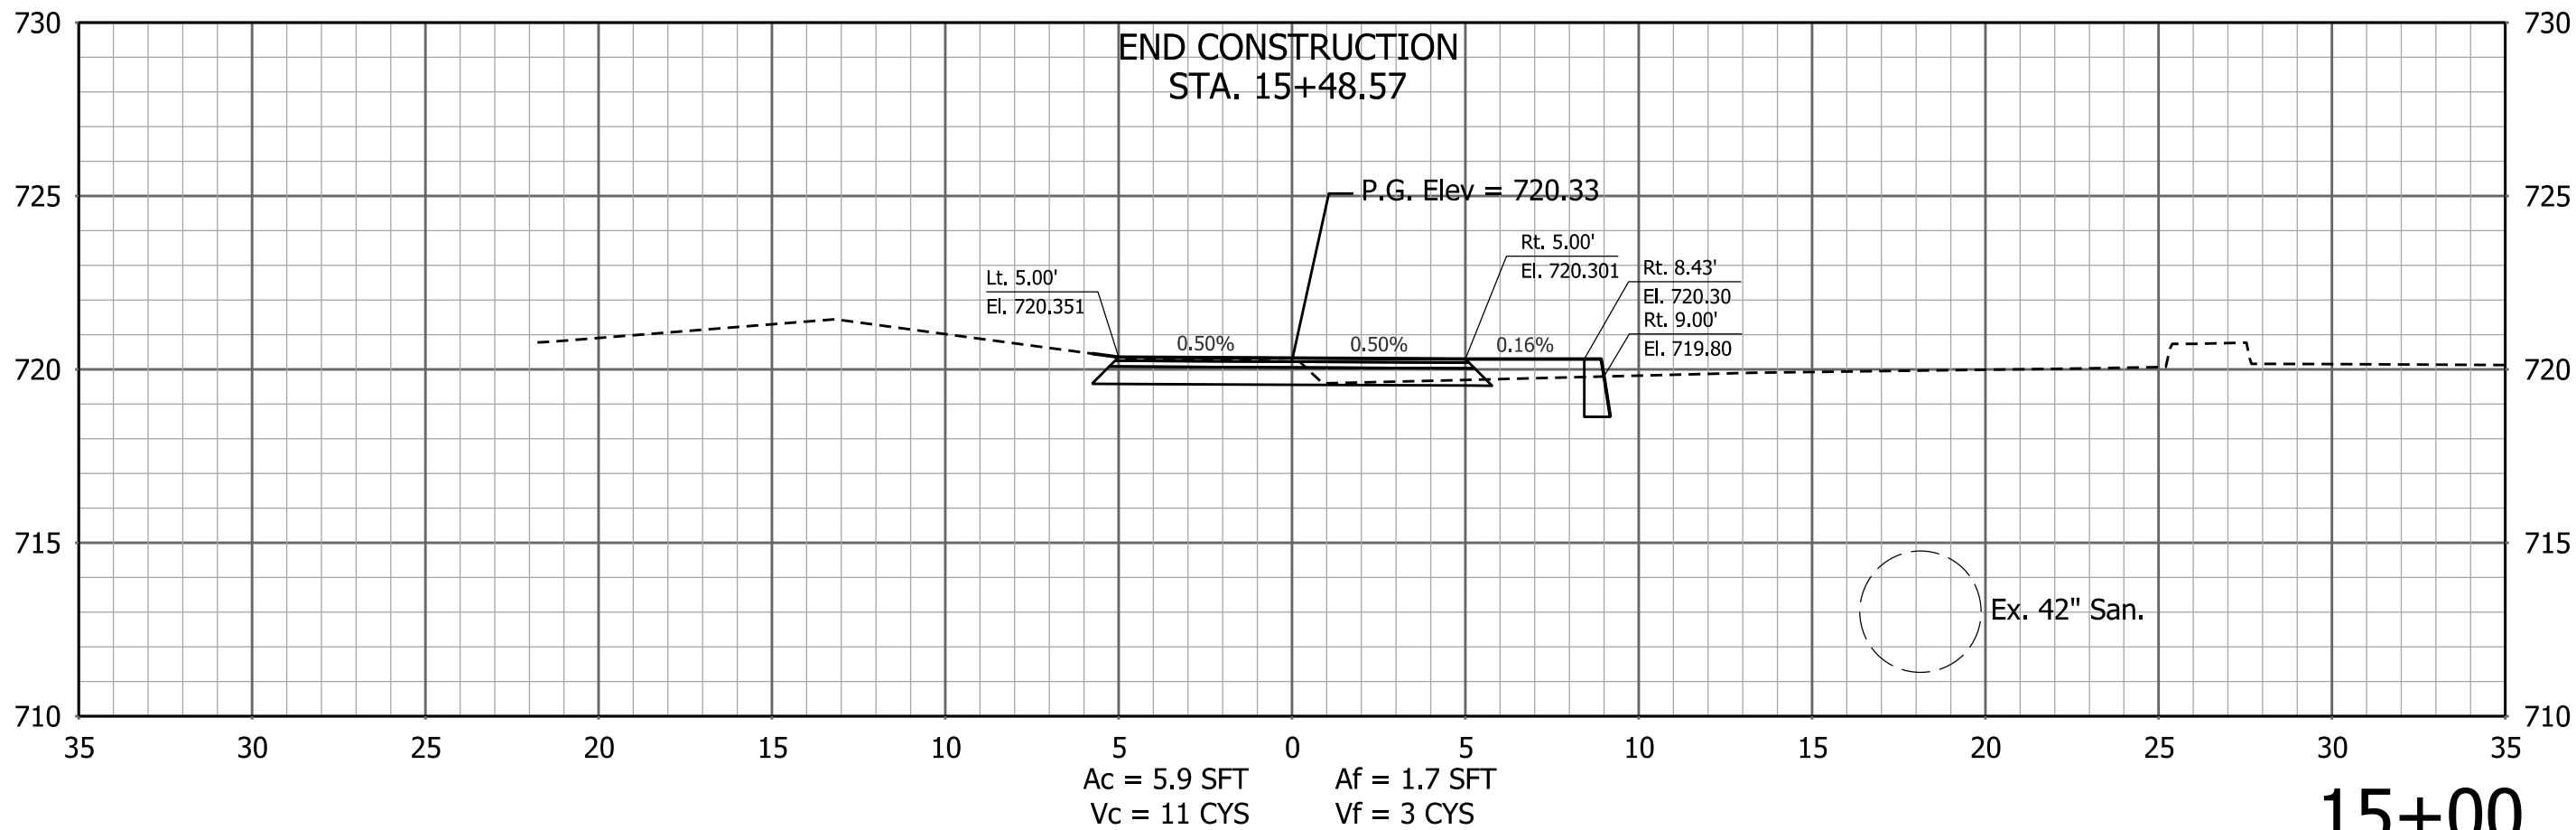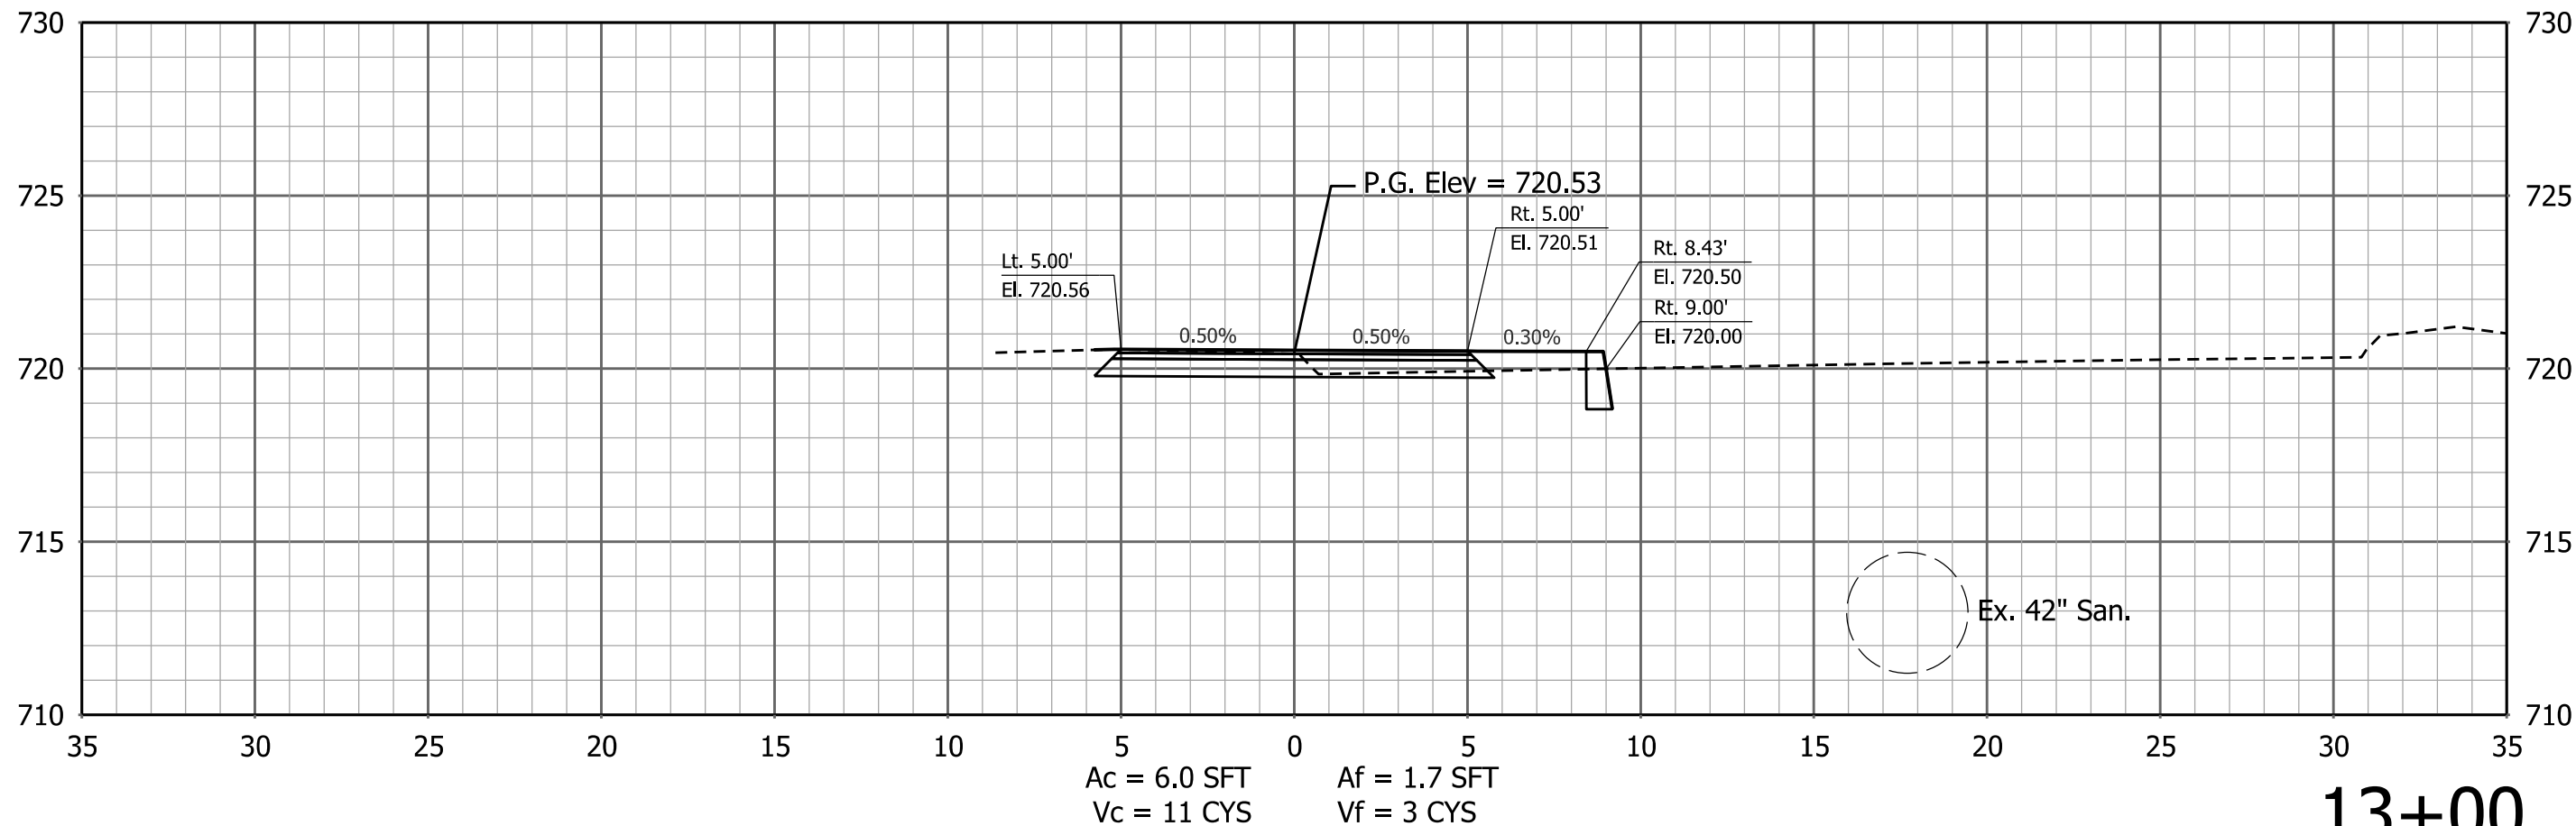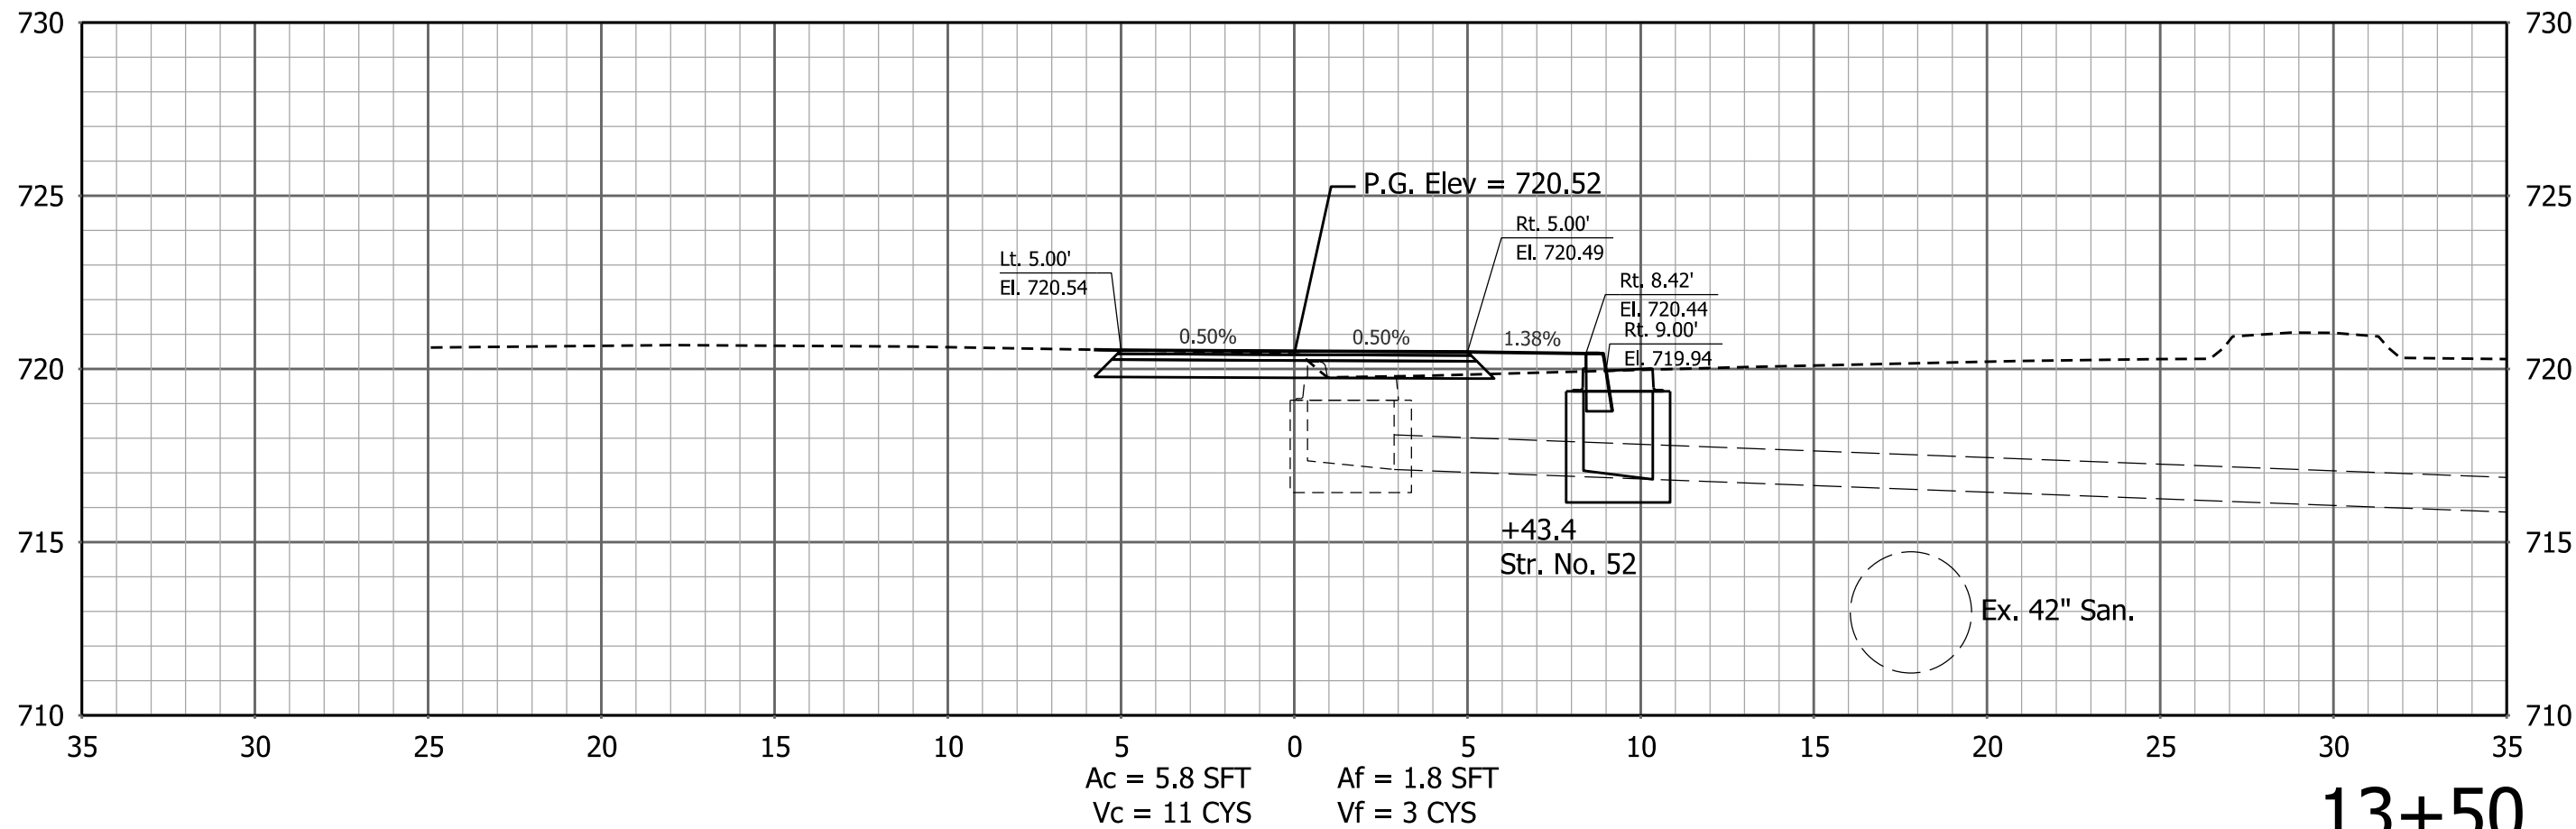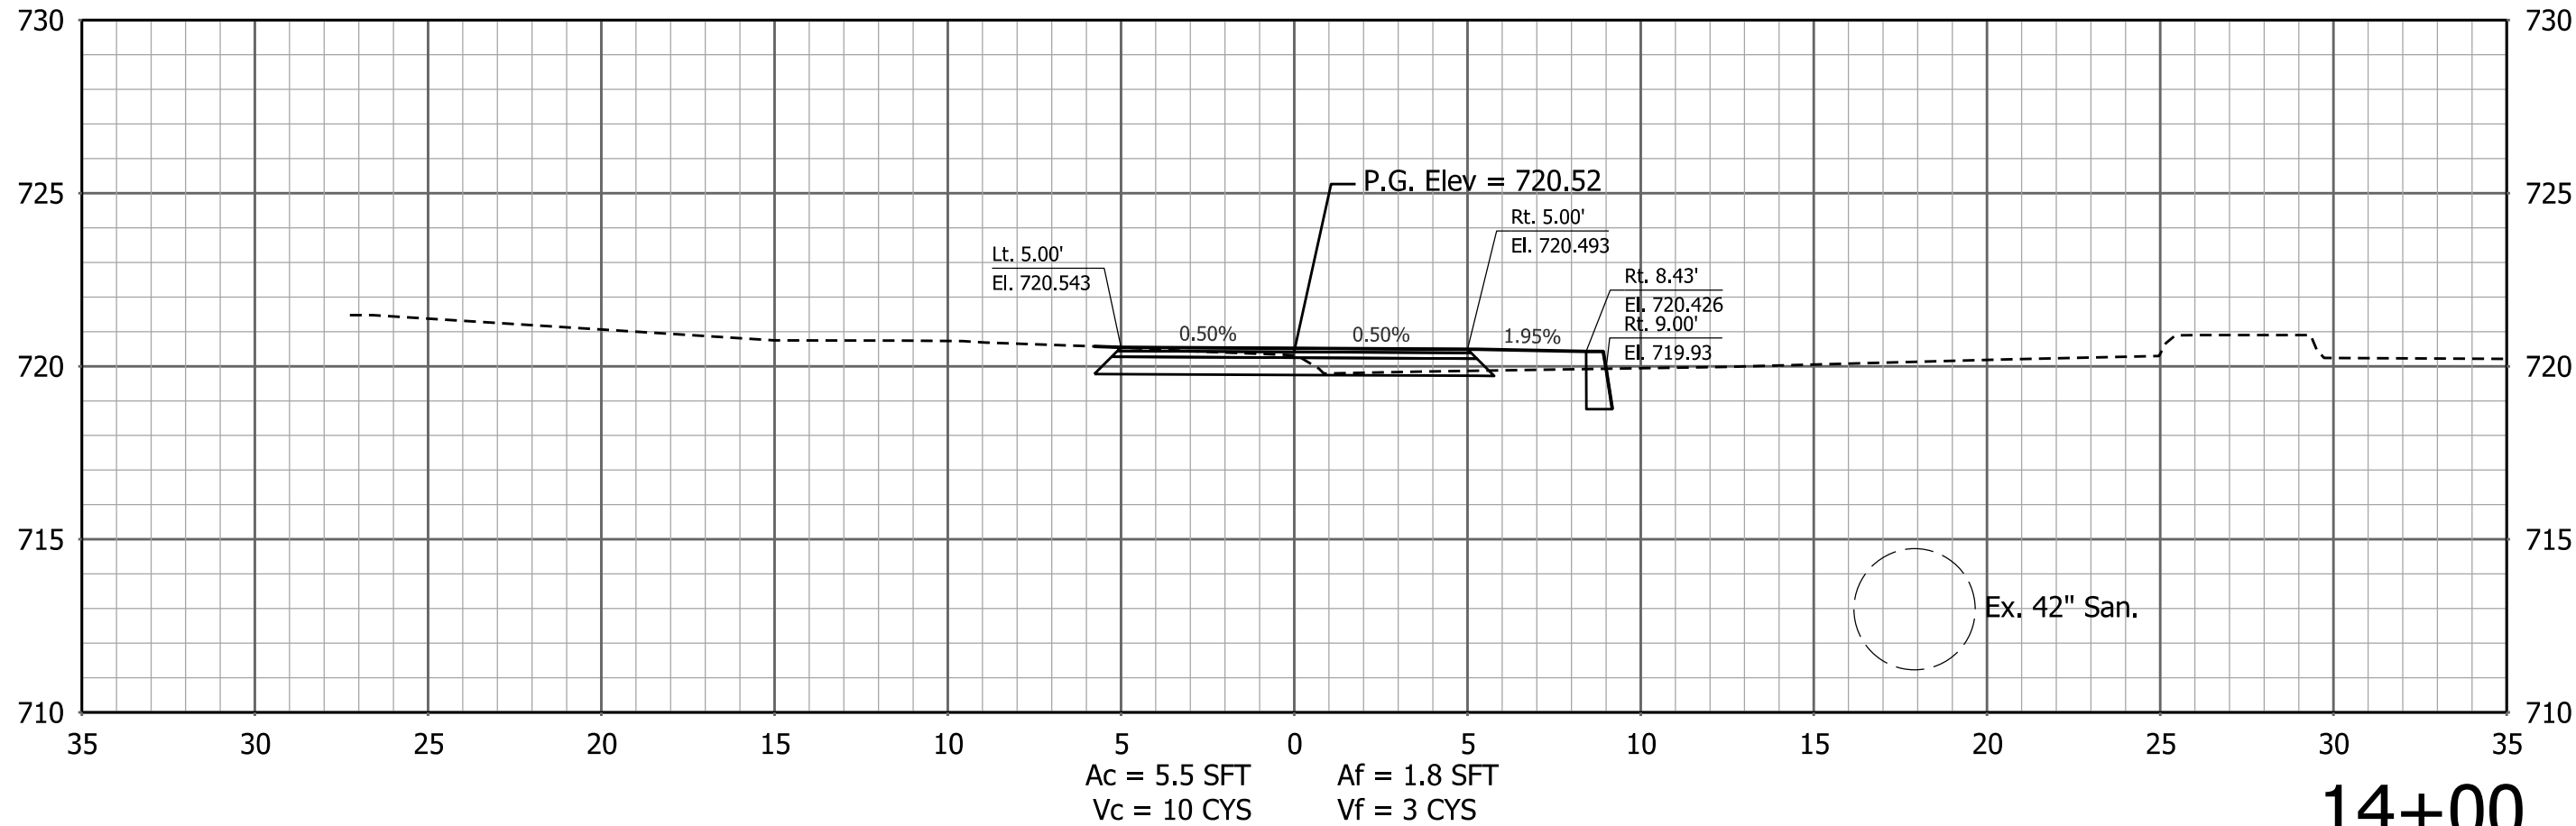

RECOMMENDED FOR APPROVAL _____ DESIGN ENGINEER DATE		CITY OF INDIANAPOLIS DEPARTMENT OF PUBLIC WORKS	SCALE		BRIDGE FILE			
			1" = 5'					
					DESIGNATION			
DESIGNED: _____ VA		DRAWN: _____ JSS		SURVEY BOOK		SHEETS		
CHECKED: _____ ACD		CHECKED: _____ VA		CONTRACT		XS 40	of	XS 47
						PROJECT PA-25-001		









PATH AND FILENAME: V:\Projects\IIN62\Planning and Urban Design\Projects\27813 Pogues Run Greenway\30 SheetDrawings\40 CrossSections\Sht Xsec 5_PH1_01.dgn
MODEL NAME: Default
DATE PLOTTED: 4/16/2015
TIME PLOTTED: 5:26:18 PM

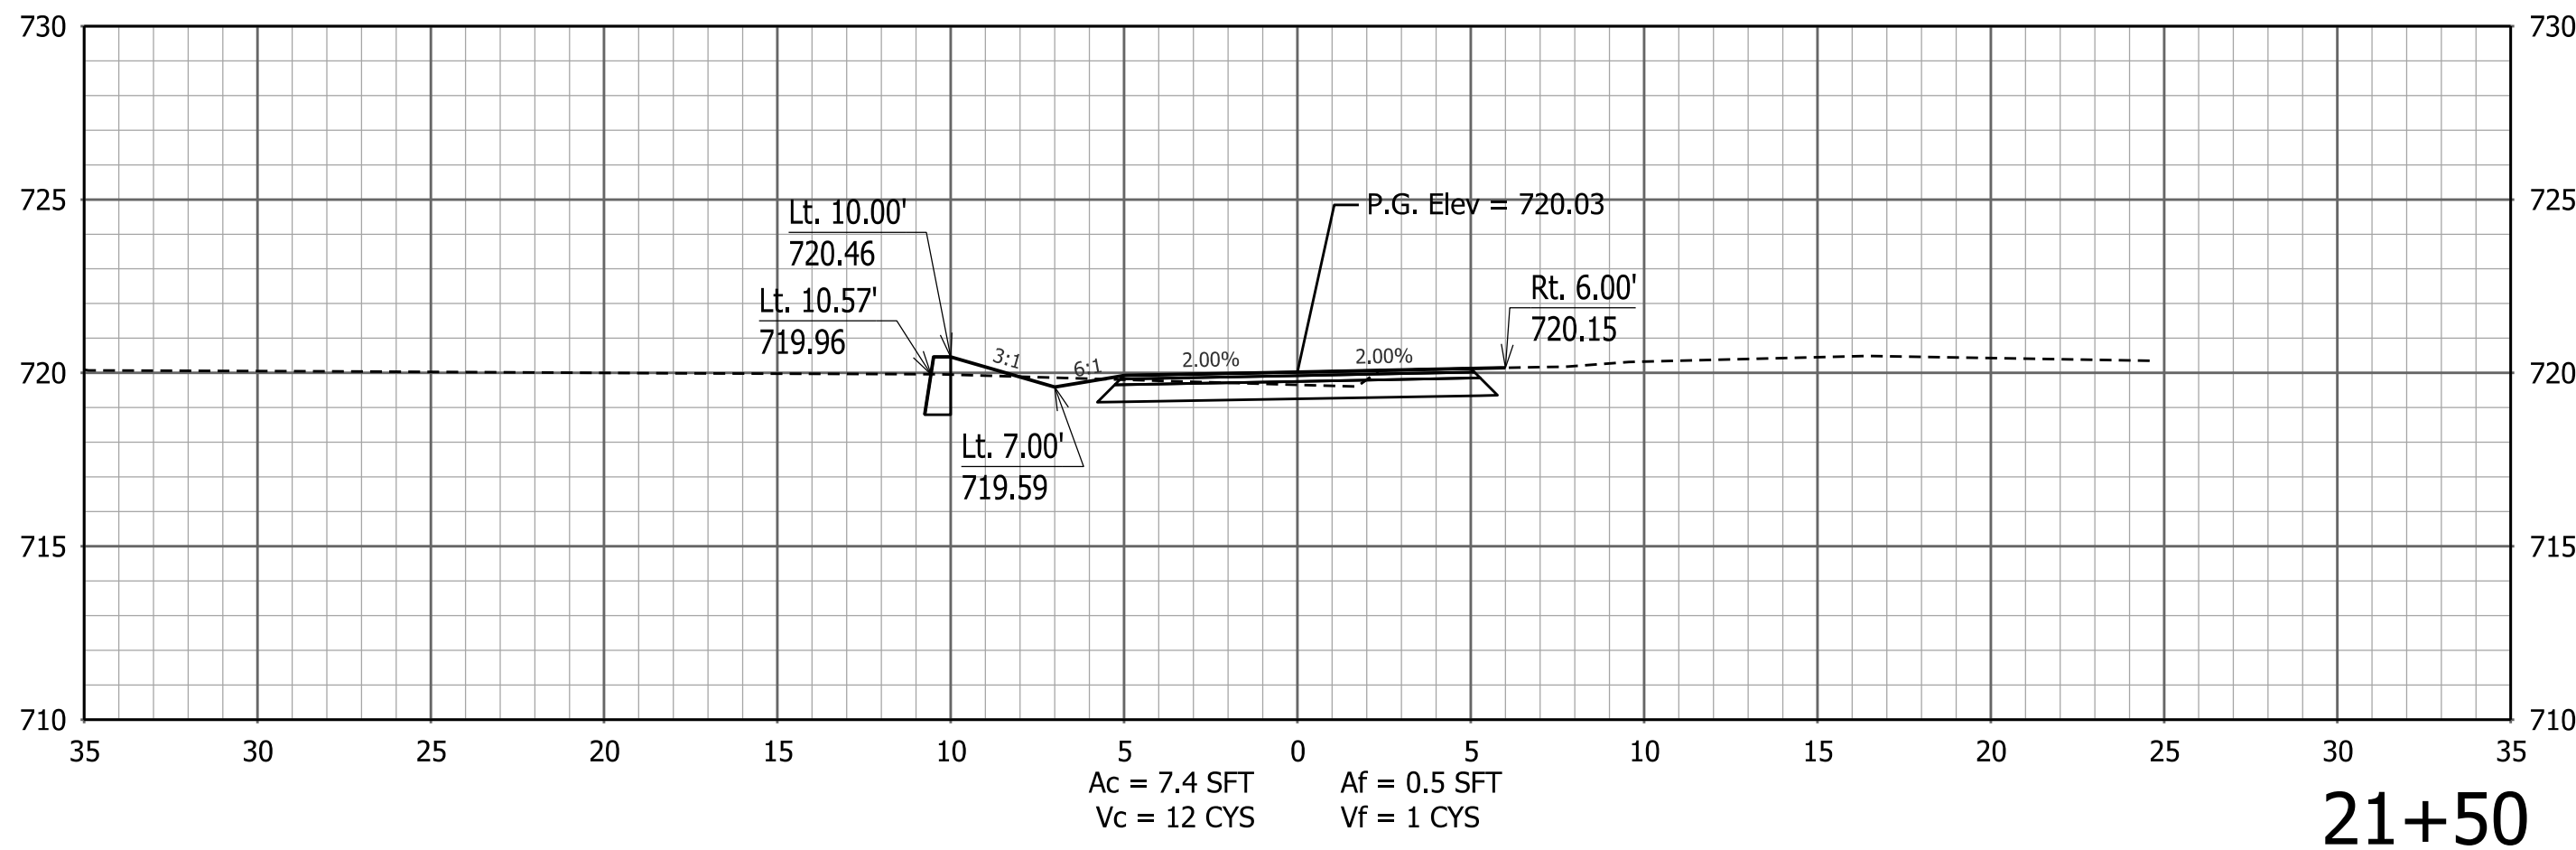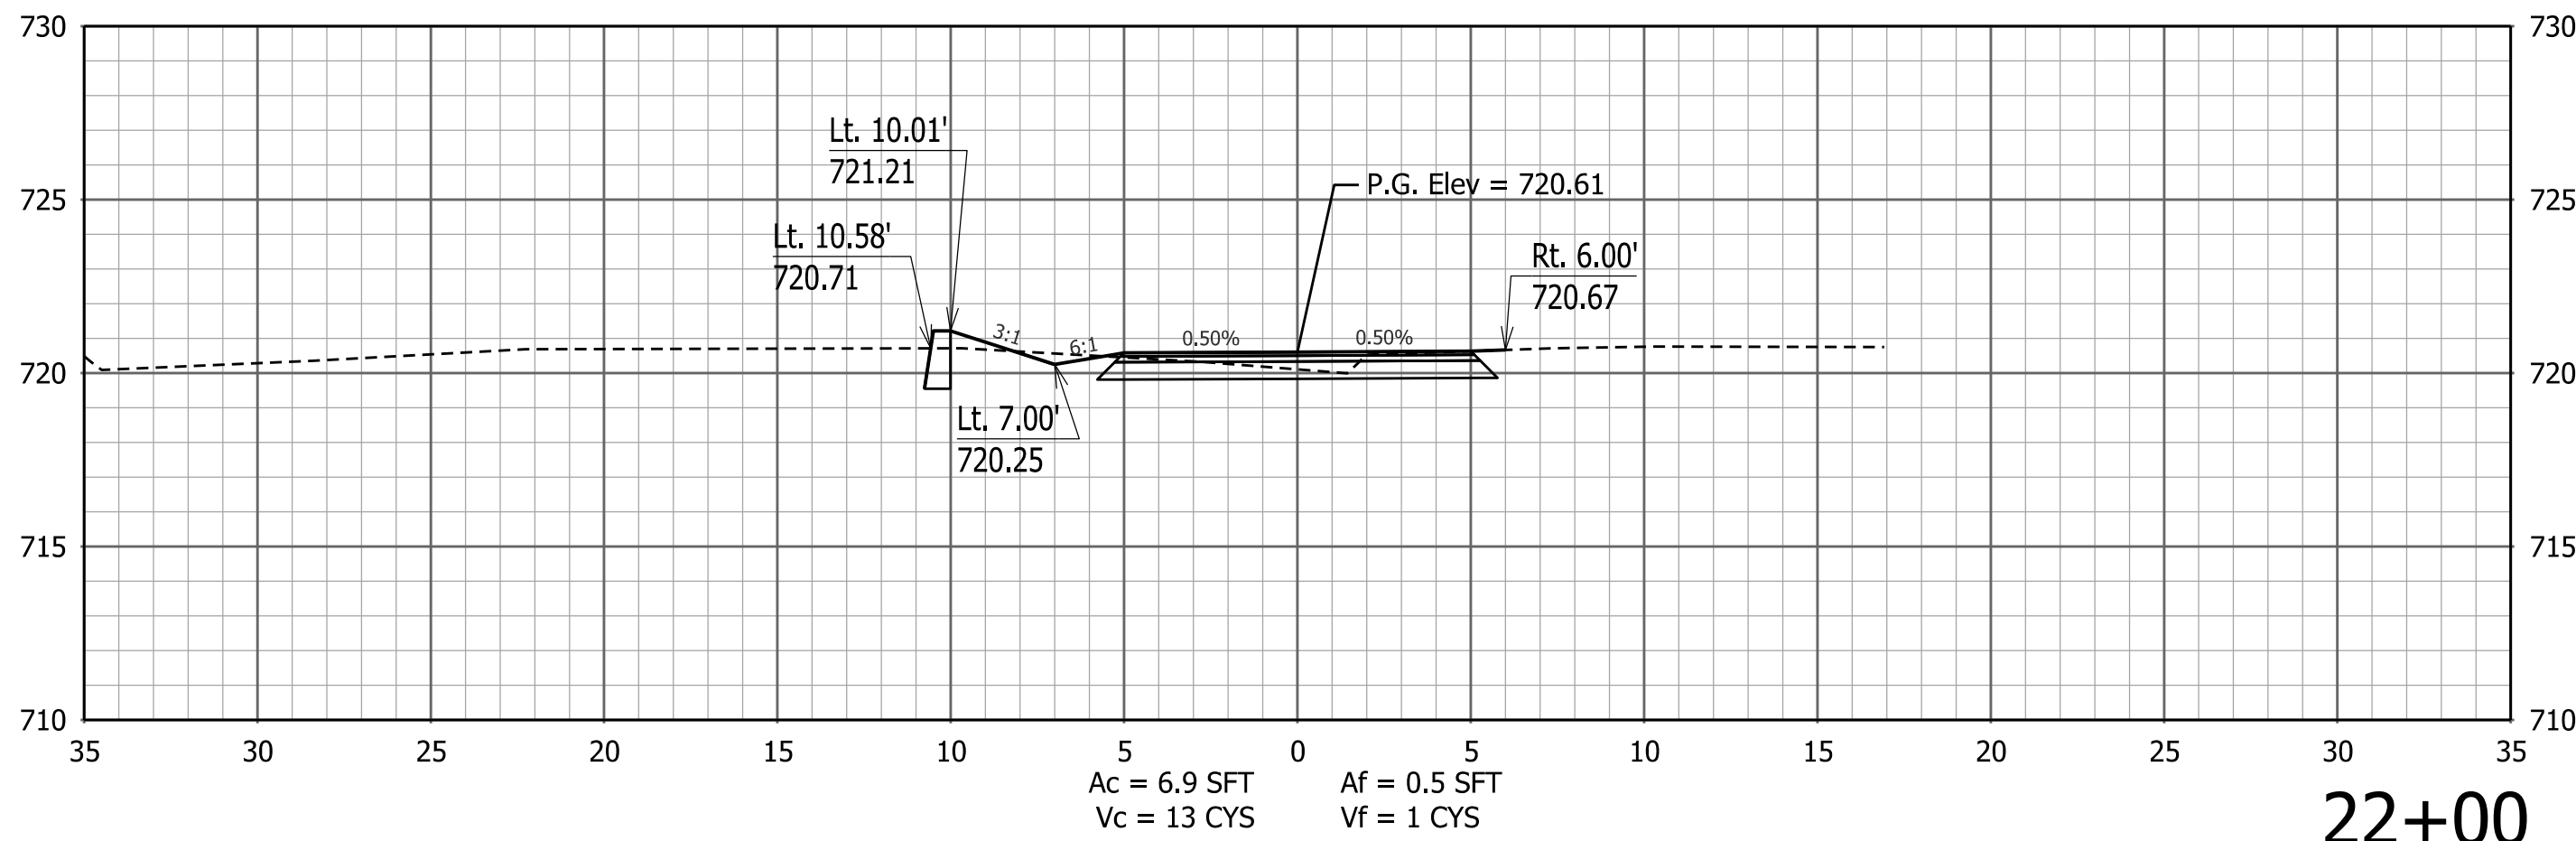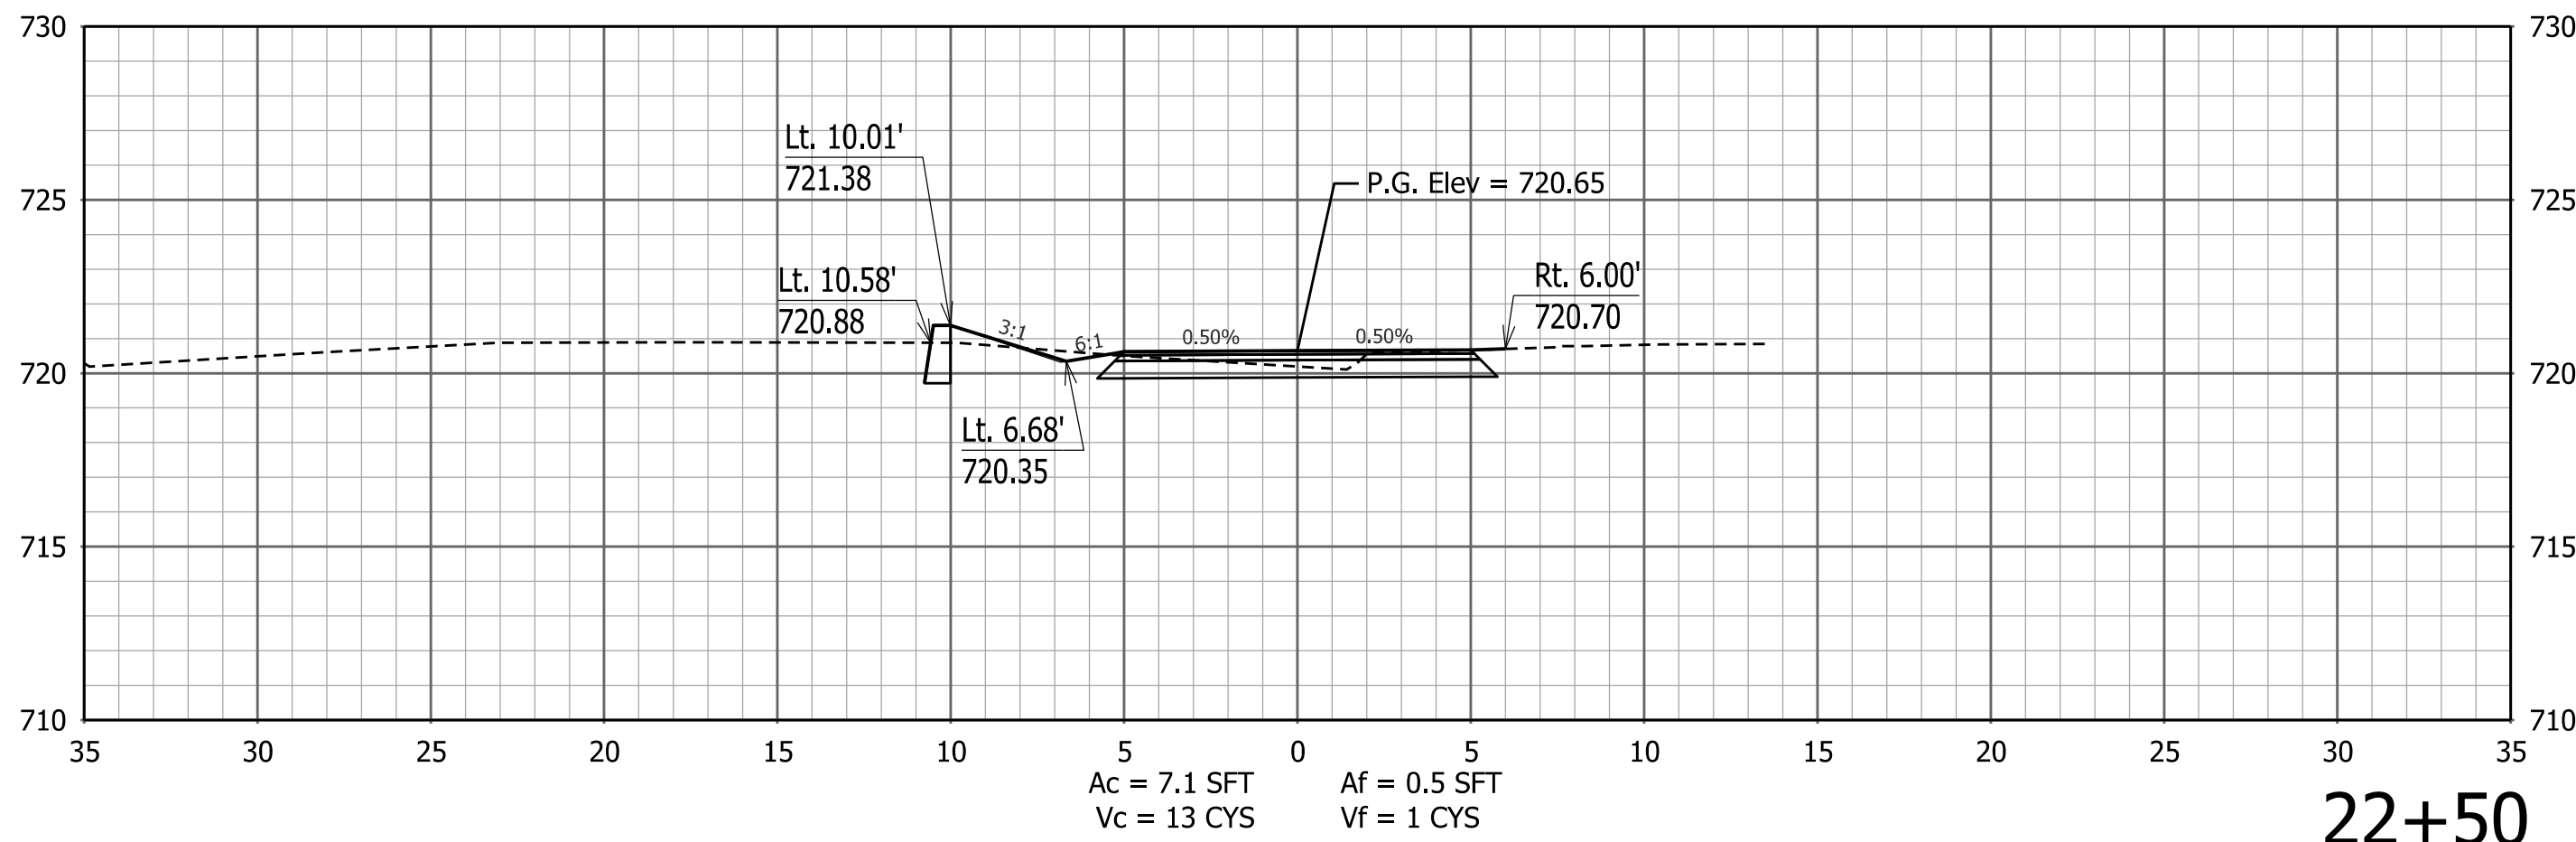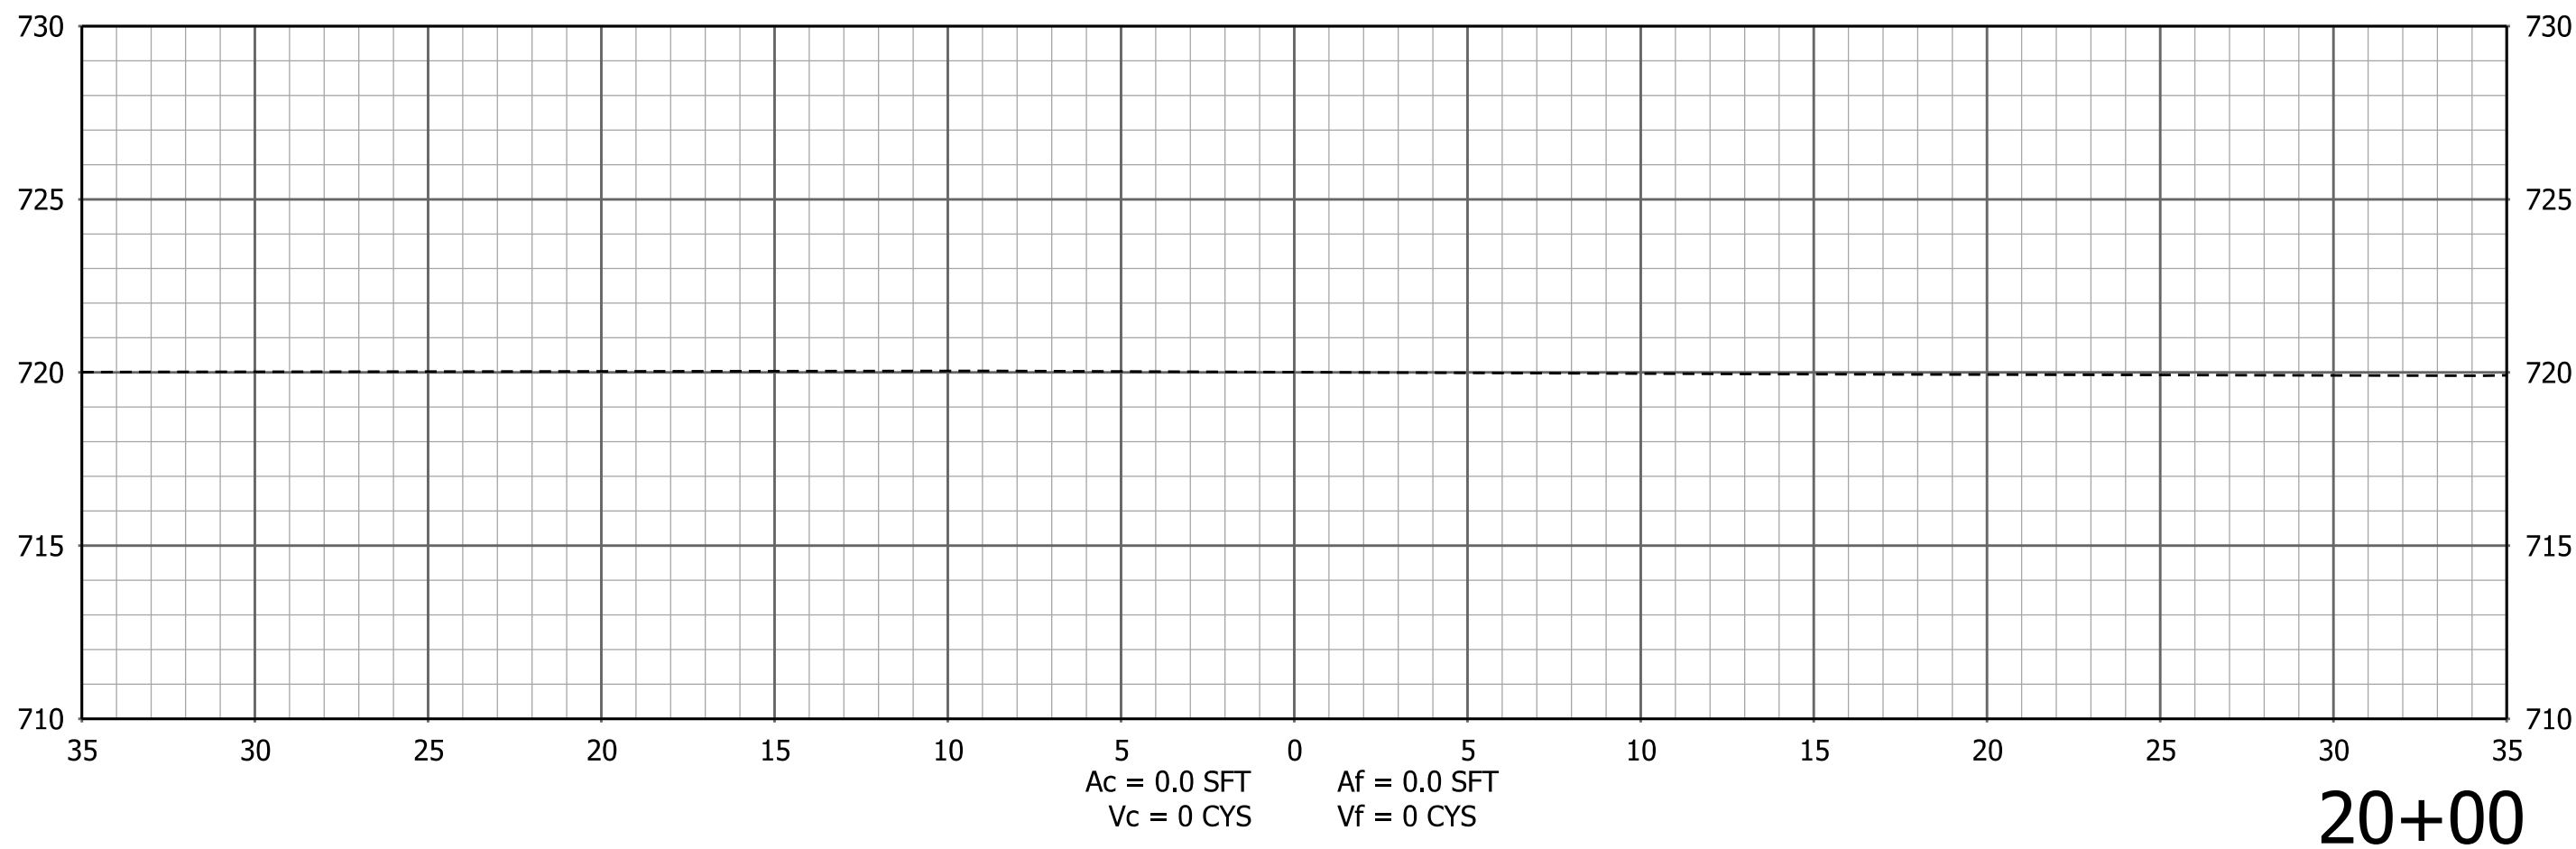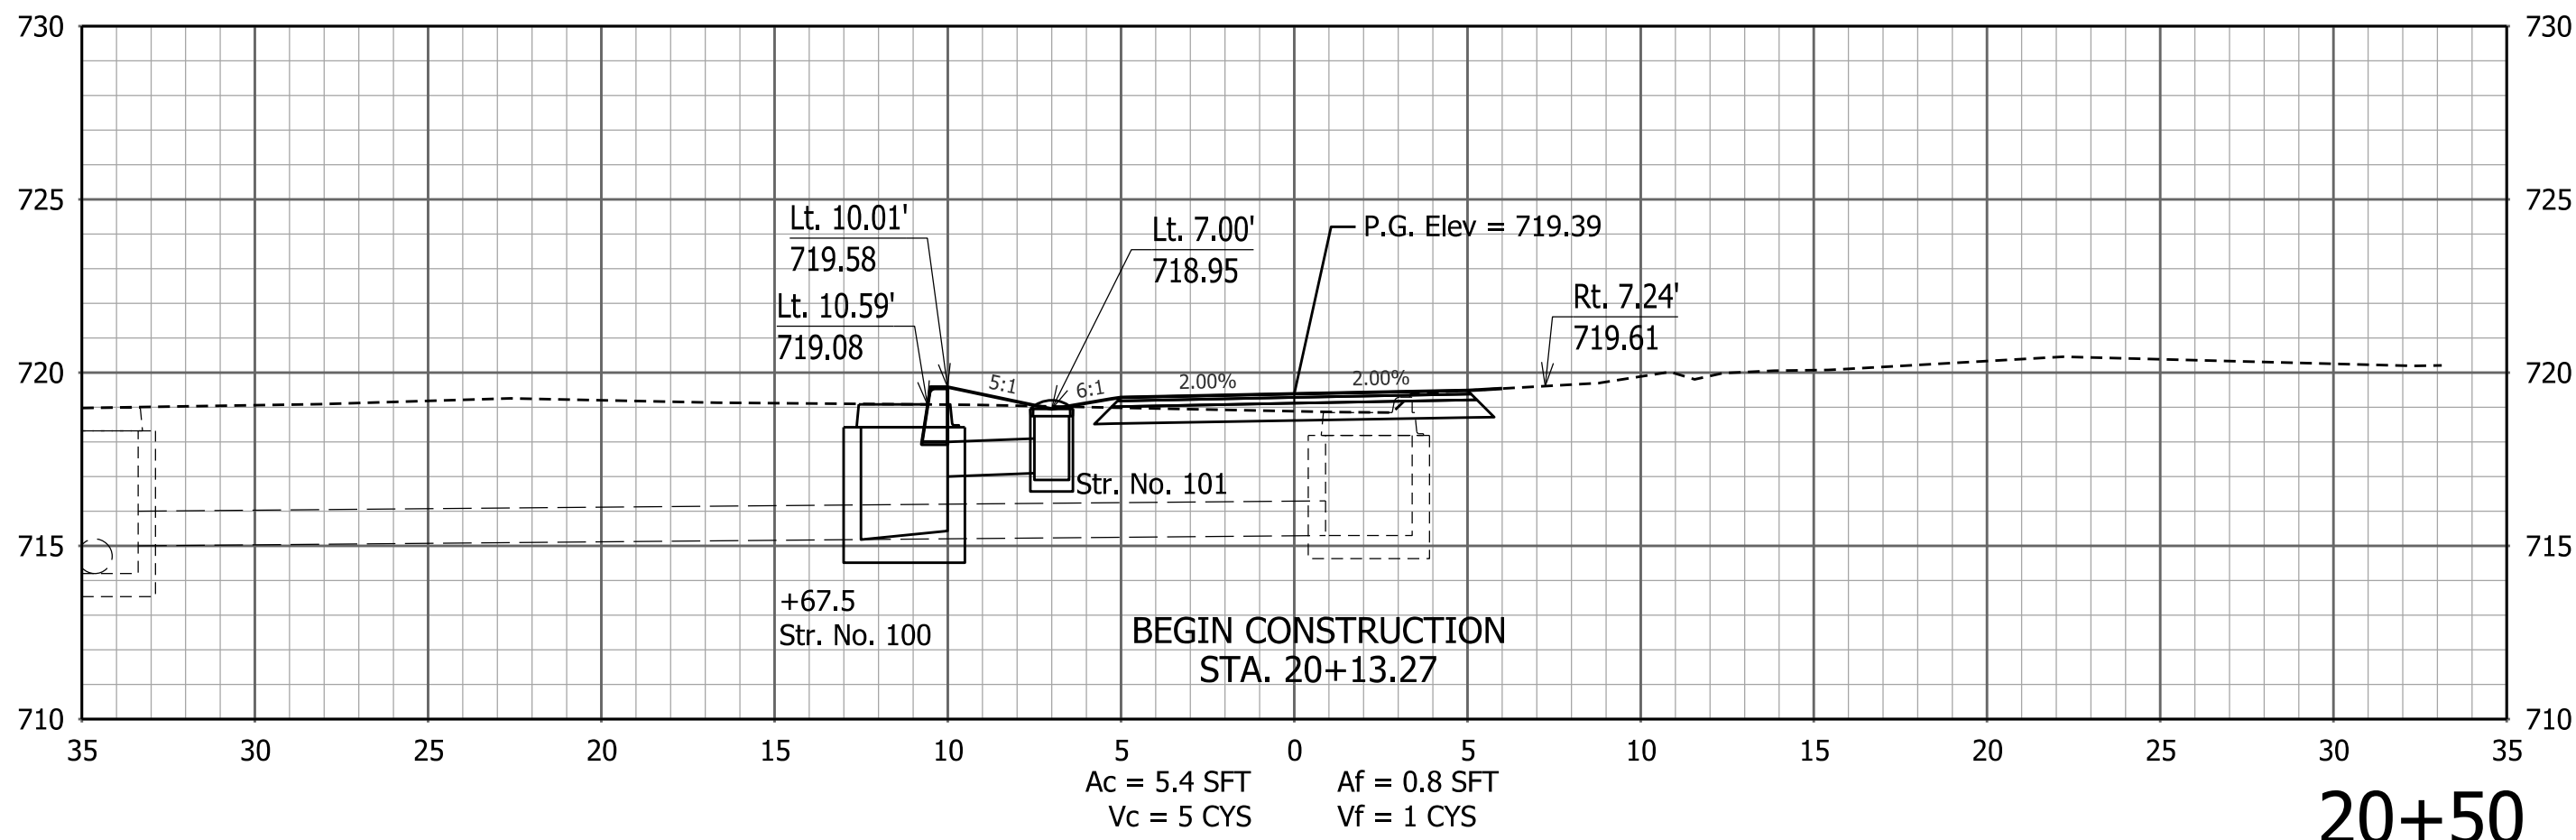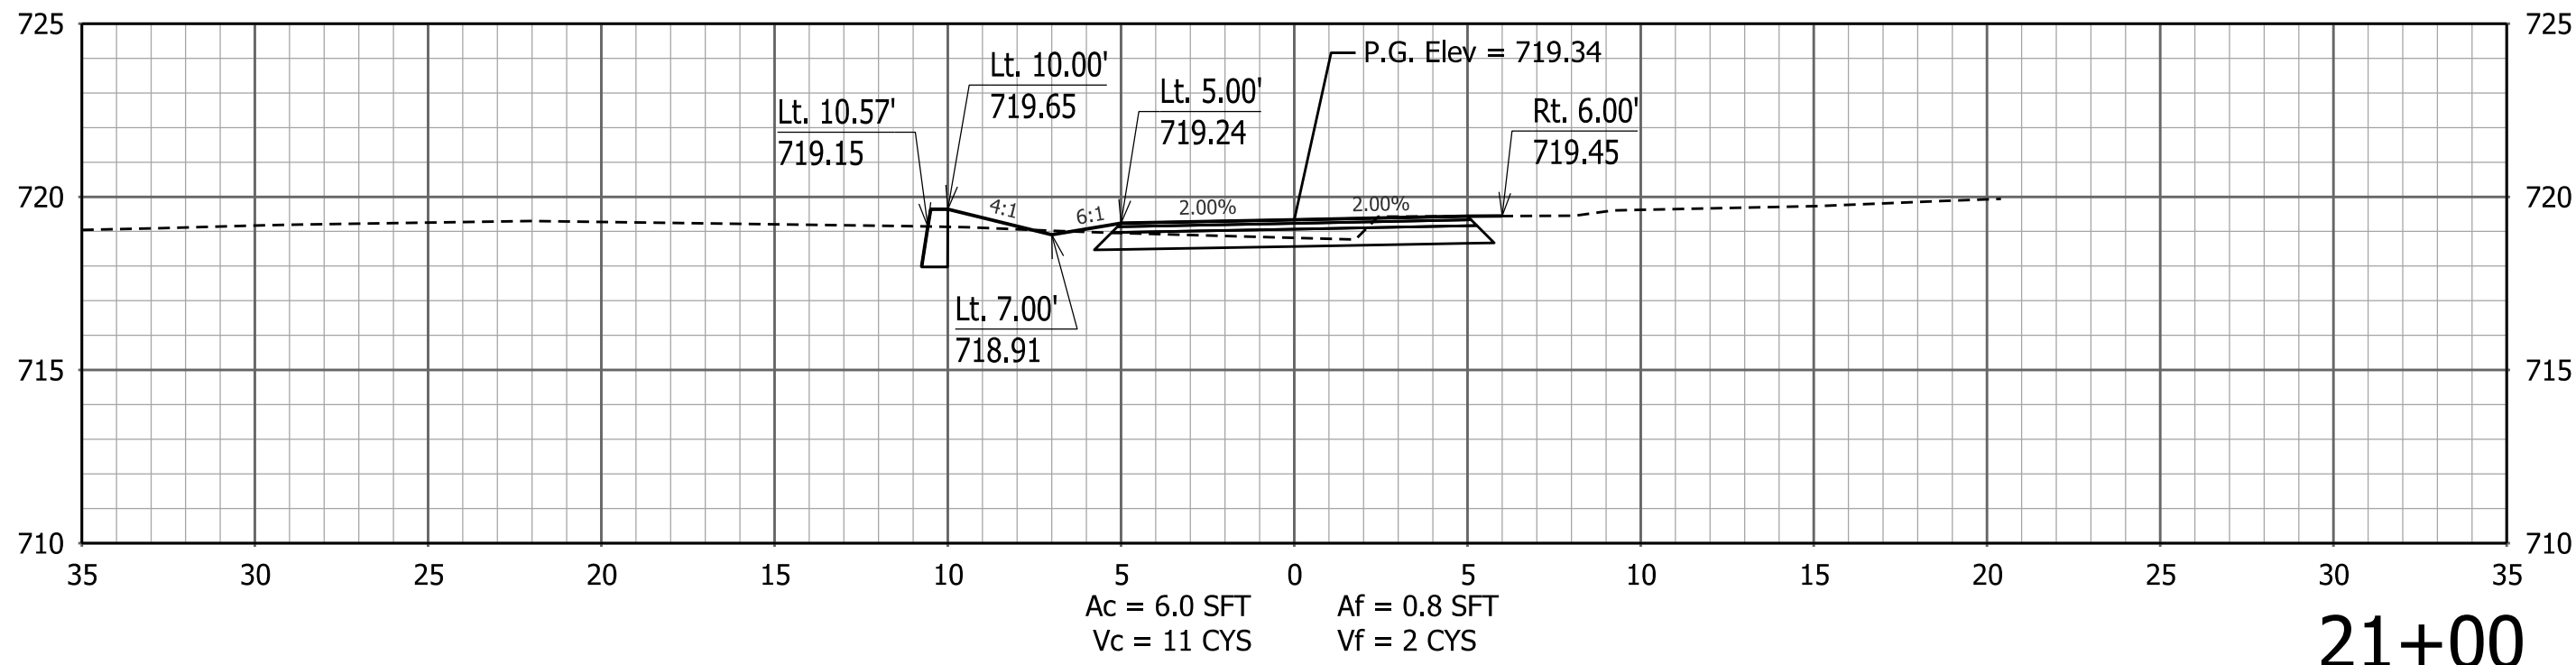

RECOMMENDED FOR APPROVAL _____ DESIGN ENGINEER DATE		CITY OF INDIANAPOLIS DEPARTMENT OF PUBLIC WORKS	SCALE		BRIDGE FILE				
			1" = 5'						
					DESIGNATION				
DESIGNED: _____ VA		DRAWN: _____ JSS		CROSS SECTIONS LINE "P"		SURVEY BOOK		SHEETS	
						XS 41		of XS 47	
CHECKED: _____ ACD		CHECKED: _____ VA				CONTRACT		PROJECT	
						PA-25-001			









STA. 20+00 TO STA. 22+50

PATH AND FILENAME: V:\Projects\IIN62\Planning and Urban Design\Projects\27813 Pogues Run Greenway\30 SheetDrawings\40 CrossSections\Sht Xsec 5_PH1_01.dgn
MODEL NAME: Default
DATE PLOTTED: 4/16/2015
TIME PLOTTED: 5:26:18 PM

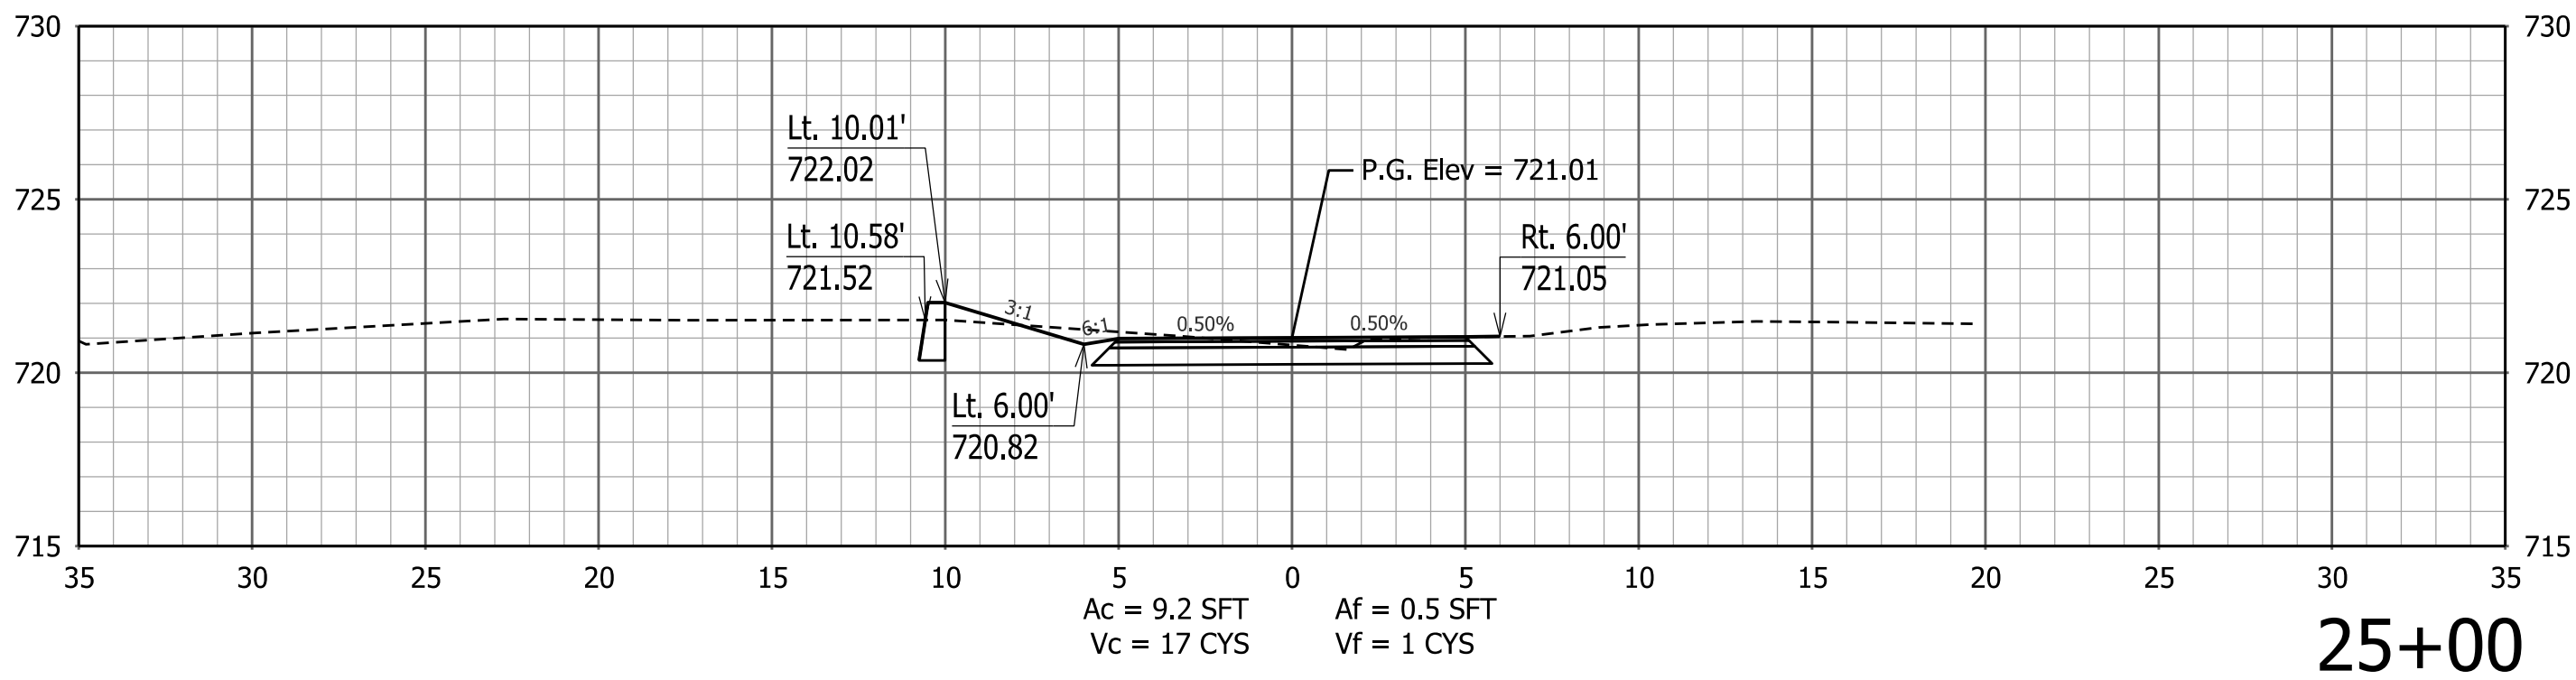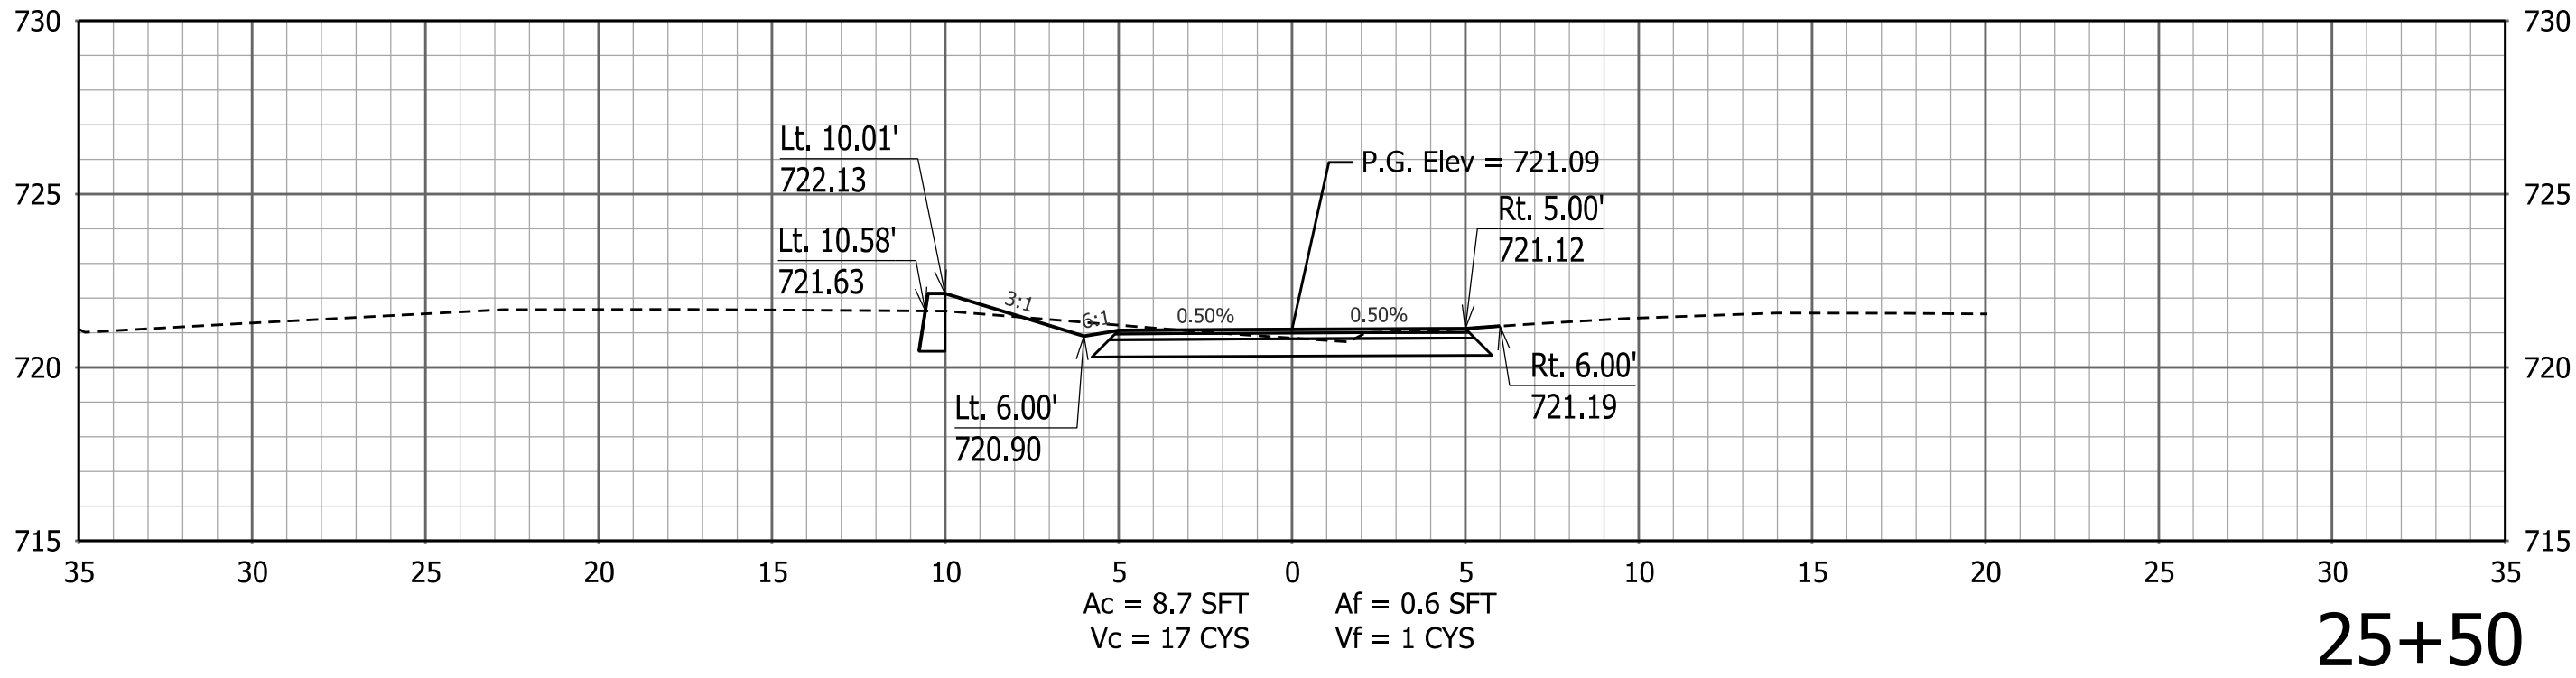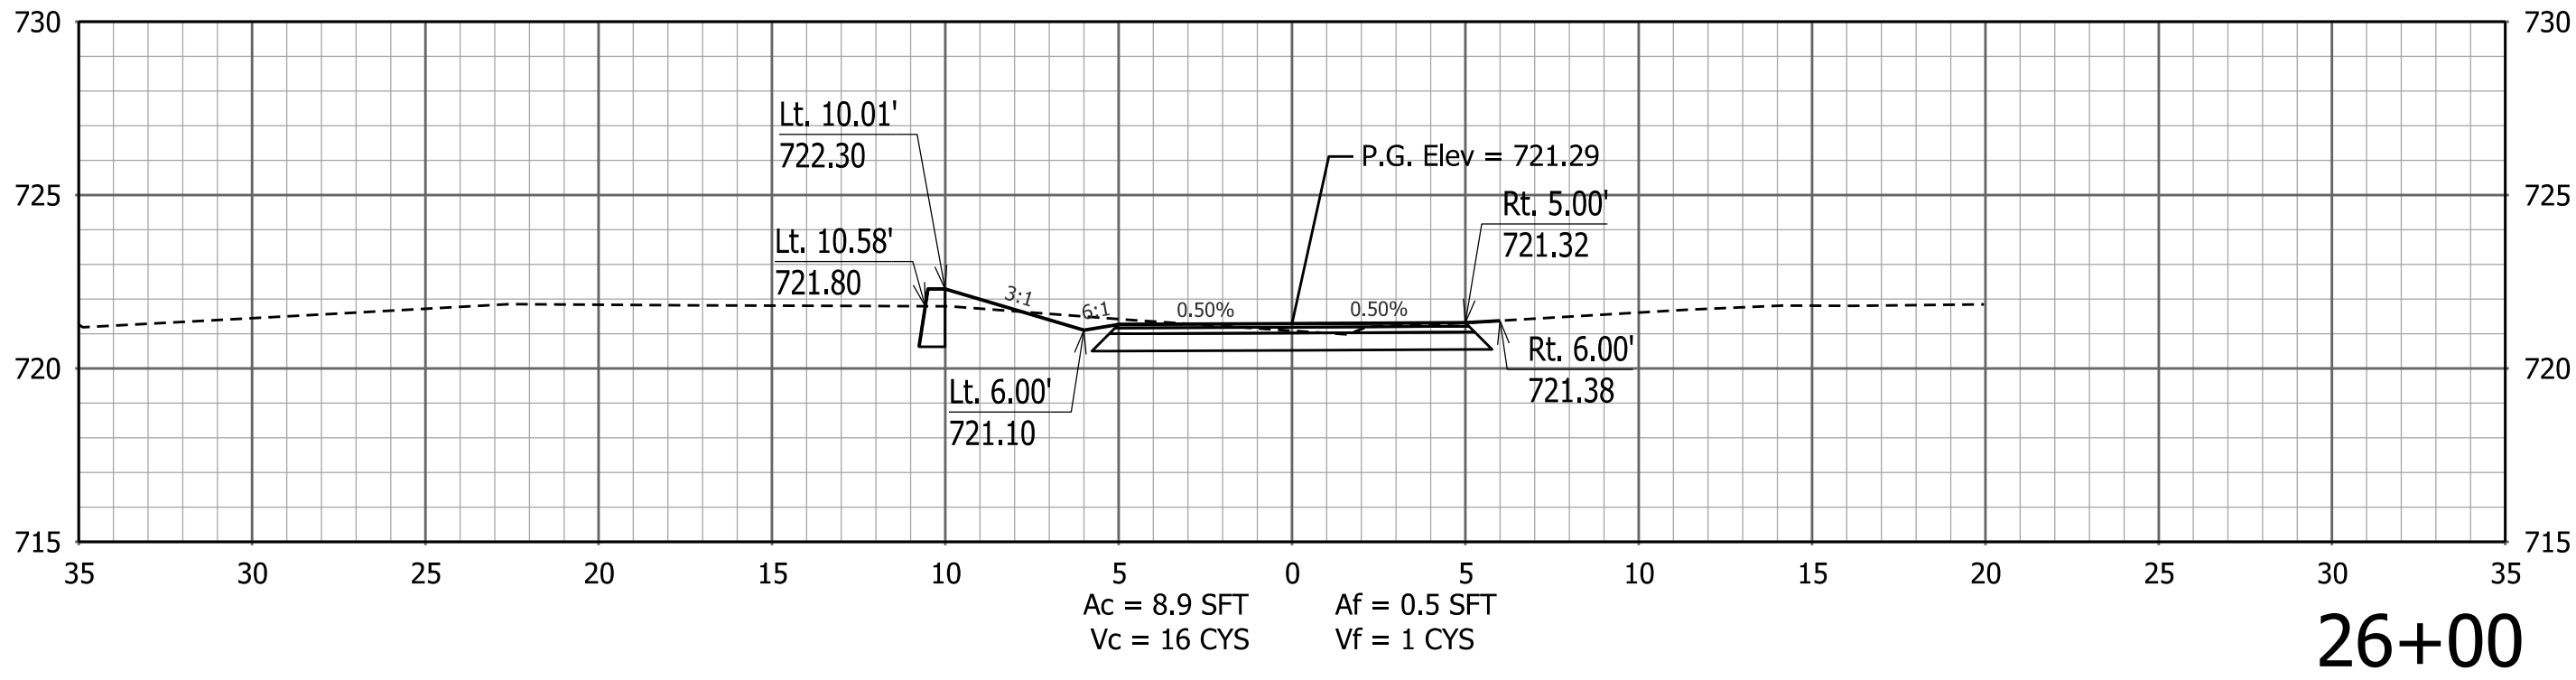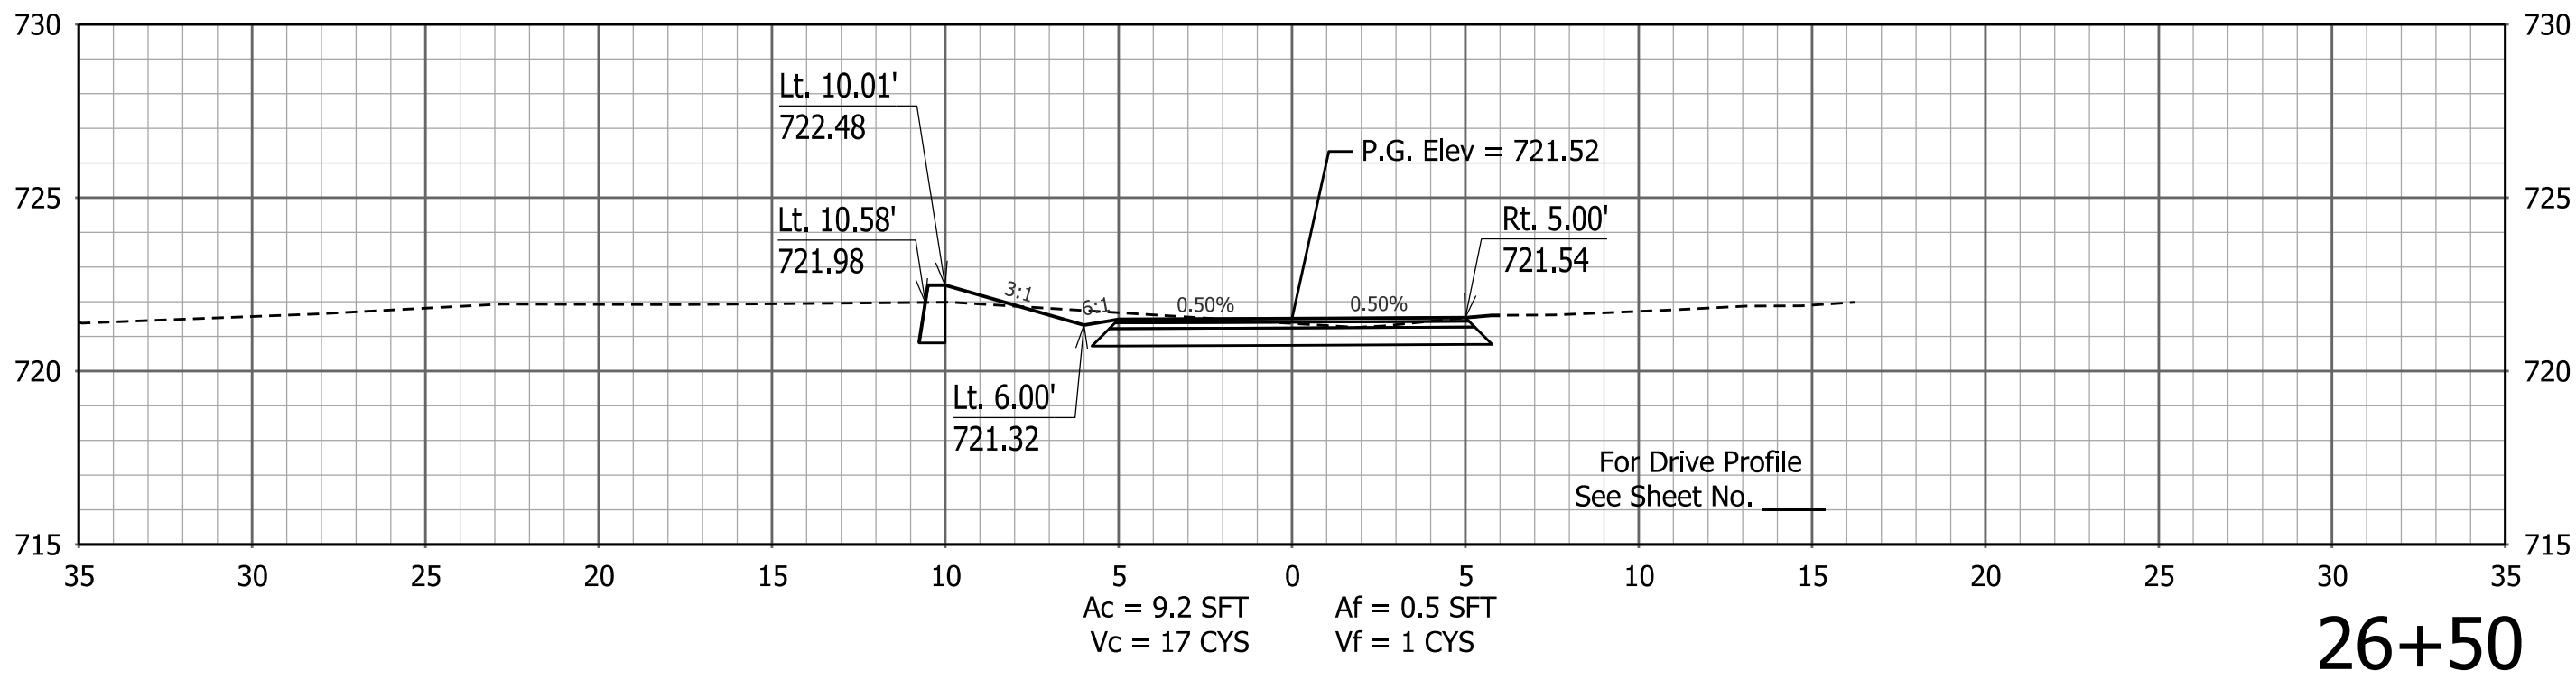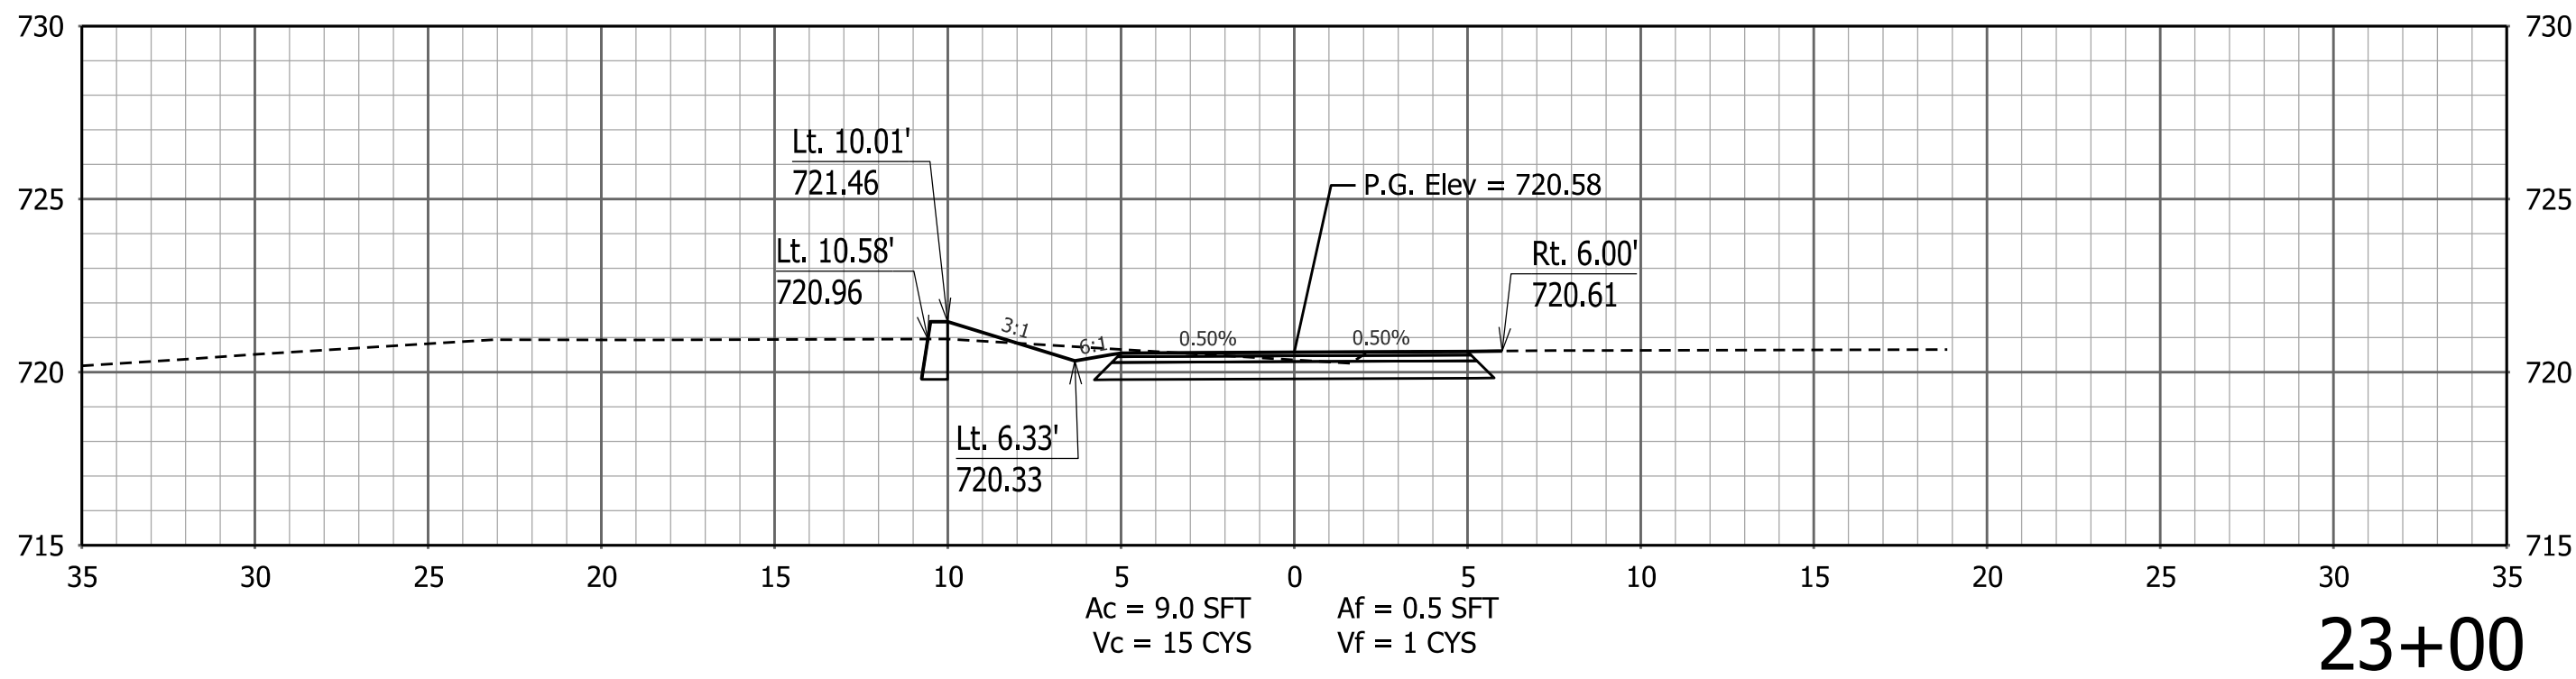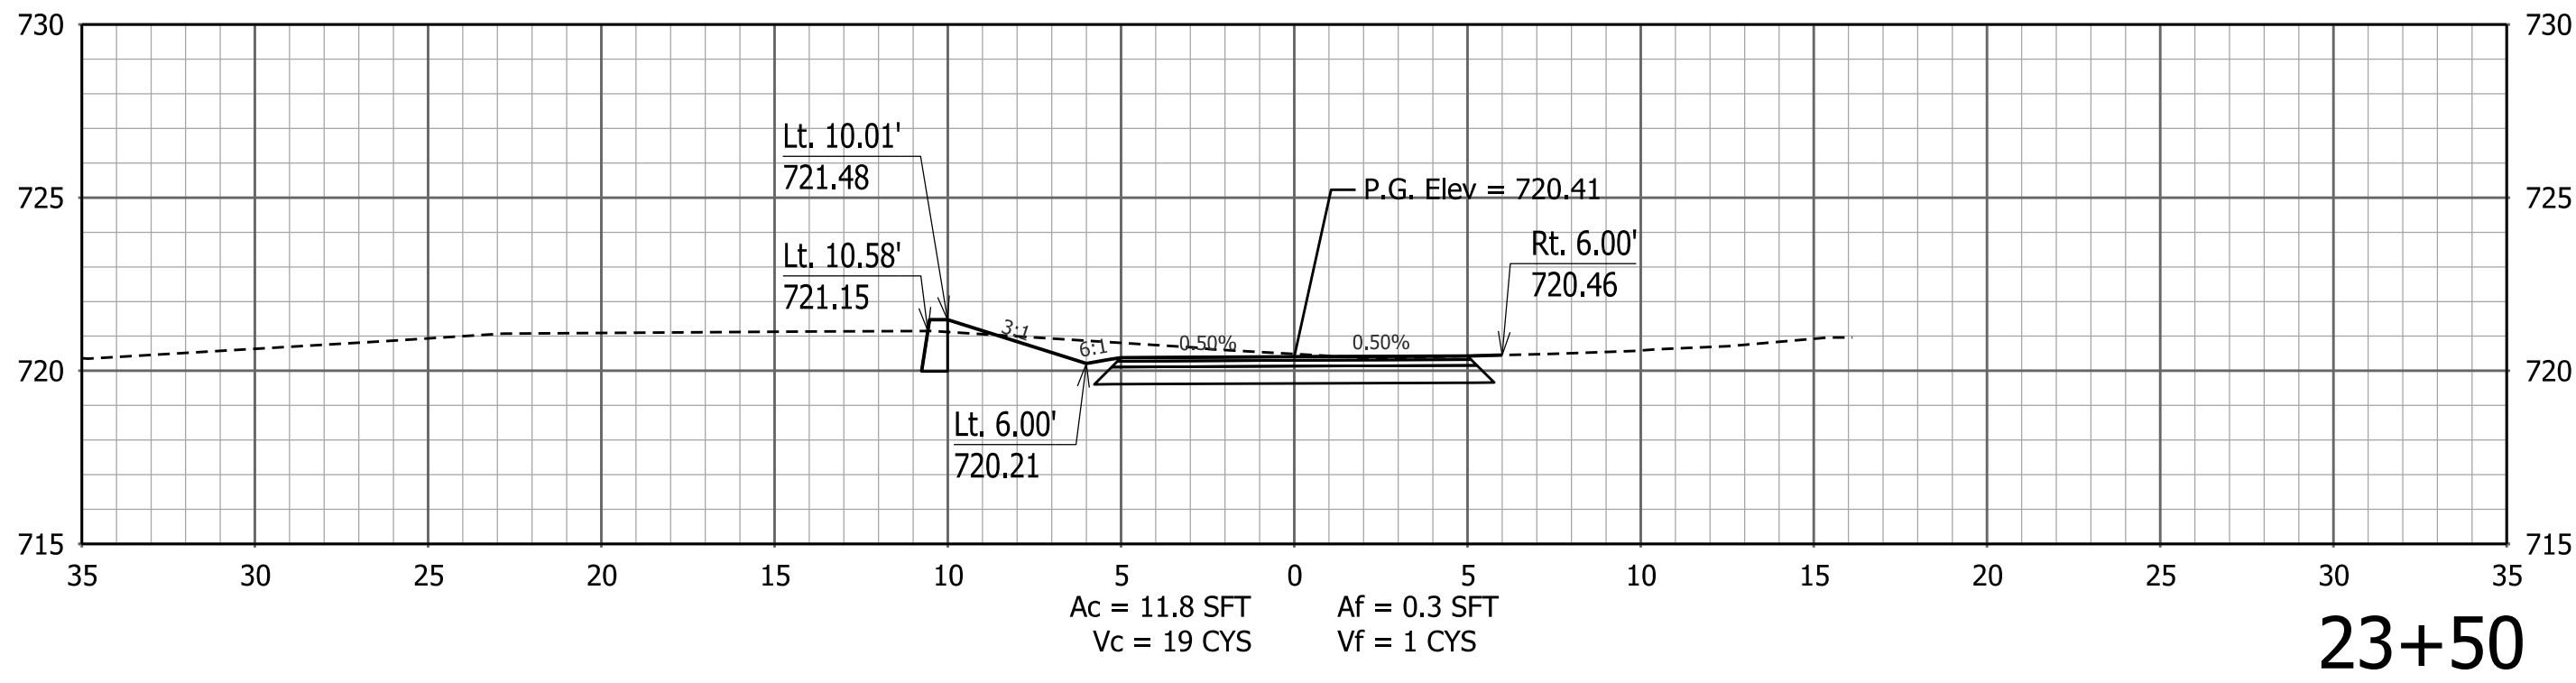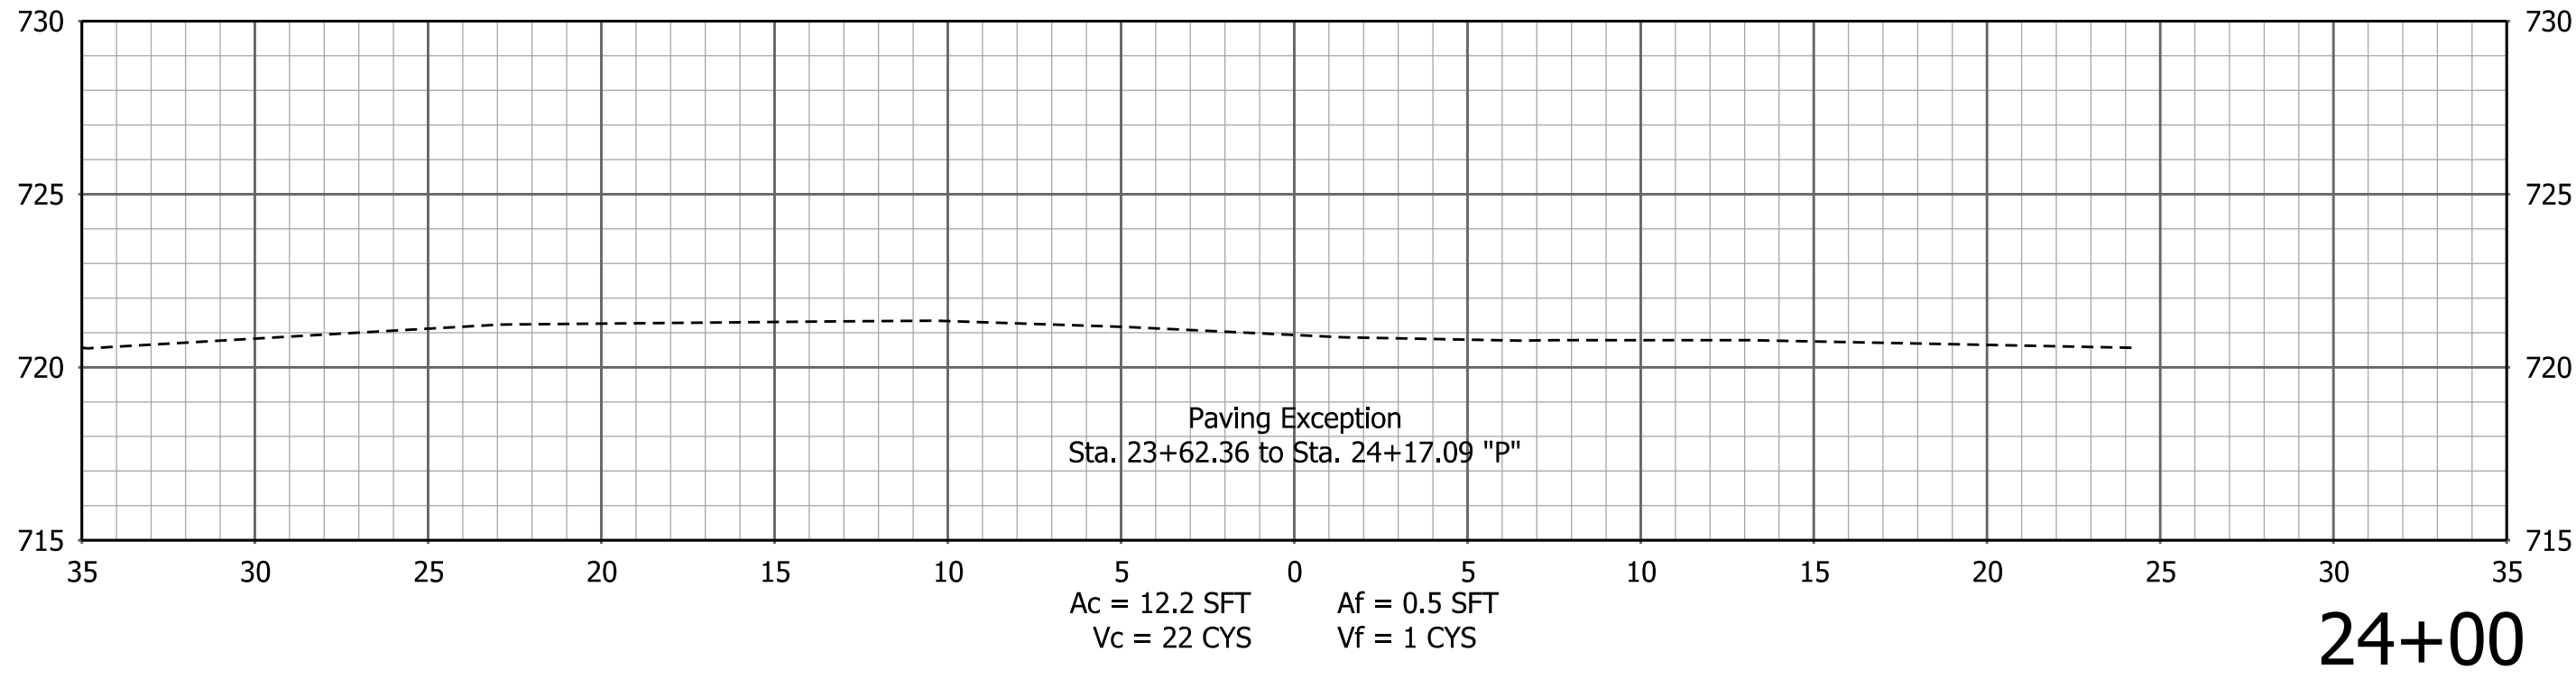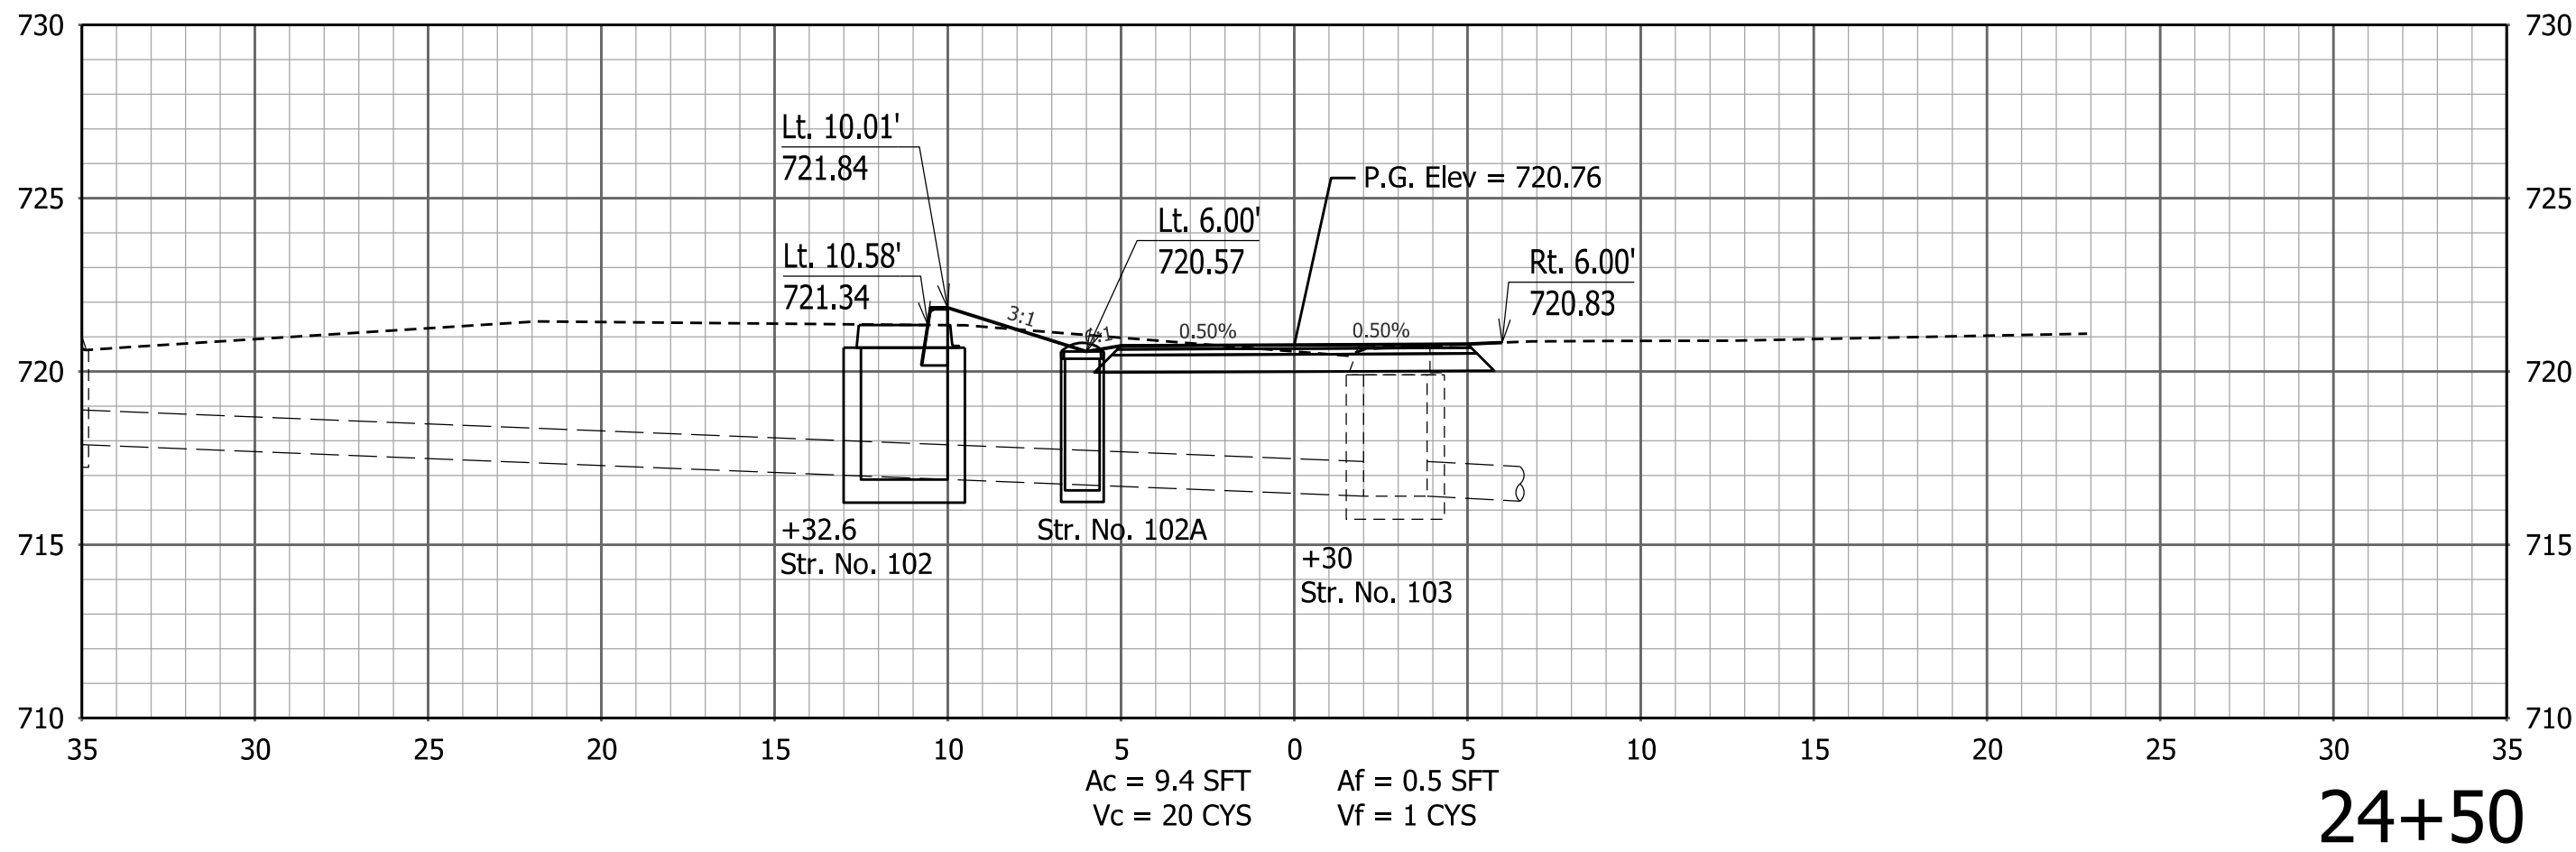

RECOMMENDED FOR APPROVAL	DESIGN ENGINEER	DATE	CITY OF INDIANAPOLIS DEPARTMENT OF PUBLIC WORKS		SCALE 1" = 5'	BRIDGE FILE
						DESIGNATION
DESIGNED: VA	DRAWN: JSS		CROSS SECTIONS LINE "P"		SURVEY BOOK	SHEETS XS 42 of XS 47
CHECKED: ACD	CHECKED: VA				CONTRACT	PROJECT PA-25-001









PATH AND FILENAME: V:\Projects\IIN62\Planning and Urban Design\Projects\27813 Pogues Run Greenway\30 SheetDrawings\40 CrossSections\Sht Xsec 5_PH1_01.dgn
MODEL NAME: Default
DATE PLOTTED: 4/16/2015
TIME PLOTTED: 5:26:20 PM

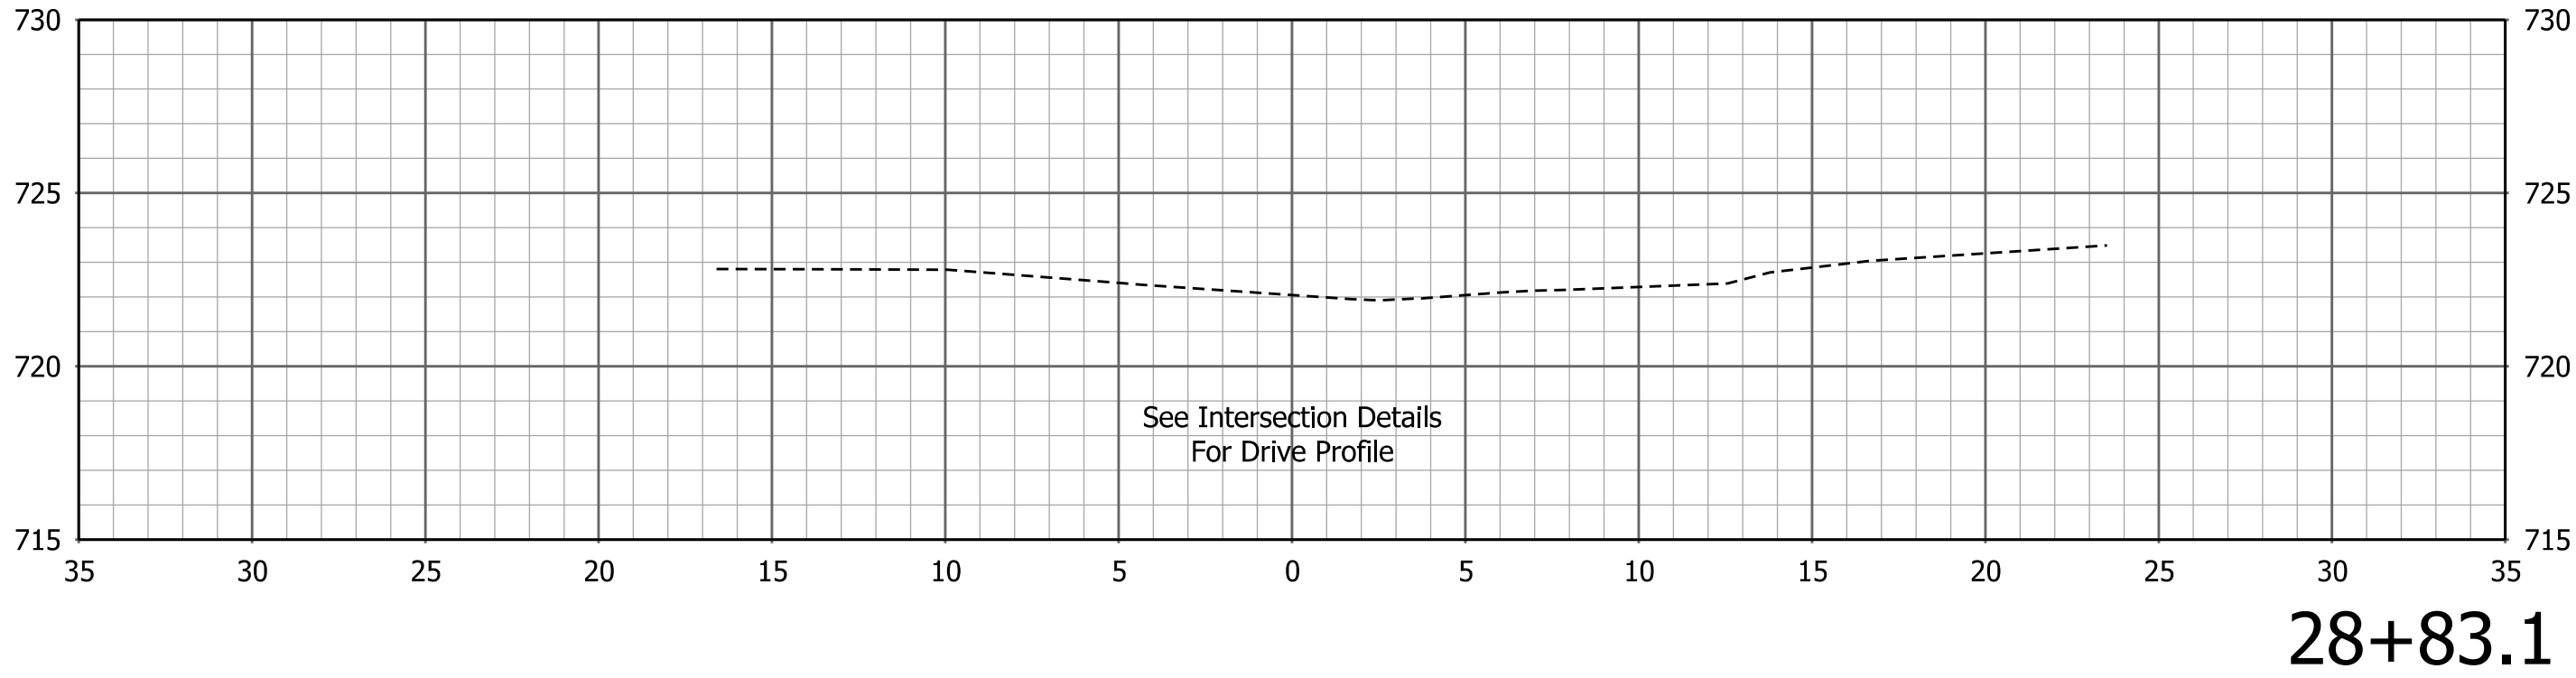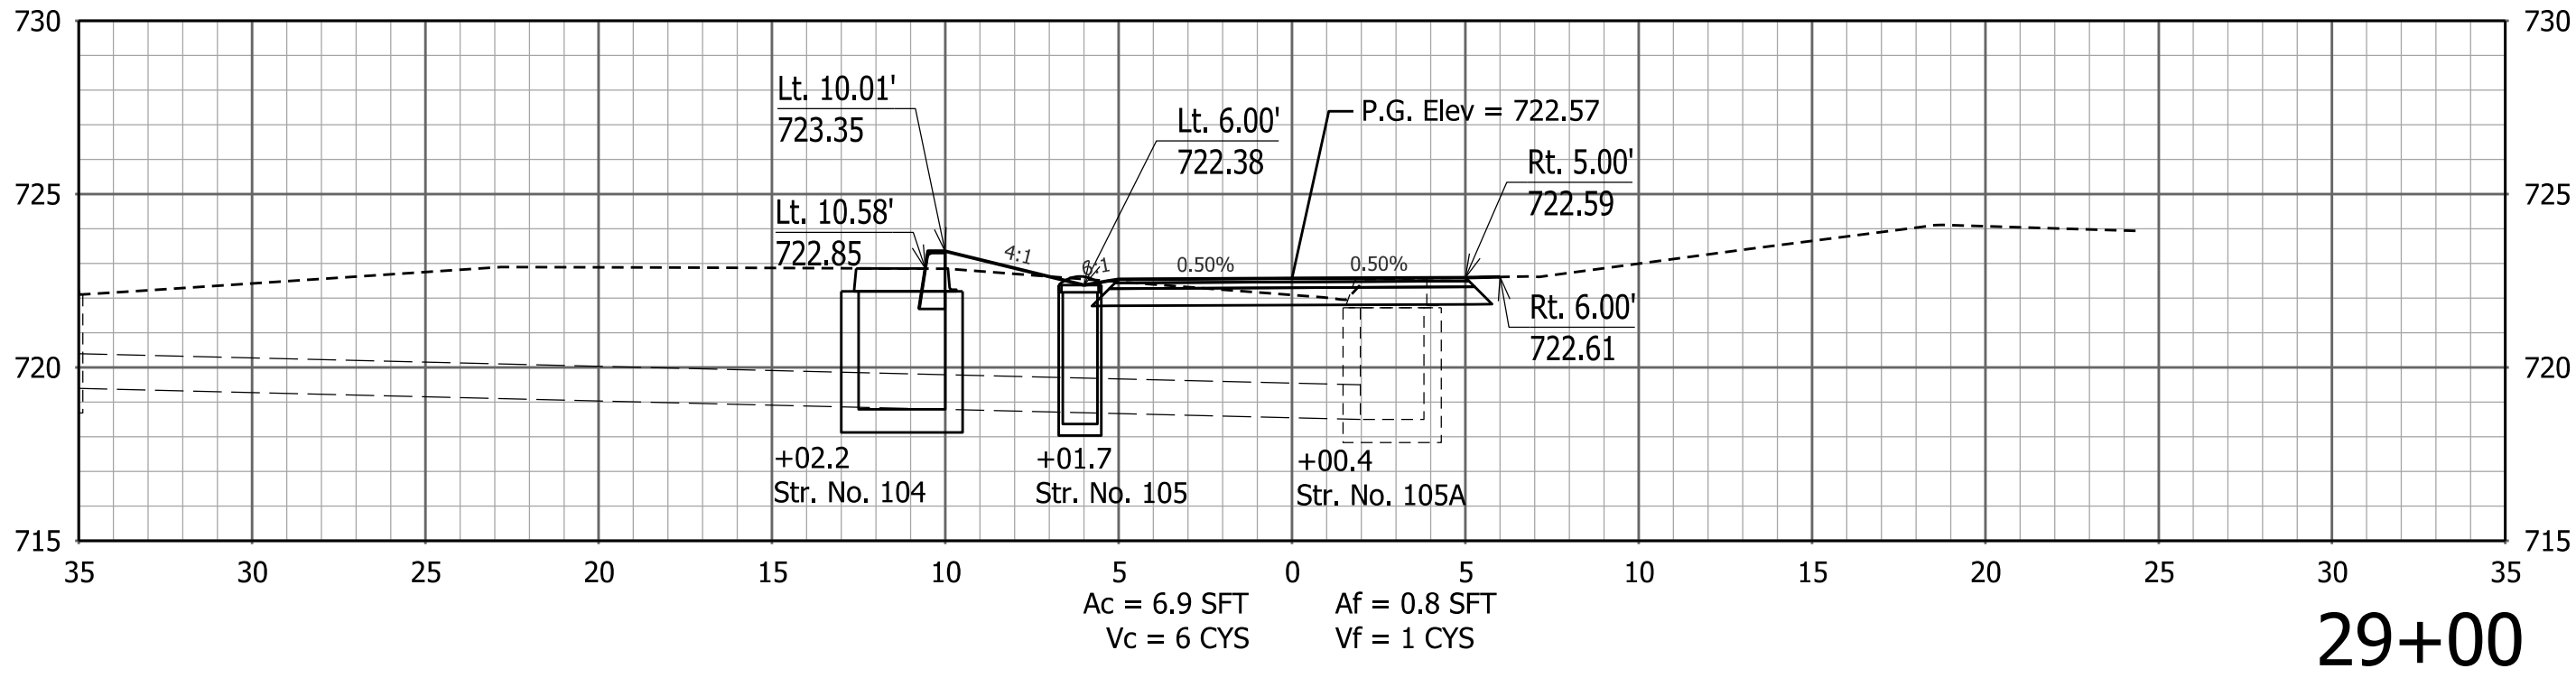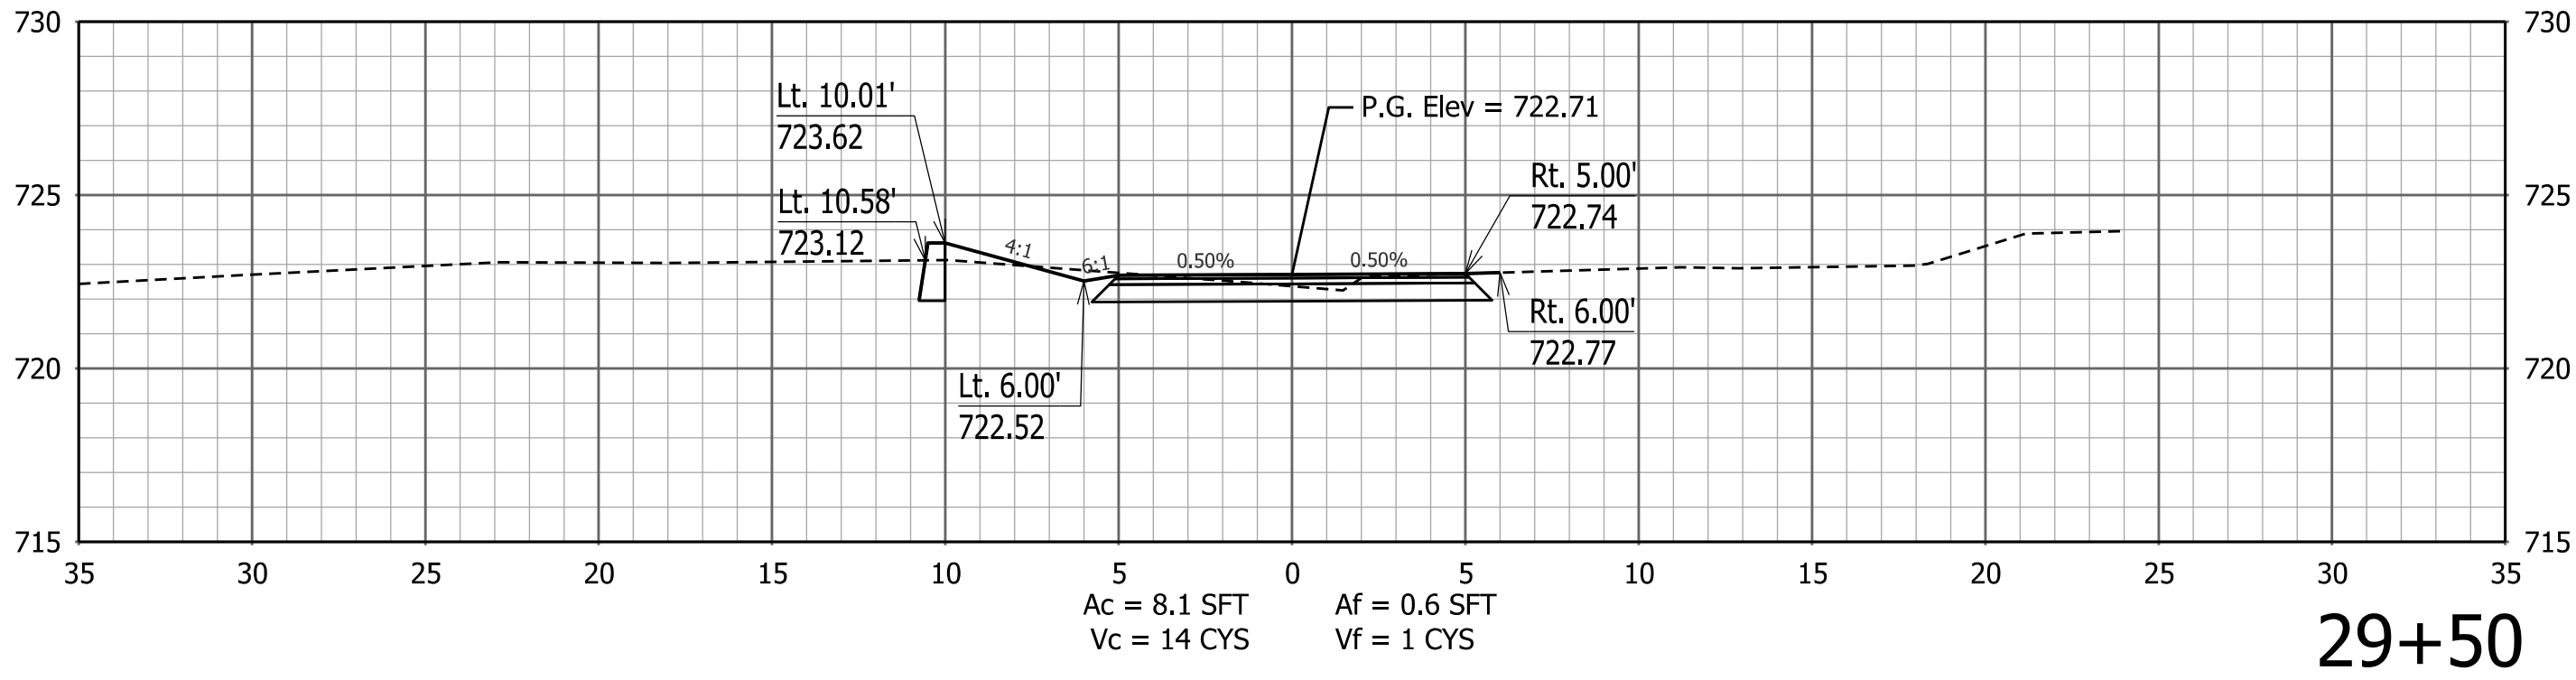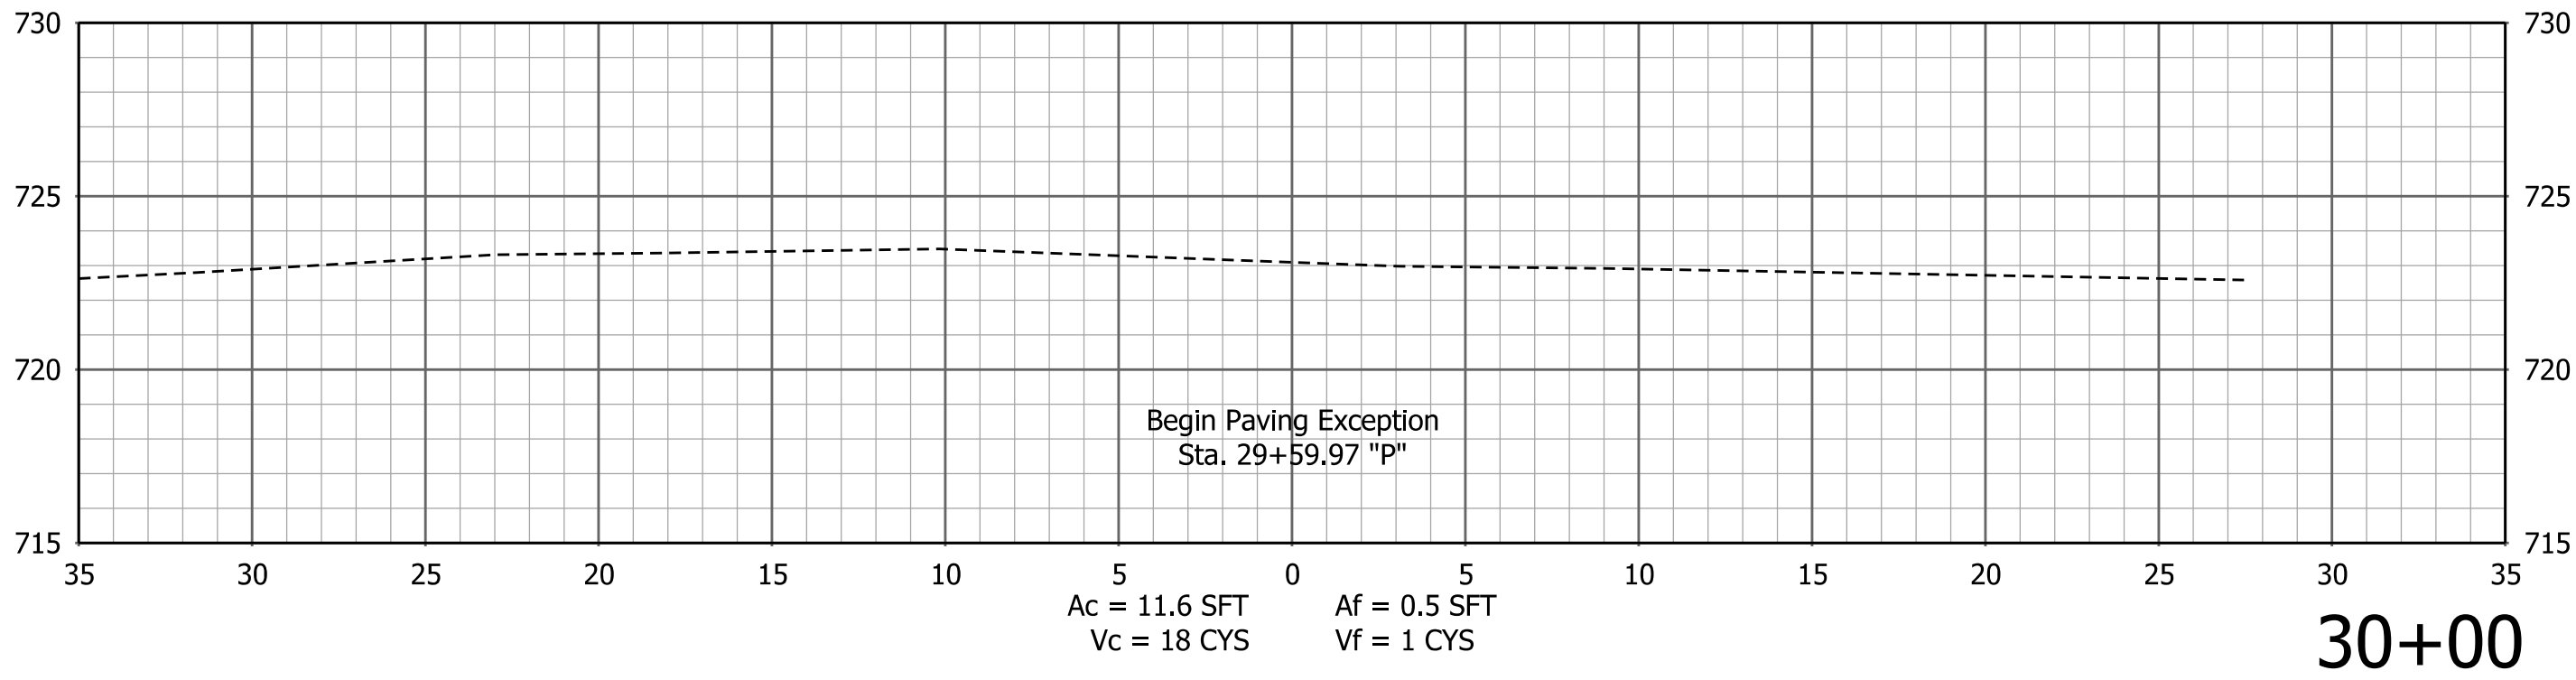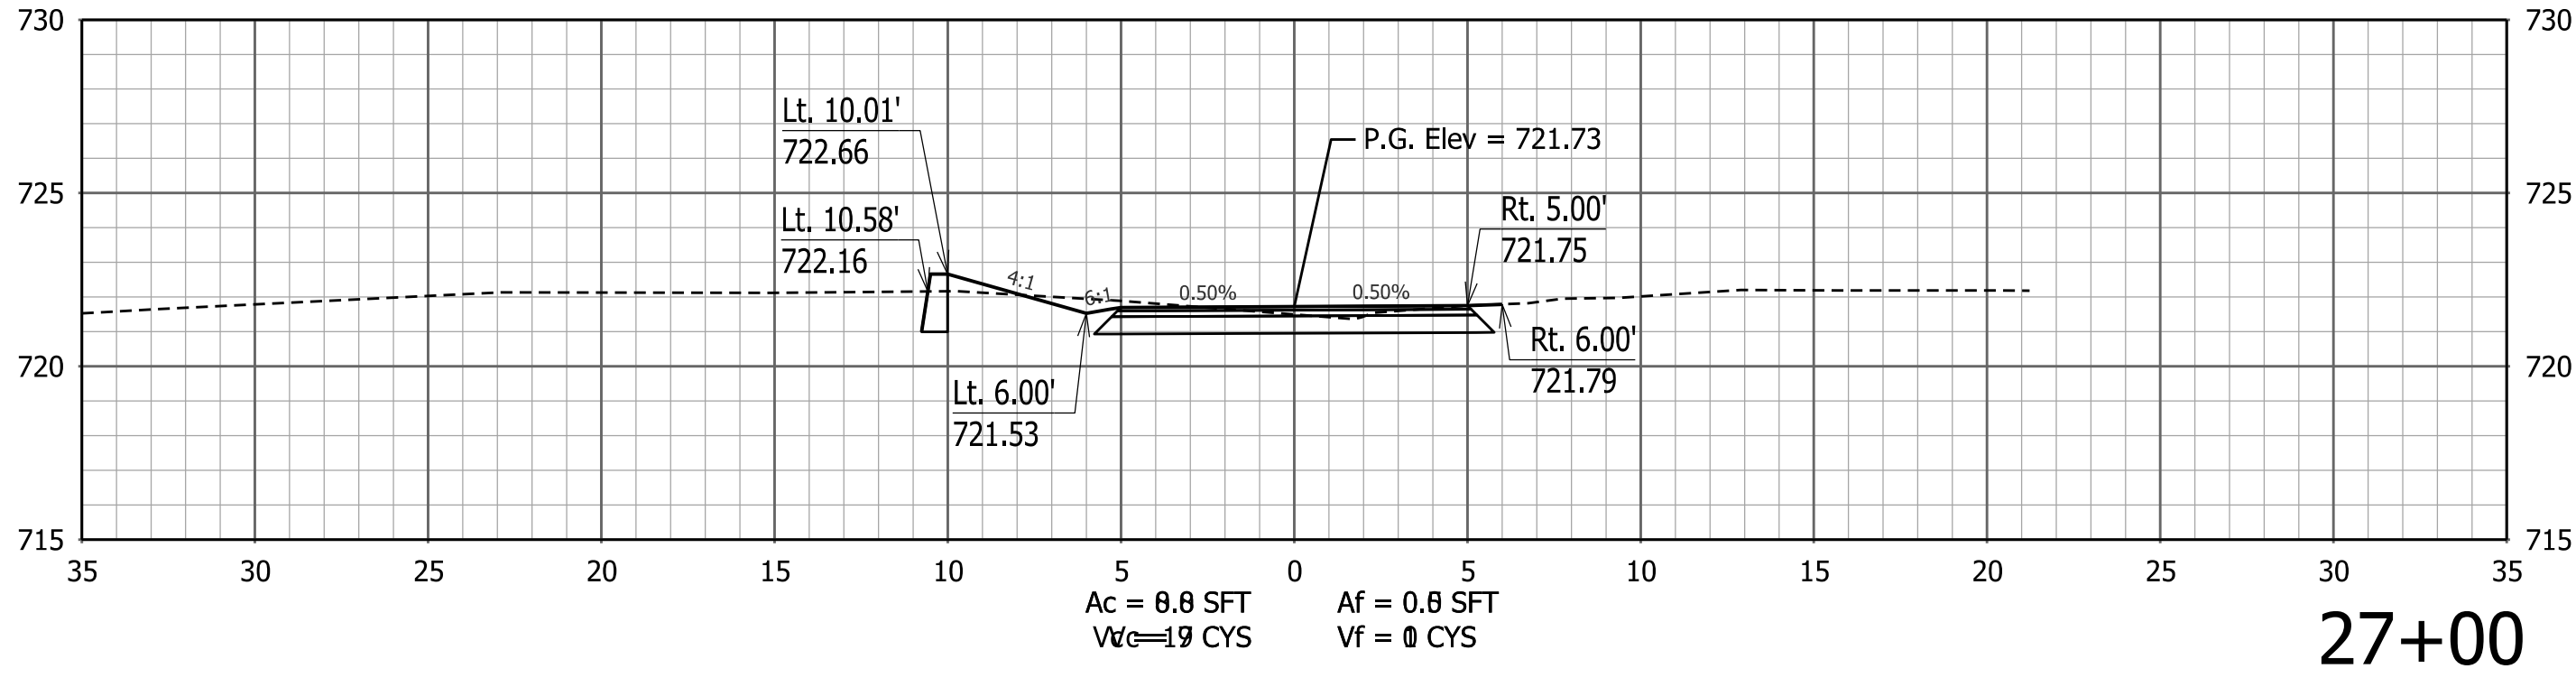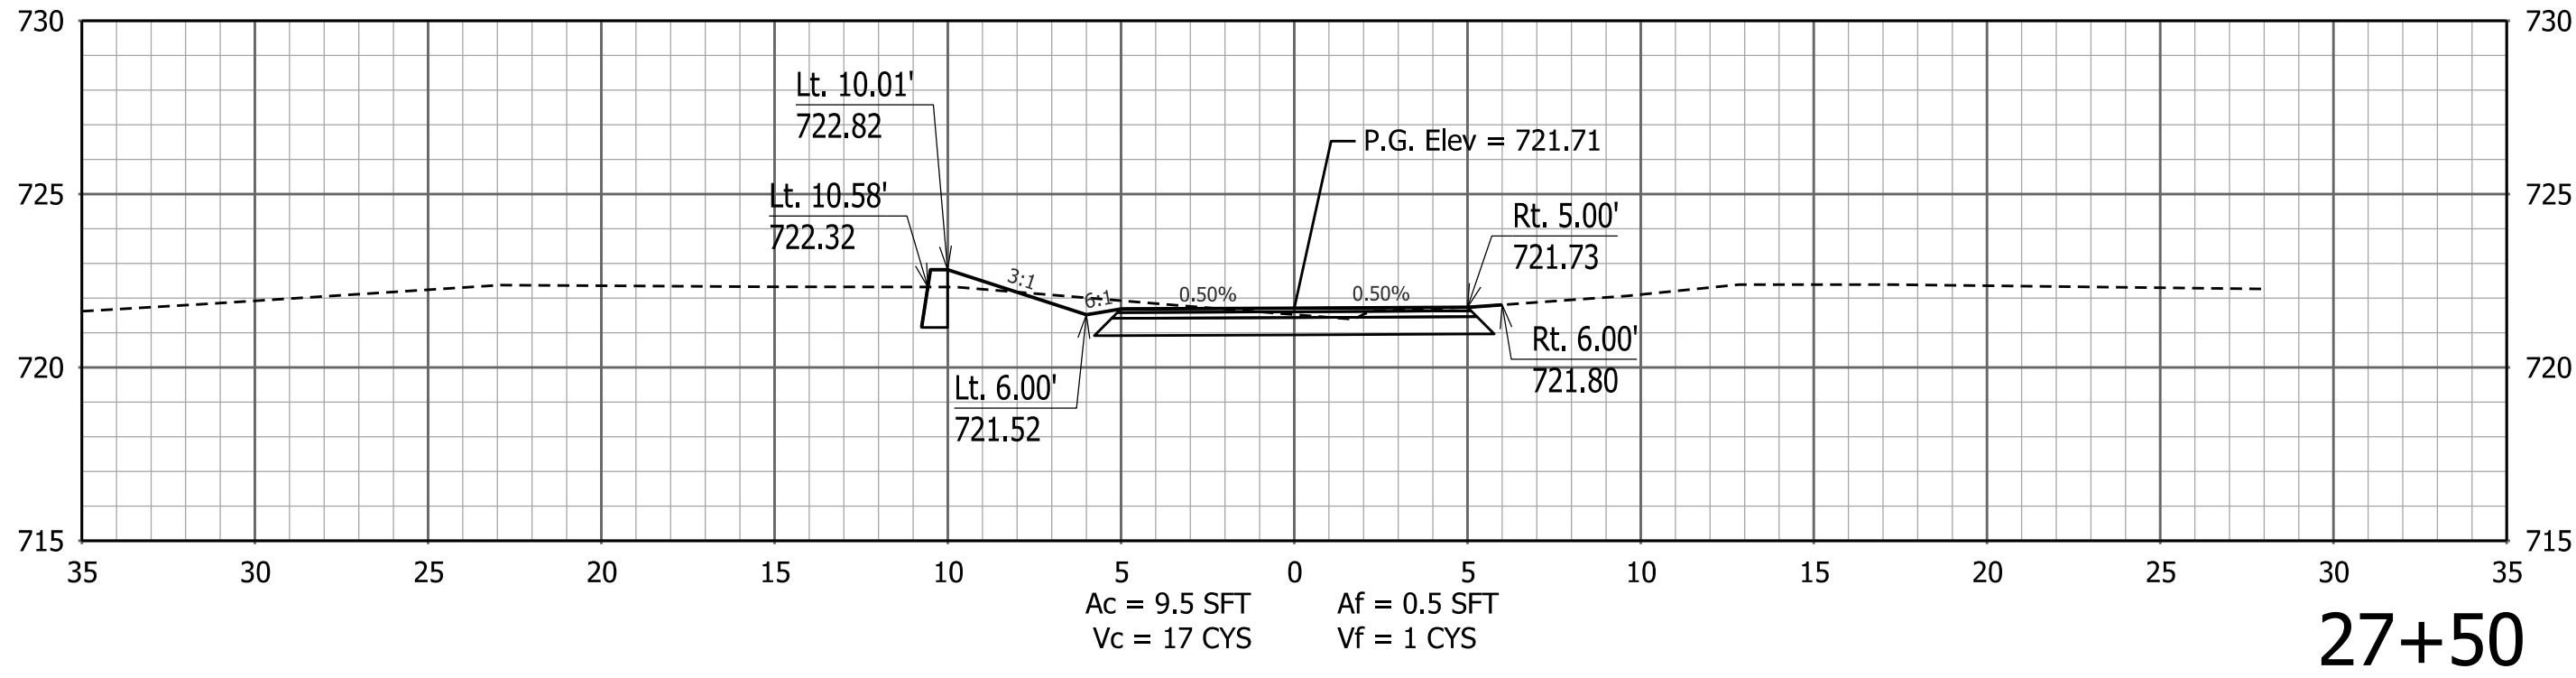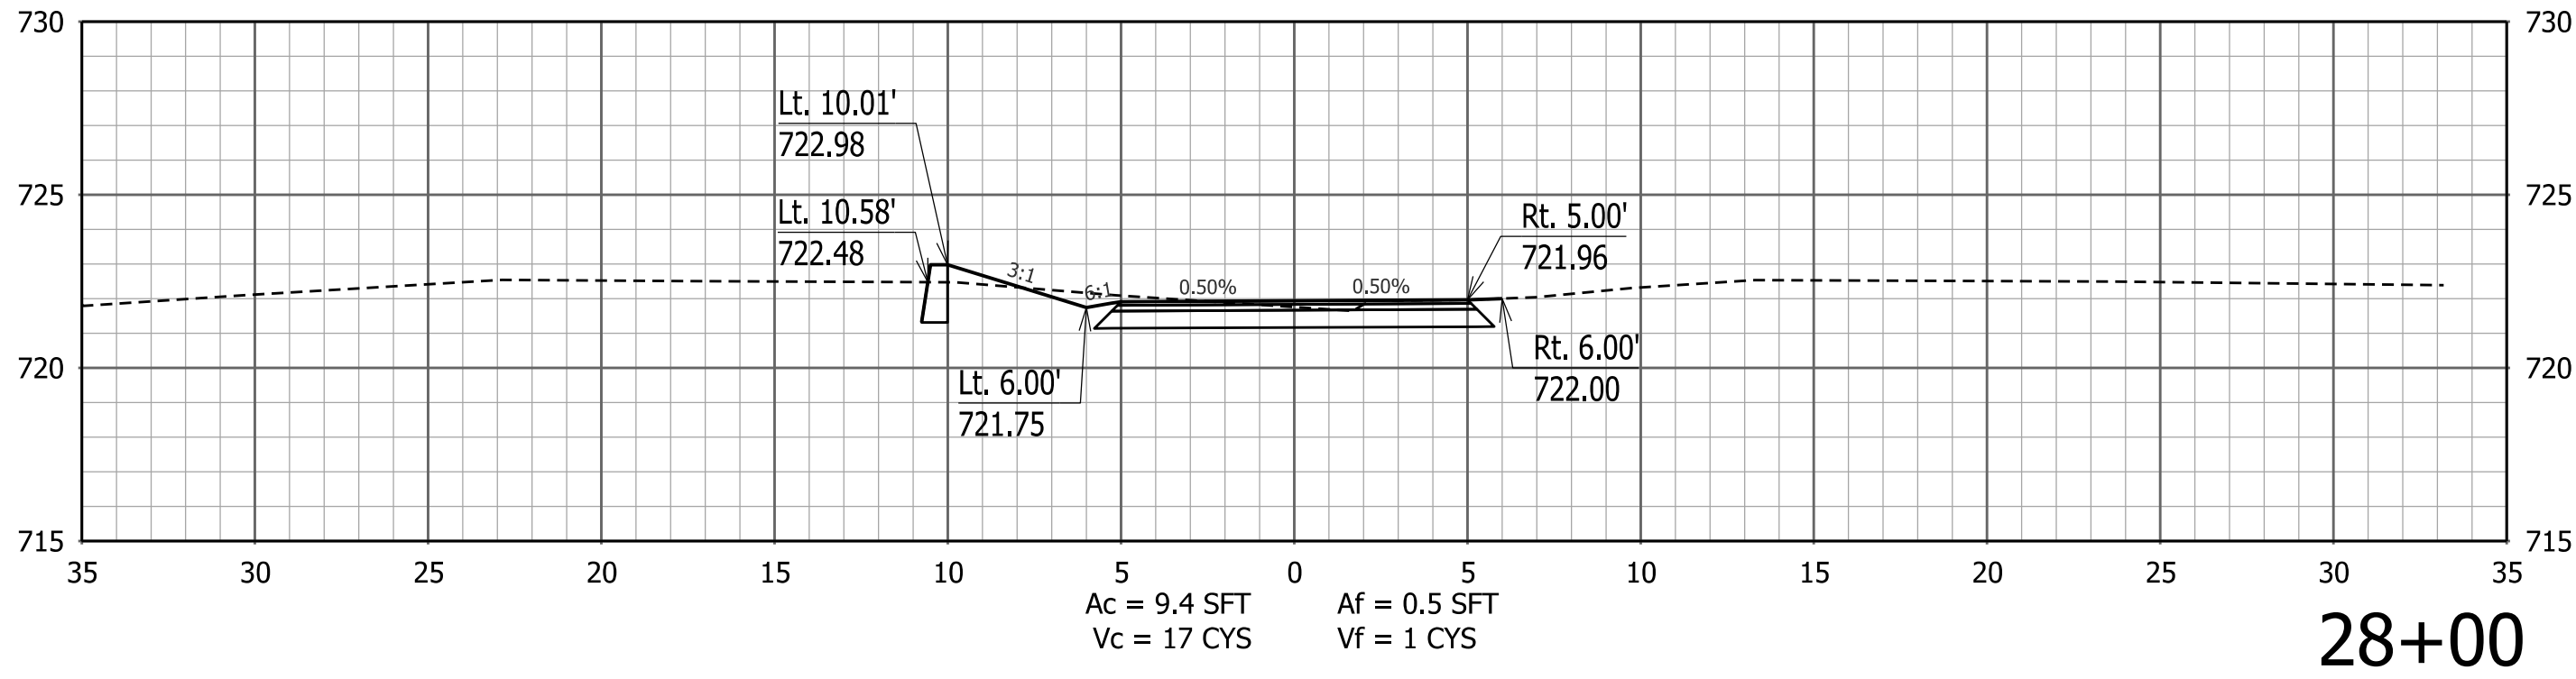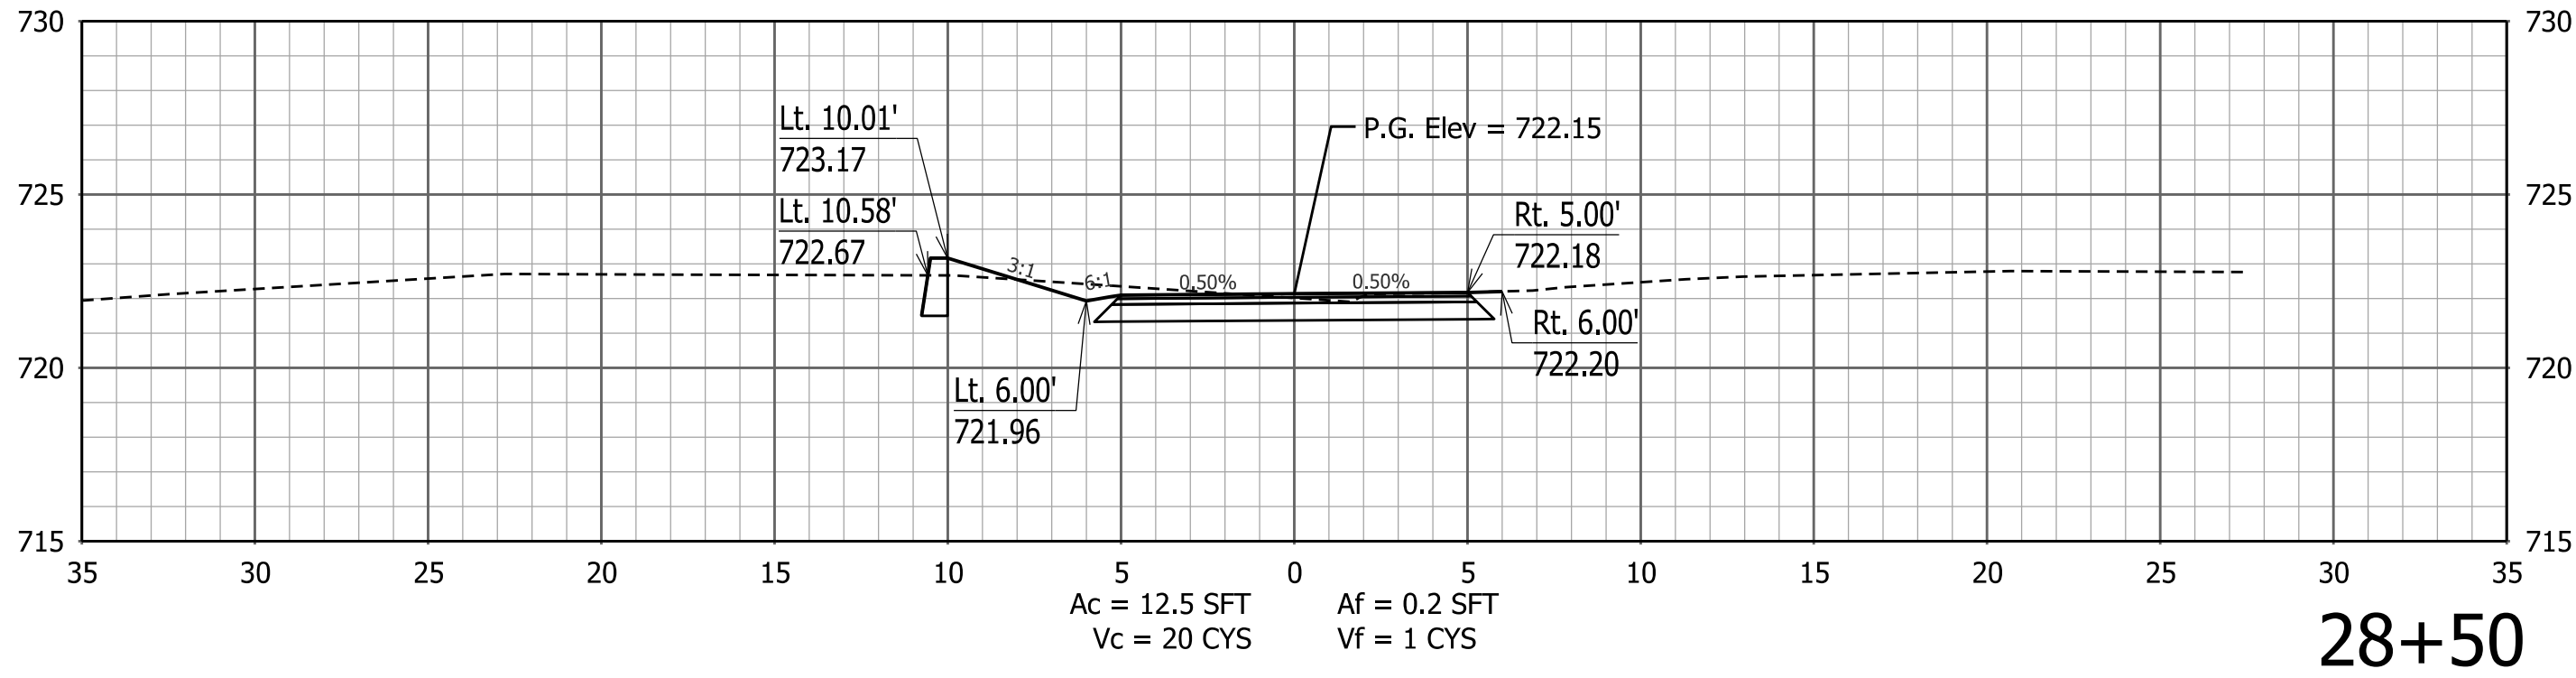

RECOMMENDED FOR APPROVAL			CITY OF INDIANAPOLIS DEPARTMENT OF PUBLIC WORKS	SCALE	BRIDGE FILE		
				1" = 5'			
				DESIGNATION			
DESIGN ENGINEER		DATE	CROSS SECTIONS LINE "P"	SURVEY BOOK		SHEETS	
DESIGNED: VA	DRAWN: JSS				XS 43	of	XS 47
CHECKED: ACD	CHECKED: VA			CONTRACT		PROJECT	
						PA-25-001	

STA. 26+50 TO STA. 30+00







PATH AND FILENAME: V:\Projects\IIN62\Planning and Urban Design\Projects\27813 Pogues Run Greenway\30 SheetDrawings\40 CrossSections\Sht Xsec 5_PH1_01.dgn
MODEL NAME: Default
DATE PLOTTED: 4/16/2015
TIME PLOTTED: 5:26:20 PM

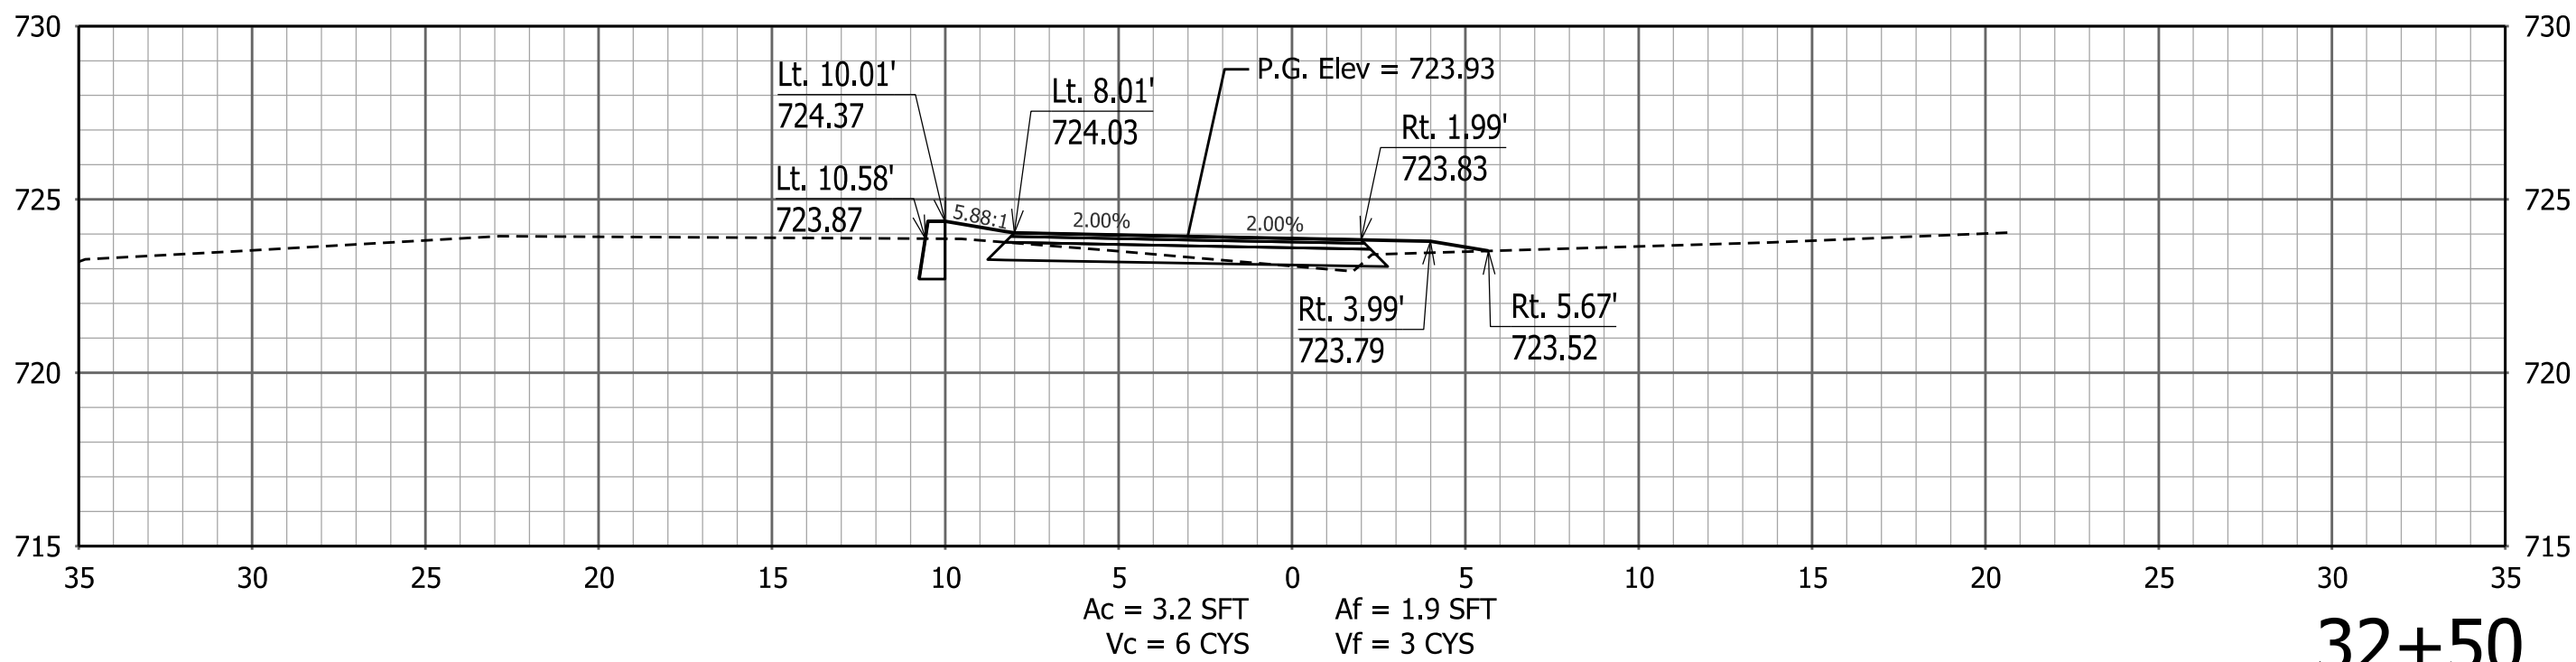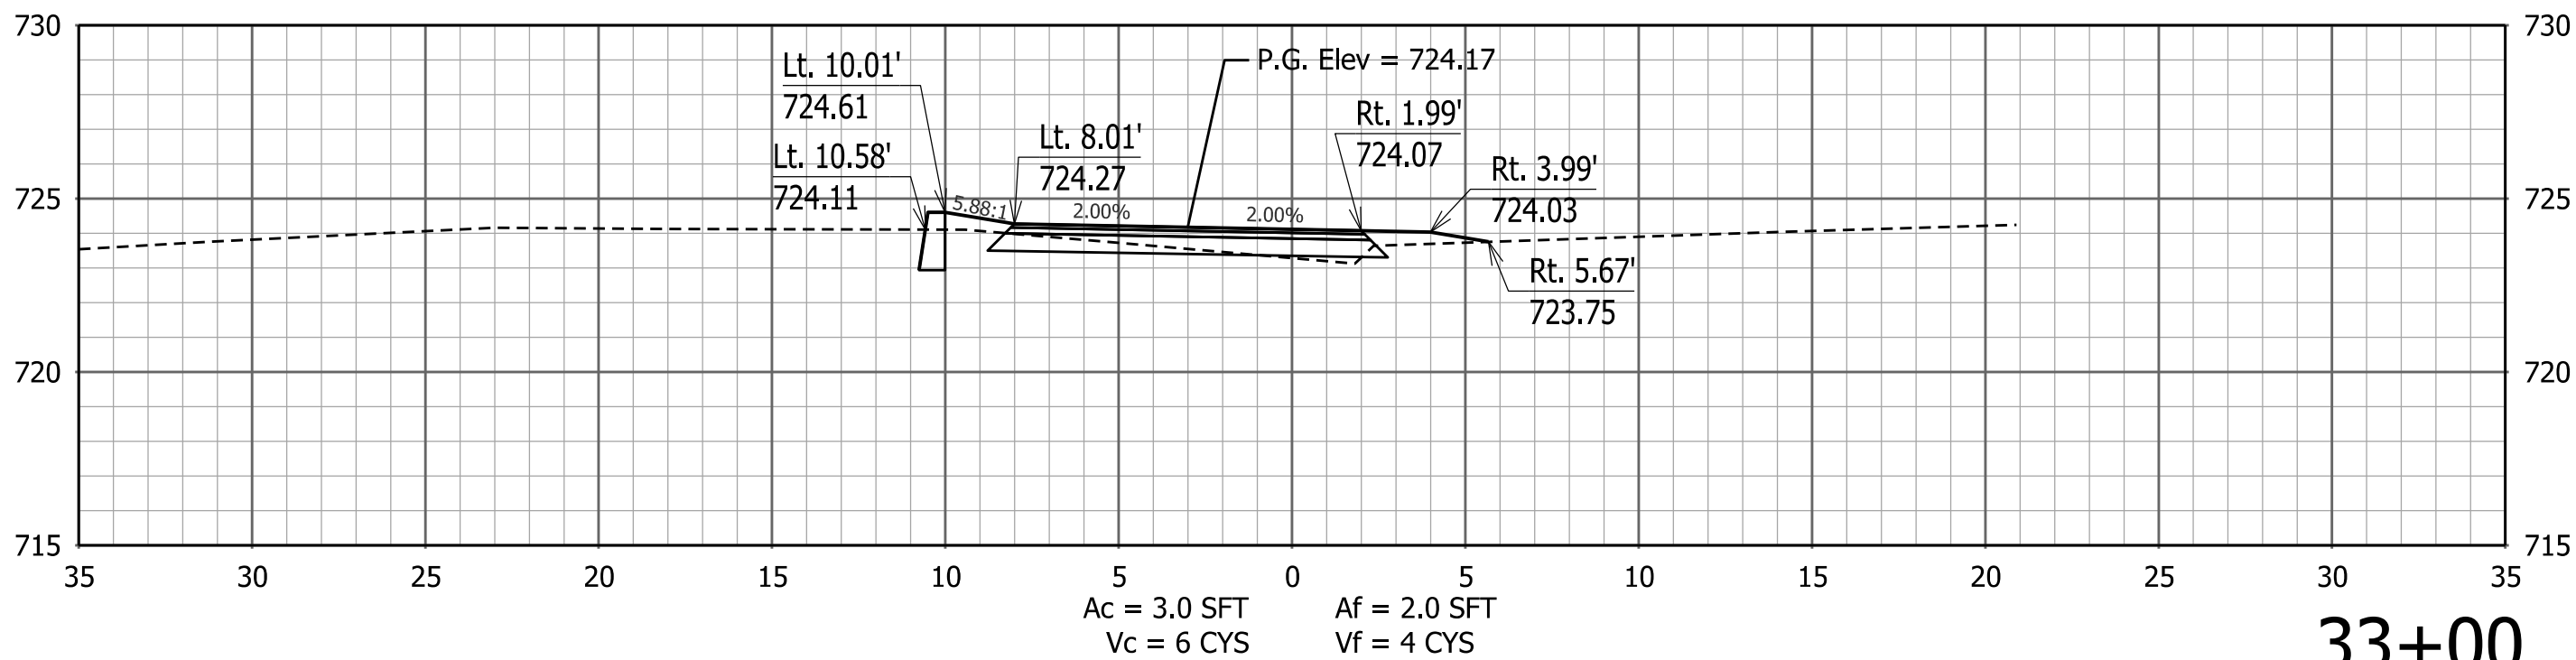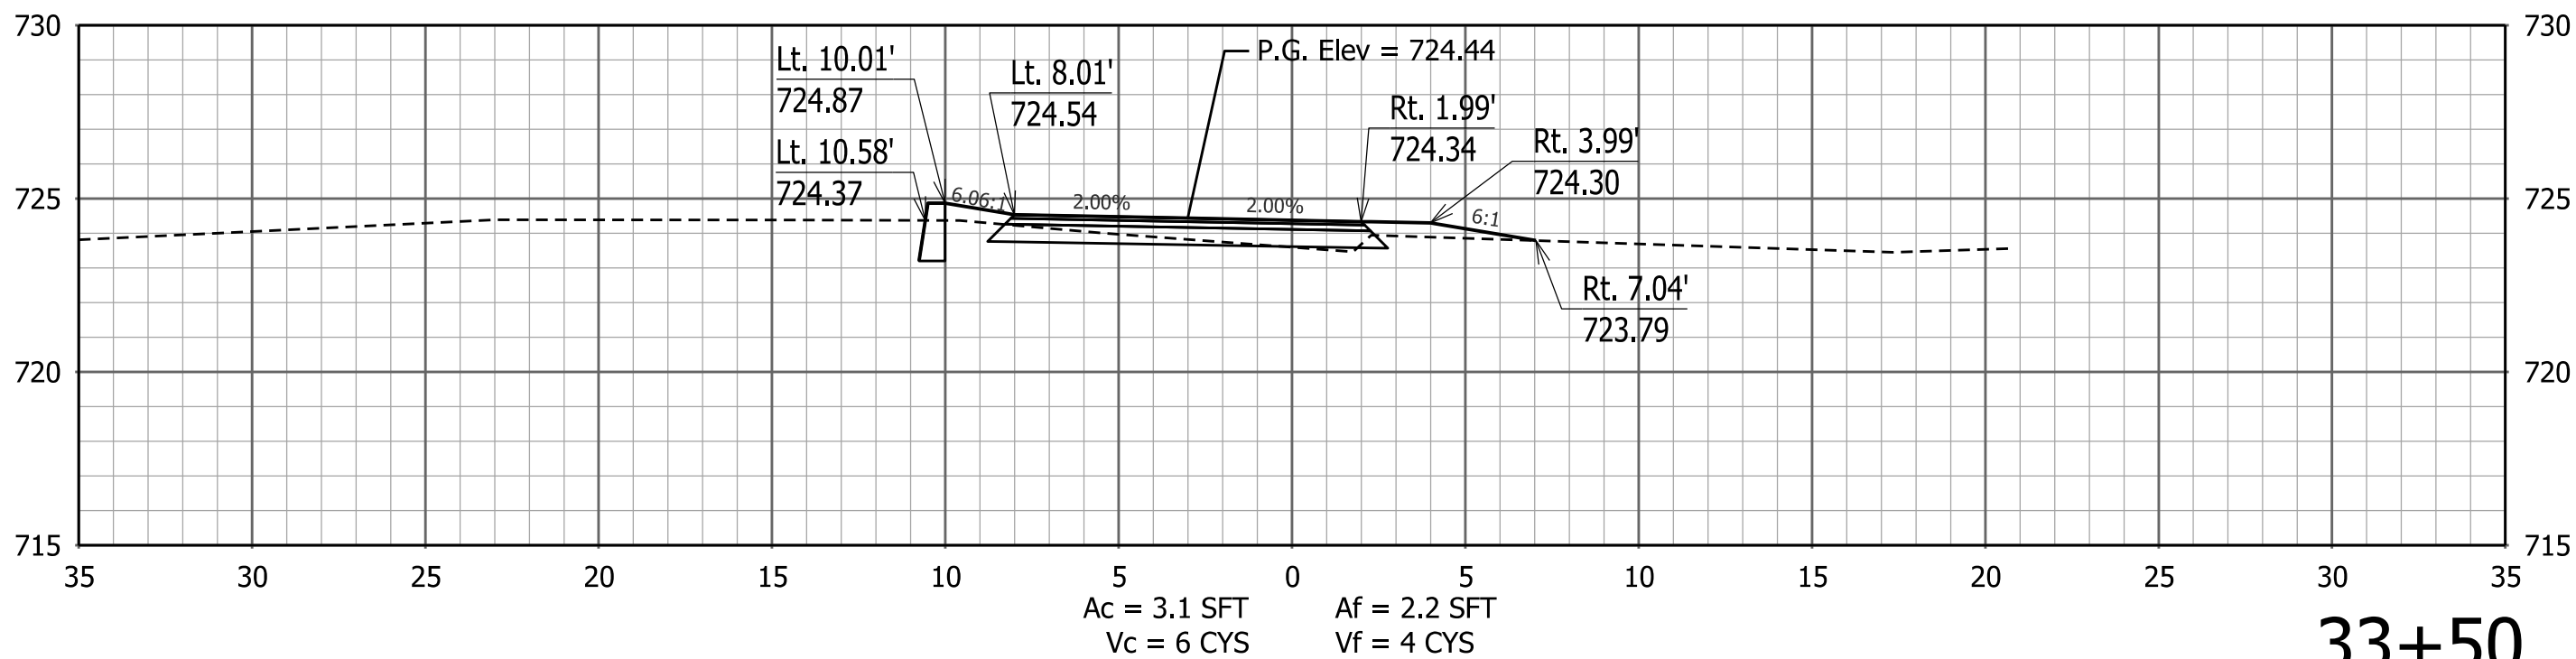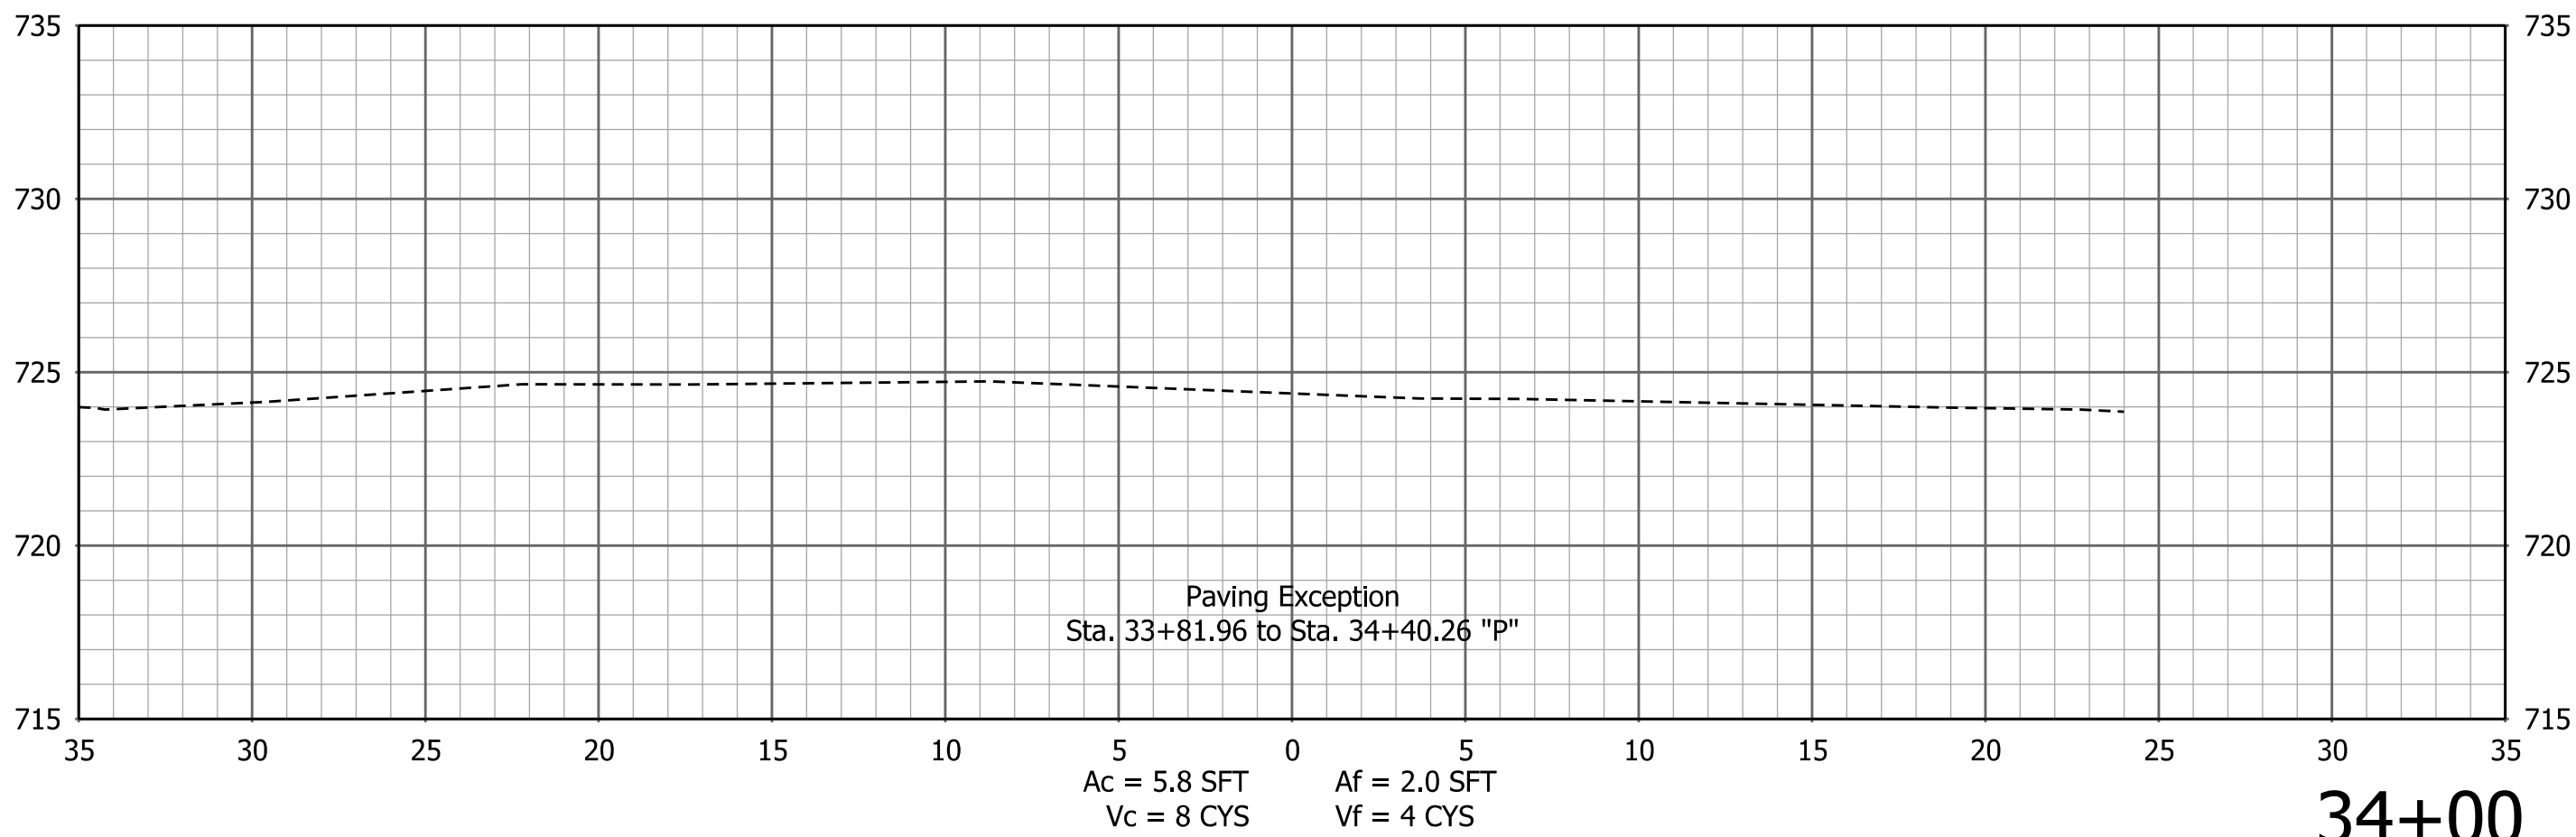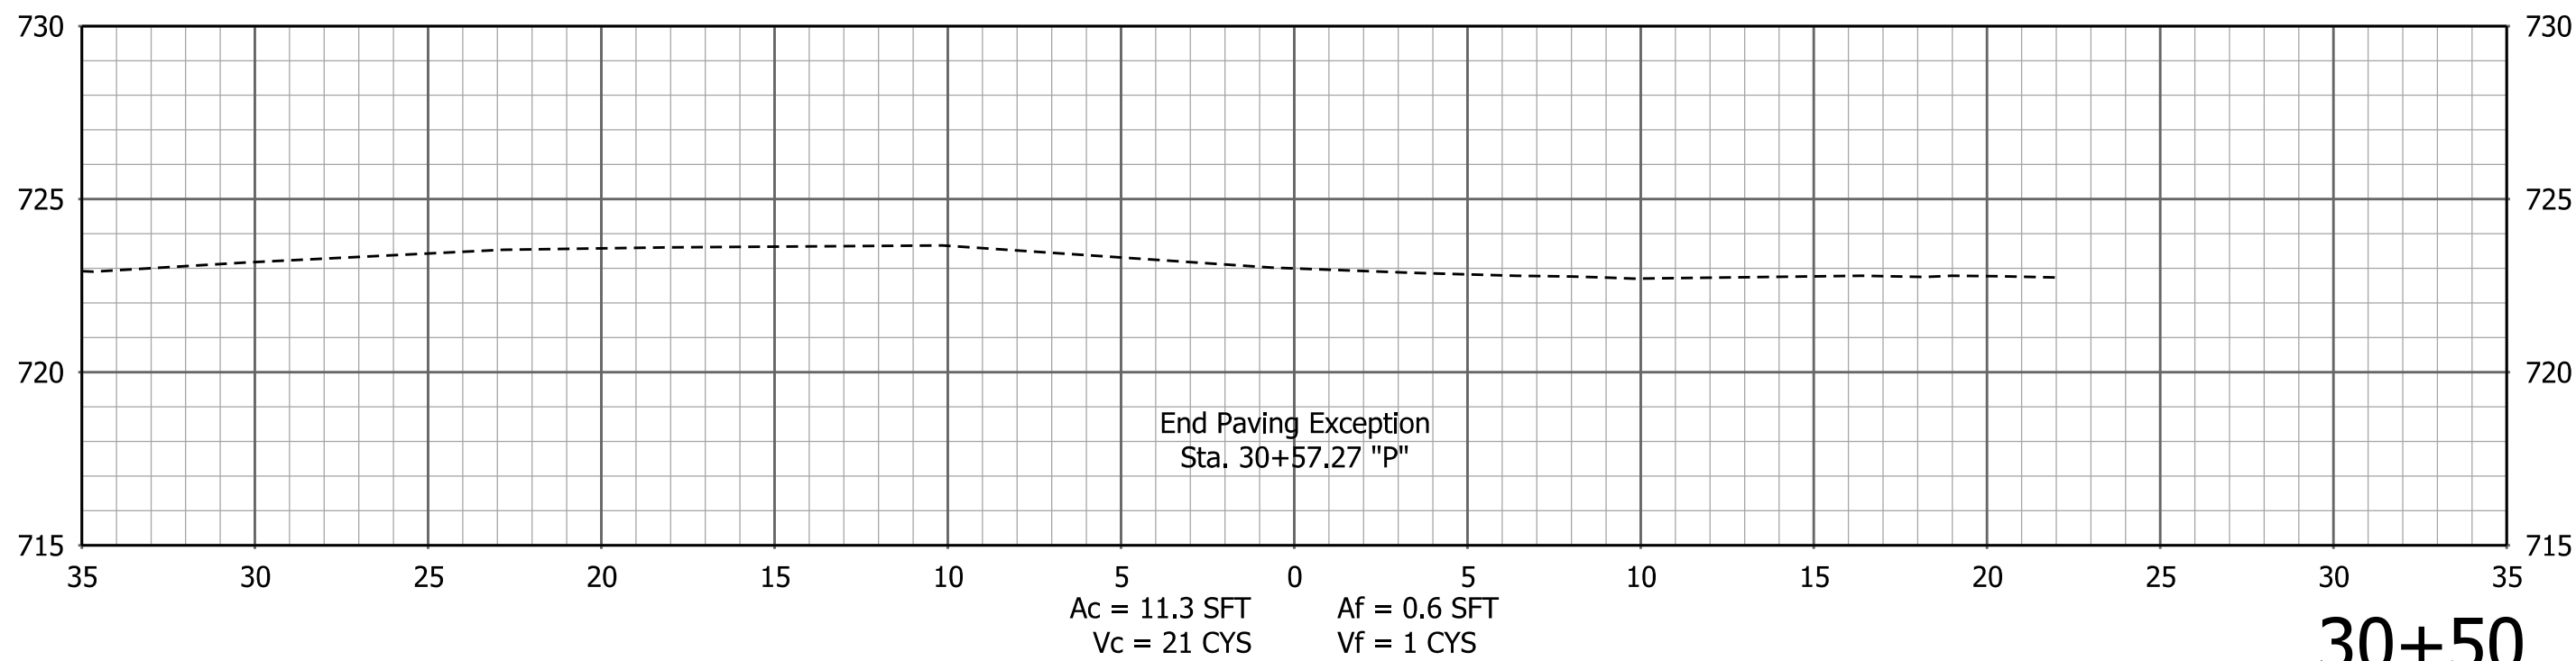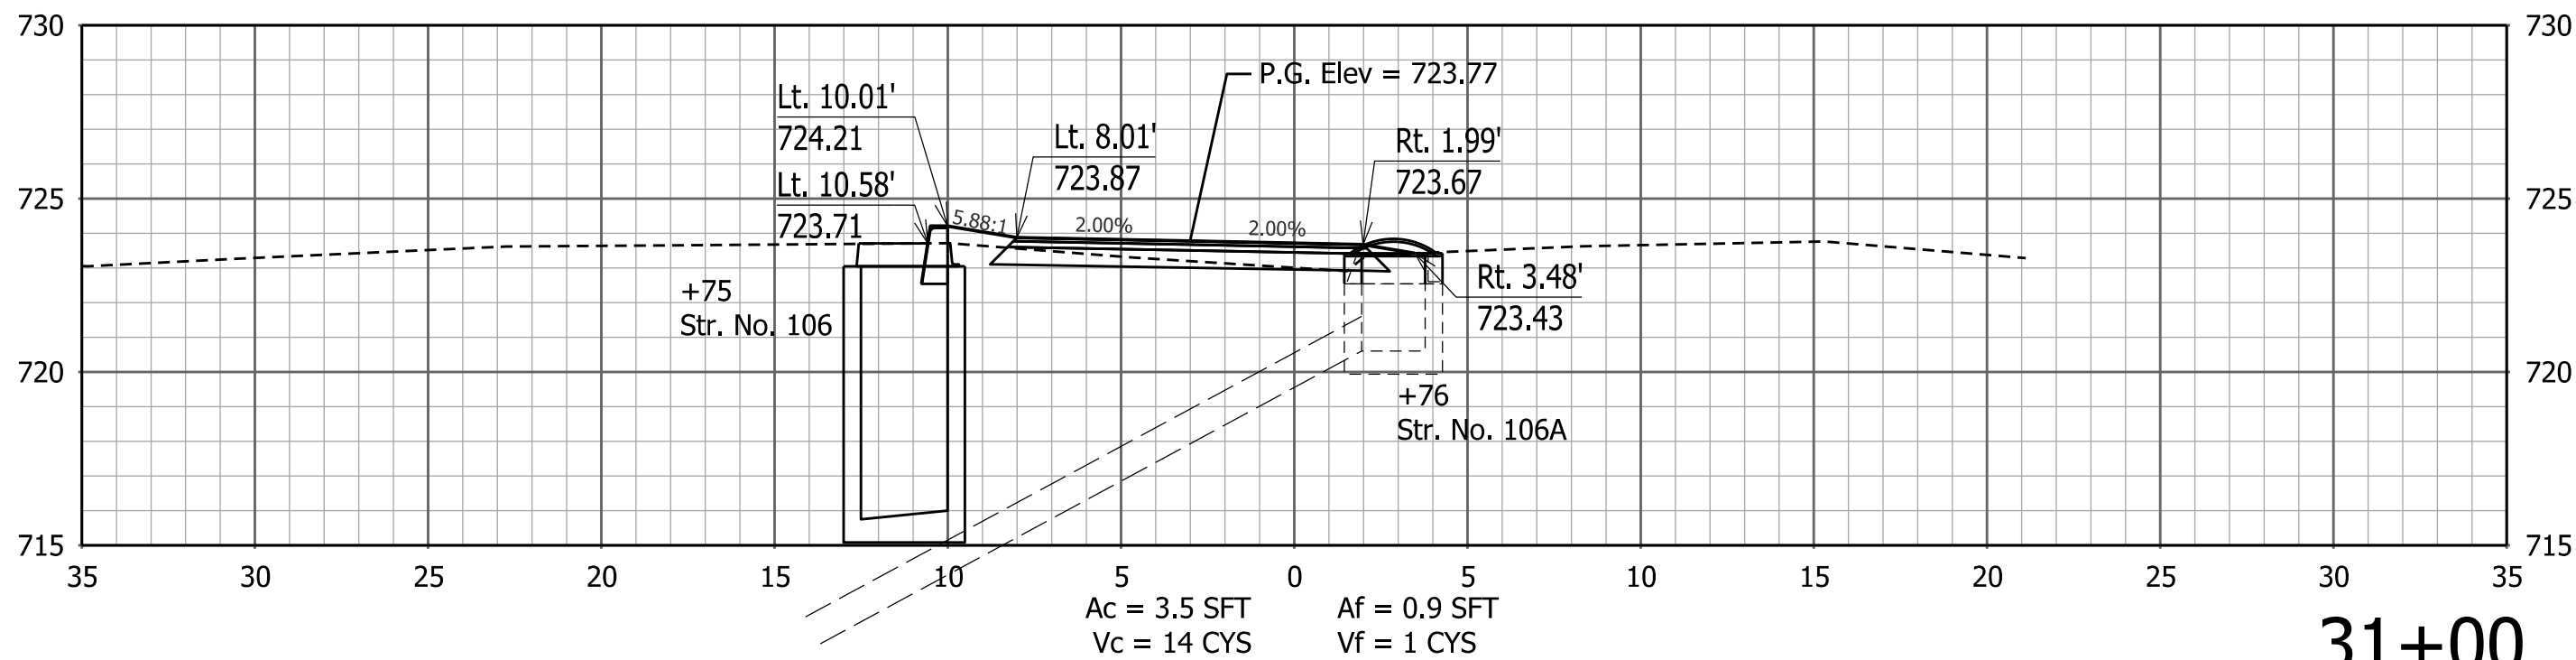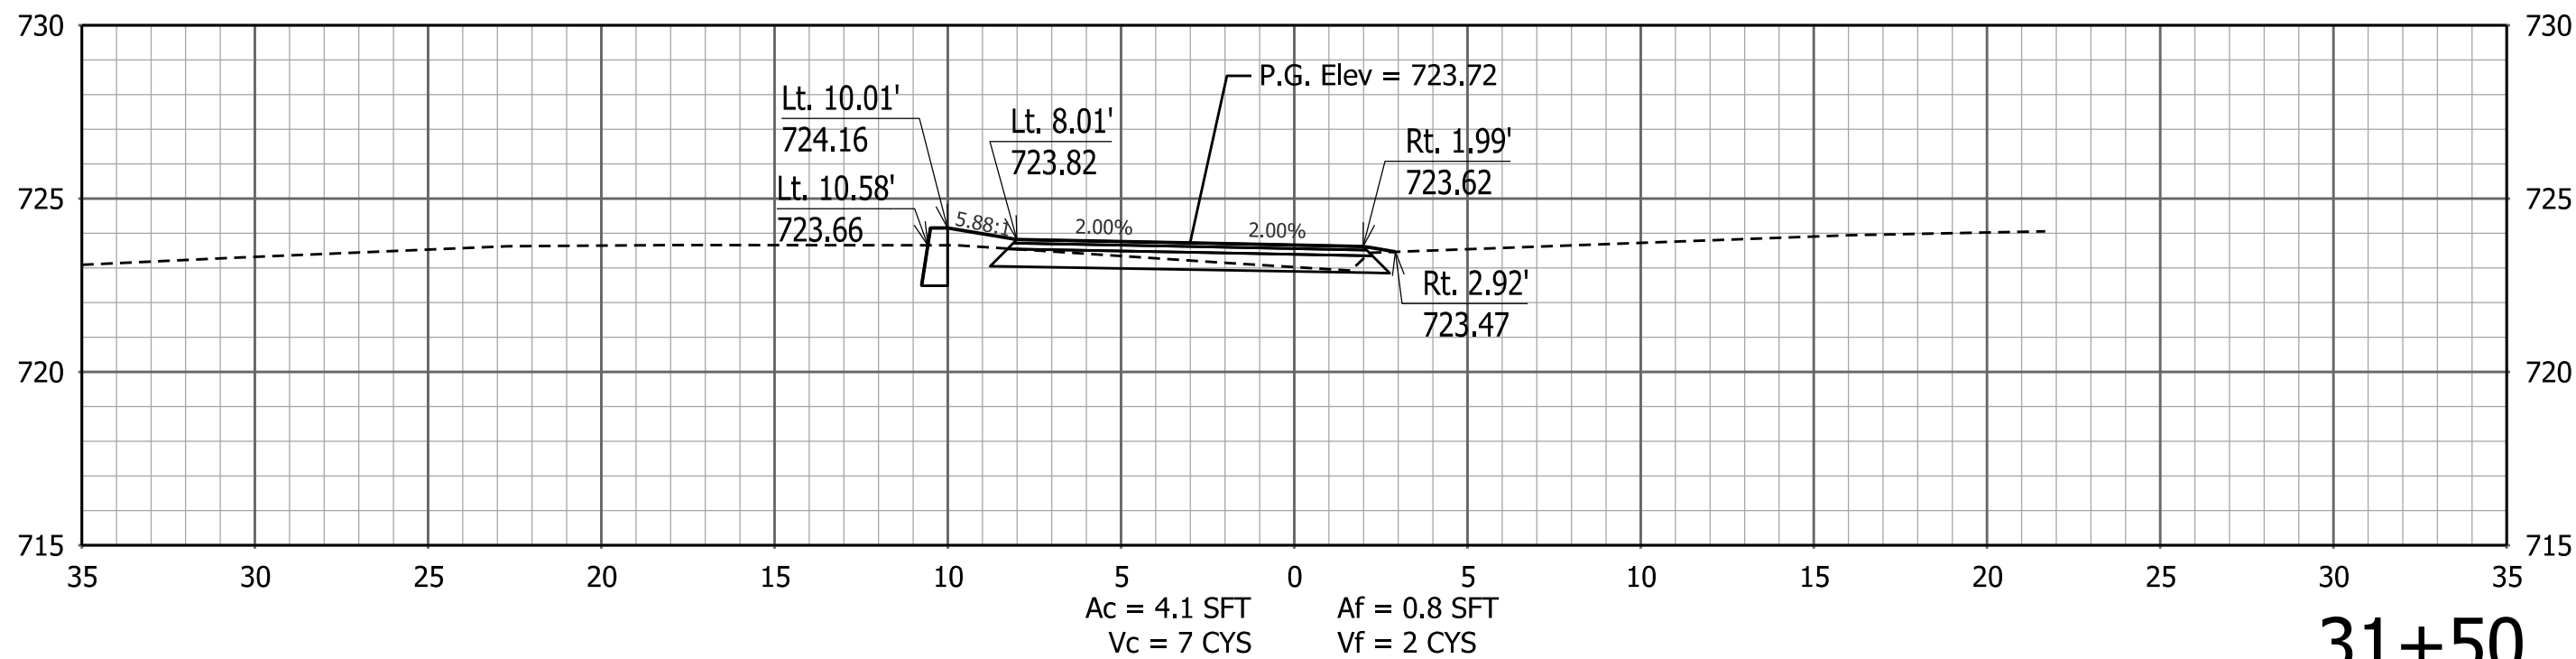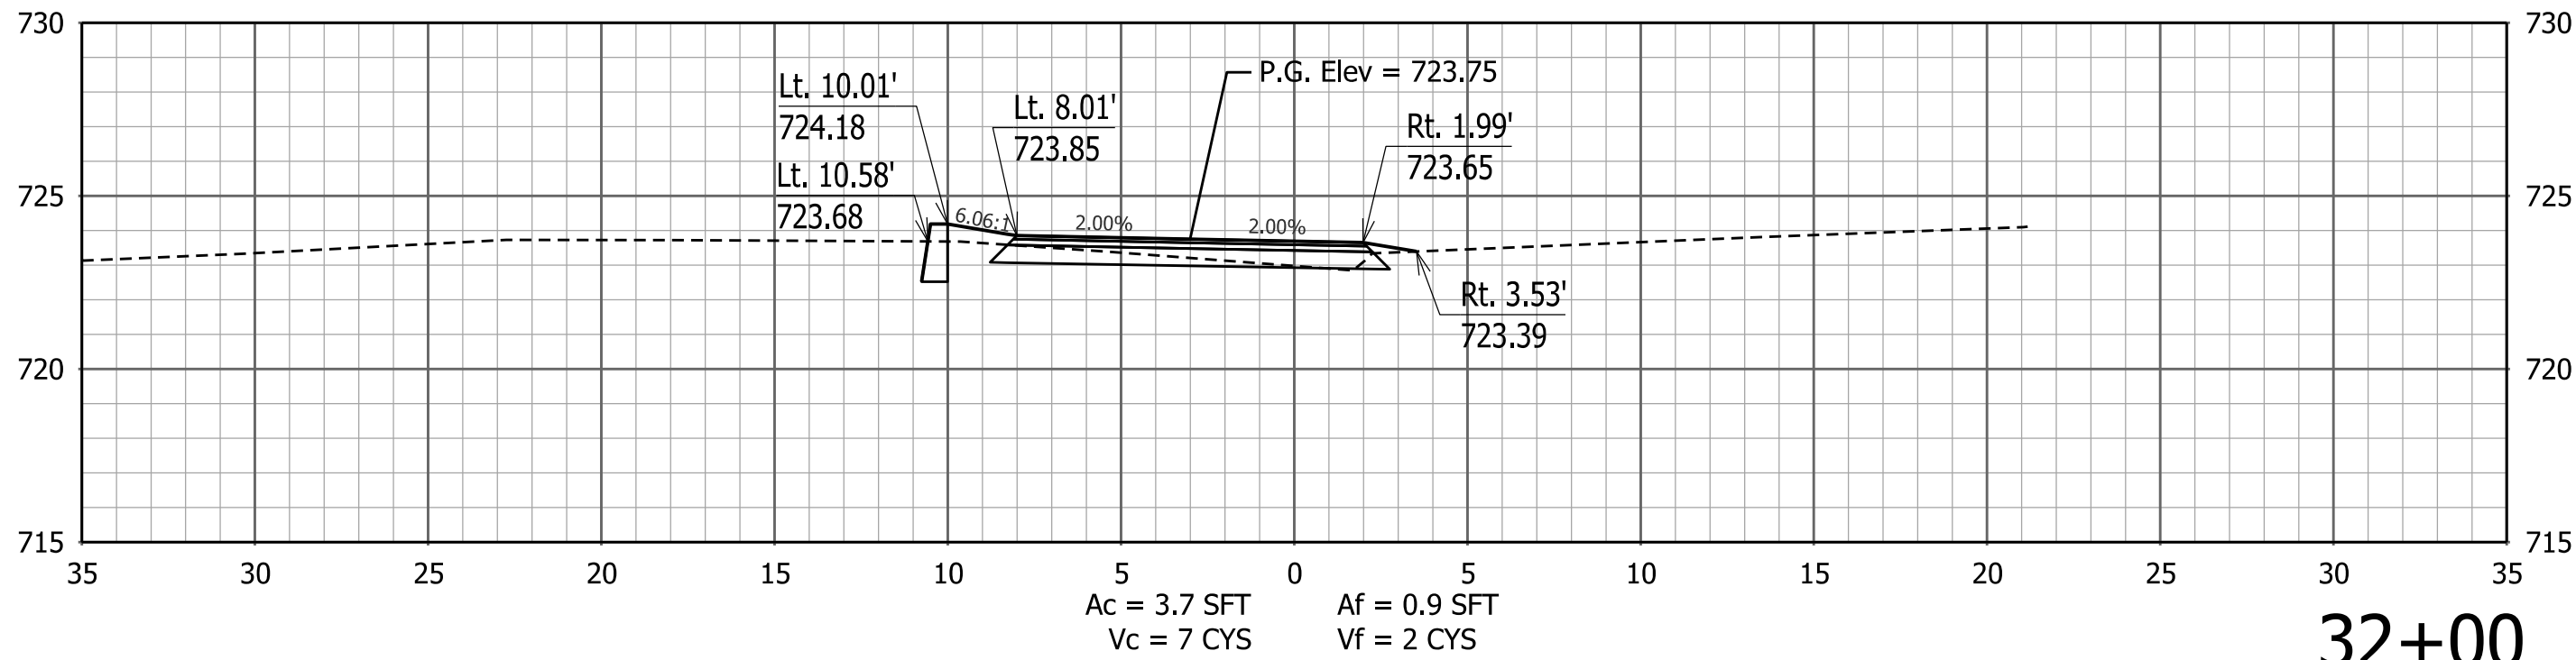

STA. 30+50 TO STA. 34+00


RECOMMENDED FOR APPROVAL _____ DESIGN ENGINEER _____ DATE _____		CITY OF INDIANAPOLIS DEPARTMENT OF PUBLIC WORKS		SCALE		BRIDGE FILE				
				1" = 5'						
						DESIGNATION				
DESIGNED: _____ VA		DRAWN: _____ JSS		CROSS SECTIONS LINE "P"		SURVEY BOOK		SHEETS		
						XS 44		of	XS 47	
CHECKED: _____ ACD		CHECKED: _____ VA				CONTRACT		PROJECT		
						PA-25-001				

PATH AND FILENAME: V:\Projects\IIN62\Planning and Urban Design\27813 Pogues Run Greenway\30 SheetDrawings\40 CrossSections\Sht Xsec 5_PH1_01.dgn

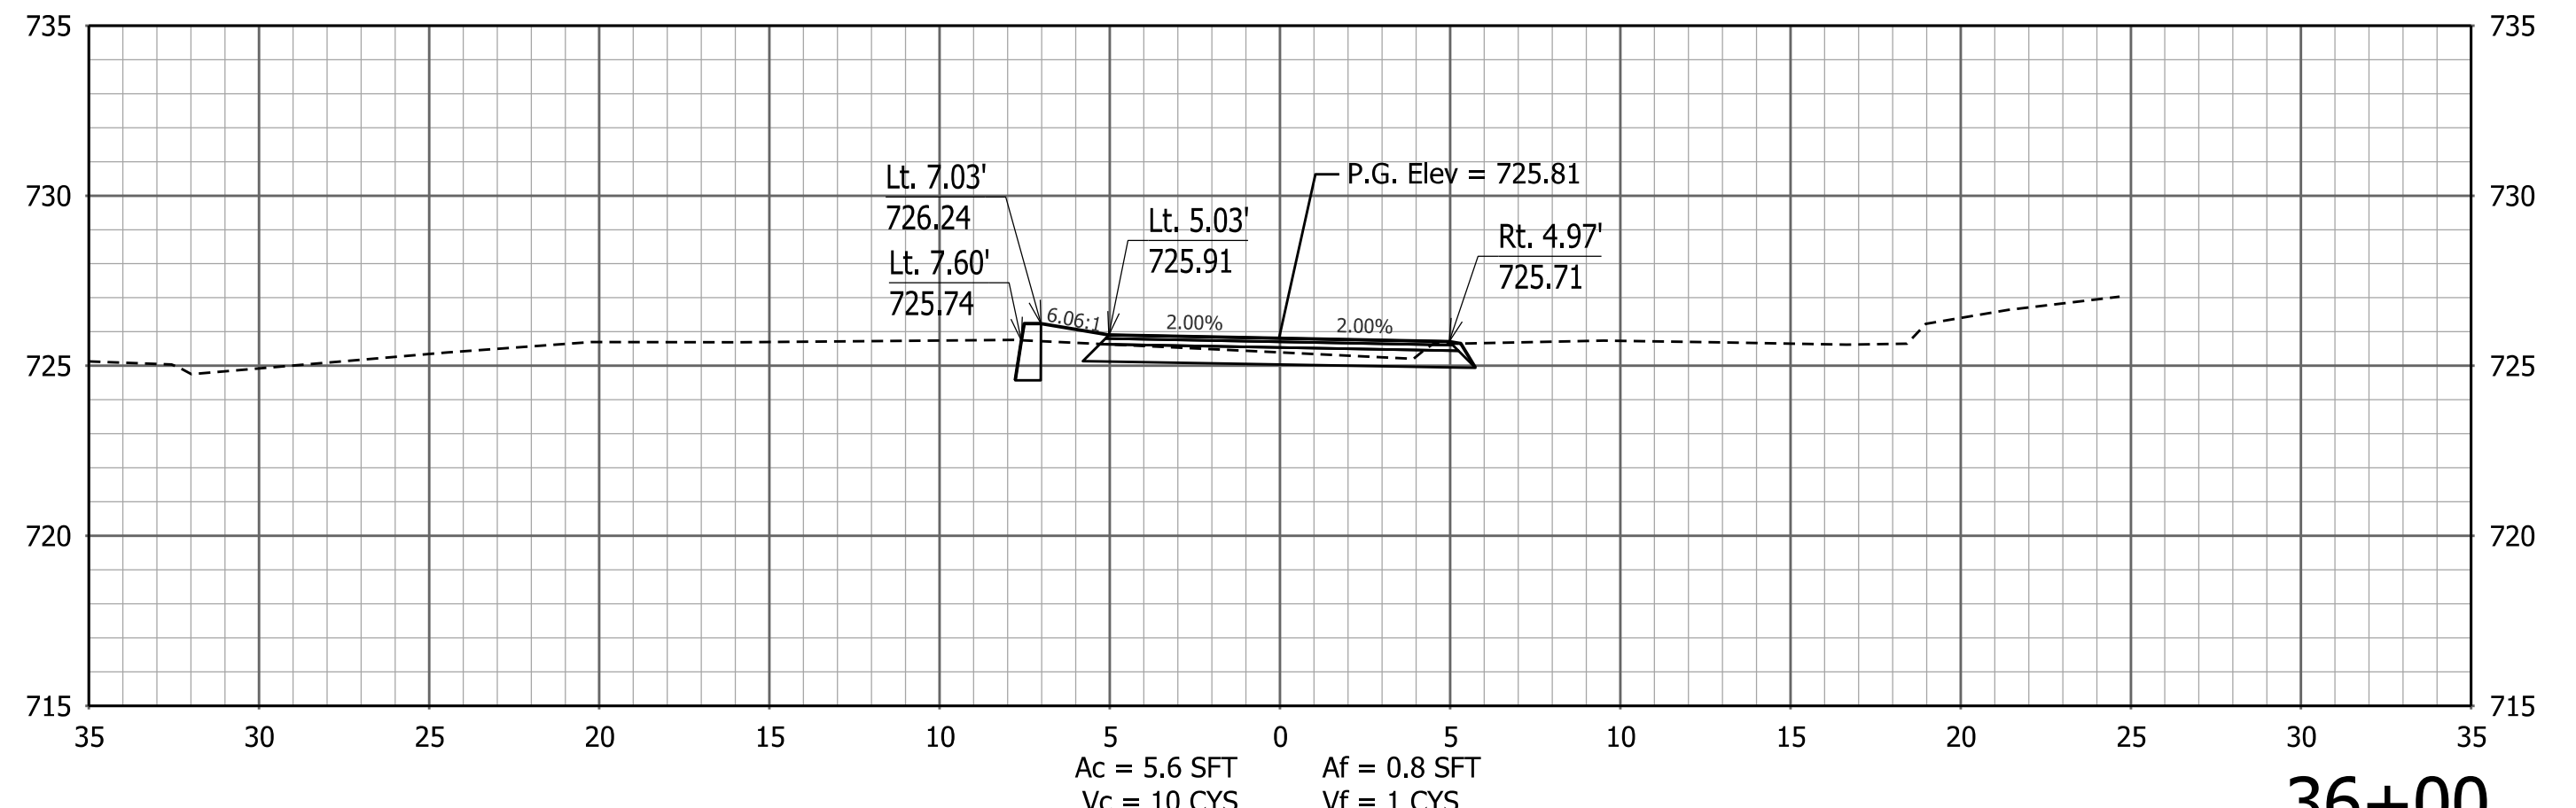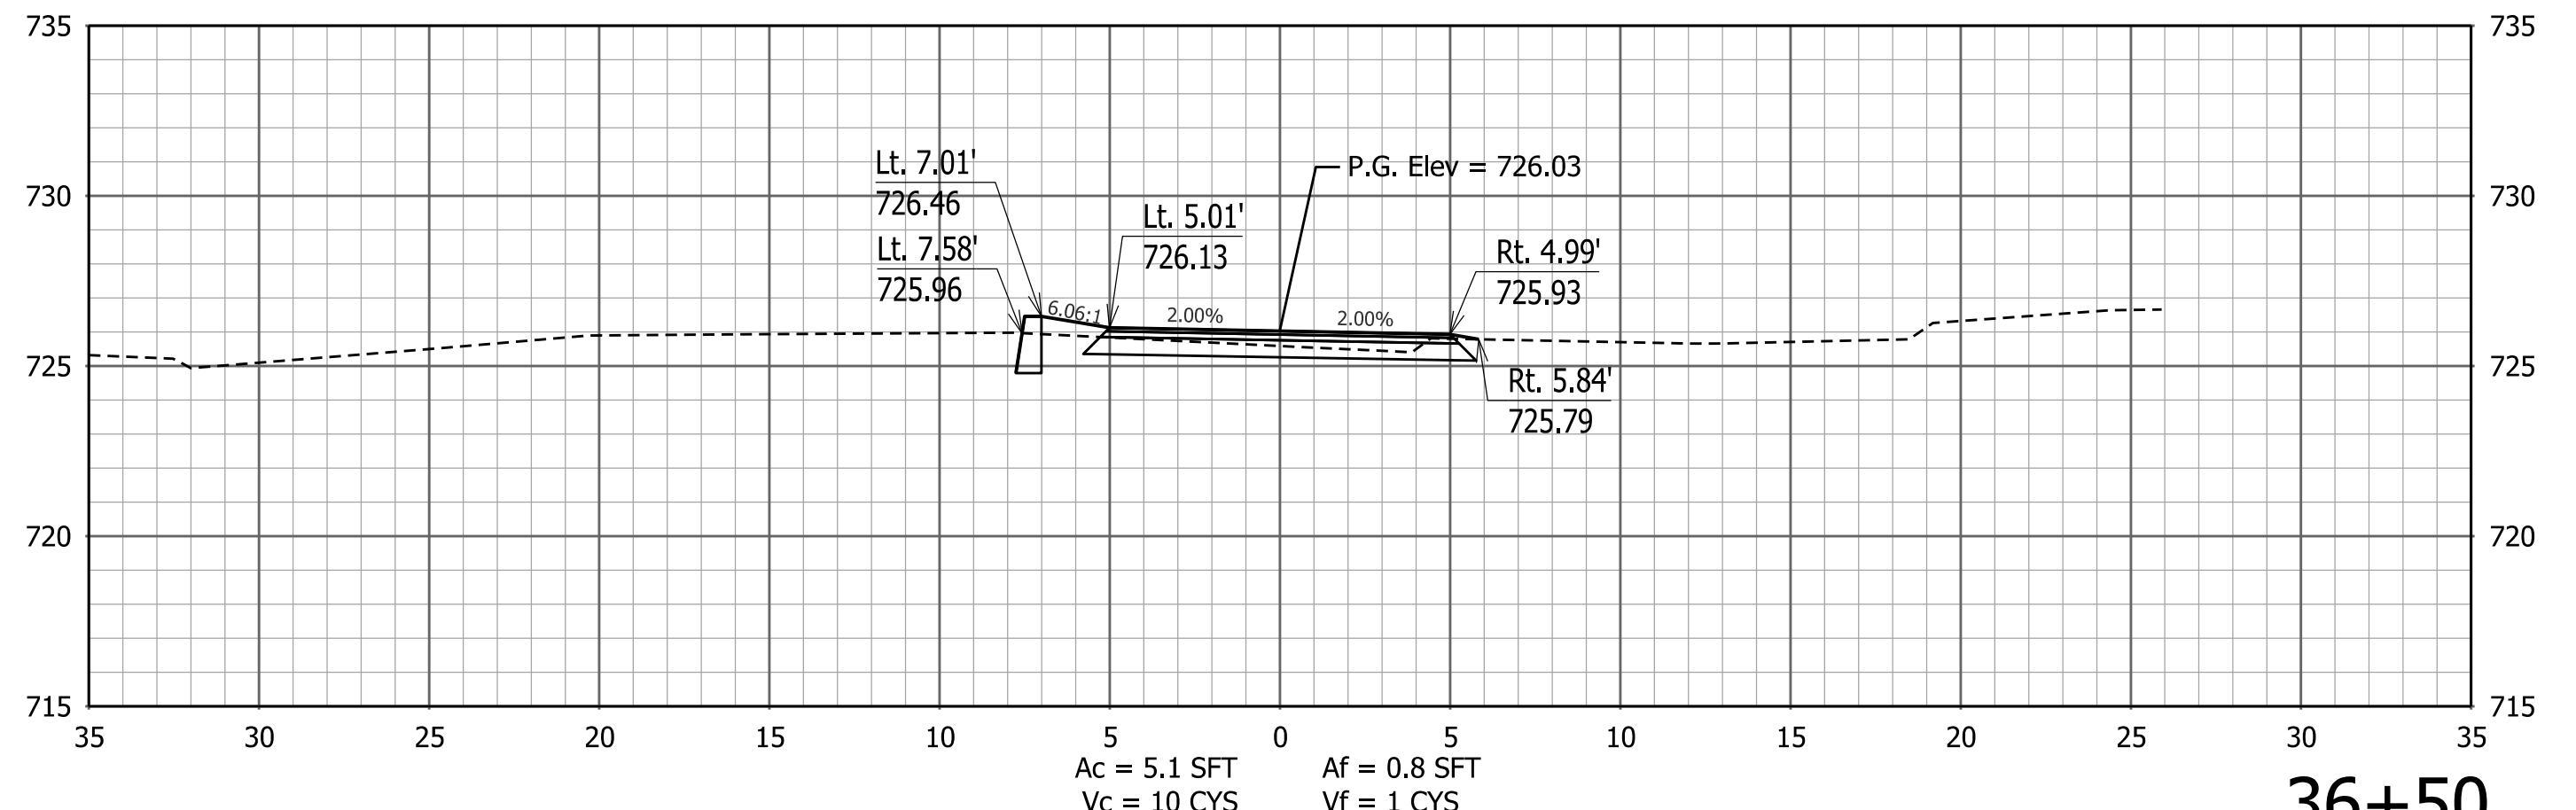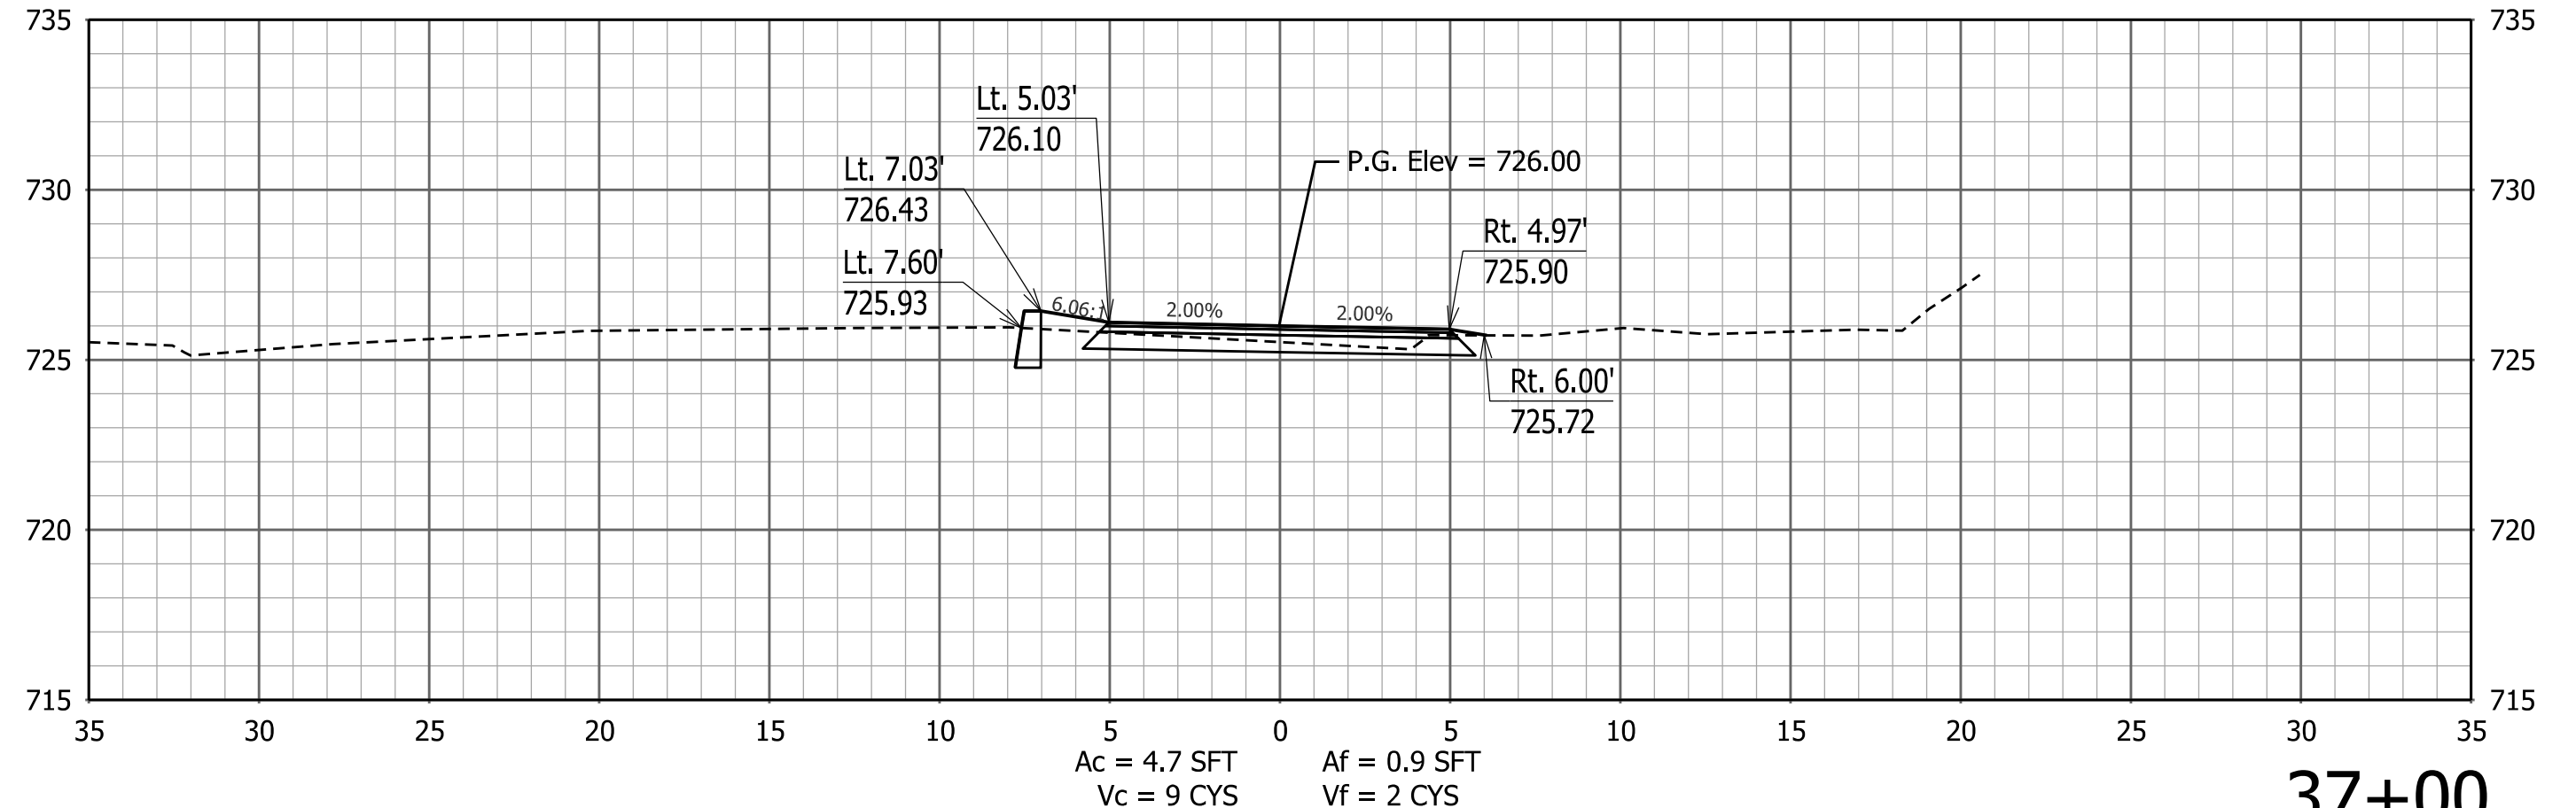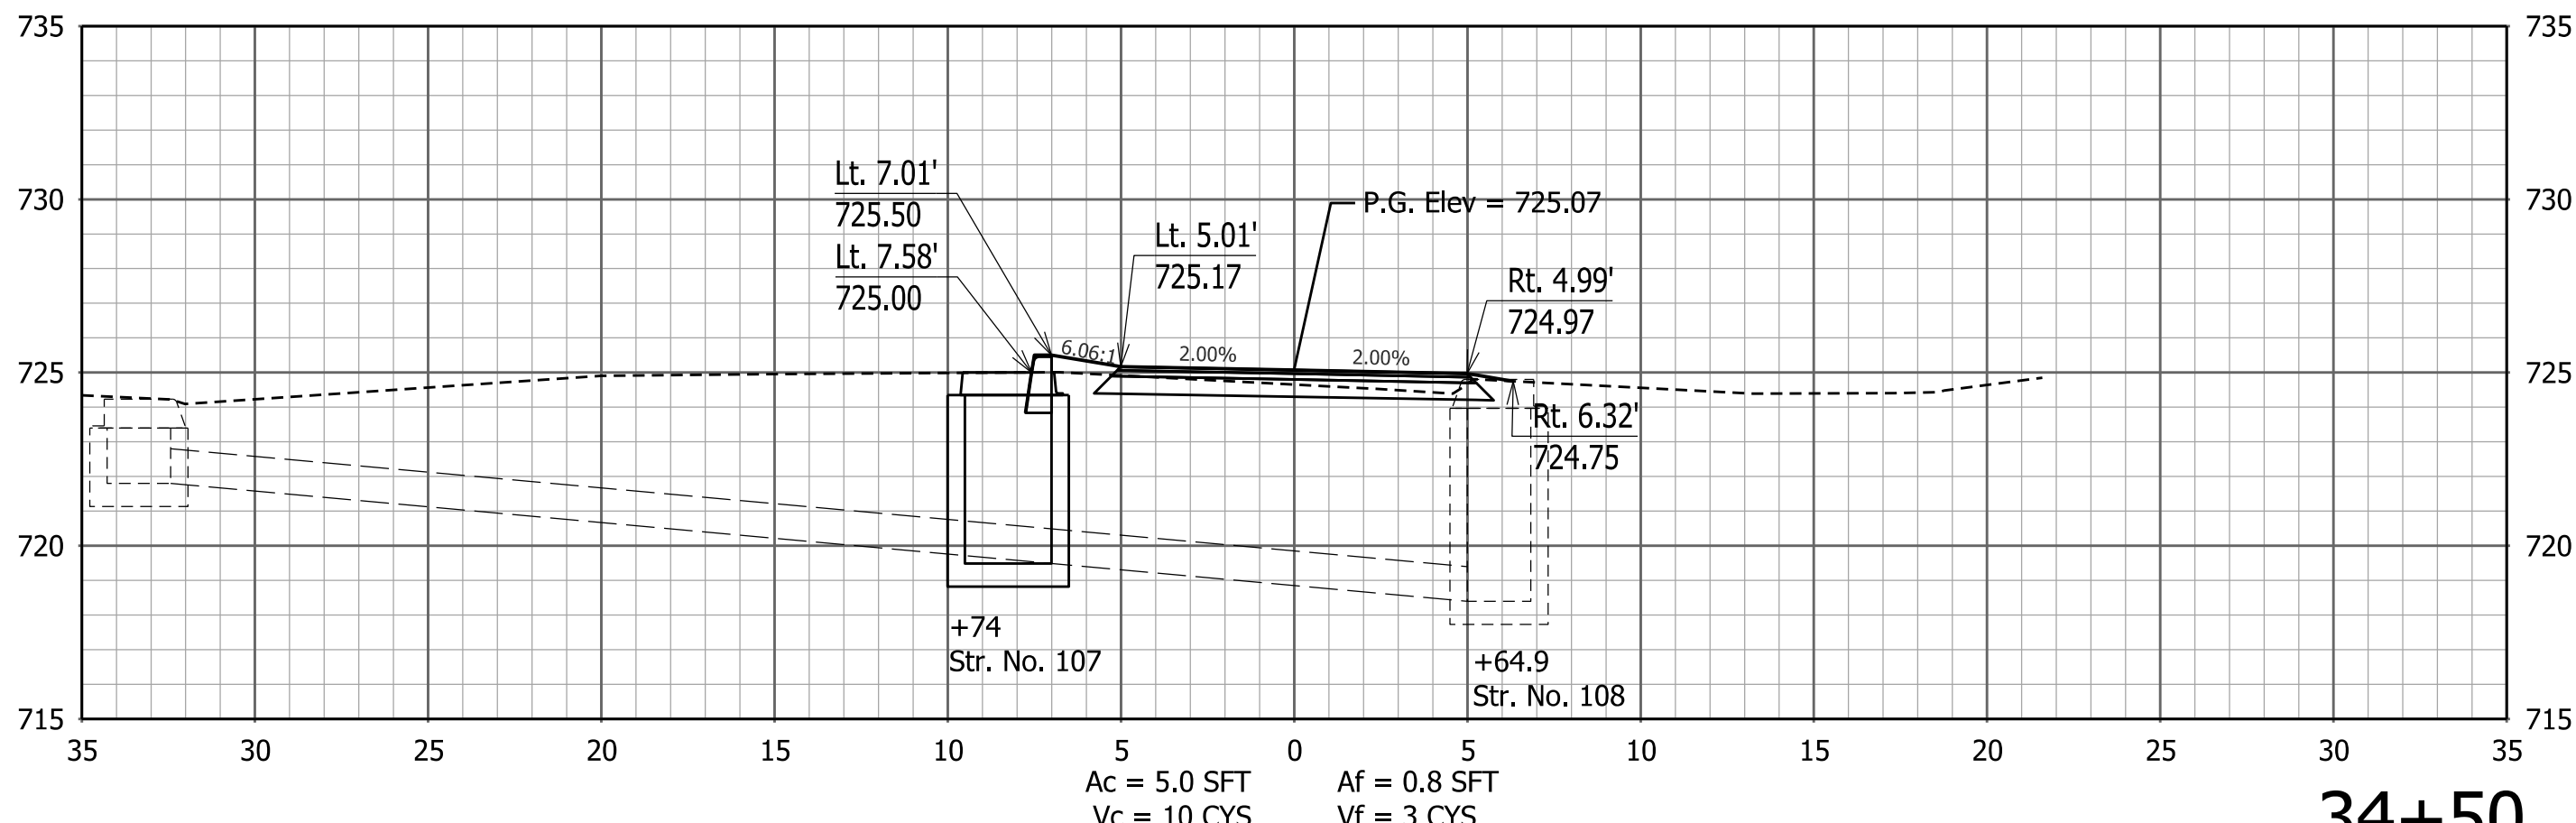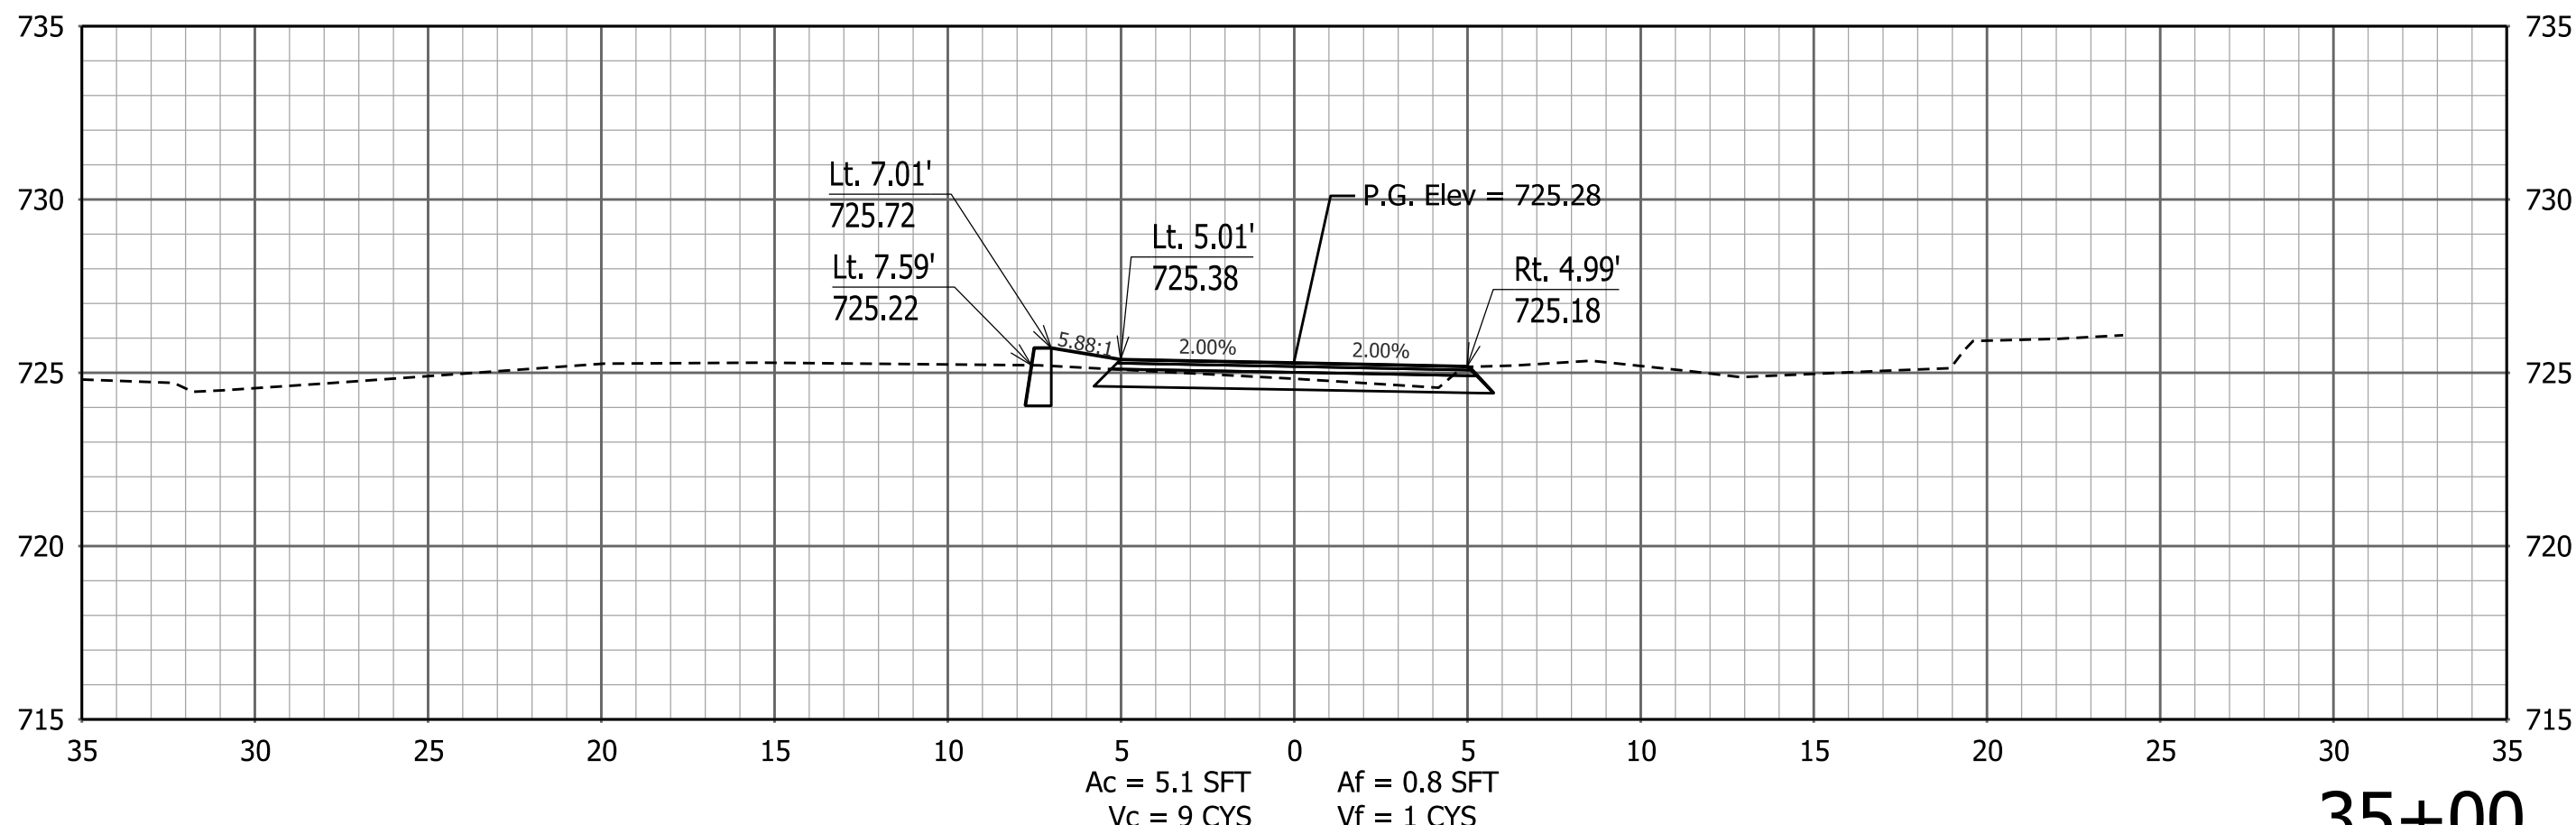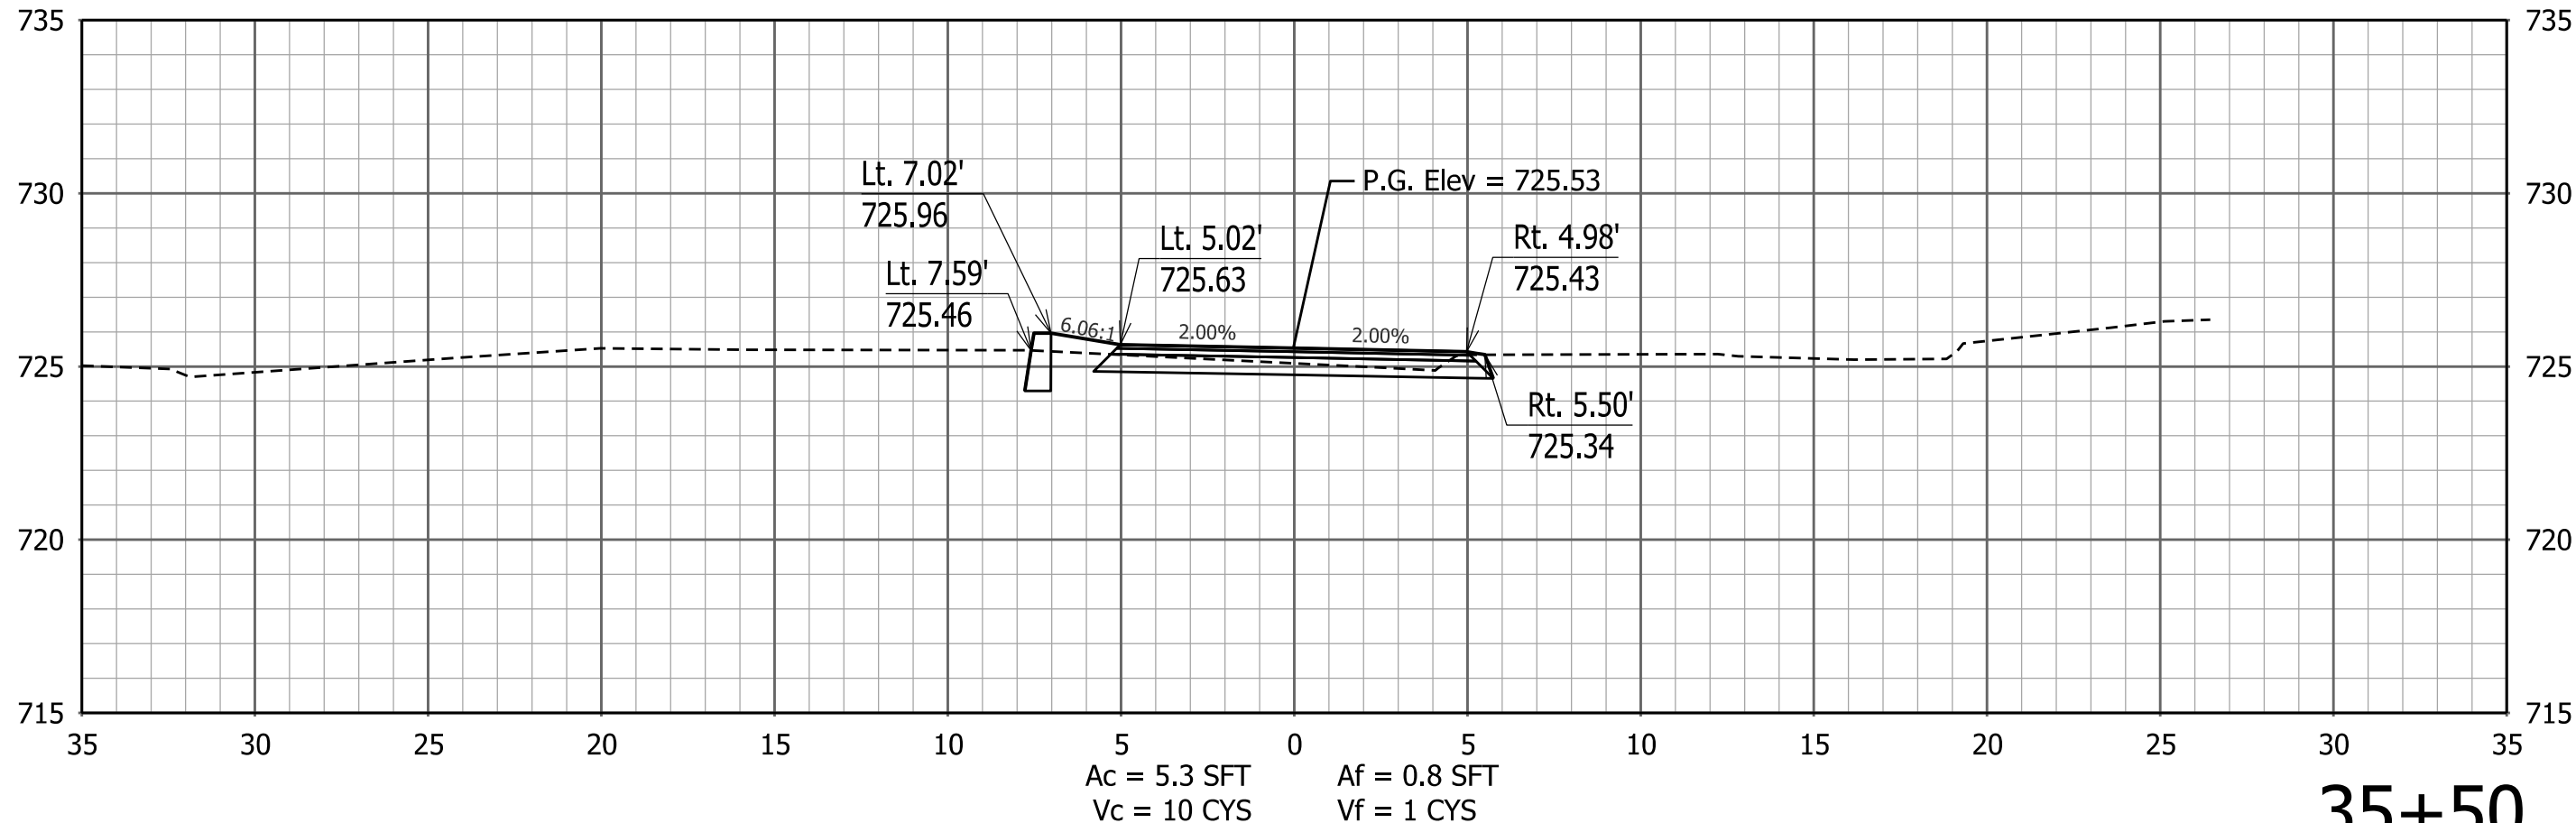


RECOMMENDED FOR APPROVAL _____ DESIGN ENGINEER _____ DATE _____		CITY OF INDIANAPOLIS DEPARTMENT OF PUBLIC WORKS		SCALE		BRIDGE FILE	
				1" = 5'		DESIGNATION	
DESIGNED: _____ VA _____ DRAWN: _____ JSS _____		CROSS SECTIONS LINE "P"		SURVEY BOOK		SHEETS	
CHECKED: _____ ACD _____ CHECKED: _____ VA _____				XS 45 of XS 47			
				PROJECT PA-25-001			


PATH AND FILENAME: V:\Projects\IIN62\Planning and Urban Design\Projects\27813 Pogues Run Greenway\30 SheetDrawings\40 CrossSections\Sht Xsec 5_PH1_01.dgn
MODEL NAME: Default
DATE PLOTTED: 4/16/2015
TIME PLOTTED: 5:26:22 PM

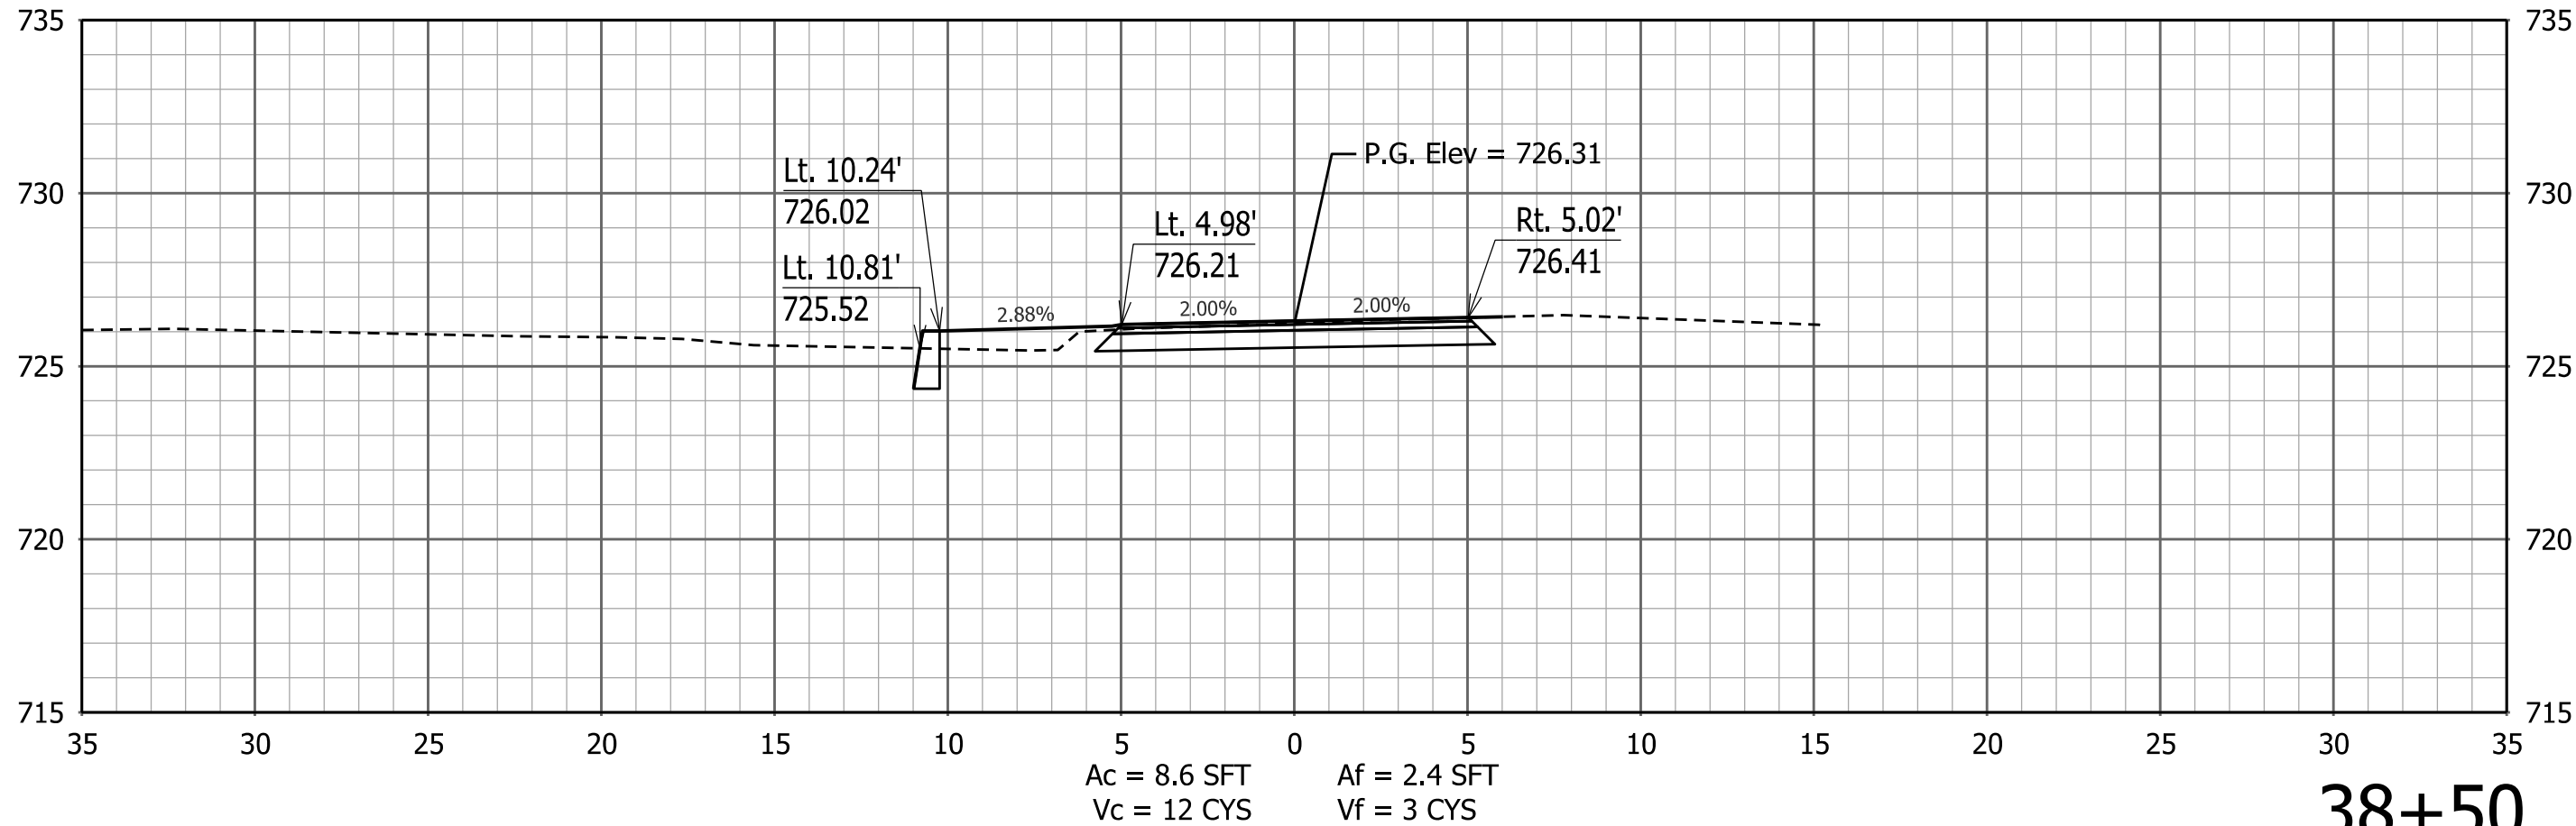


38+50

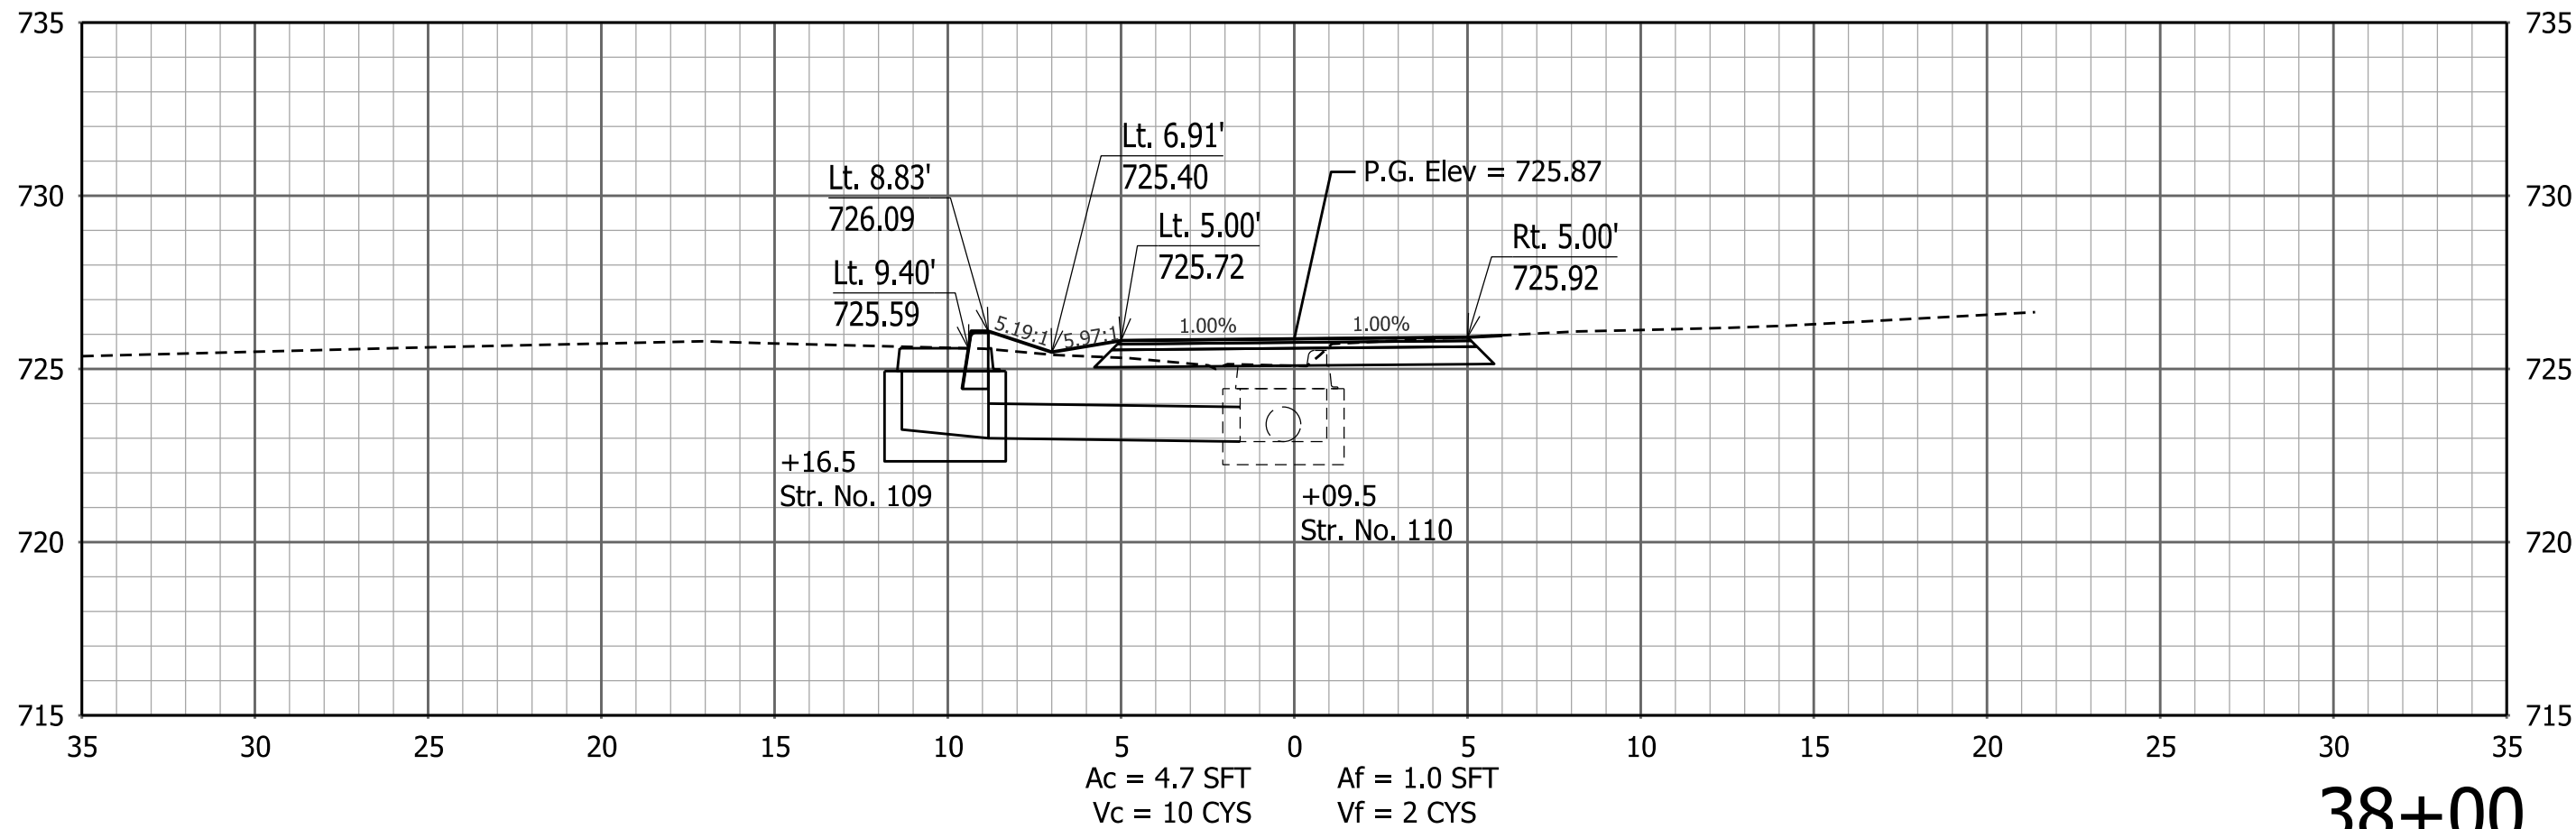


38+00

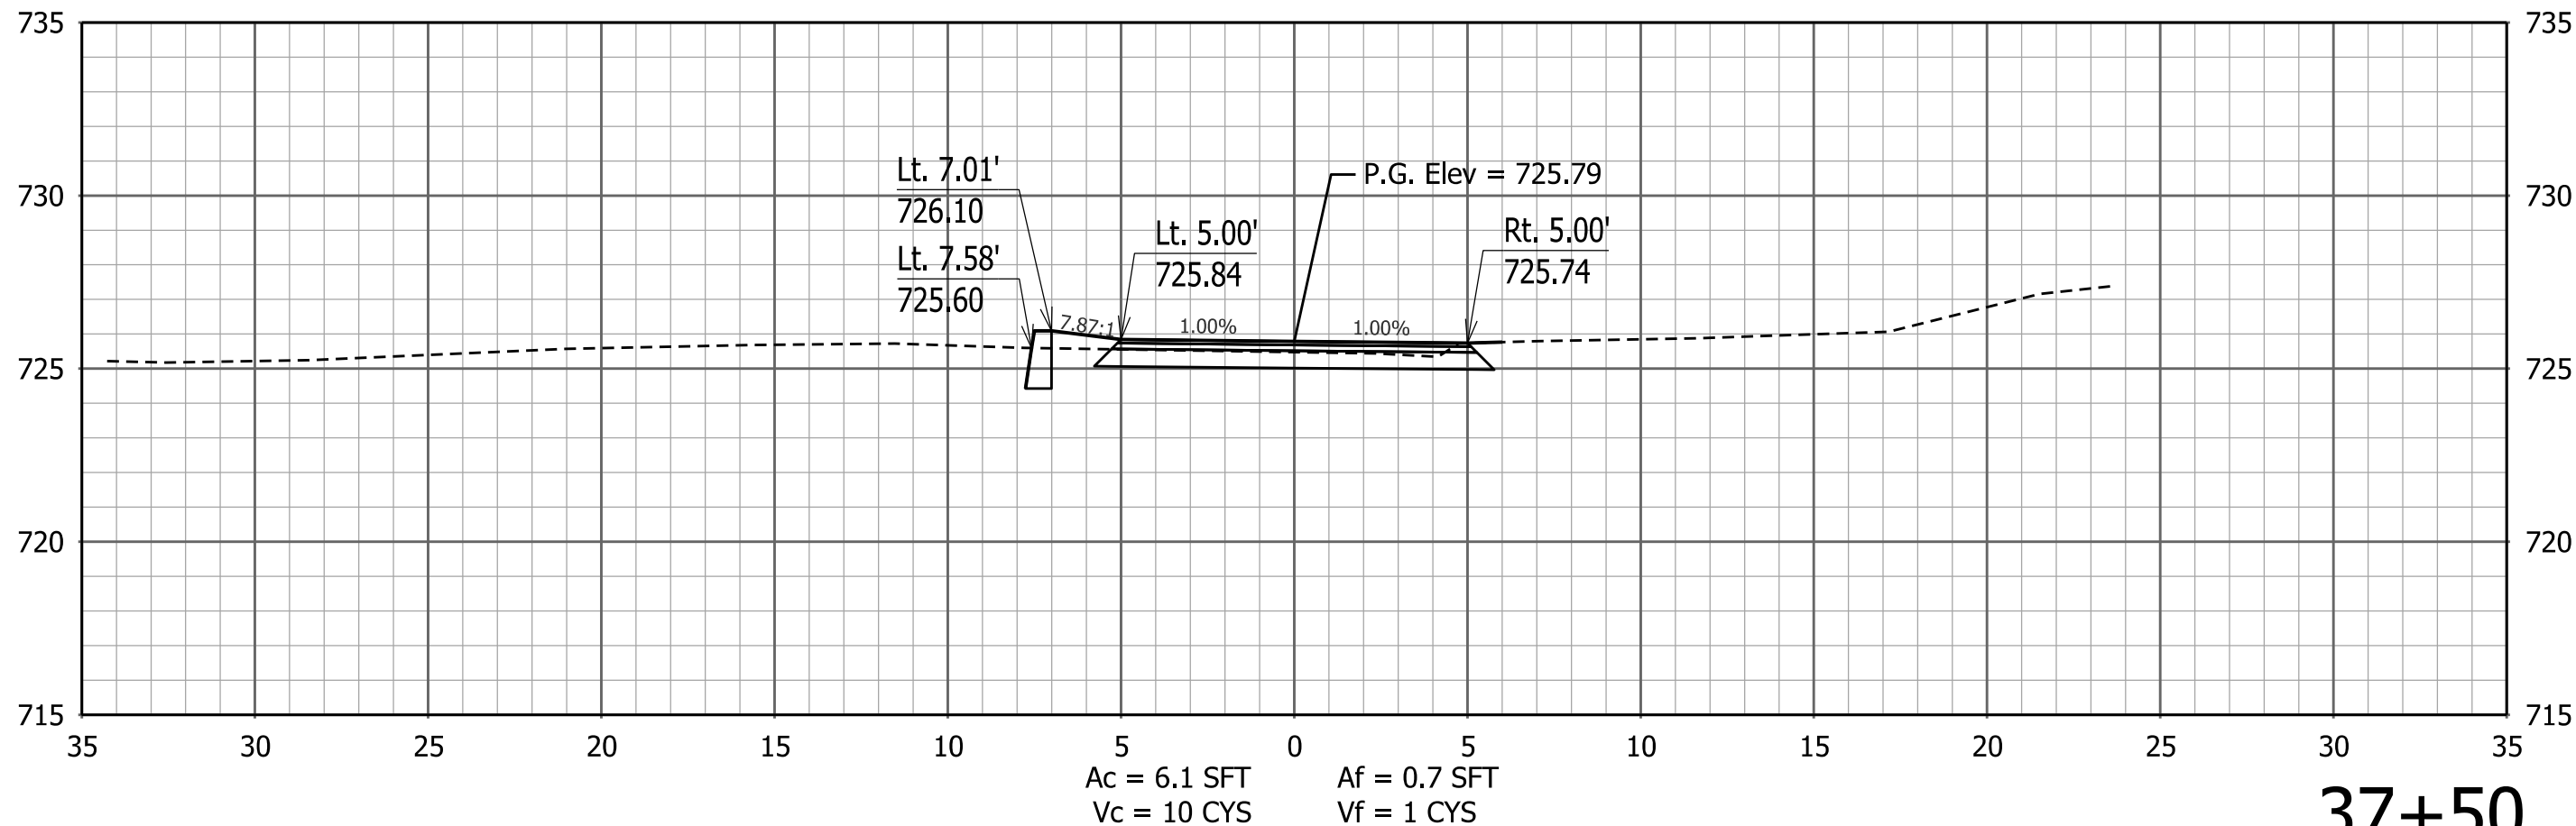


37+50

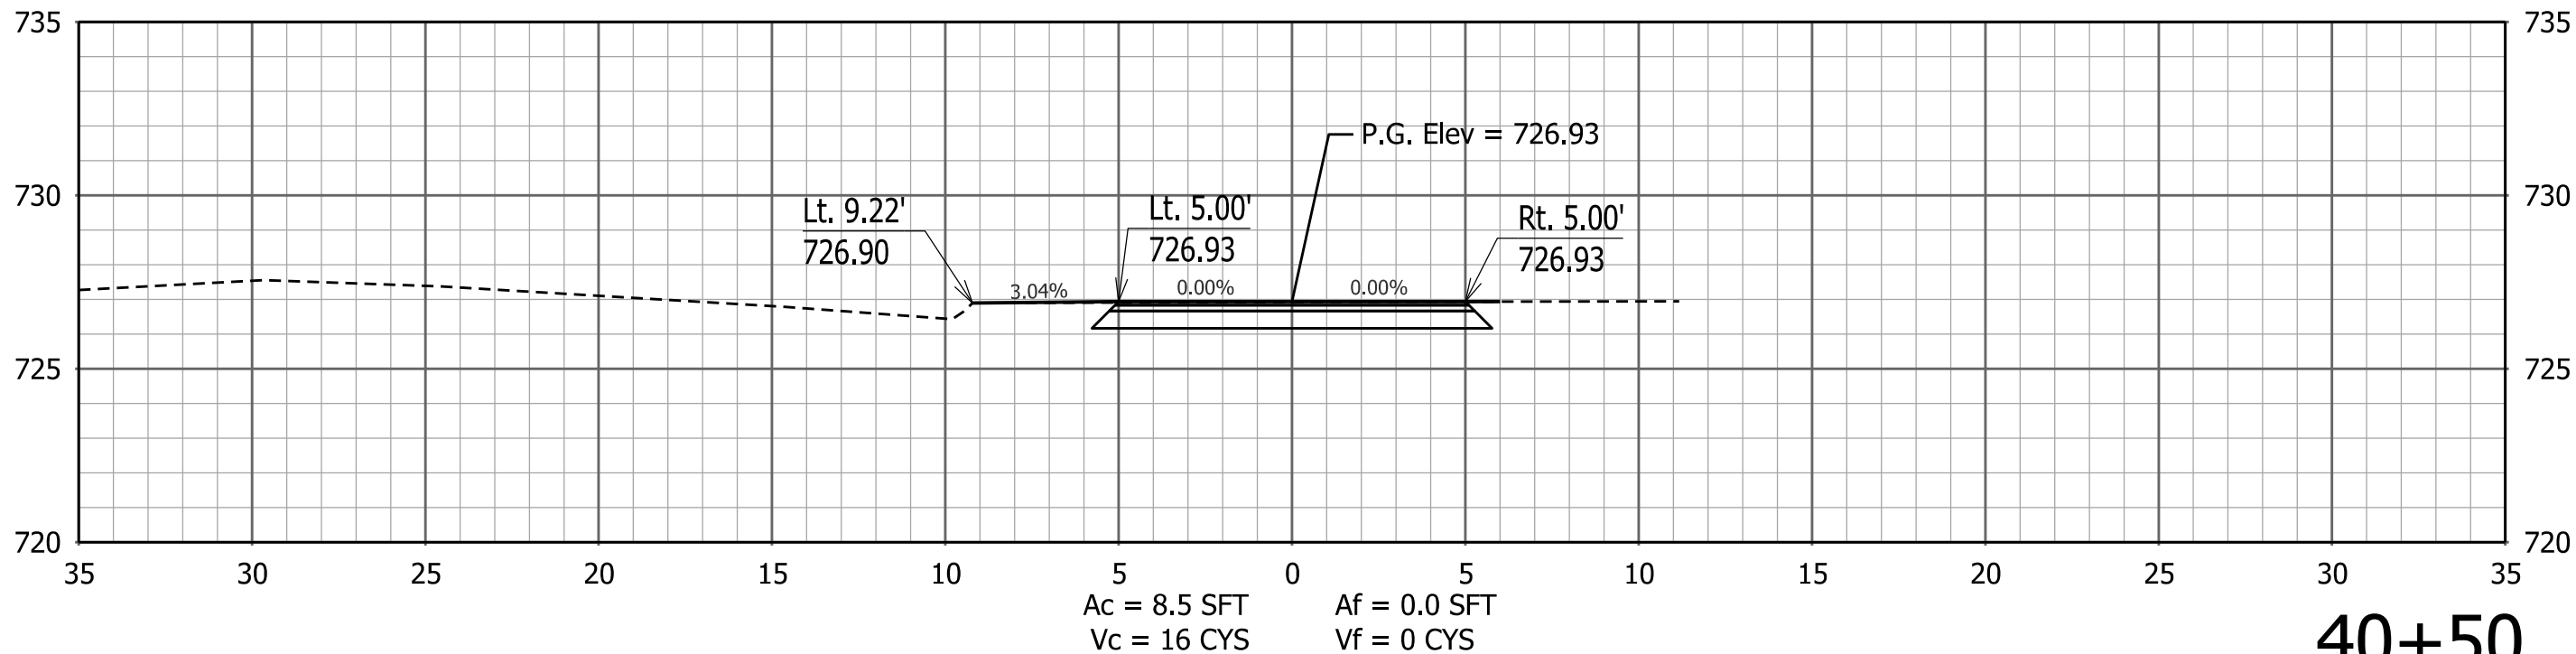


40+50

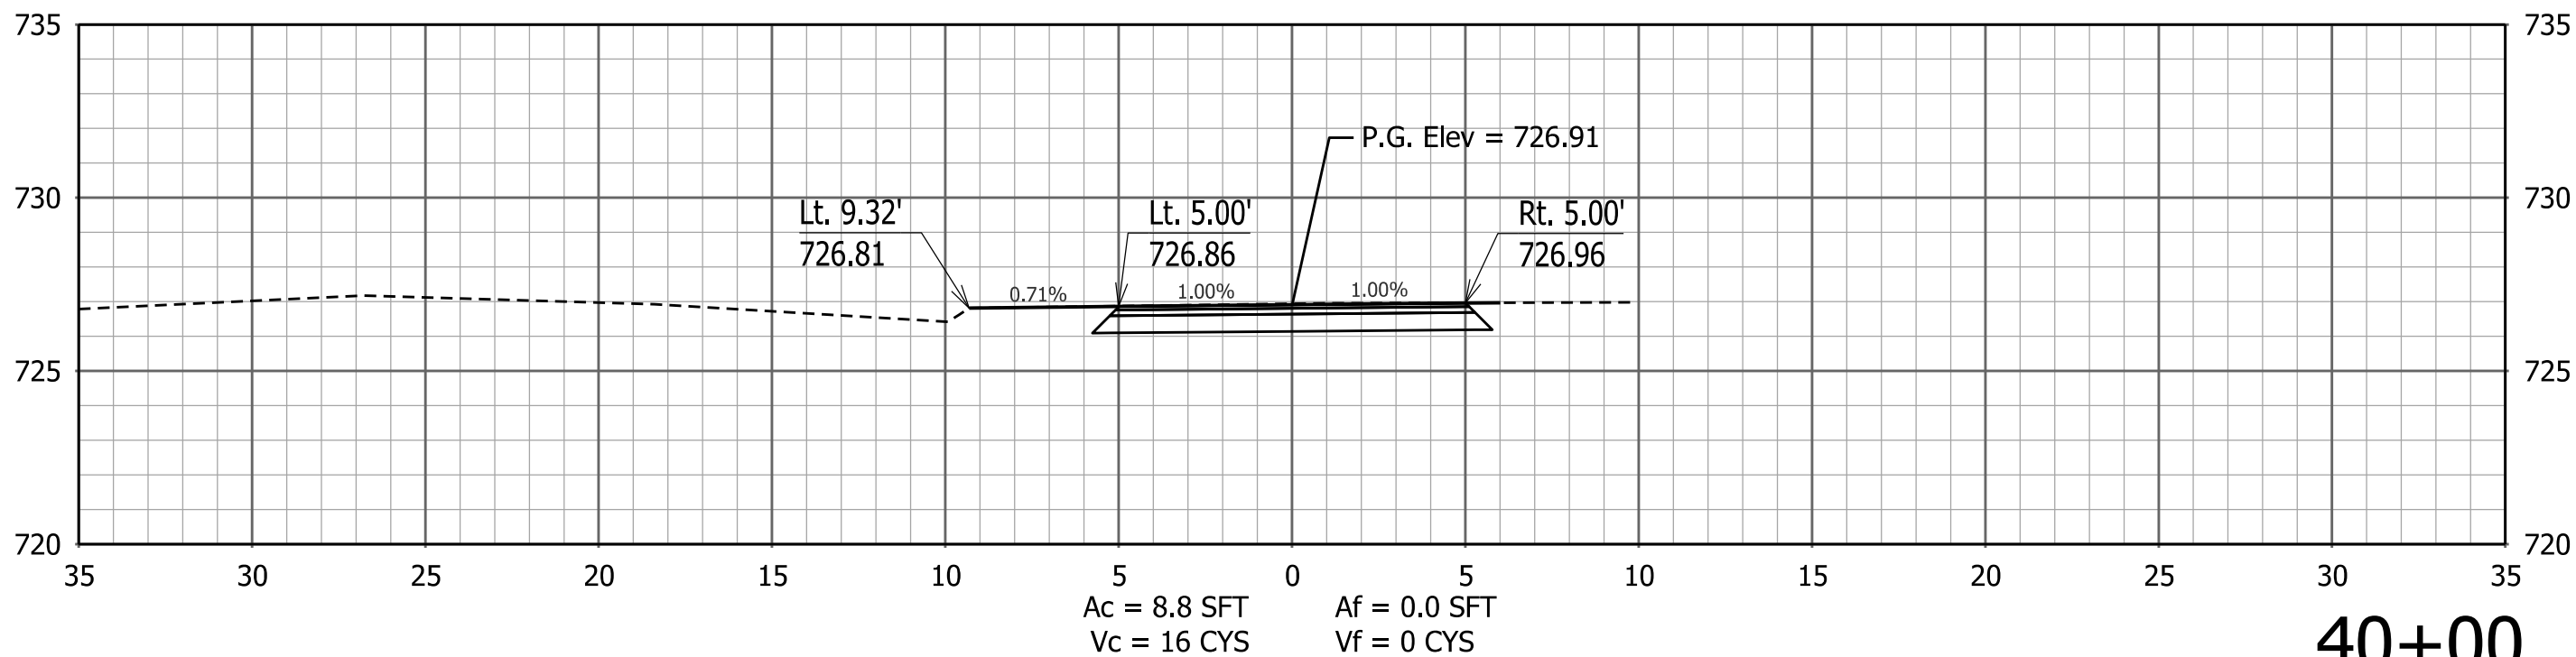

40+00

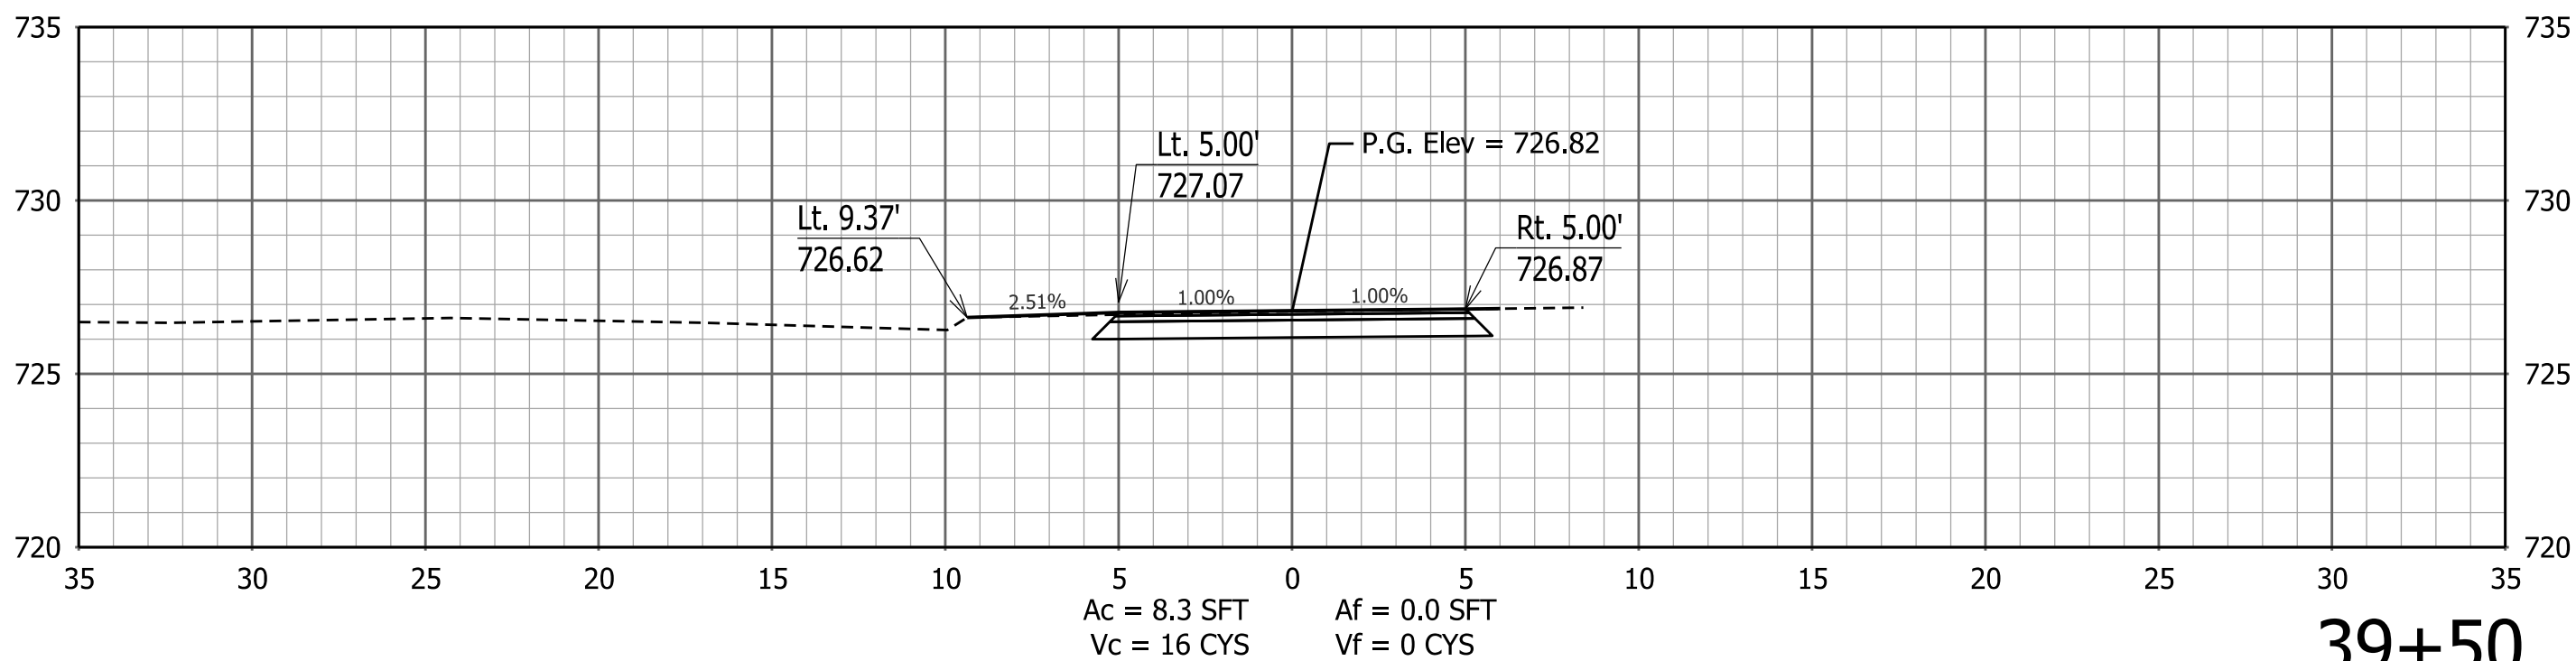

39+50








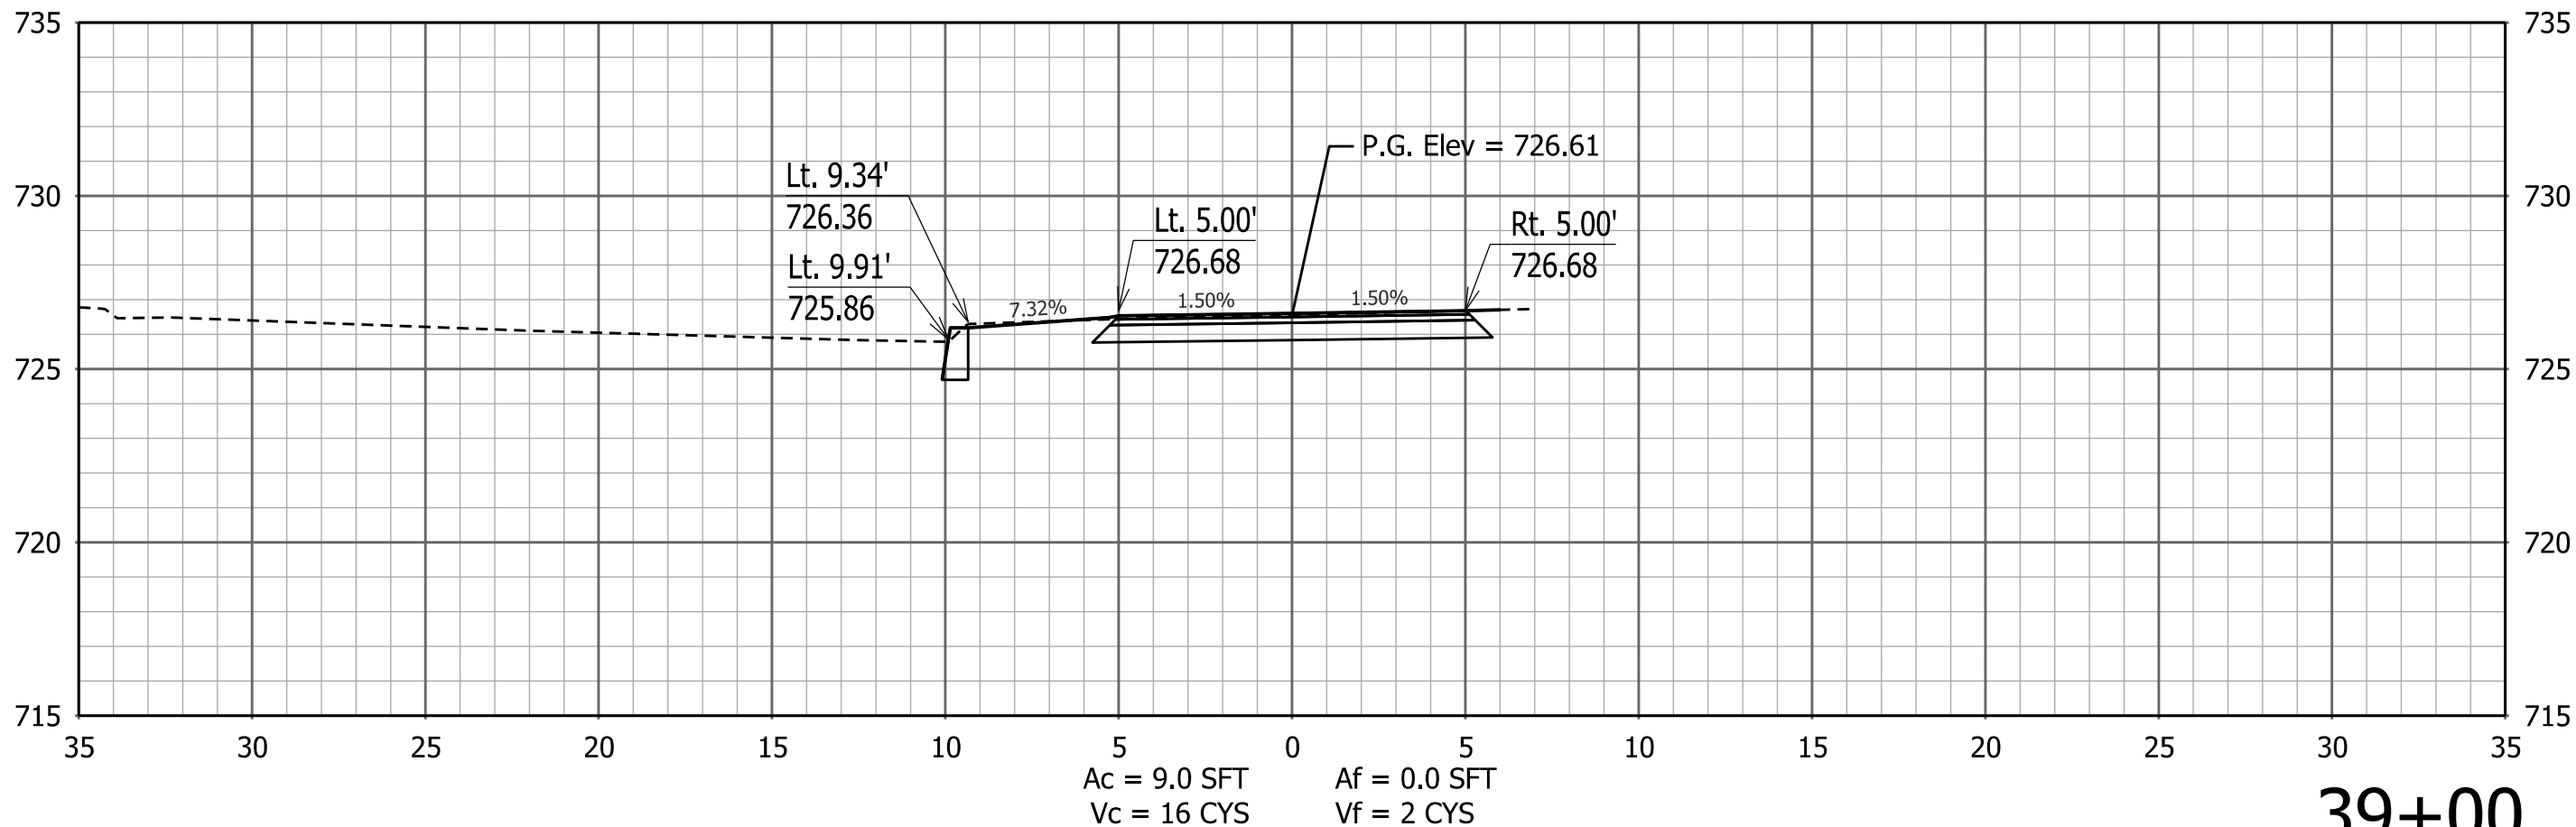


39+00

STA. 37+50 TO STA. 40+50

RECOMMENDED FOR APPROVAL	DESIGN ENGINEER	DATE	CITY OF INDIANAPOLIS DEPARTMENT OF PUBLIC WORKS		SCALE 1" = 5'	BRIDGE FILE
						DESIGNATION
DESIGNED: VA	DRAWN: JSS		CROSS SECTIONS LINE "P"		SURVEY BOOK	SHEETS of XS 47
CHECKED: ACD	CHECKED: VA				CONTRACT	PROJECT PA-25-001

        edgn



STA. 41+00 TO STA. 44+50

RECOMMENDED FOR APPROVAL _____ DESIGN ENGINEER _____ DATE _____	CITY OF INDIANAPOLIS DEPARTMENT OF PUBLIC WORKS			SCALE 1" = 5'	BRIDGE FILE	
					DESIGNATION	
DESIGNED: _____ VA	DRAWN: _____ JSS	CROSS SECTIONS LINE "P"			SURVEY BOOK	SHEETS XS 47 of XS 47
CHECKED: _____ ACD	CHECKED: _____ VA				CONTRACT	PROJECT PA-25-001